

MARTIN LUTHER KING JR. RECREATION CENTER

705 14TH COURT EAST
PANAMA CITY, FL 32401

PROJECT TEAM

ARCHITECT
CCR ARCHITECTURE & INTERIORS
2920 1ST AVENUE SOUTH
BIRMINGHAM, AL 35233
PROJECT CONTACT: ROMAN GARY
TAMMY COHEN
EMAIL: ROMAN@CCRARCHITECTURE.COM
TAMMY@CCRARCHITECTURE.COM
PHONE: (205) 324-8864

CIVIL ENGINEER
PANHANDLE ENGINEERING, INC.
600 OHIO AVENUE
LYNN HAVEN, FL 32444
PROJECT CONTACT: CHRIS FOREHAND
EMAIL: CFB@PANHANDLEENGINEERING.COM
PHONE: (850) 596-1235

LANDSCAPE ARCHITECT
MACKNALLY LAND DESIGN
4000 3RD AVENUE SOUTH
SUITE 101
BIRMINGHAM, ALABAMA 35222
PROJECT CONTACT: LEA ANN MACKNALLY
EMAIL: LMACKNALLY@MACKNALLY.NET
PHONE: (205) 328-4160

STRUCTURAL ENGINEER
MK WEBER ENGINEERING, LLC
3000 W. 23RD STREET
PANAMA CITY, FL 32405
PROJECT CONTACT: MICHAEL WEBER
EMAIL: MIKE@MKWEBER.COM
PHONE: (850) 640-4298

INTERIM CITY MANAGER
BRANDY WALDRON

MECHANICAL & PLUMBING ENGINEER
ENGINEERING DESIGN TECHNOLOGIES, INC.
215 19TH STREET NORTH
SUITE 200
BIRMINGHAM, AL 35203
PROJECT CONTACT: ZACHARY ROBERTSON
EMAIL: ZACHARY.ROBERTSON@EDTINC.NET
PHONE: (205) 942-8630

ELECTRICAL ENGINEER
ENGINEERING DESIGN TECHNOLOGIES, INC.
215 19TH STREET NORTH
SUITE 200
BIRMINGHAM, AL 35203
PROJECT CONTACT: ZACHARY ROBERTSON
EMAIL: ZACHARY.ROBERTSON@EDTINC.NET
PHONE: (205) 942-8630



LIFE SAFETY LEGEND

- EGRESS PATH OF TRAVEL
- EXIT SIGN
- FIRE EXTINGUISHER
- ACCESSORY STORAGE AREAS
- ASSEMBLY - UNCONCENTRATED
- BUSINESS AREAS
- CLASSROOM AREA
- COMMERCIAL KITCHEN
- CONCOURSE
- EXERCISE ROOMS
- READING ROOMS

EGRESS PATH

EGRESS PATH	EGRESS DISTANCE
A	92'
B	38'
C	149'
D	152'
E	111'



VICINITY SITE PLAN
N.T.S.

GENERAL NOTES

- BASE BID SCOPE OF WORK FOR THE PROJECT IS FOR THE BUILDING TO RESIST A 160MPH WIND SPEED. ALTERNATED BID SCOPE OF WORK IS FOR THE BUILDING TO RESIST A 140MPH WIND SPEED.
- GENERAL CONTRACTOR TO FOLLOW ALL APPLICABLE FEDERAL, STATE AND LOCAL BUILDING CODES, ORDINANCES AND REGULATIONS.
- GENERAL CONTRACTOR TO NOTIFY ARCHITECT IF UNKNOWN CONDITIONS ARE DISCOVERED DURING CONSTRUCTION
- BASIS-OF-DESIGN: PRODUCTS SHOWN ON THE DRAWINGS ARE FOR BASIS-OF-DESIGN ONLY. SEE SPECIFICATIONS FOR EQUALS AND SUBSTITUTION PROCEDURES.

APPLICABLE CODES

BUILDING CODE:
(2020) FLORIDA BUILDING CODE

PLUMBING CODE:
(2020) FLORIDA PLUMBING CODE


MECHANICAL CODE:
(2020) FLORIDA MECHANICAL CODE

ELECTRICAL CODE:
(2017) NATIONAL ELECTRICAL CODE

FIRE CODE:
(2020) FLORIDA FIRE PREVENTION CODE

ACCESSIBILITY CODE:
(2020) FLORIDA ACCESSIBILITY CODE

ENERGY CODE:
(2020) FLORIDA ENERGY CONSERVATION CODE

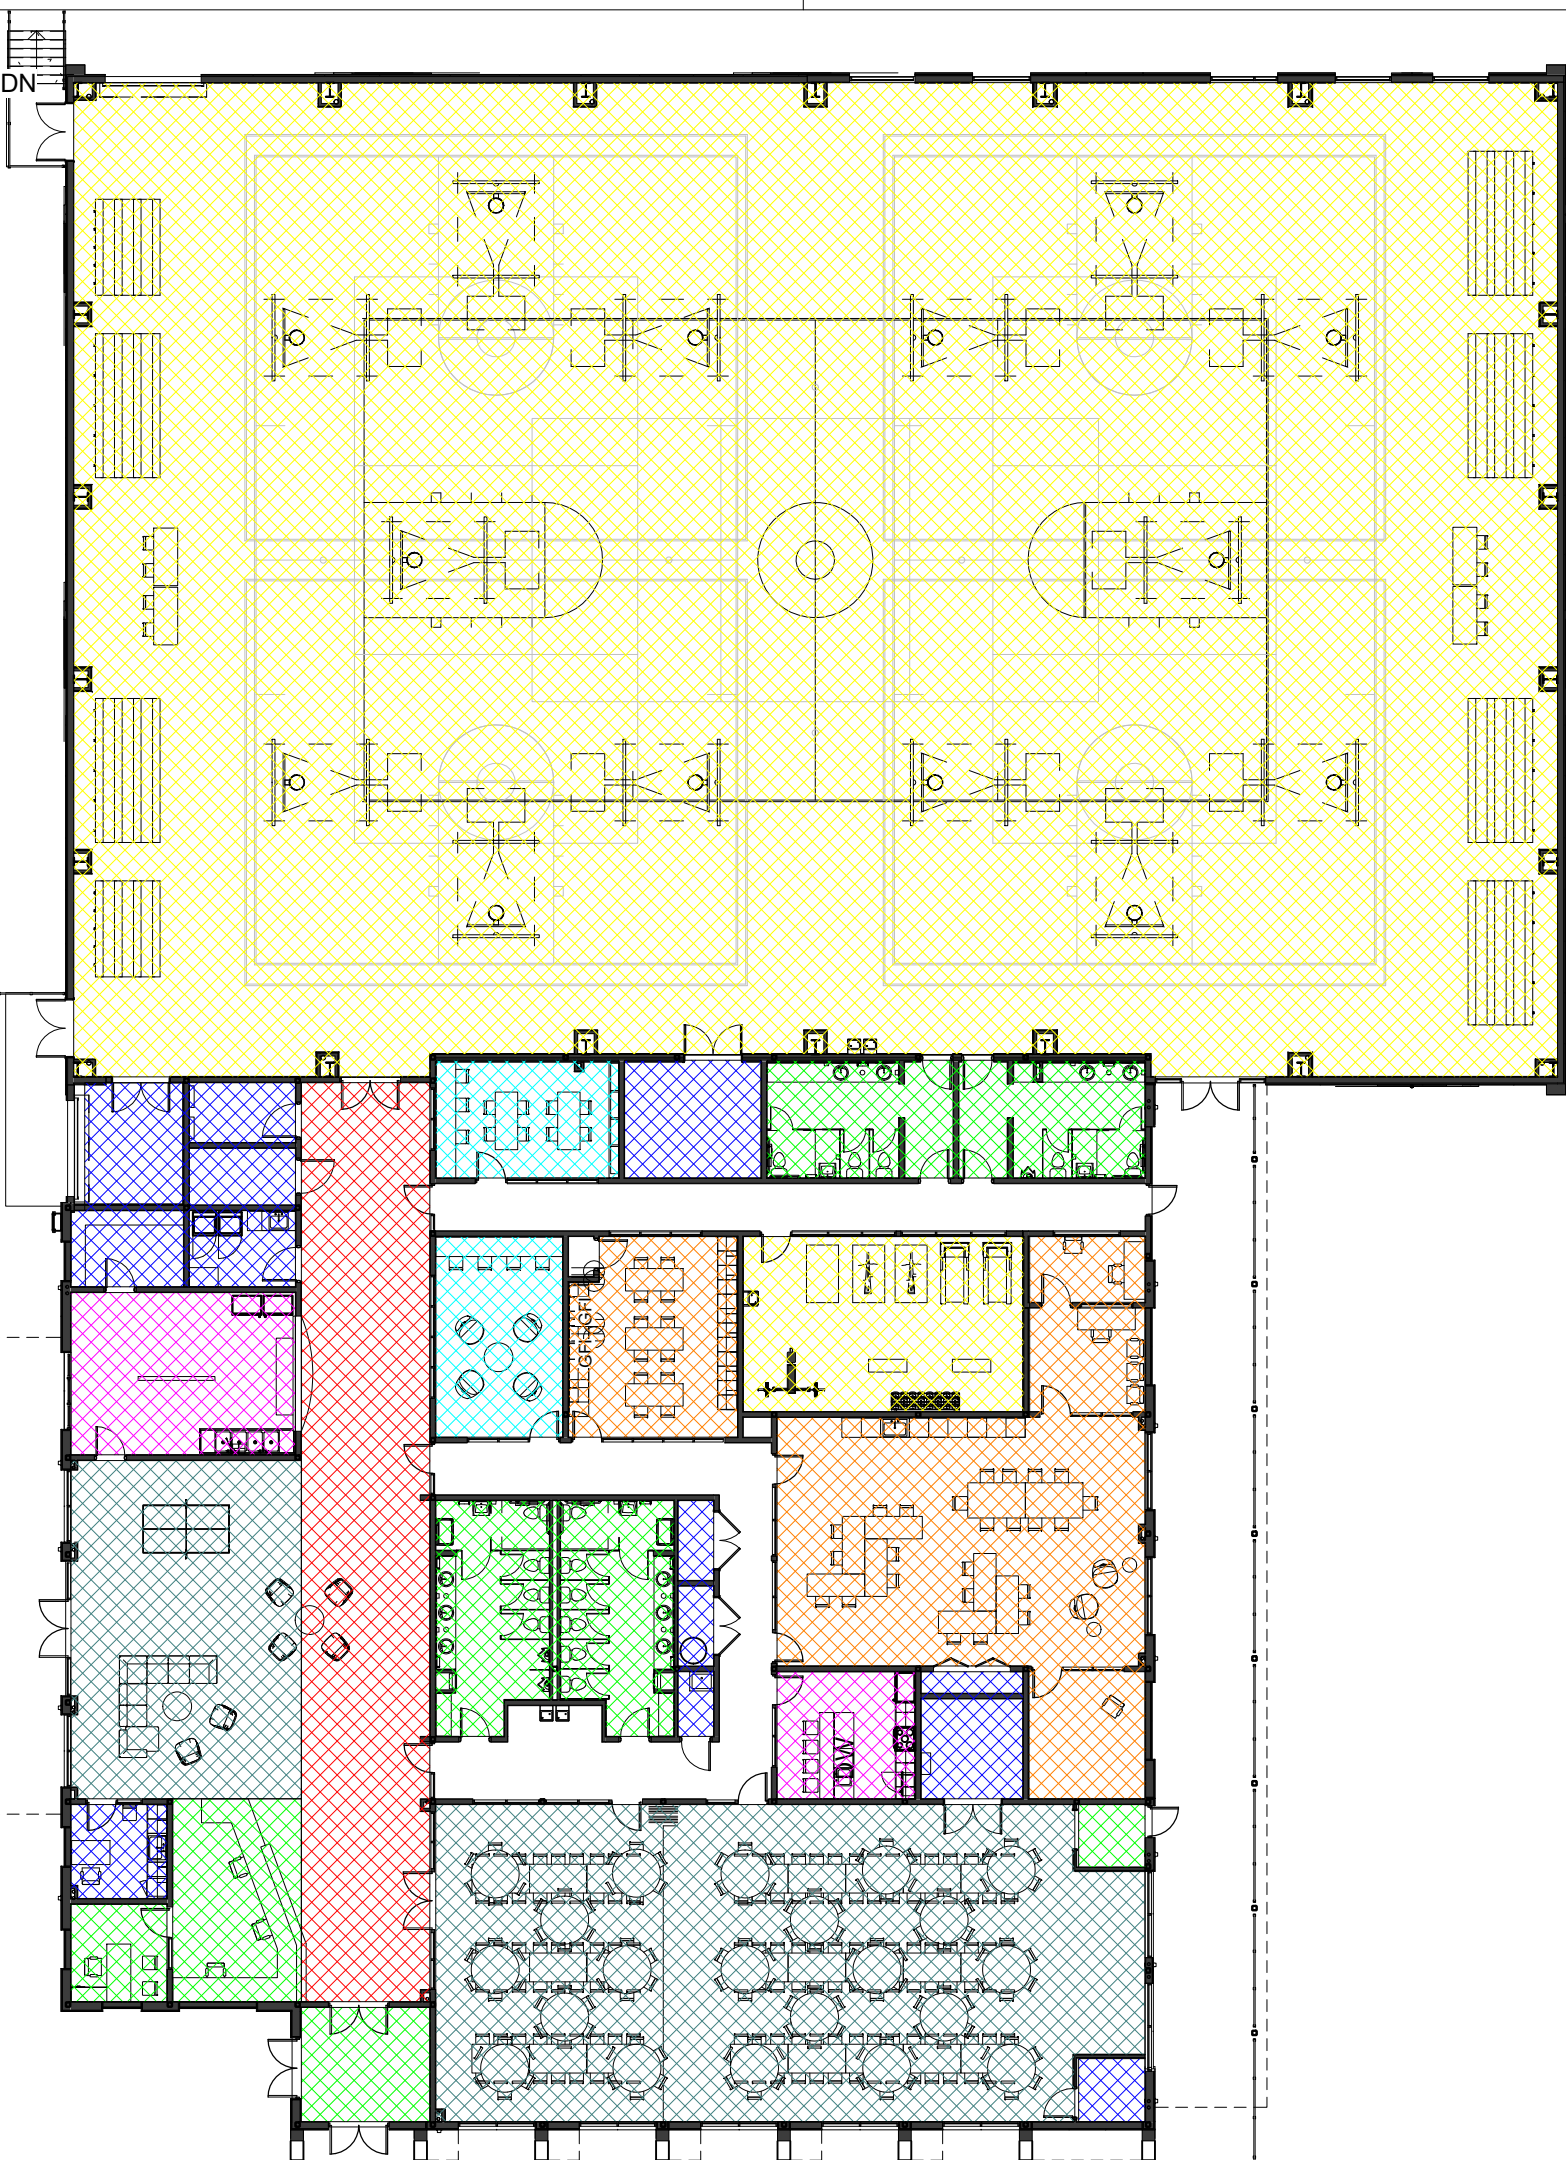


DRAWING INDEX

GENERAL	TITLE SHEET	ARCHITECTURAL
G000	ADA	A000 ARCHITECTURAL SITE PLAN
G001		A001 PERSPECTIVE VIEWS
CIVIL		A002 FLOOR PLAN - LEVEL 1
C-1	EXISTING CONDITIONS WITH AERIAL	A101 FLOOR PLAN - LEVEL 1 Alternate
C-2	EROSION CONTROL PLAN	A102 ENLARGED PLAN - MAIN
C-3	DEMOLITION PLAN	A103 ENLARGED PLAN - GYM
C-4	EHP DESIGNATED AREAS EXHIBIT	A104 ENLARGED PLAN - COURT LAYOUT
C-5	MASTER GIST SITE PLAN WITH AERIAL	A201 REFLECTED CEILING PLAN - LEVEL 1
C-6	SITE & UTILITY PLAN	A301 EXTERIOR ELEVATIONS
C-7	SITE & UTILITY PLAN	A302 FINISH PLAN - LEVEL 1
C-8	SIGNAGE & STRIPING PLAN	A303 FURNITURE PLAN
C-9	GRADING & DRAINAGE PLAN	A401 BUILDING SECTIONS
C-10	GRADING & DRAINAGE PLAN	A402 TYPICAL WALL SECTIONS
C-11	SECTIONS	A403 TYPICAL WALL SECTIONS
C-12	CONSTRUCTION DETAILS	A404 ENLARGED PLANS
C-13	CONSTRUCTION DETAILS	A501 BUILDING DETAILS
C-14	UTILITY DETAILS	A601 INTERIOR ELEVATIONS
C-15	UTILITY DETAILS	A602 INTERIOR ELEVATIONS
C-16	GENERAL NOTES & EROSION CONTROL DETAILS	A603 INTERIOR ELEVATIONS
C-17	DOOR SCHEDULE	A604 INTERIOR ELEVATIONS
C-18	STORMWATER POLLUTION PREVENTION PLAN	A901 DOOR SCHEDULE
LANDSCAPE		A902 STOREFRONT SCHEDULE
L0-0	GENERAL NOTES	A902-ALT STOREFRONT SCHEDULE Alternate
L1-0	SITE IRRIGATION PLAN-NORTH	
L1-1	SITE IRRIGATION PLAN-SOUTH	
L1-2	IRRIGATION DETAILS	
L2-0	HARDSCAPE & MATERIALS OVERALL PLAN	MECHANICAL
L2-1	HARDSCAPE & MATERIALS & LAYOUT	M001 LEGENDS, NOTES, ABBREVIATIONS AND DETAILS - HVAC
L2-2	PLAN-ENLARGEMENTS	M101 FIRST FLOOR PLAN - HVAC
L2-3	HARDSCAPE DETAILS	M201 ROOF - HVAC
L3-0	SITE PLANTING PLAN-NORTH	M301 ENLARGEMENT-HVAC
L3-1	SITE PLANTING PLAN-SOUTH	M401 DETAILS - HVAC
L3-2	LANDSCAPE DETAILS	M402 DETAILS - HVAC
STRUCTURAL		M501 SCHEDULES - HVAC
S1-0	STRUCTURAL NOTES	M502 SCHEDULES - HVAC
S2-0	GYMNASIUM FOUNDATION PLAN	M701 CONTROLS - HVAC
S2-1	MULTI-PURPOSE BUILDING FOUNDATION PLAN	M702 CONTROLS - HVAC
S2-2	MULTI-PURPOSE BUILDING FOUNDATION PLAN	PLUMBING
S2-3	GYMNASIUM FRAMING PLAN	P001 LEGENDS, NOTES, AND ABBREVIATIONS - PLUMBING
S2-4	MULTI-PURPOSE BUILDING LOWER LEVEL FRAMING PLAN	P101 FIRST FLOOR PLAN - PLUMBING
S2-5	MULTI-PURPOSE BUILDING UPPER LEVEL FRAMING PLAN	P102 FIRST FLOOR PLAN - SANITARY
S2-6	LOWER CEILING LIGHT FRAMING PLAN	P201 ROOF - PLUMBING
S2-7	HIGHER CEILING LIGHT FRAMING PLAN	P401 DETAILS - PLUMBING
S2-8	GYMNASIUM NORTH WALL FRAMING ELEVATIONS	P402 DETAILS - PLUMBING
S2-9	LOWER CEILING LIGHT FRAMING PLAN	P501 SCHEDULES - PLUMBING
S2-10	LOWER CEILING LIGHT FRAMING PLAN	P601 ISOMETRIC - SANITARY
S2-11	LOWER CEILING LIGHT FRAMING PLAN	P602 ISOMETRIC - GAS
S2-12	MULTI-PURPOSE BUILDING FOUNDATION PLAN	FIRE PROTECTION
S2-13	COLUMN SCHEDULE AND REFERENCE DETAILS	FP001 FIRE PROTECTION LEGEND, ANNOTATIONS & SYMBOLS
S2-13 ALT	COLUMN SCHEDULE AND REFERENCE DETAILS	FP101 FIRST FLOOR PLAN - FIRE PROTECTION
S3-0	FOUNDATION DETAILS	ELECTRICAL
S3-1	FOUNDATION DETAILS	E-001 LEGEND AND ABBREVIATIONS
S3-2	FOUNDATION DETAILS	ES101 ELECTRICAL SITE PLAN
S3-3	FOUNDATION DETAILS	ES101-ALT ELECTRICAL SITE PLAN Alternate
S3-4	FRAMING DETAILS	EL101 LIGHTING PLAN - ZONE A
S3-5	FRAMING DETAILS	EL102 LIGHTING PLAN - ZONE B
S3-6	FRAMING DETAILS	EP101 POWER PLAN - ZONE A
S3-7	FRAMING DETAILS	EP102 POWER PLAN - ZONE B
S3-8	FRAMING DETAILS	EP103 POWER PLAN-ROOF
S3-9	TYP. WALL FRAMING DETAIL	E-501 DETAILS
S3-10	PARAPET FRAMING DETAILS	E-502 DETAILS
S3-11	DOUBLE TRANSOM DOOR WALL FRAMING	E-503 DETAILS
S3-12	TYP. WALL FRAMING DETAIL	E-504 DETAILS
S3-13	STAIR/RETAINING WALL DETAIL	E-601 SINGLE LINE DIAGRAM AND PANEL SCHEDULES
S3-14	BEAM CONNECTION DETAILS	E-701 LIGHTNING PROTECTION PLAN
S4-0	BEAM CONNECTION PLATE DETAILS	FA101 FIRE ALARM PLAN - ZONE A
S4-1	BASE PLATE DETAILS	FA102 FIRE ALARM PLAN - ZONE B
S4-2	COLUMN #71 DETAILS	FA103 FIRE ALARM PLAN - ROOF
S4-3	BEAM END CONDITION DETAILS	FA601 FIRE ALARM RISER DIAGRAM
S4-4	BEAM END CONDITION DETAILS	LV101 LOW VOLTAGE - ZONE A
S4-5	"T" BRACKET DETAILS	LV102 LOW VOLTAGE - ZONE B
		T-101 TELECOMMUNICATION PLAN - ZONE A
		T-102 TELECOMMUNICATION PLAN - ZONE B
		FOOD SERVICE
		FS-1 EQUIPMENT PLAN
		FS-2 PLUMBING ROUGH-IN PLAN
		FS-3 ELECTRICAL ROUGH-IN PLAN
		FS-4 EQUIPMENT & SPECIAL CONDITIONS PLAN

CODE ANALYSIS

2020 FLORIDA BUILDING CODE (FBC)	
2020 FLORIDA FIRE PREVENTION CODE (FFPC)	
PROJECT DESCRIPTION NEW CONSTRUCTION OF A COMMUNITY CENTER / GYMNASIUM BUILDING.	
OCCUPANCY CLASSIFICATION:	A-3 ASSEMBLY
CONSTRUCTION TYPE:	TYPE IIB, SPRINKLERED
BUILDING AREA:	30,000 SF
TABLE 504.3	GROUP A, TYPE IIB: 75'-0" MAXIMUM BUILDING HEIGHT
TABLE 504.4	SPRINKLERED, TYPE IIB: 3 STORIES
TABLE 506.2	GROUP A-3, SPRINKLERED TYPE IIB: 38,000 SF MAXIMUM AREA PER FLOOR
TABLE 601	NO RATINGS ARE REQUIRED FOR TYPE IIB CONSTRUCTION
TABLE 803.11	MINIMUM INTERIOR FINISHES ARE TO BE CLASS 'B' FOR CORRIDORS & CLASS 'C' FOR ROOMS & ENCLOSED SPACES
1003.2	7'-6" MINIMUM CEILING HEIGHT
OCCUPANT LOAD	
TABLE 1004.5	
ACCESSORY STORAGE AREAS	884 SF / 15 NET = 3.0 PEOPLE
ASSEMBLY - UNCONCENTRATED	3,184 SF / 15 NET = 212.3 PEOPLE
BUSINESS AREAS	1,642 SF / 150 GROSS = 11.0 PEOPLE
CLASSROOM AREAS	1,739 SF / 20 NET = 87.0 PEOPLE
COMMERCIAL KITCHEN	586 SF / 200 GROSS = 2.9 PEOPLE
CONCOURSE	1,283 SF / 100 GROSS = 12.8 PEOPLE
EXERCISE ROOMS	16,365 SF / 50 GROSS = 327.3 PEOPLE
READING ROOMS	511 SF / 50 NET = 10.2 PEOPLE
TOTAL	667 OCCUPANTS
1005.3.2	MINIMUM EGRESS WIDTH REQUIREMENTS: OTHER COMPONENTS: 667 * 0.2 = 133.4" REQUIRED 408" PROVIDED
1010.1.1	MINIMUM WIDTH AT DOORS: 32" MAXIMUM: 48" LEAF
TABLE 1017.2	EXIT AVES TRAVEL DISTANCE WITH SPRINKLER SYSTEM: 250 FEET
1020.4	MAXIMUM DEAD END CORRIDOR LENGTH: 20 FEET
CHAPTER 29	MINIMUM PLUMBING FACILITIES: 667 TOTAL OCCUPANTS
	MALE 334/125 = 3 WATER CLOSETS 334/200 = 2 LAVATORIES
	FEMALE 334/165 = 6 WATER CLOSETS 334/200 = 2 LAVATORIES
	667/500 = 2 DRINKING FOUNTAIN
	1 SERVICE SINK

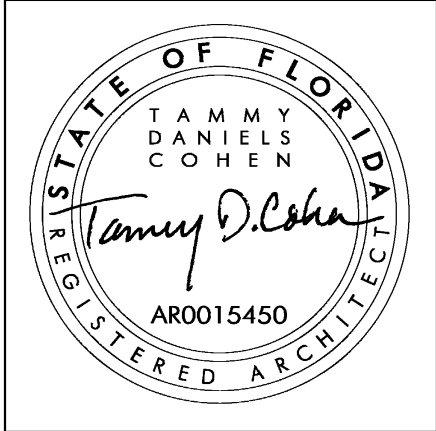

P F CHURCH K WEBER WALDRON HQ WALDRON UV

MARTIN LUTHER KING JR. RECREATION CENTER
705 14TH COURT EAST
PANAMA CITY, FL 32401

JOB NUMBER:
21109

DATE:
05/18/2023

PRINTED / REVISIONS
& DESCRIPTION GDRM

SHEET TITLE:
TITLE SHEET

SHEET NUMBER:
G000

GENERAL NOTES

1. GENERAL CONTRACTOR TO VERIFY SHOWN DIMENSIONS WITH CURRENT REGULATIONS, LOCAL CODES, AND ORDINANCES.
2. ALL MINIMUM FACE OF FINISH AND/OR MINIMUM DIMENSIONS MUST TAKE INTO ACCOUNT THE THICKNESS OF THE WALL FINISHES SUCH AS CERAMIC TILE, SOLID SURFACE MATERIAL, BACKER BOARD OR ANY OTHER FINISH MATERIAL BEING USED.
3. LOCATION OF TOILET ACCESSORIES ARE SHOWN FOR REFERENCE FOR ACCESSIBILITY REQUIREMENTS ONLY. SEE DRAWINGS FOR SPECIFIC LOCATIONS AND ADDITIONAL INFORMATION.

Technical drawing of a toilet compartment showing dimensions and clearances:

- Overall width: 5'-1" CLEAR
- Overall height: 6'-0" MIN.
- Top horizontal clearance: 16"-18"
- Top horizontal offset: 4"
- Grab bar height: 36" MIN. GRAB BAR
- Right side vertical clearance: 5'-0" MIN.
- Bottom horizontal clearance: 2'-8" CLEAR MIN
- Bottom horizontal offset: 4" MAX
- Bottom horizontal clearance (alternative): OR 4' - 8" MIN
- Coat hook location: COAT HOOK @ 4' - 0"
- Labels: TOILET COMPARTMENT PANEL, R, R

5'-1" CLEAR

16"-18"

4"

60" MIN.

36" MIN. GRAB BAR

50" MIN.

TOILET COMPARTMENT PANEL

2'-8" CLEAR MIN.

OR 4' - 8" MIN.

COAT HOOK @ 4'-0"

4" MAX.

Diagram illustrating the required clearances for various fixtures:

- ELECTRIC HAND:** 35" - 45" SEE TABLE
- SOAP:** 3'-8"
- PAPER TOWEL:** 3'-4"
- TOILET TISSUE:** 17'-9"
- 18"x48":** 1'-6"

42" MIN.
60" MAX.

Diagram illustrating the required clear floor space for a wheelchair. The space is 2'-6" MIN wide and 4'-0" MIN deep.

HINGE SIDE APPROACH MANEUVERING CLEARANCES AT DOORS

The diagram illustrates the required clearances for a wheelchair to approach a table from both the push side and the pull side. On the left, the 'PUSH SIDE' shows a wheelchair approaching from the left. The required clearance is 54" Min. for the main body and 42" Min. for the front. A 22" MIN. clearance is also indicated for the front of the wheelchair. On the right, the 'PULL SIDE' shows a wheelchair approaching from the right, with a curved arrow indicating the path. A dashed line indicates the required clearance area.

NOTE: Y=48" MINIMUM IF DOOR HAS
A LATCH AND A CLOSER

LATCH SIDE APPROACH MANEUVERING CLEARANCES AT DOORS

PULL SIDE

PUSH SIDE

The diagram illustrates the required clearances for a person to approach a door from the latch side. On the left, the 'PULL SIDE' shows a person pulling a door open. The vertical clearance is labeled 'Y 48" Min.' and the horizontal clearance is labeled 'X 24" Min.'. On the right, the 'PUSH SIDE' shows a person pushing a door open. The horizontal clearance is labeled 'X 24" Min.'. Both sides use dashed lines to indicate the required clearance boundaries.

NOTE: Y=54" MINIMUM IF D

NOTE: Y=48" MINIMUM IF DOOR
HAS A CLOSER

FRONT APPROACH MANEUVERING CLEARANCES AT DOORS

MANEUVERING CLEARANCE NOTES

THE FLOOR AREA WITHIN THE REQUIRED MANEUVERING CLEARANCES AT DOORS SHALL BE LEVEL AND CLEAR

WHERE ANY OBSTRUCTION WITHIN 18" OF THE LATCH SIDE OF THE DOOR WAY PROJECTS MORE THAN 8" BEYOND THE FACE OF THE DOOR, MANEUVERING CLEARANCE FOR A FORWARD APPROACH SHALL BE PROVIDED

DASHED LINES INDICATE MANEUVERING CLEARANCES

DOOR OPENINGS SHALL PROVIDE A CLEAR WIDTH OF 32"

MINIMUM CLEAR FLOOR SPACE FOR MANEUVERING CLEARANCE AT DOORS REQUIRED TO BE MAINTAINED

WHEN TWO DOORS ARE IN A SERIES A 5'-0" DIAMETER CLEAR FLOOR SPACE IS REQUIRED.

NOTES - ACCESSIBLE TOILET ROOM

PROVIDE 5'-0" DIAMETER WHEEL CHAIR TURNING SPACE

PROVIDE 30"x48" CLEAR FLOOR SPACE AT LAVATORY

CLEAR FLOOR SPACE REQUIRED FOR MANEUVERING CLEARANCE AT EACH SIDE OF DOOR

IF A 30"x48" CLEAR FLOOR SPACE IS PROVIDED BEYOND THE ARC OF THE DOOR, DOORS SHALL BE PERMITTED TO SWING INTO THE CLEARANCE REQUIRED FOR ANY FIXTURE AND THE CLEAR SPACE FOR TURNING RADIUS.

[illegible]

Technical drawing of a toilet stall showing dimensions and components. The drawing includes the following labels and dimensions:

- Dimensions:**
 - 39" MIN (width of the stall)
 - 41" MAX (width of the stall)
 - 15" (height of the stall)
 - 60" (height of the stall)
 - 39" MIN (width of the stall)
 - 41" MAX (width of the stall)
 - 15" (height of the stall)
 - 17" MIN, 19" MAX (height of the stall)
- Components:**
 - TOILET
 - TOILET PAPER DISPENSER
 - 1/2" DIA (diameter of the toilet paper dispenser)
 - SANITARY NAPKIN DISPOSAL
 - TO SEAT
- Other Labels:**
 - FIN FL (Finish Floor)

Technical drawing of a vanity unit showing side and front elevations with dimensions and labels:

- Side Elevation (Left):**
 - Overall height: 35" MIN
 - Overall width: 36" MAX
 - FIN FL (Finish Floor) line is indicated.
- Front Elevation (Right):**
 - Overall height: 3' 3 1/2" MAX
 - REFLECTIVE SURFACE (Mirror) is indicated.
 - Overall width: 36" MAX
- Labels and Details:**
 - CENTER MIRROR ON LAVATORY
 - 18"x36" (Mirror dimensions)
 - SOAP DISPENSER
 - 6" (Distance from mirror to soap dispenser)
 - 3" (Distance from soap dispenser to centerline)
 - 34" MAX (Distance from floor to mirror centerline)
 - LAV (Lavatory/Sink)

Diagram illustrating the required clearances and dimensions for a wall-hung lavatory:

- PAPER TOWEL DISPENSER**: Indicated by an arrow pointing to the dispenser mounted on the wall.
- WALL HUNG LAV**: Indicated by an arrow pointing to the lavatory fixture.
- SPAC**: Vertical clearance dimension, labeled as **2'-11"** and **2'-3" MIN**.
- LINES OF KNEE AND TOE CLEARANCE**: Indicated by arrows pointing to the knee and toe clearances.
- 5'-0"**: Horizontal clearance dimension.


SIDE ELEVATION

	
 CCR ARCHITECTURE & INTERIORS	
MARTIN LUTHER KING JR. RECREATION CENTER 705 14TH COURT EAST PANAMA CITY, FL 32401	
JOB NUMBER: 21109	
DATE: 05/18/2023	
PRINTED / REVISIONS	
# DESCRIPTION	DATE
SHEET TITLE: ADA	
SHEET NUMBER: G001	


05/18/2023 10:18 AM
705 14TH COURT EAST
PANAMA CITY, FL 32401
THIS DRAWING IS THE PROPERTY OF CCR ARCHITECTURE & INTERIORS AND IS NOT TO BE REPRODUCED, COPIED OR ALTERED IN WHOLE OR IN PART OR USED FOR ANY PURPOSE WITHOUT THE APPROVAL OF CCR ARCHITECTURE & INTERIORS AND IS TO BE RETURNED UPON REQUEST.




① OVERALL SITE MAP
1" = 50'-0"

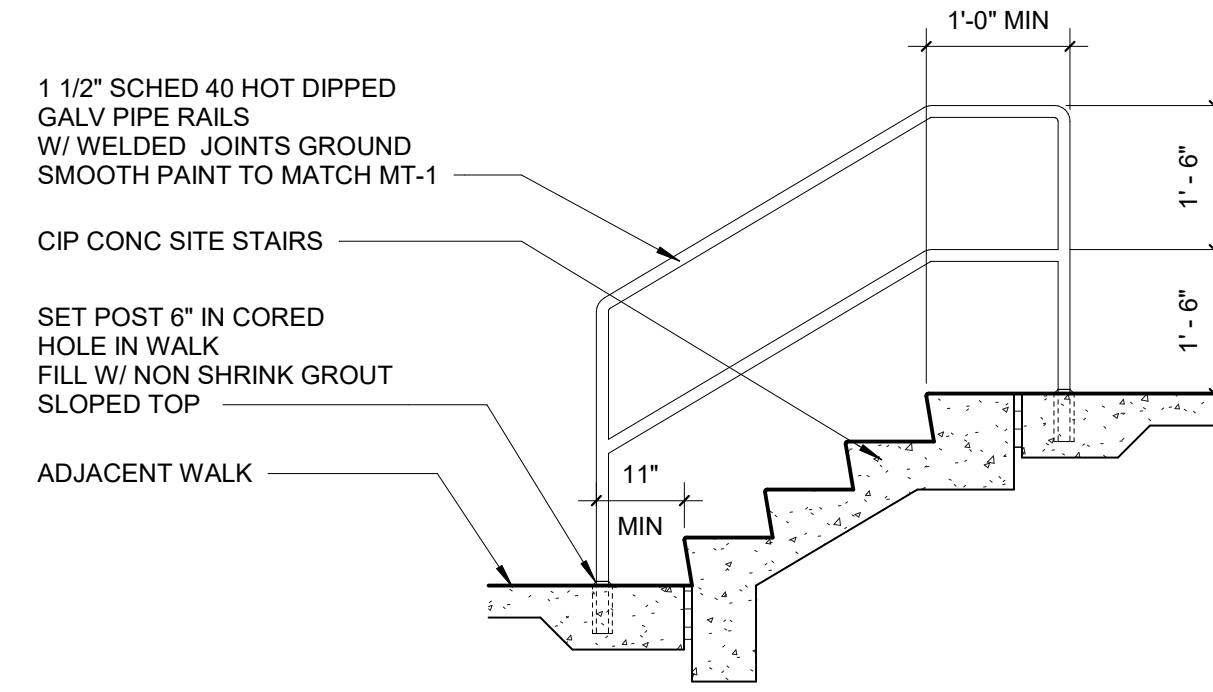


④ SITE SECTION - TYPICAL CONCRETE STAIR
1/2" = 1'-0"

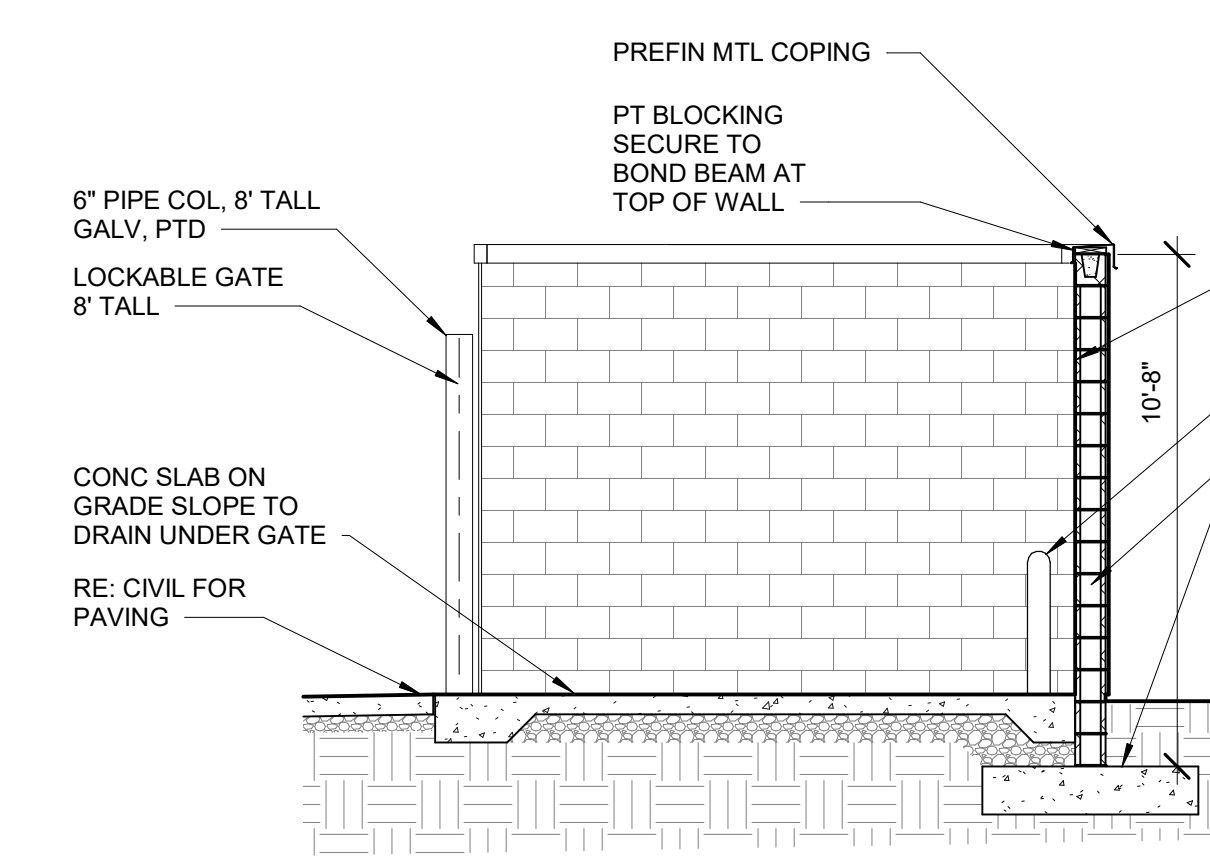

③ SITE SECTION - REFUSE ENCLOSURE
1/4" = 1'-0"

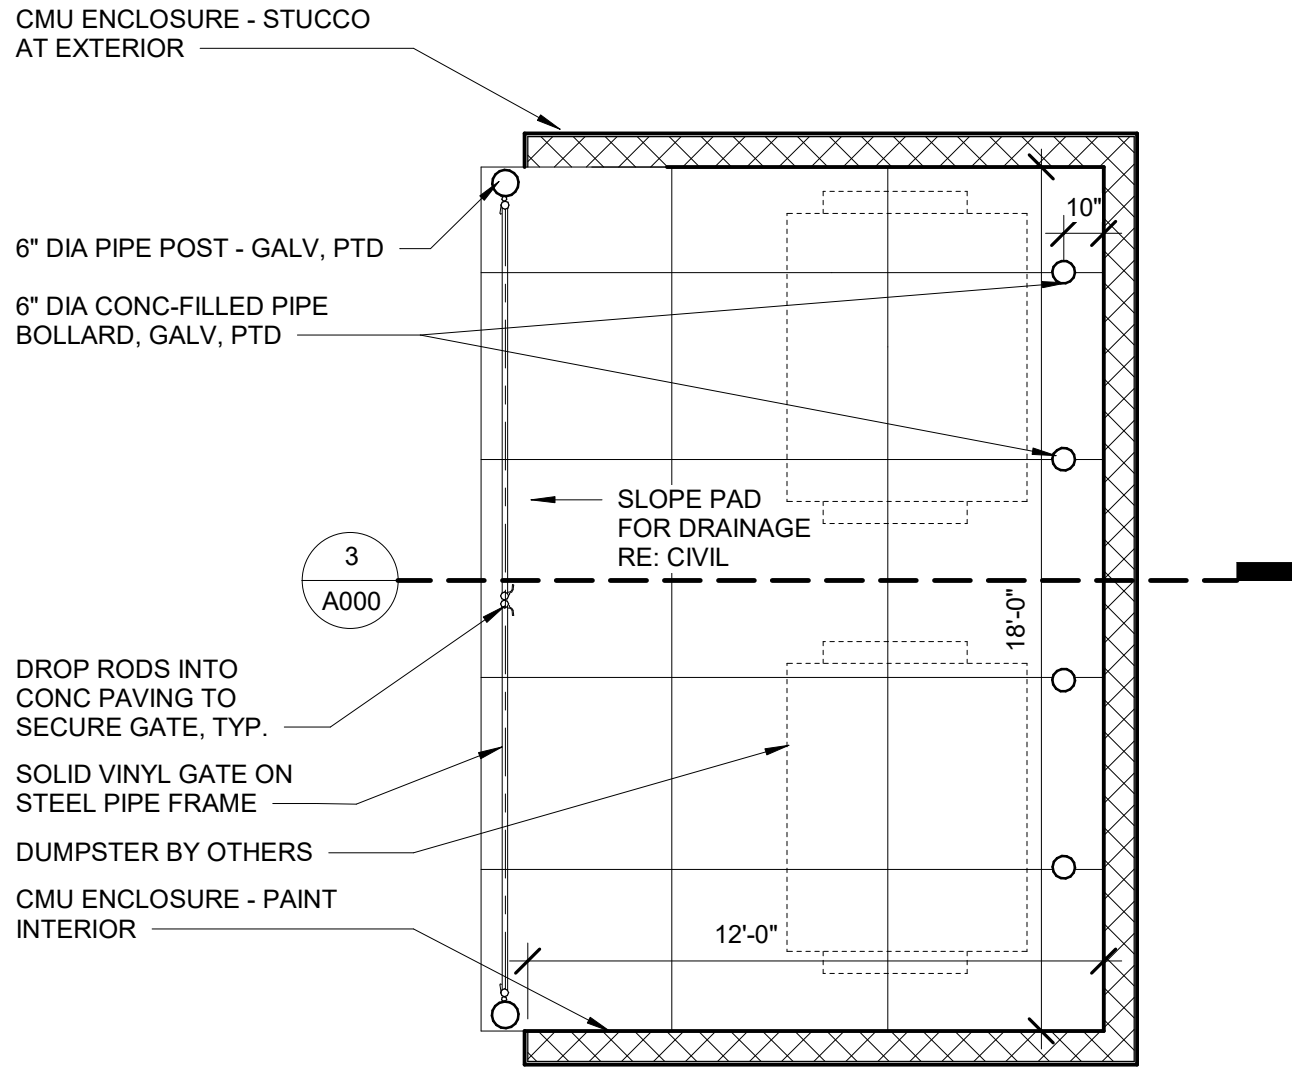

② SITE DETAIL - REFUSE ENCLOSURE
1/4" = 1'-0"

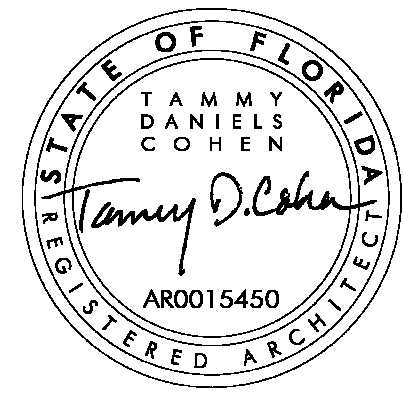

CCR ARCHITECTURE & INTERIORS

MARTIN LUTHER KING JR. RECREATION CENTER

705 14TH COURT EAST
PANAMA CITY, FL 32401

JOB NUMBER:
21109

DATE:
05/18/2023

PRINTED / REVISIONS

#	DESCRIPTION	DATE
---	-------------	------

SHEET TITLE:
ARCHITECTURAL SITE PLAN

SHEET NUMBER:

A000


05/18/2023 10:28 AM
705 14TH COURT EAST
PANAMA CITY, FL 32401
THIS DRAWING IS THE PROPERTY OF CCR ARCHITECTURE & INTERIORS AND IS NOT TO BE REPRODUCED, COPIED OR ALTERED IN WHOLE OR IN PART OR USED FOR ANY PURPOSE WITHOUT THE APPROVAL OF CCR ARCHITECTURE & INTERIORS AND IS TO BE RETURNED UPON REQUEST.
Scheme 2 of 4



② SOUTHWEST



① SOUTHEAST

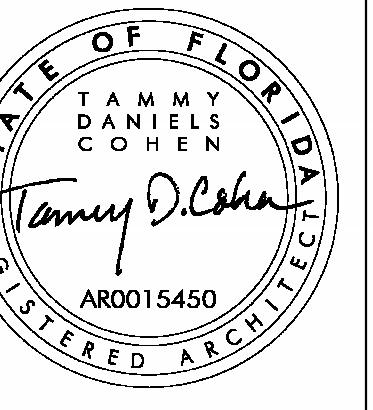

CCR ARCHITECTURE & INTERIORS

MARTIN LUTHER KING JR. RECREATION CENTER

705 14TH COURT EAST
PANAMA CITY, FL 32401

JOB NUMBER:
21109

DATE:
05/18/2023


PRINTED / REVISIONS
DESCRIPTION DATE

SHEET TITLE:
PERSPECTIVE VIEWS


SHEET NUMBER:

A001


05/18/2023 10:52 AM
705 14TH COURT EAST
PANAMA CITY, FL 32401
THIS DRAWING IS THE PROPERTY OF CCR ARCHITECTURE & INTERIORS AND IS NOT TO BE REPRODUCED, COPIED OR ALTERED IN WHOLE OR IN PART OR USED FOR ANY PURPOSE WITHOUT THE APPROVAL OF CCR ARCHITECTURE & INTERIORS AND IS TO BE RETURNED UPON REQUEST.

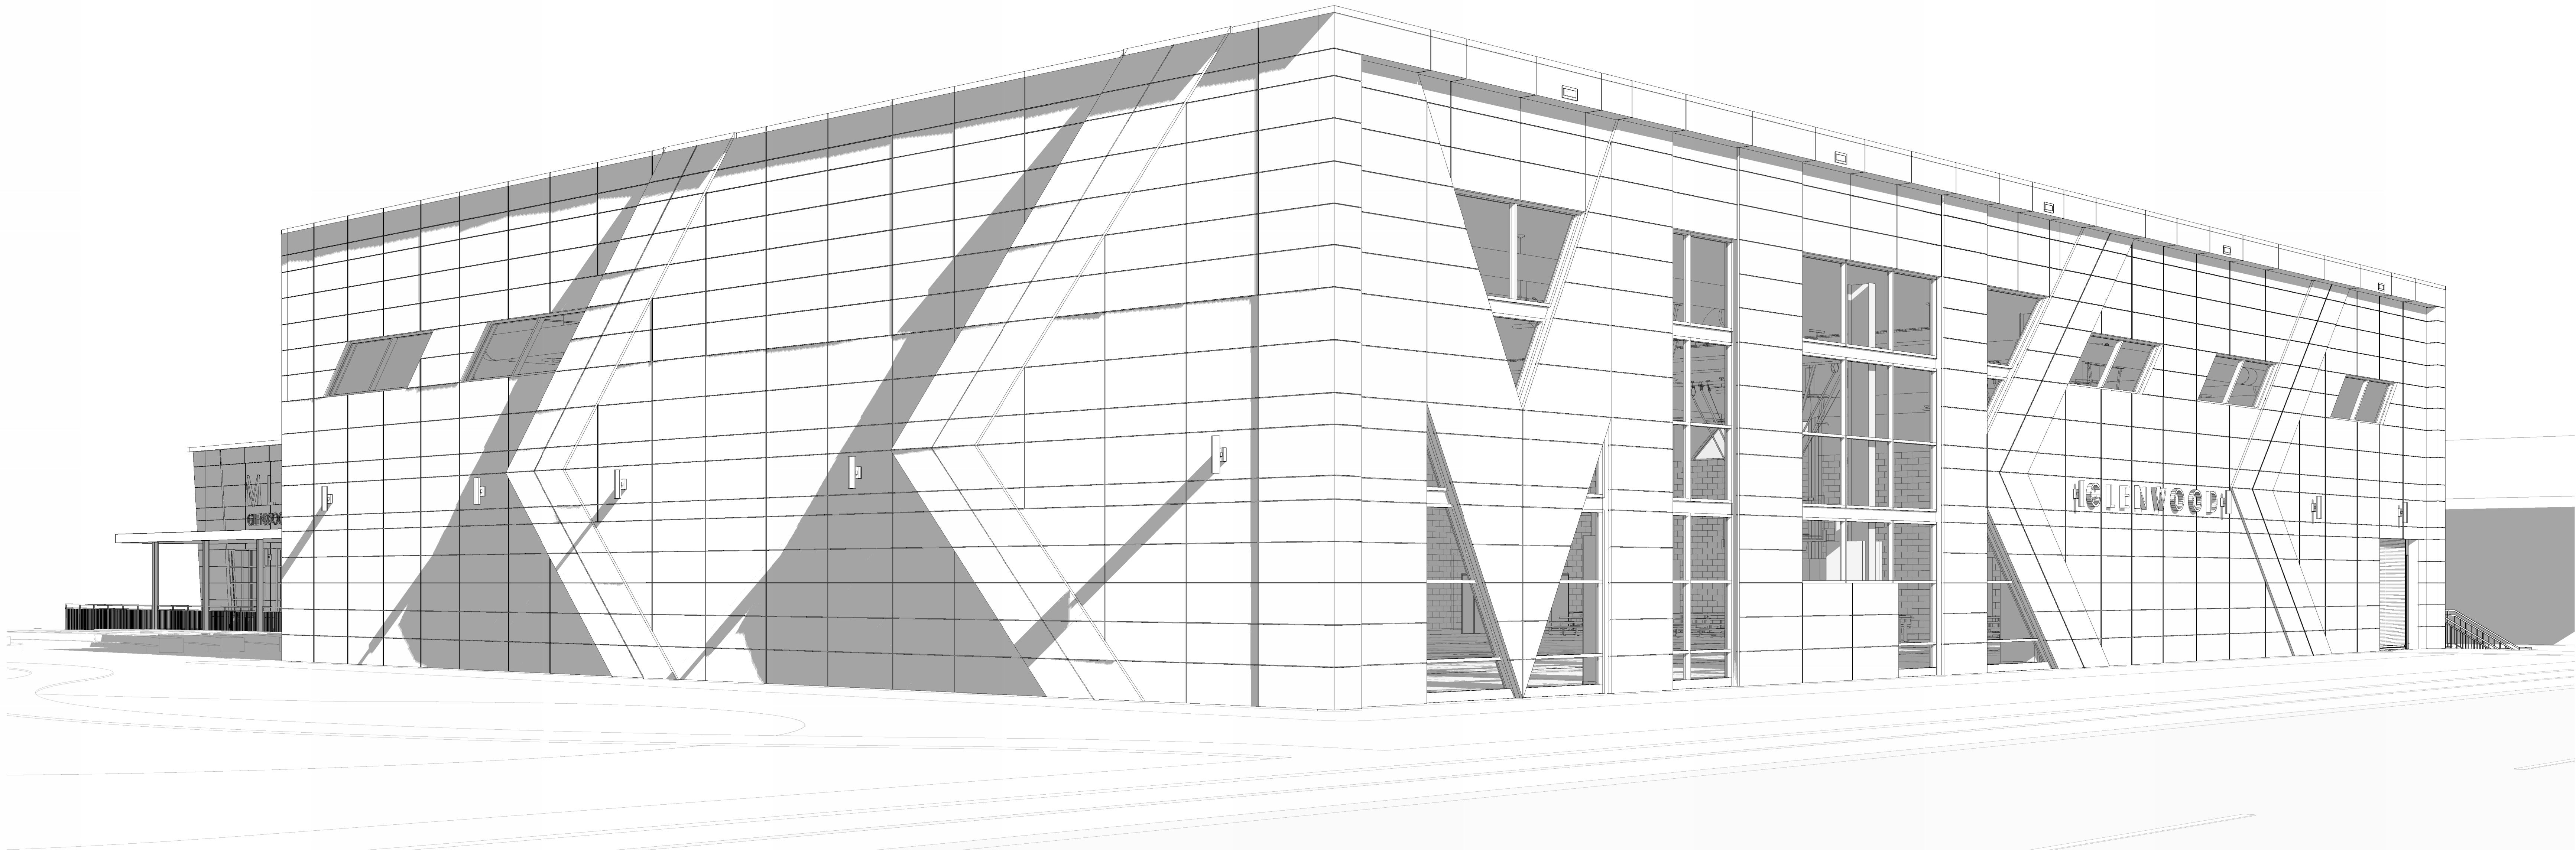

① NORTHEAST

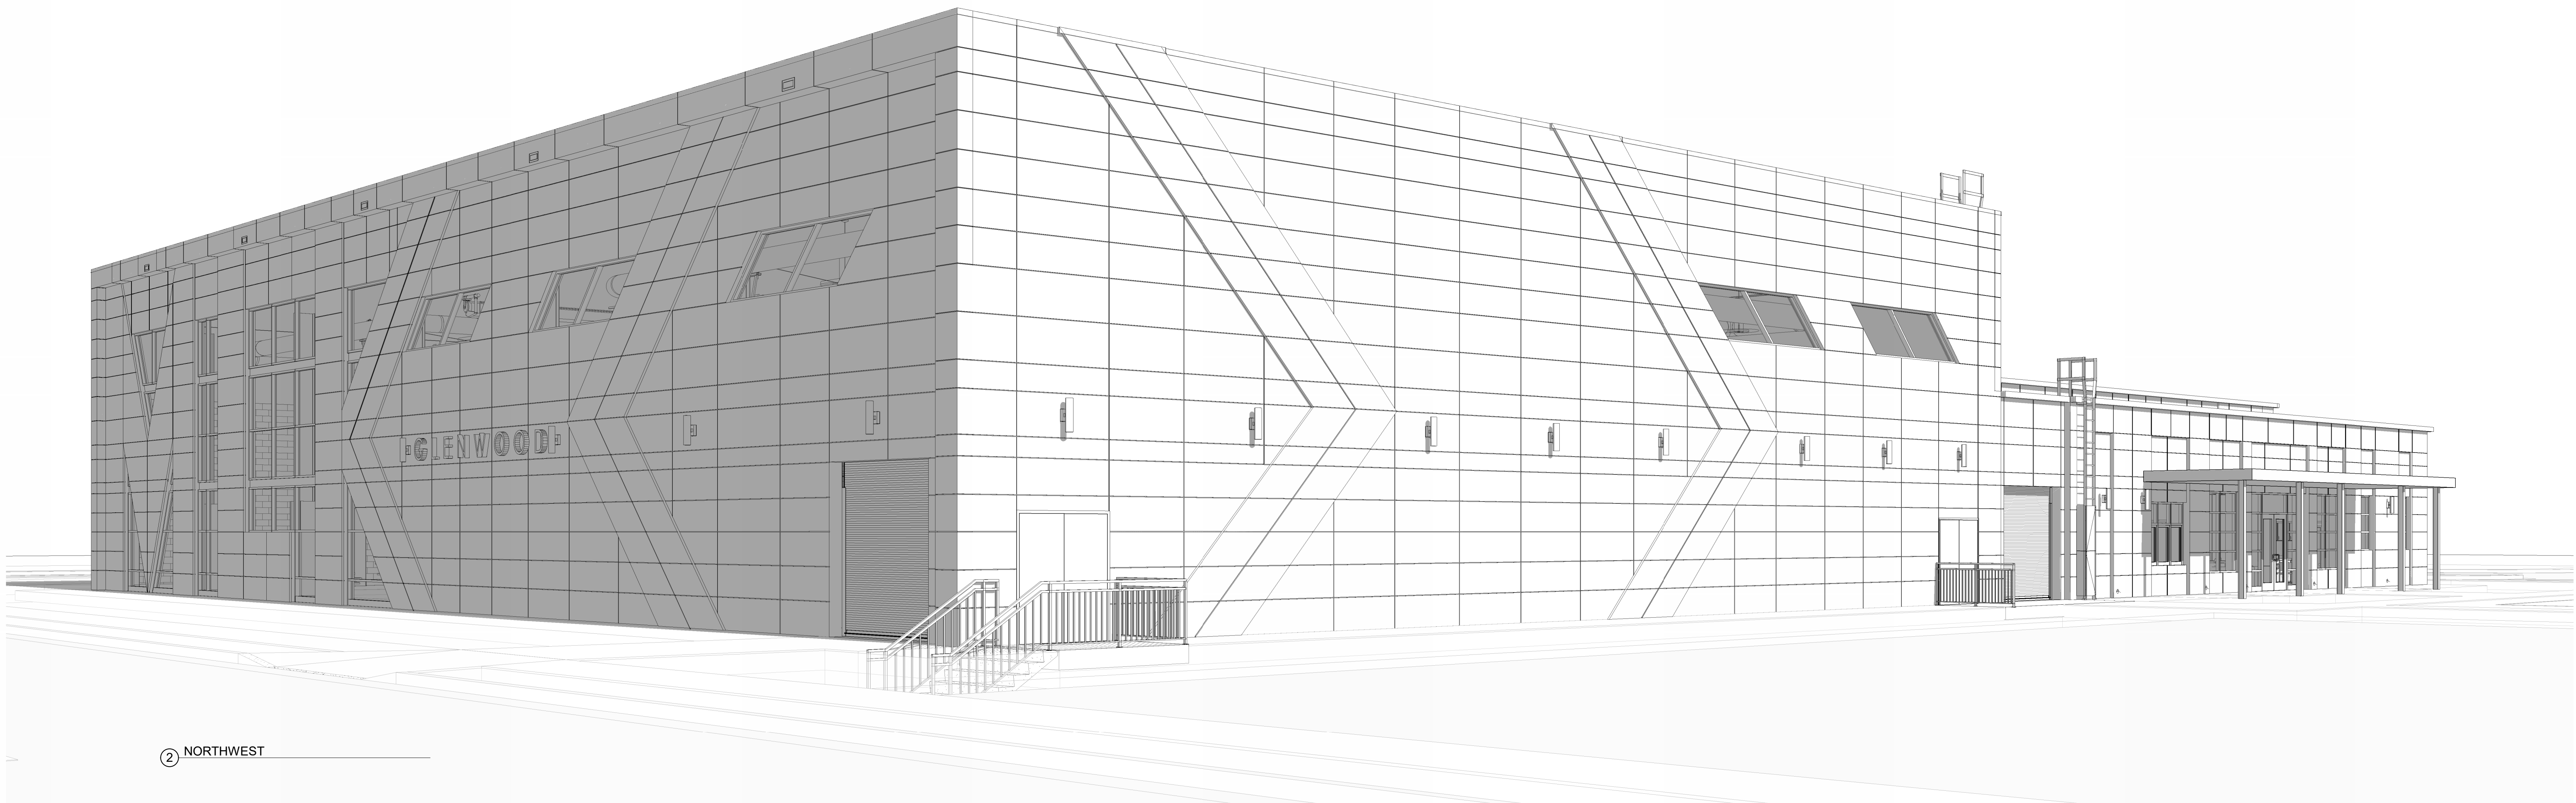

② NORTHWEST

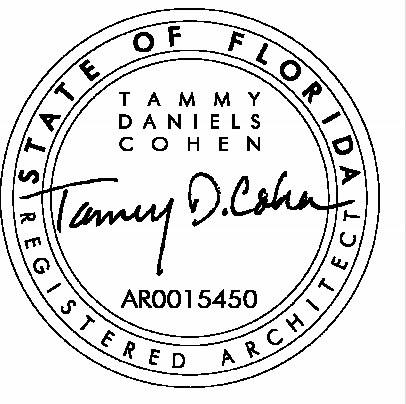

CCR ARCHITECTURE & INTERIORS

MARTIN LUTHER KING JR. RECREATION CENTER

705 14TH COURT EAST
PANAMA CITY, FL 32401

JOB NUMBER:
21109

DATE:
05/18/2023


PRINTED / REVISIONS
DESCRIPTION DATE

SHEET TITLE:
PERSPECTIVE VIEWS


SHEET NUMBER:

A002


EXTERIOR WALL TYPES

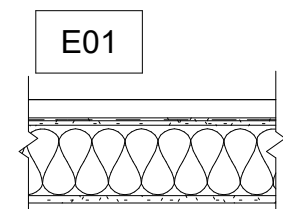

PREFINISHED FORMED METAL PANEL ON PANEL MFR CLIPS OVER FLUID APPLIED AIR BARRIER ON 3/4" PLYWOOD SHEATHING ON 10", 8" OR 6" EXTERIOR METAL STUDS AT 16" O.C. AND MIN. R-19 BATTS IN STUD CAVITY.

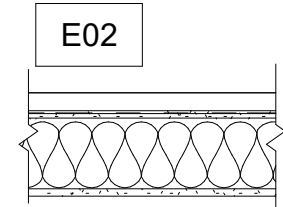


PREFINISHED FORMED METAL PANEL ON 7/8" GALV HAT CHANNEL FURRING AT 24" O.C. OVER FLUID APPLIED AIR BARRIER ON 3/4" PLYWOOD SHEATHING ON 8" EXTERIOR METAL STUDS AT 16" O.C. AND MIN. R-19 BATTS IN STUD CAVITY.

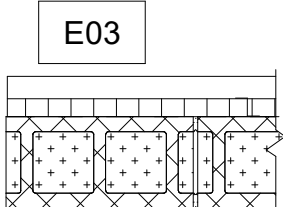


PREFINISHED FORMED METAL PANELS ON 7/8" GALV HAT CHANNEL FURRING AT 24" O.C. ON R-7.5 RIGID INSULATION OVER FLUID APPLIED AIR BARRIER ON 8" (MIN. R-19) FOAM FILLED CMU - PAINT INSIDE FACE OF CMU.

NOTE: LEGEND IS FOR IDENTIFICATION ON ARCHITECTURAL PLANS ONLY. SEE ELEVATIONS FOR HEIGHTS, JOINT LOCATIONS AND DECORATIVE REVEALS. SEE STRUCTURAL DRAWINGS AND SPECIFICATIONS FOR NOTES, BRACING, AND OTHER TECHNICAL INFORMATION. DIMENSIONS OF EXTERIOR FRAMED WALLS ARE GIVEN TO THE EXTERIOR FACE OF METAL STUD.


INTERIOR PARTITION TYPES

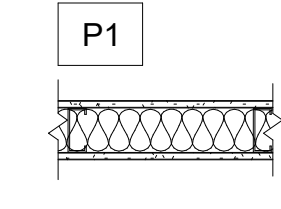


3 5/8" METAL STUDS AT 16" O.C. W/ 5/8" TYPE 'X' PAINTED GYP. BD. EACH SIDE WITH 1 1/2" THICK SOUND ATTENUATION BLANKETS HEAD OF WALL AT 6" ABOVE CEILING

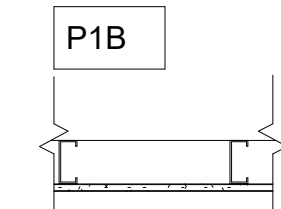


FURRING WALL 3 5/8" METAL STUDS AT 16" O.C. W/ 5/8" GYP. BD. ONE SIDE HEAD OF WALL 6" ABOVE CEILING

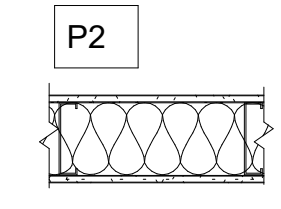

6" METAL STUDS AT 16" O.C. TO STRUCTURE ABOVE W/ 5/8" TYPE 'X' PAINTED GYP. BD. EACH SIDE WITH 1 1/2" THICK SOUND ATTENUATION BLANKETS

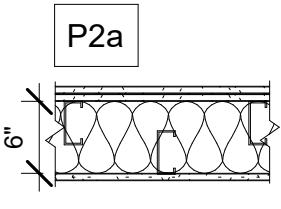


SOUND BOOTH PARTITIONS
3 5/8" METAL STUDS STAGGERED AT 16" O.C. TO STRUCTURE ABOVE W/ 5/8" TYPE 'X' PAINTED GYP. BD. (ONE LAYER EXTERIOR, TWO LAYERS INTERIOR) AND 1 1/2" THICK SOUND ATTENUATION BLANKETS
NOTE: STAGGER JOINTS IN GYP BD. TAPE AND BED EACH LAYER SEPARATELY. SEAL ALL GYP BD EDGES TO STRUCTURE AND SEAL ALL WALL PENETRATIONS WITH ACOUSTIC CAULK.

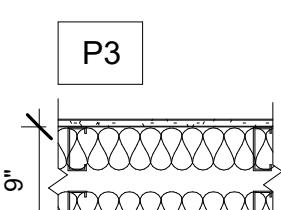

DOUBLE 3 5/8" METAL STUDS AT 16" O.C. TO STRUCTURE ABOVE W/ 5/8" TYPE 'X' PAINTED GYP. BD. EACH SIDE WITH 1 1/2" THICK SOUND ATTENUATION BLANKETS

NOTE: ALL GYP. BD. TYPE 'X' U.N.O.
INTERIOR STUD WALLS ARE 6" METAL STUDS AT 16" O.C. U.N.O.





PROVIDE CONTROL JOINTS IN GYP BD. WALLS AT 30' MAX - PREFERABLY ABOVE DOOR FRAMES
PROVIDE MOISTURE RESISTANT GYPSUM BOARD IN ALL WET AREAS AND WHEREVER NOTED ON DWGS.
SEE STRUCTURAL FOR STUD SPACING AND SHEAR WALLS - TYP.
ALL OUTSIDE CORNERS AND WING WALLS OF EXPOSED CMU PARTITIONS TO HAVE BULLNOSE CORNERS
DIMENSIONS OF FRAMED WALLS ARE GIVEN TO ONE FACE OF THE STUD
DIMENSIONS OF MASONRY WALLS ARE GIVEN TO ONE FACE OF THE MASONRY

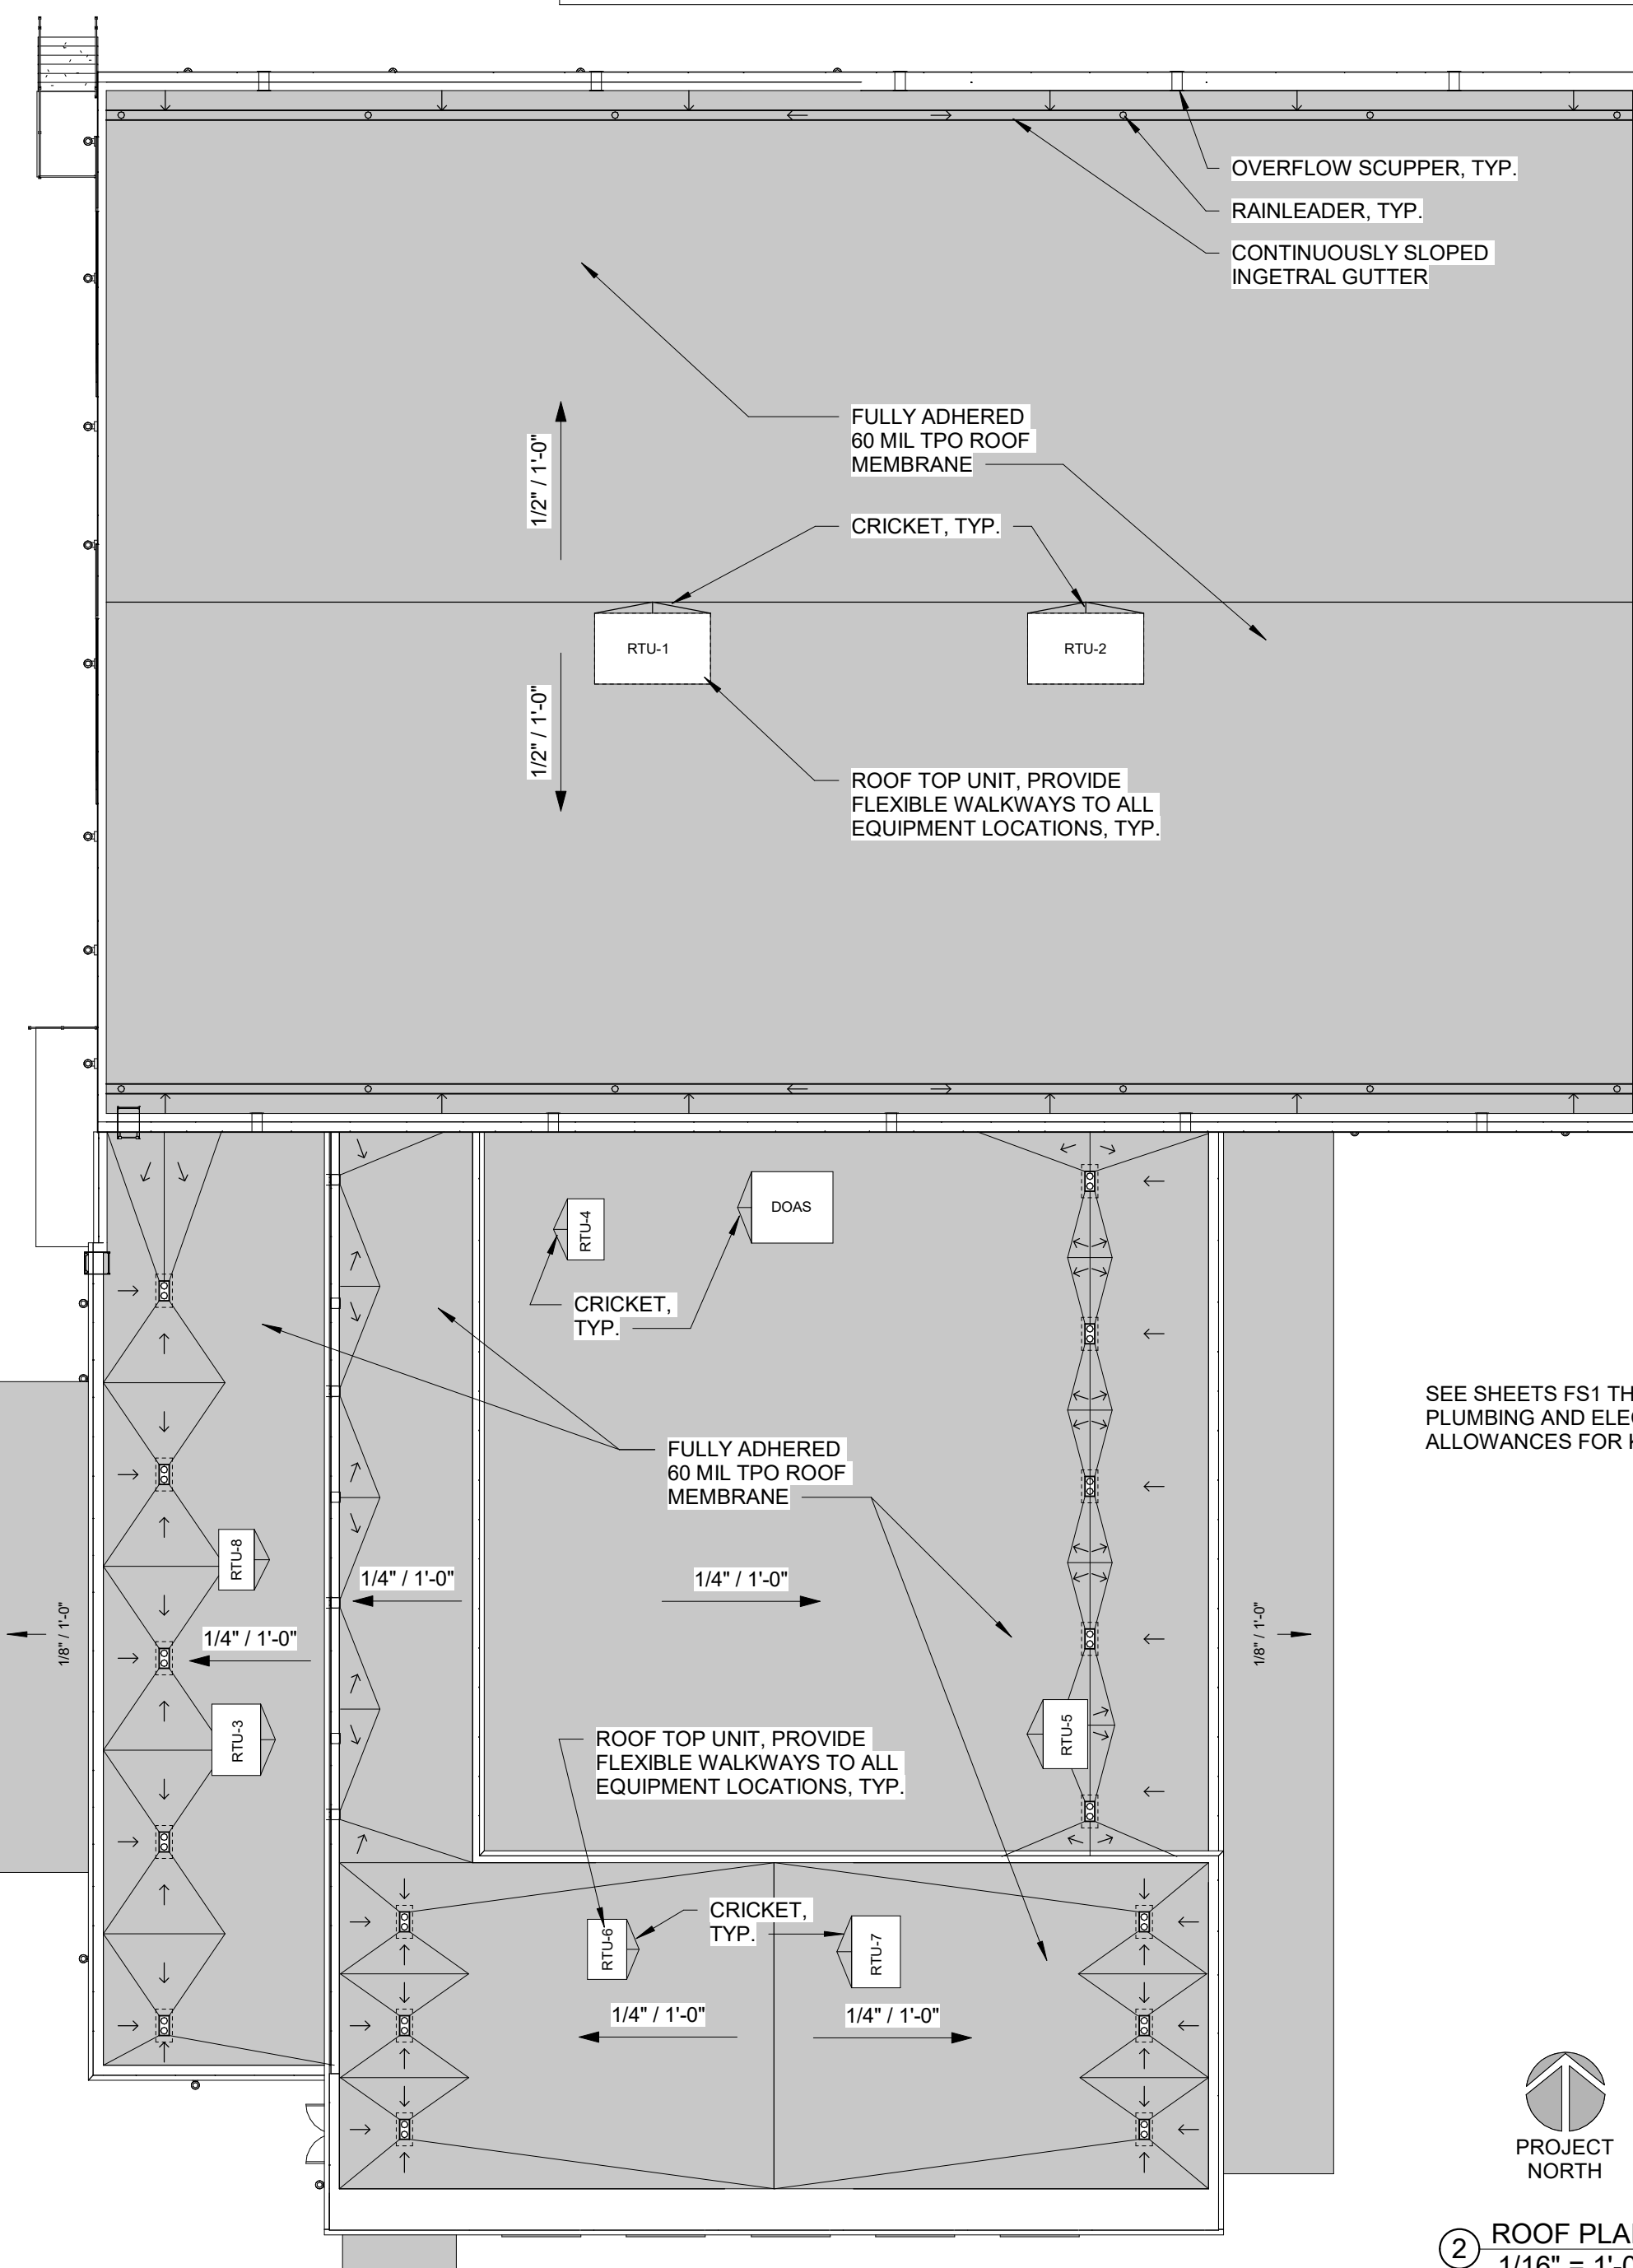


SEE SHEETS F51 THRU F54 FOR CONCESSION PLUMBING AND ELECTRICAL. SEE SPEC ALLOWANCES FOR KITCHEN EQUIPMENT.



2 ROOF PLAN
1/16" = 1'-0"

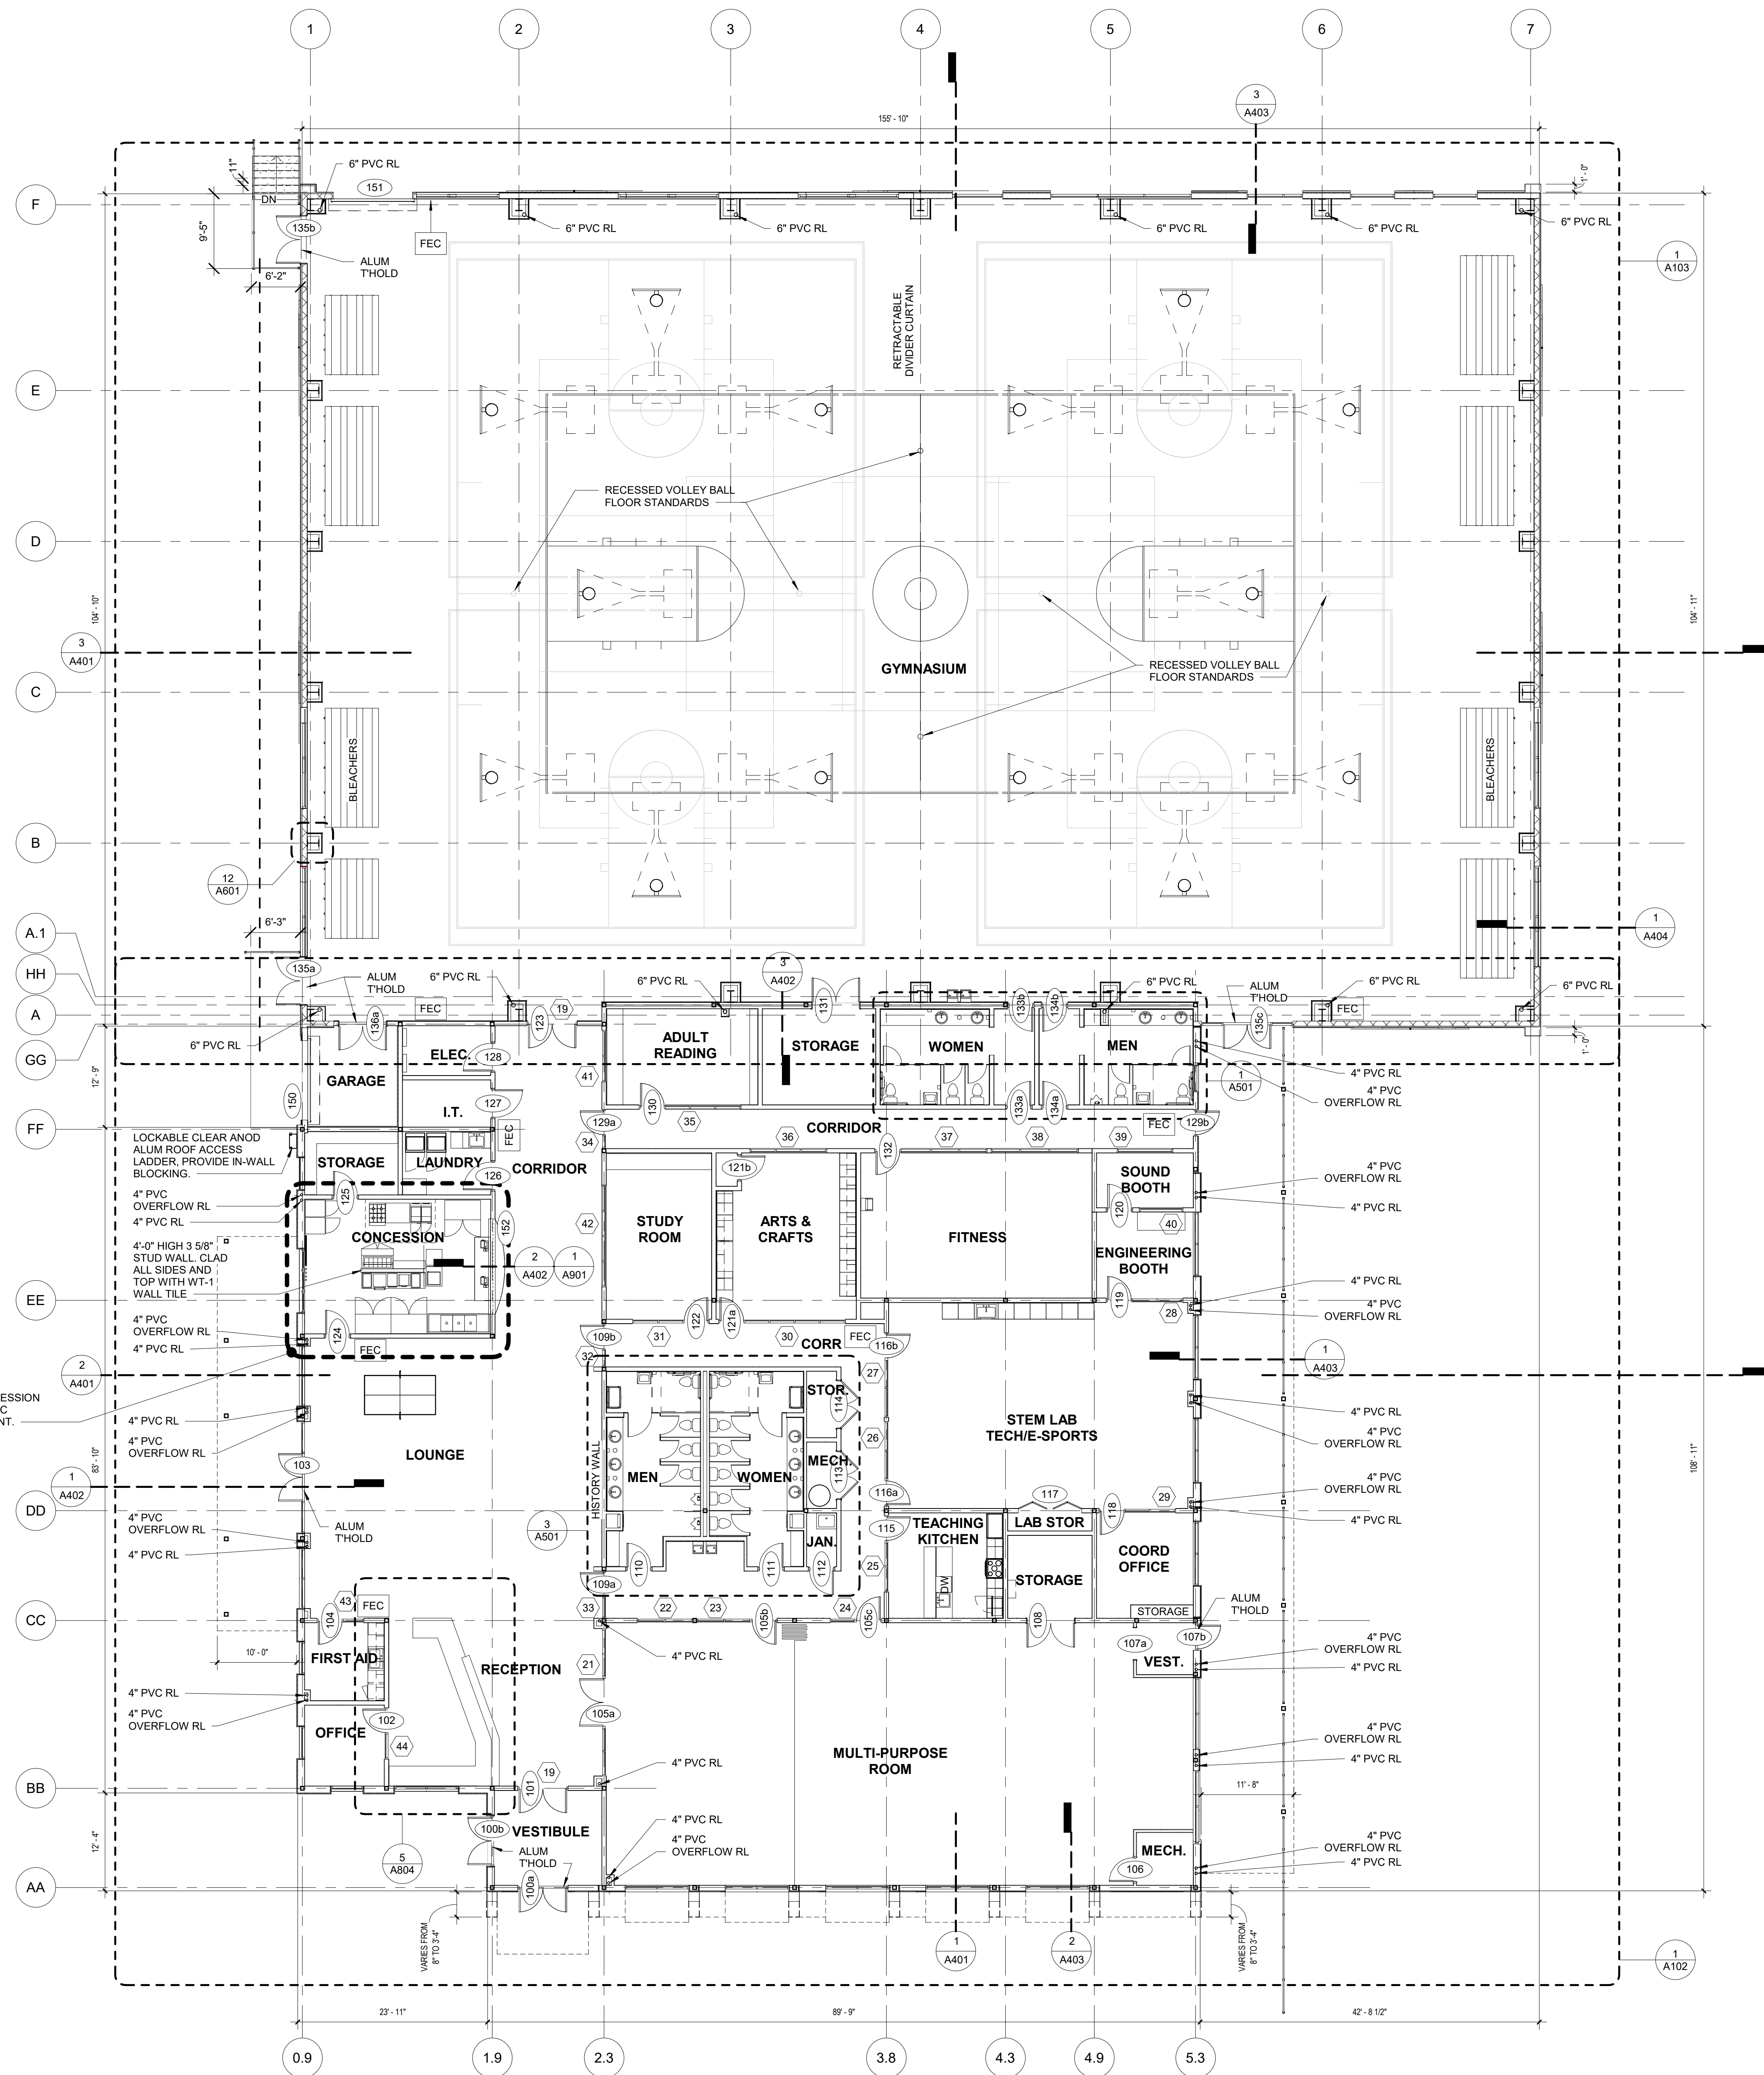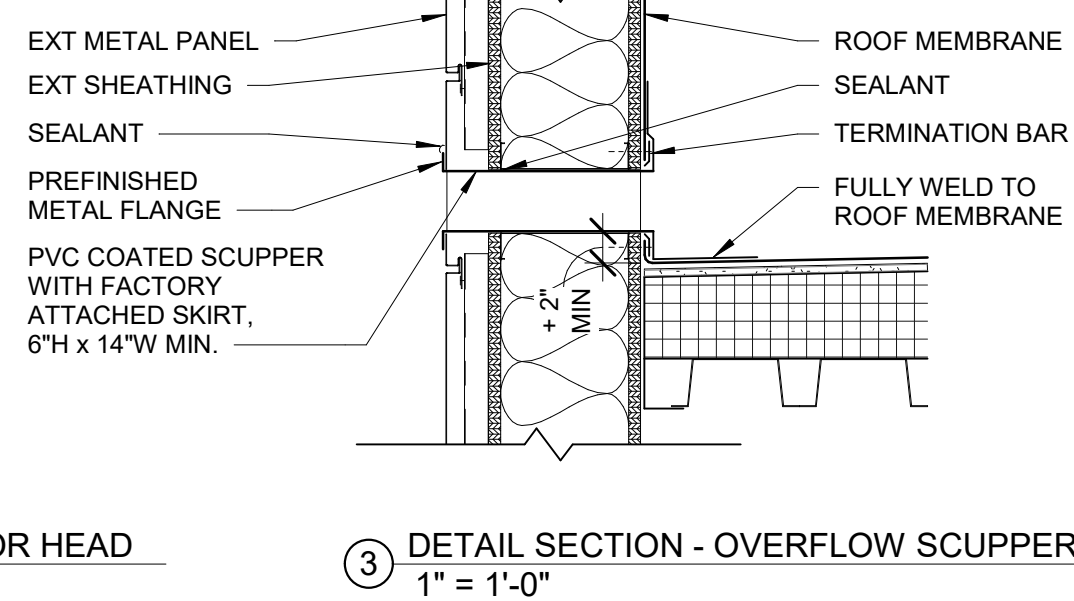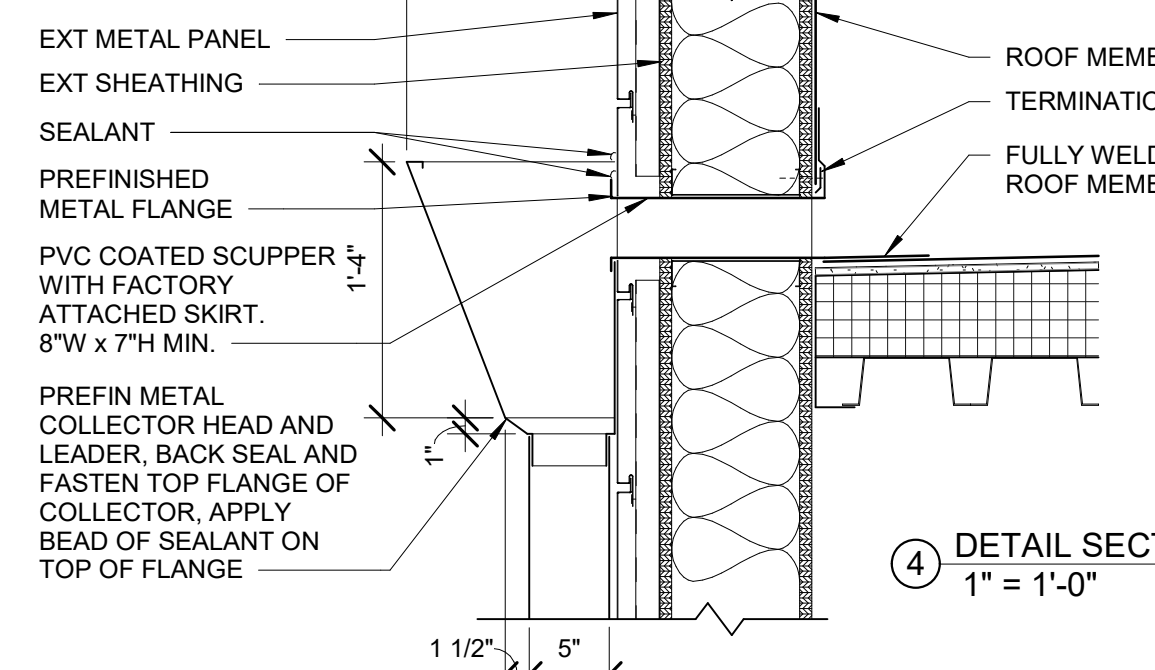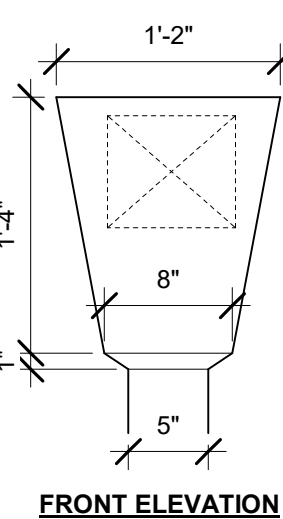

1 FLOOR PLAN - LEVEL 1
1" = 10'-0"

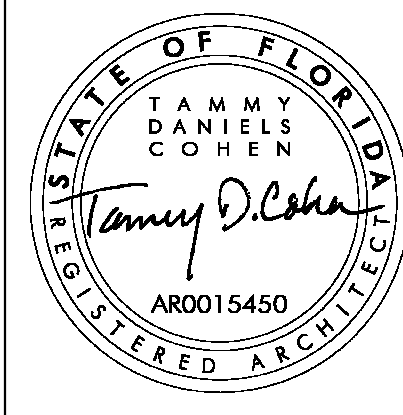

MARTIN LUTHER KING JR. RECREATION CENTER

705 14TH COURT EAST
PANAMA CITY, FL 32401

JOB NUMBER:
21109

DATE:
05/18/2023

PRINTED / REVISIONS
DESCRIPTION DATE

SHEET TITLE:
FLOOR PLAN - LEVEL 1

SHEET NUMBER:

A101

MARTIN LUTHER KING JR. RECREATION CENTER
705 14TH COURT EAST

705 14TH COURT EAST
PANAMA CITY, FL 32401

JOB NUMBER:
21109


DATE:
05/18/2023

PRINTED / REVISIONS		
#	DESCRIPTION	DATE


SHEET TITLE:
FLOOR PLAN - LEVEL 1
Alternate

SHEET NUMBER:

A101-ALT

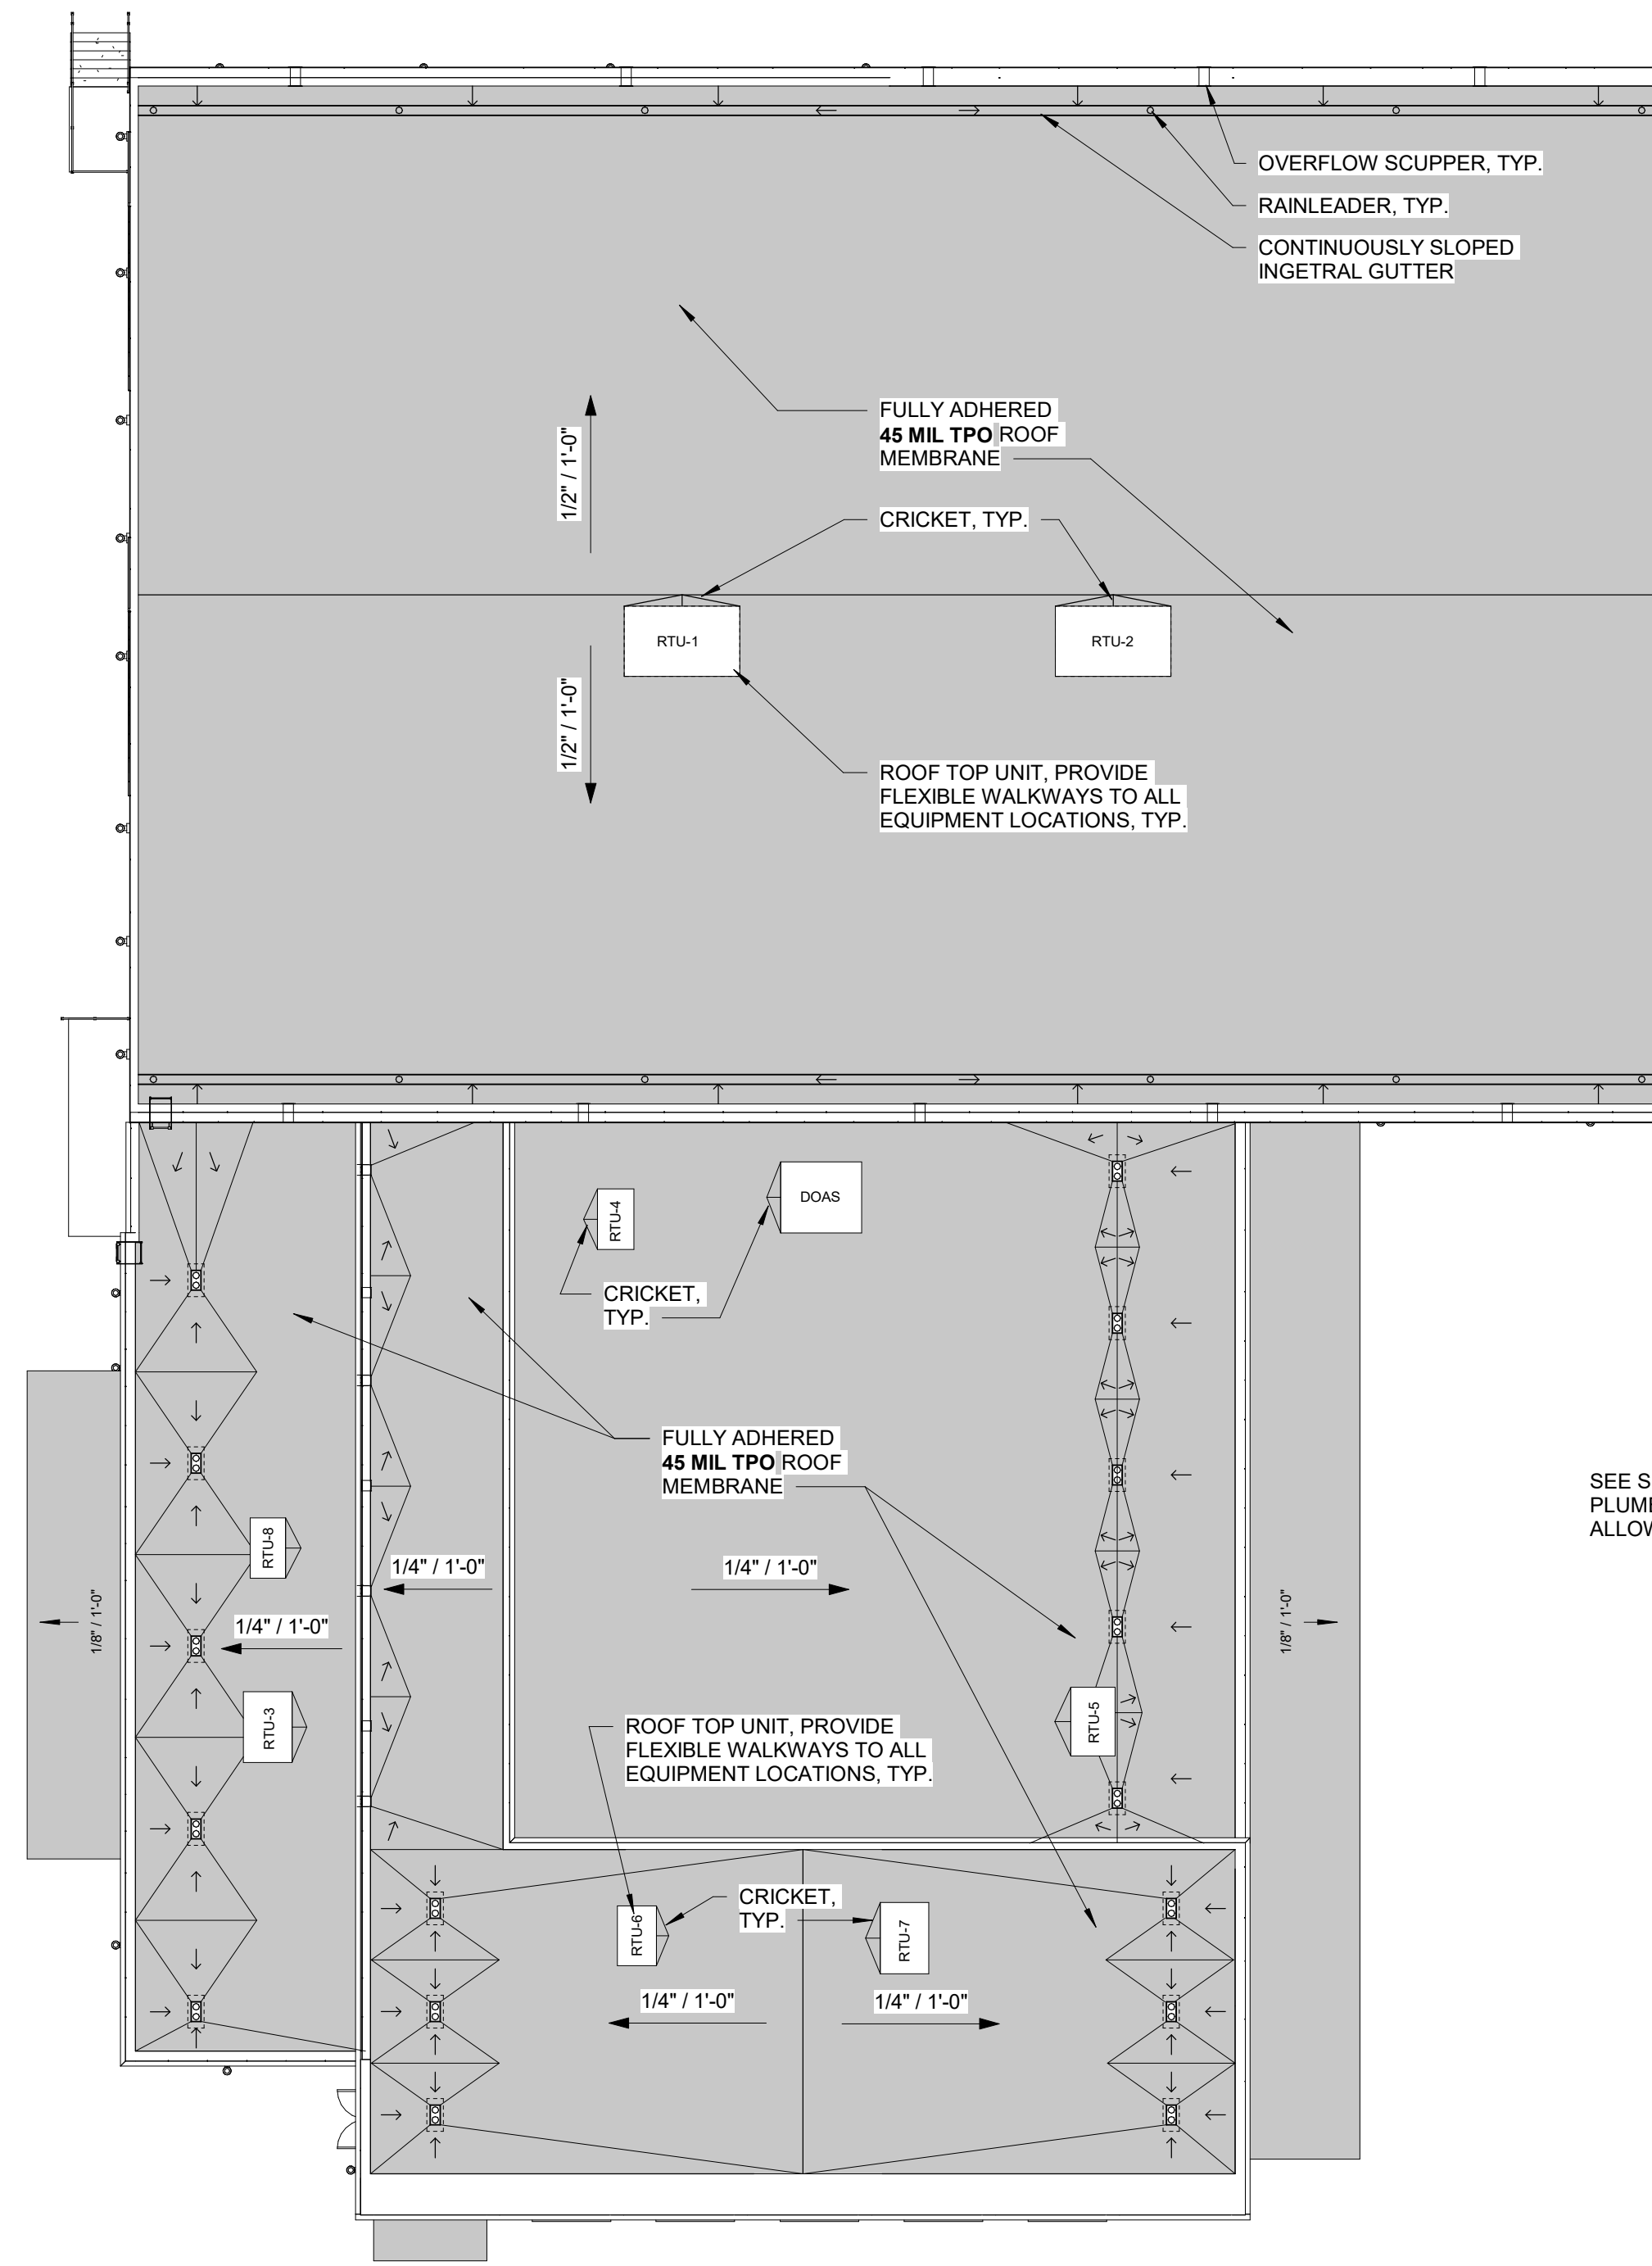


② ROOF PLAN - Alternate
1/16" = 1'-0"

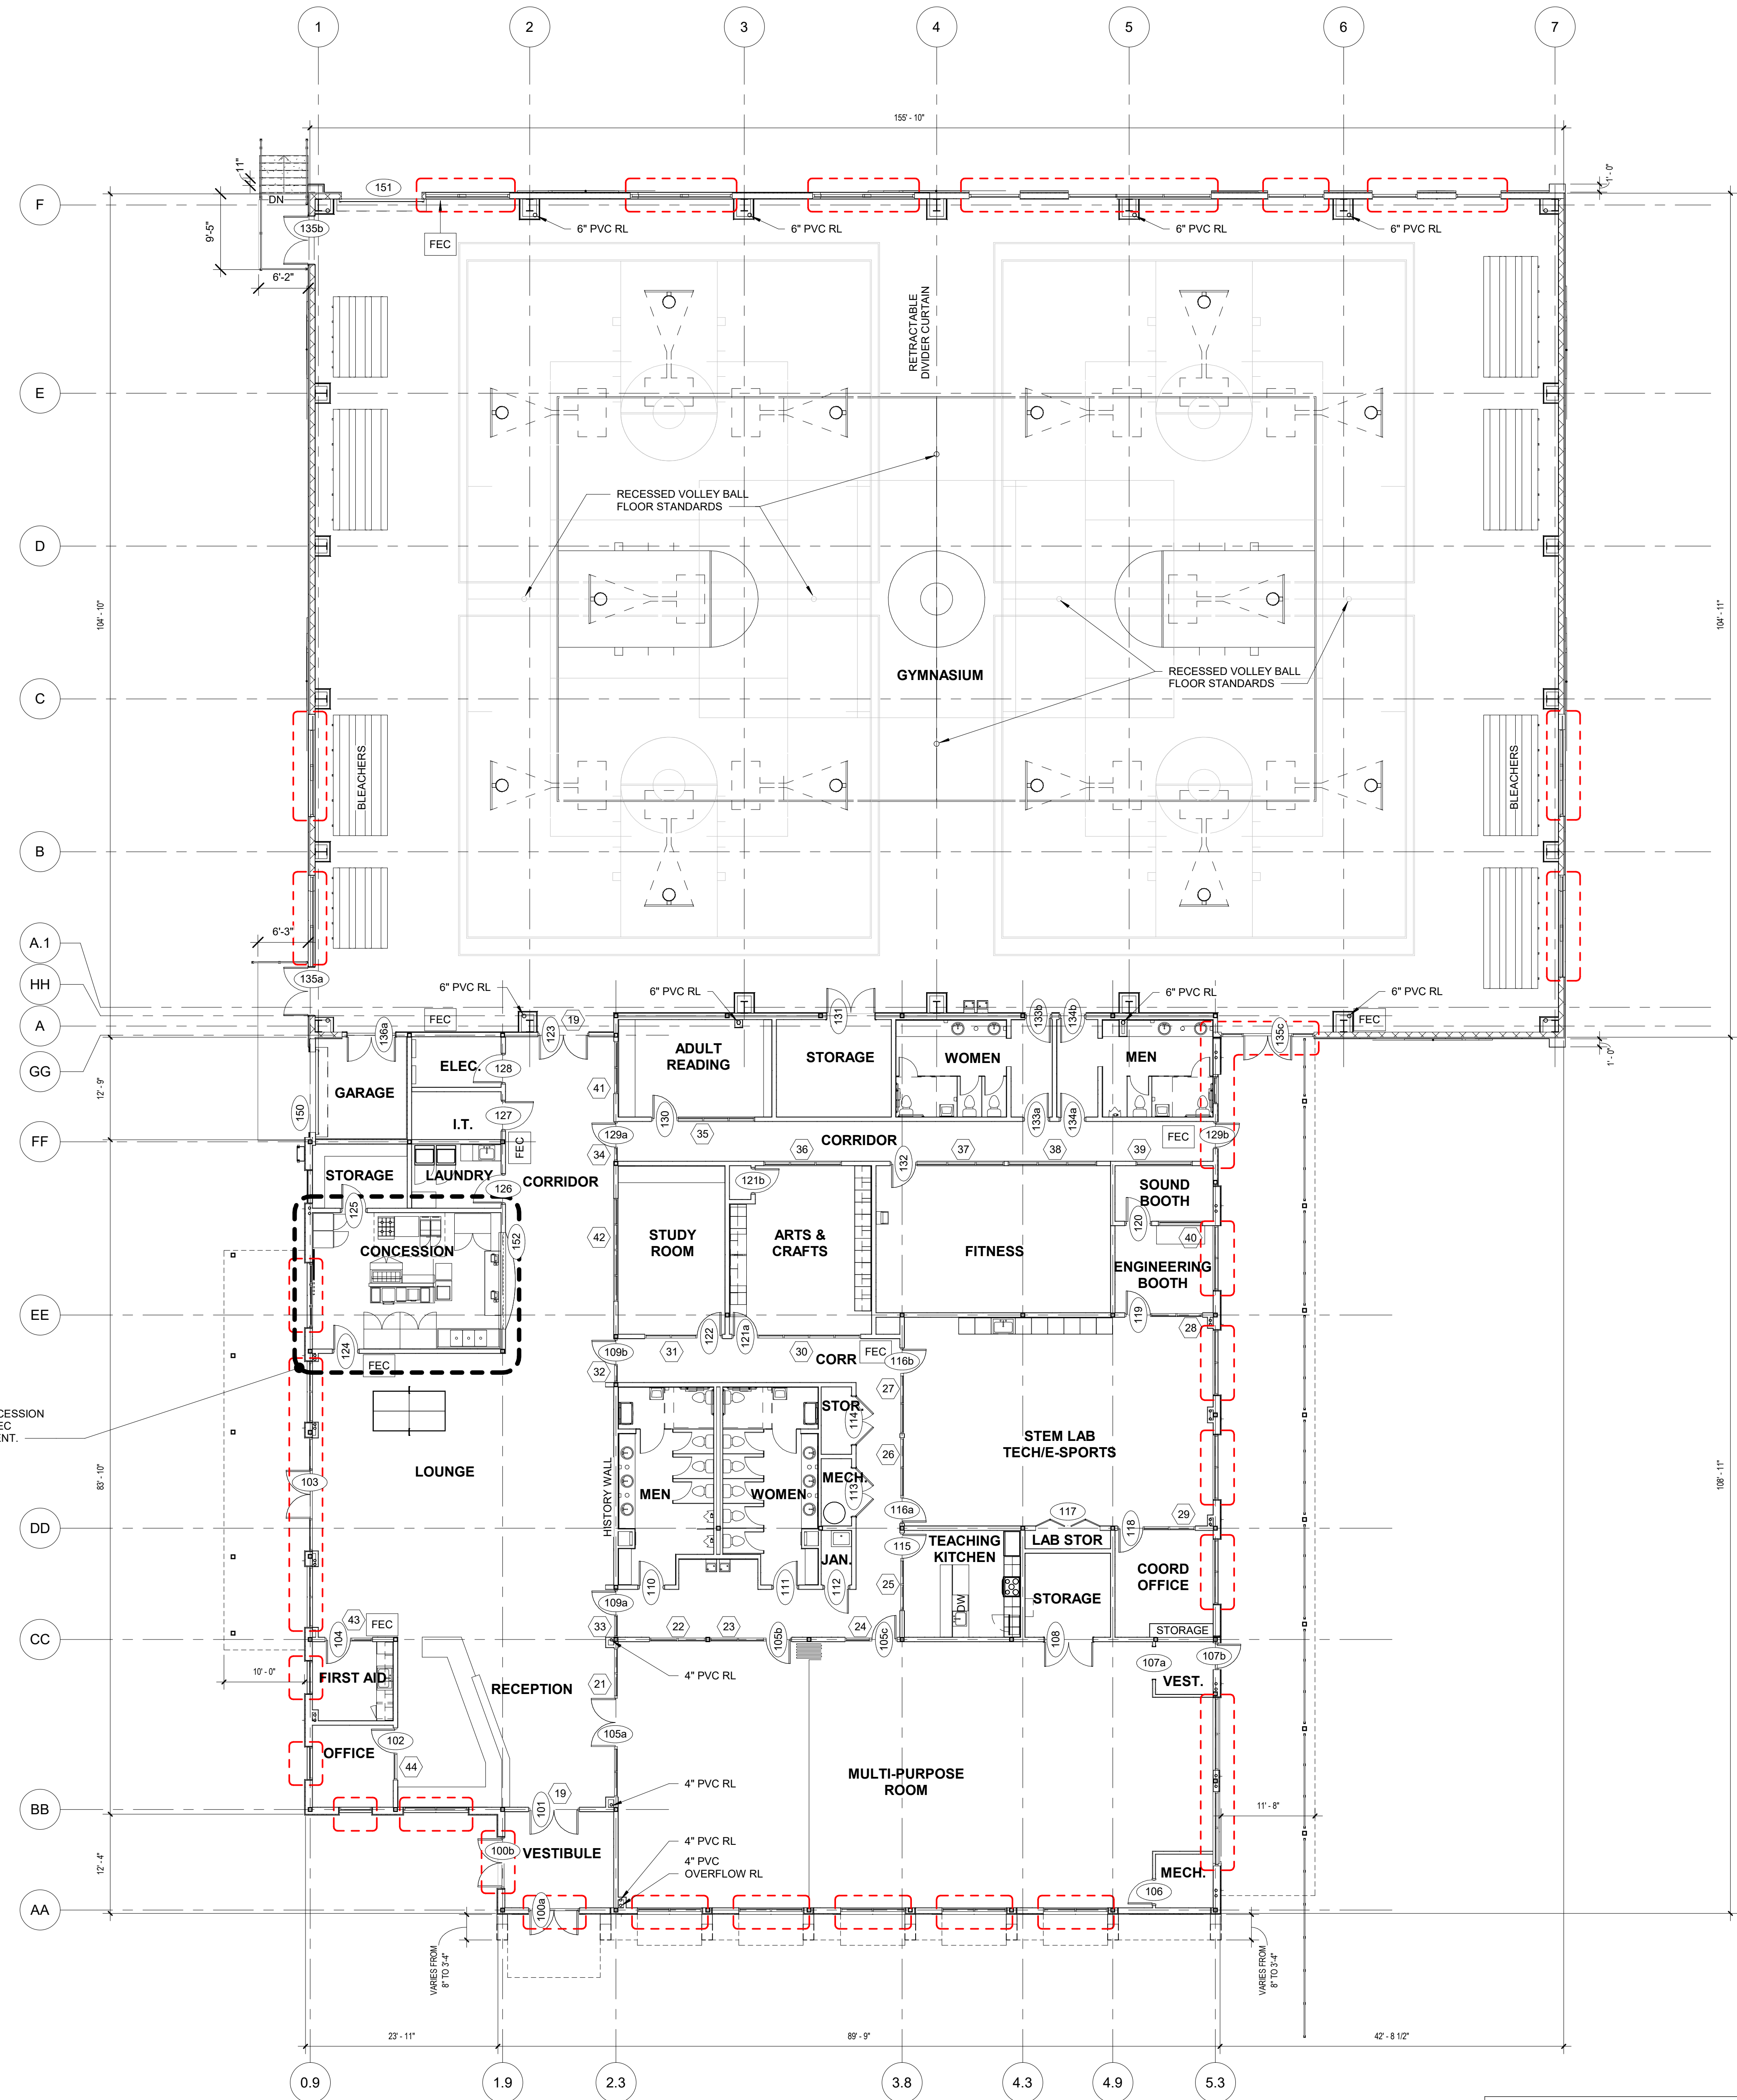

① FLOOR PLAN - LEVEL 1 Alternate
1" = 10'-0"

LEGEND

**140 MPH NON-IMPACT RATED
EXTERIOR WINDOW/DOOR OPENINGS:
PROVIDE NON-IMPACT RATED GLASS
AND STOREFRONT FRAMING AS
DESCRIBED ON SHEET A902-ALT, 140
MPH EXTERIOR STOREFRONT SYSTEM**

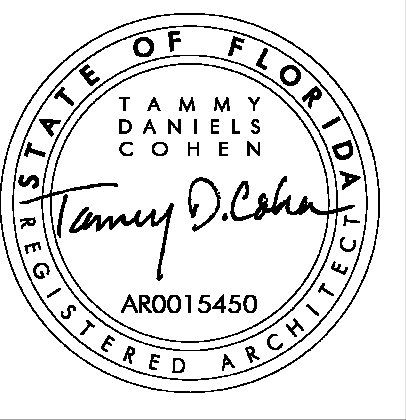

CCR ARCHITECTURE & INTERIORS

MARTIN LUTHER KING JR. RECREATION CENTER

705 14TH COURT EAST
PANAMA CITY, FL 32401

JOB NUMBER:
21109


DATE:
05/18/2023

PRINTED / REVISIONS
DESCRIPTION DATE

SHEET TITLE:
ENLARGED PLAN - MAIN

SHEET NUMBER:


A102

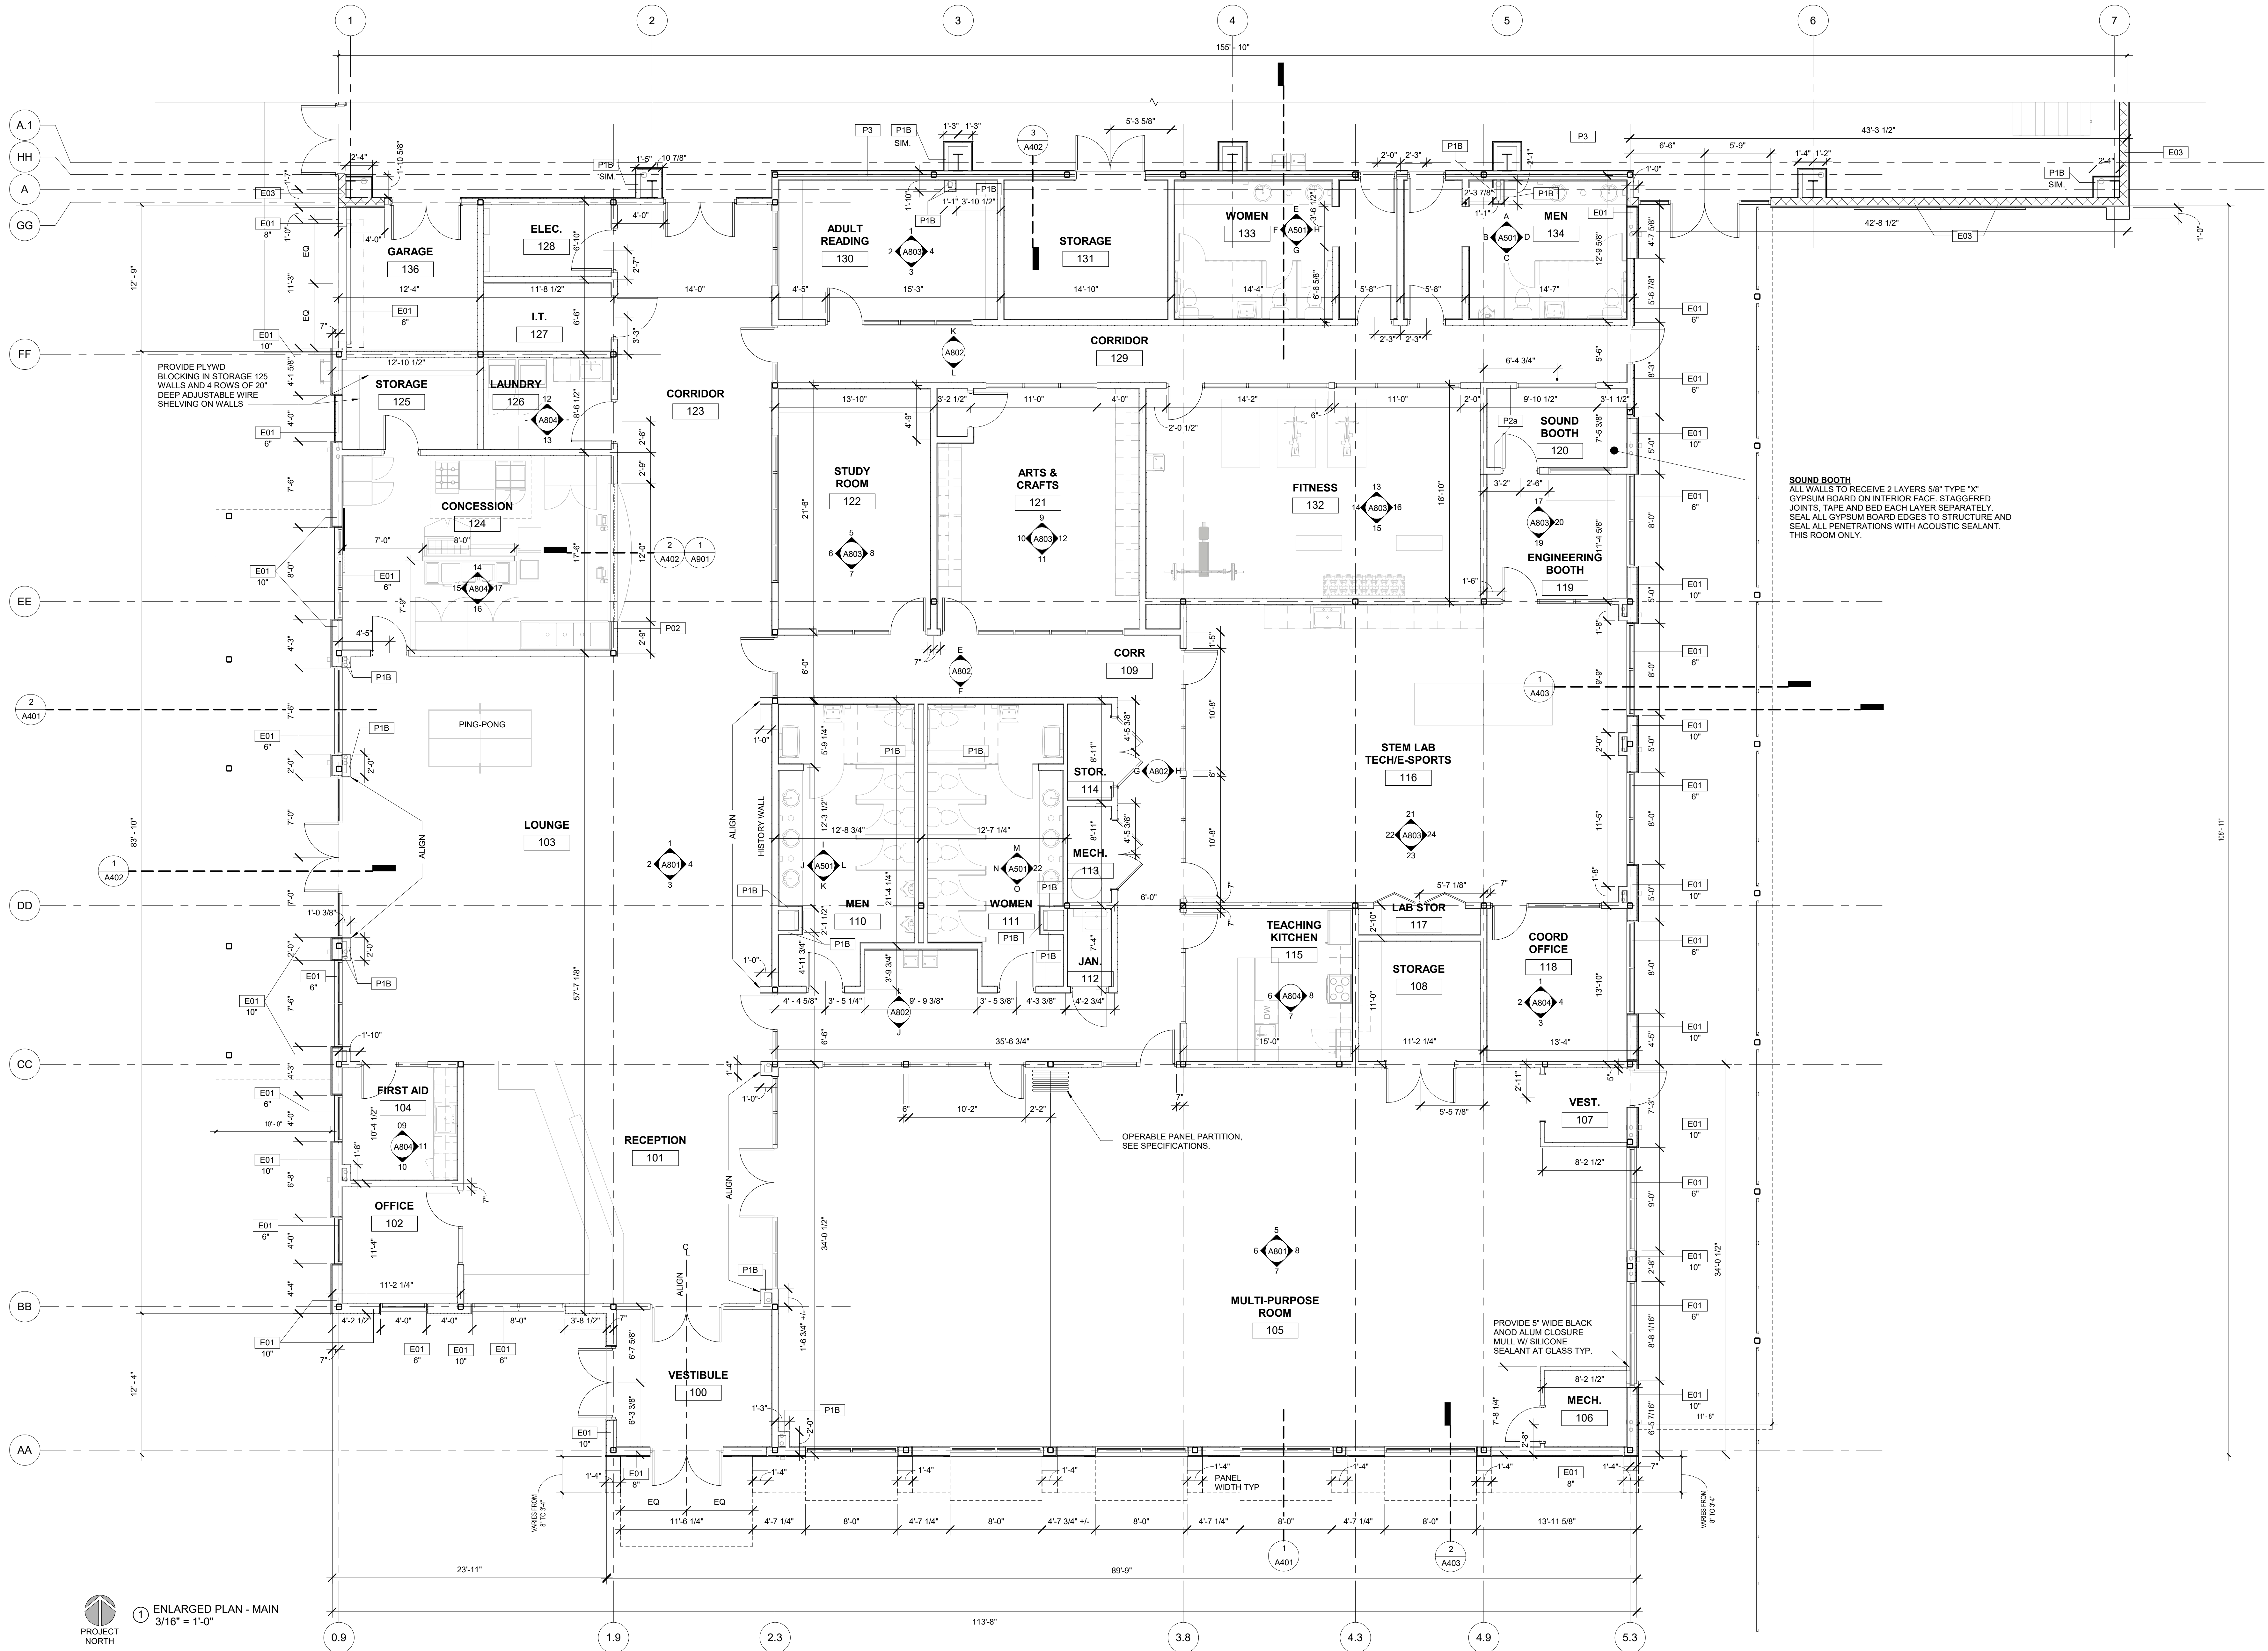


PROJECT NORTH
1 ENLARGED PLAN - MAIN
3/16" = 1'-0"

05/20/2023 10:52 AM PANAMA CITY 68623100 Panama City, AL - New Building - Scheme 2 of 4
THIS DRAWING IS THE PROPERTY OF CCR ARCHITECTURE & INTERIORS AND IS NOT TO BE REPRODUCED, COPIED OR ALTERED IN WHOLE OR IN PART OR USED FOR ANY PURPOSE WITHOUT THE APPROVAL OF CCR ARCHITECTURE & INTERIORS AND IS TO BE RETURNED UPON REQUEST.

05/18/2023 10:28 AM 705 14TH COURT EAST PANAMA CITY 32401
THIS DRAWING IS THE PROPERTY OF CCR ARCHITECTURE & INTERIORS AND IS NOT TO BE REPRODUCED, COPIED OR ALTERED IN WHOLE OR IN PART OR USED FOR ANY PURPOSE WITHOUT THE APPROVAL OF CCR ARCHITECTURE & INTERIORS AND IS TO BE RETURNED UPON REQUEST.

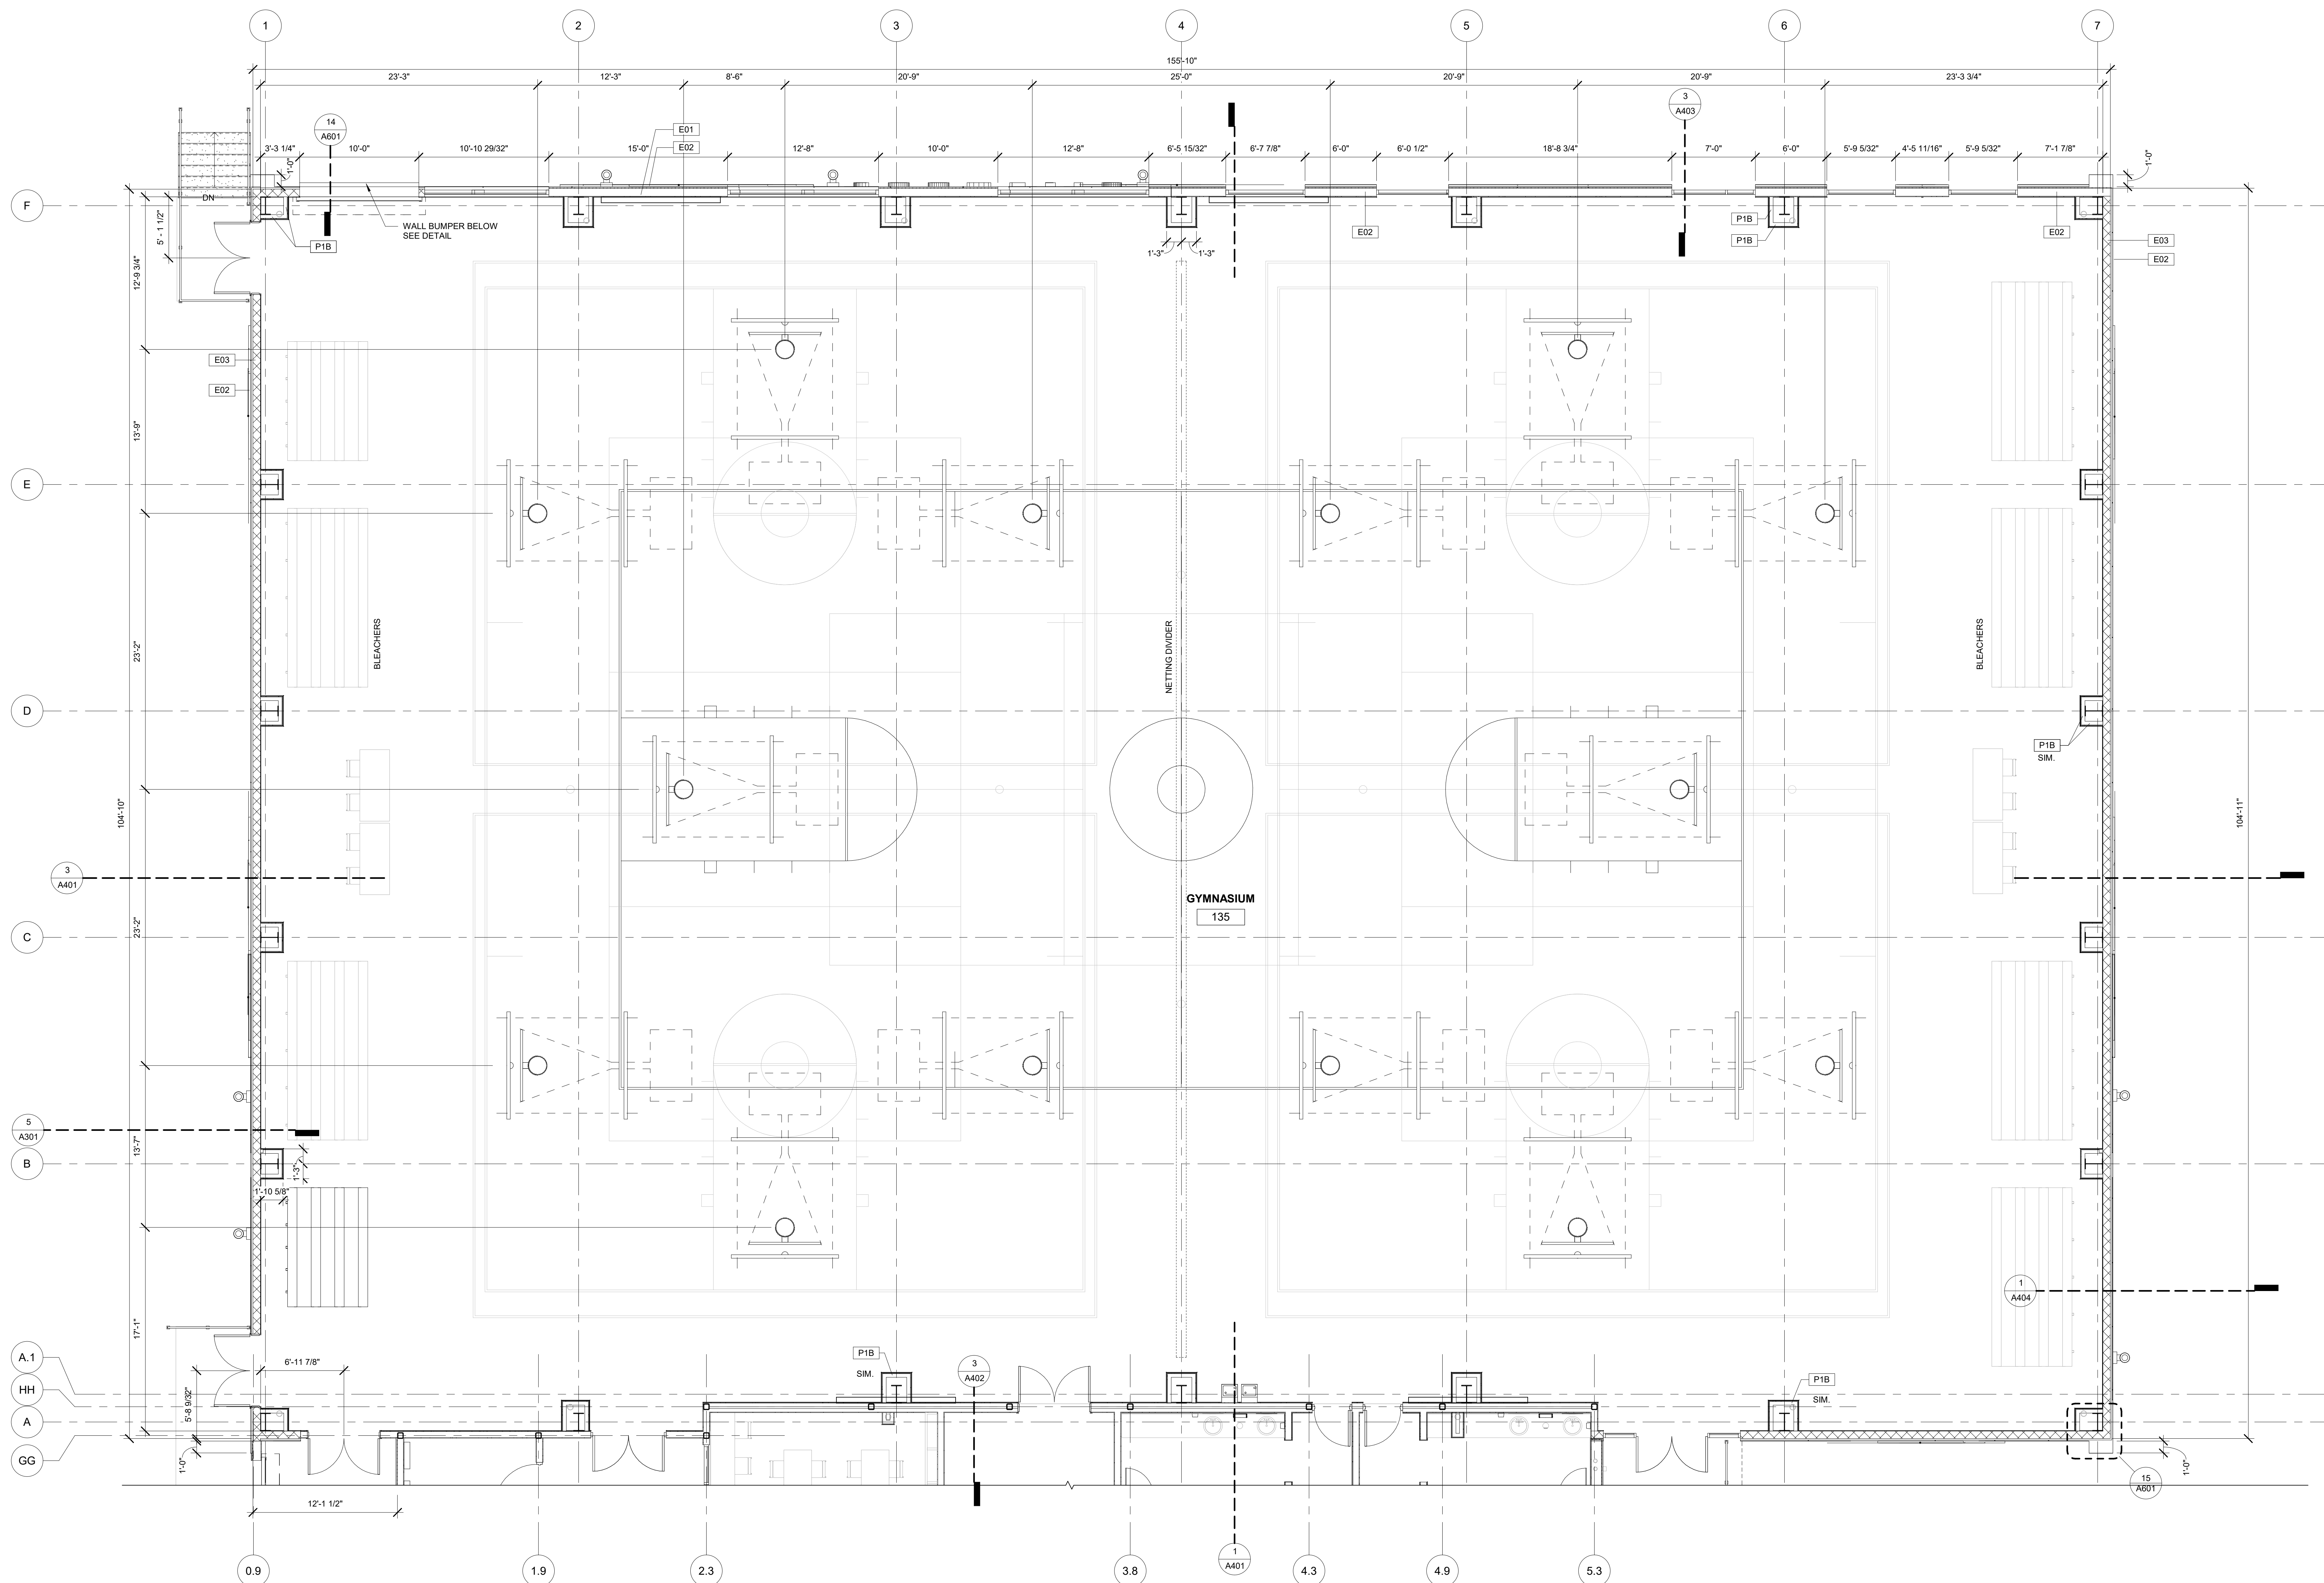

1 ENLARGED PLAN - GYM BASKETBALL GOAL LAYOUT
3/16" = 1'-0"

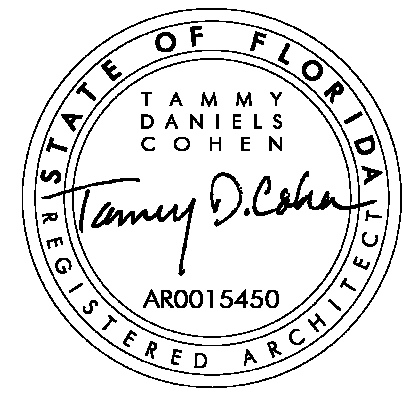

CCR ARCHITECTURE & INTERIORS

MARTIN LUTHER KING JR. RECREATION CENTER
705 14TH COURT EAST
PANAMA CITY, FL 32401

JOB NUMBER:
21109


DATE:
05/18/2023

PRINTED / REVISIONS
DESCRIPTION DATE


SHEET TITLE:
ENLARGED PLAN - GYM

SHEET NUMBER:
A103

05/02/2023 10:58 AM, PANAMA CITY, FL 32401, 100 Panama City Ave., New Building - Scheme 2 of 4
THIS DRAWING IS THE PROPERTY OF CCR ARCHITECTURE & INTERIORS AND IS NOT TO BE REPRODUCED, COPIED OR ALTERED IN WHOLE OR IN PART OR USED FOR ANY PURPOSE WITHOUT THE APPROVAL OF CCR ARCHITECTURE & INTERIORS AND IS TO BE RETURNED UPON REQUEST.

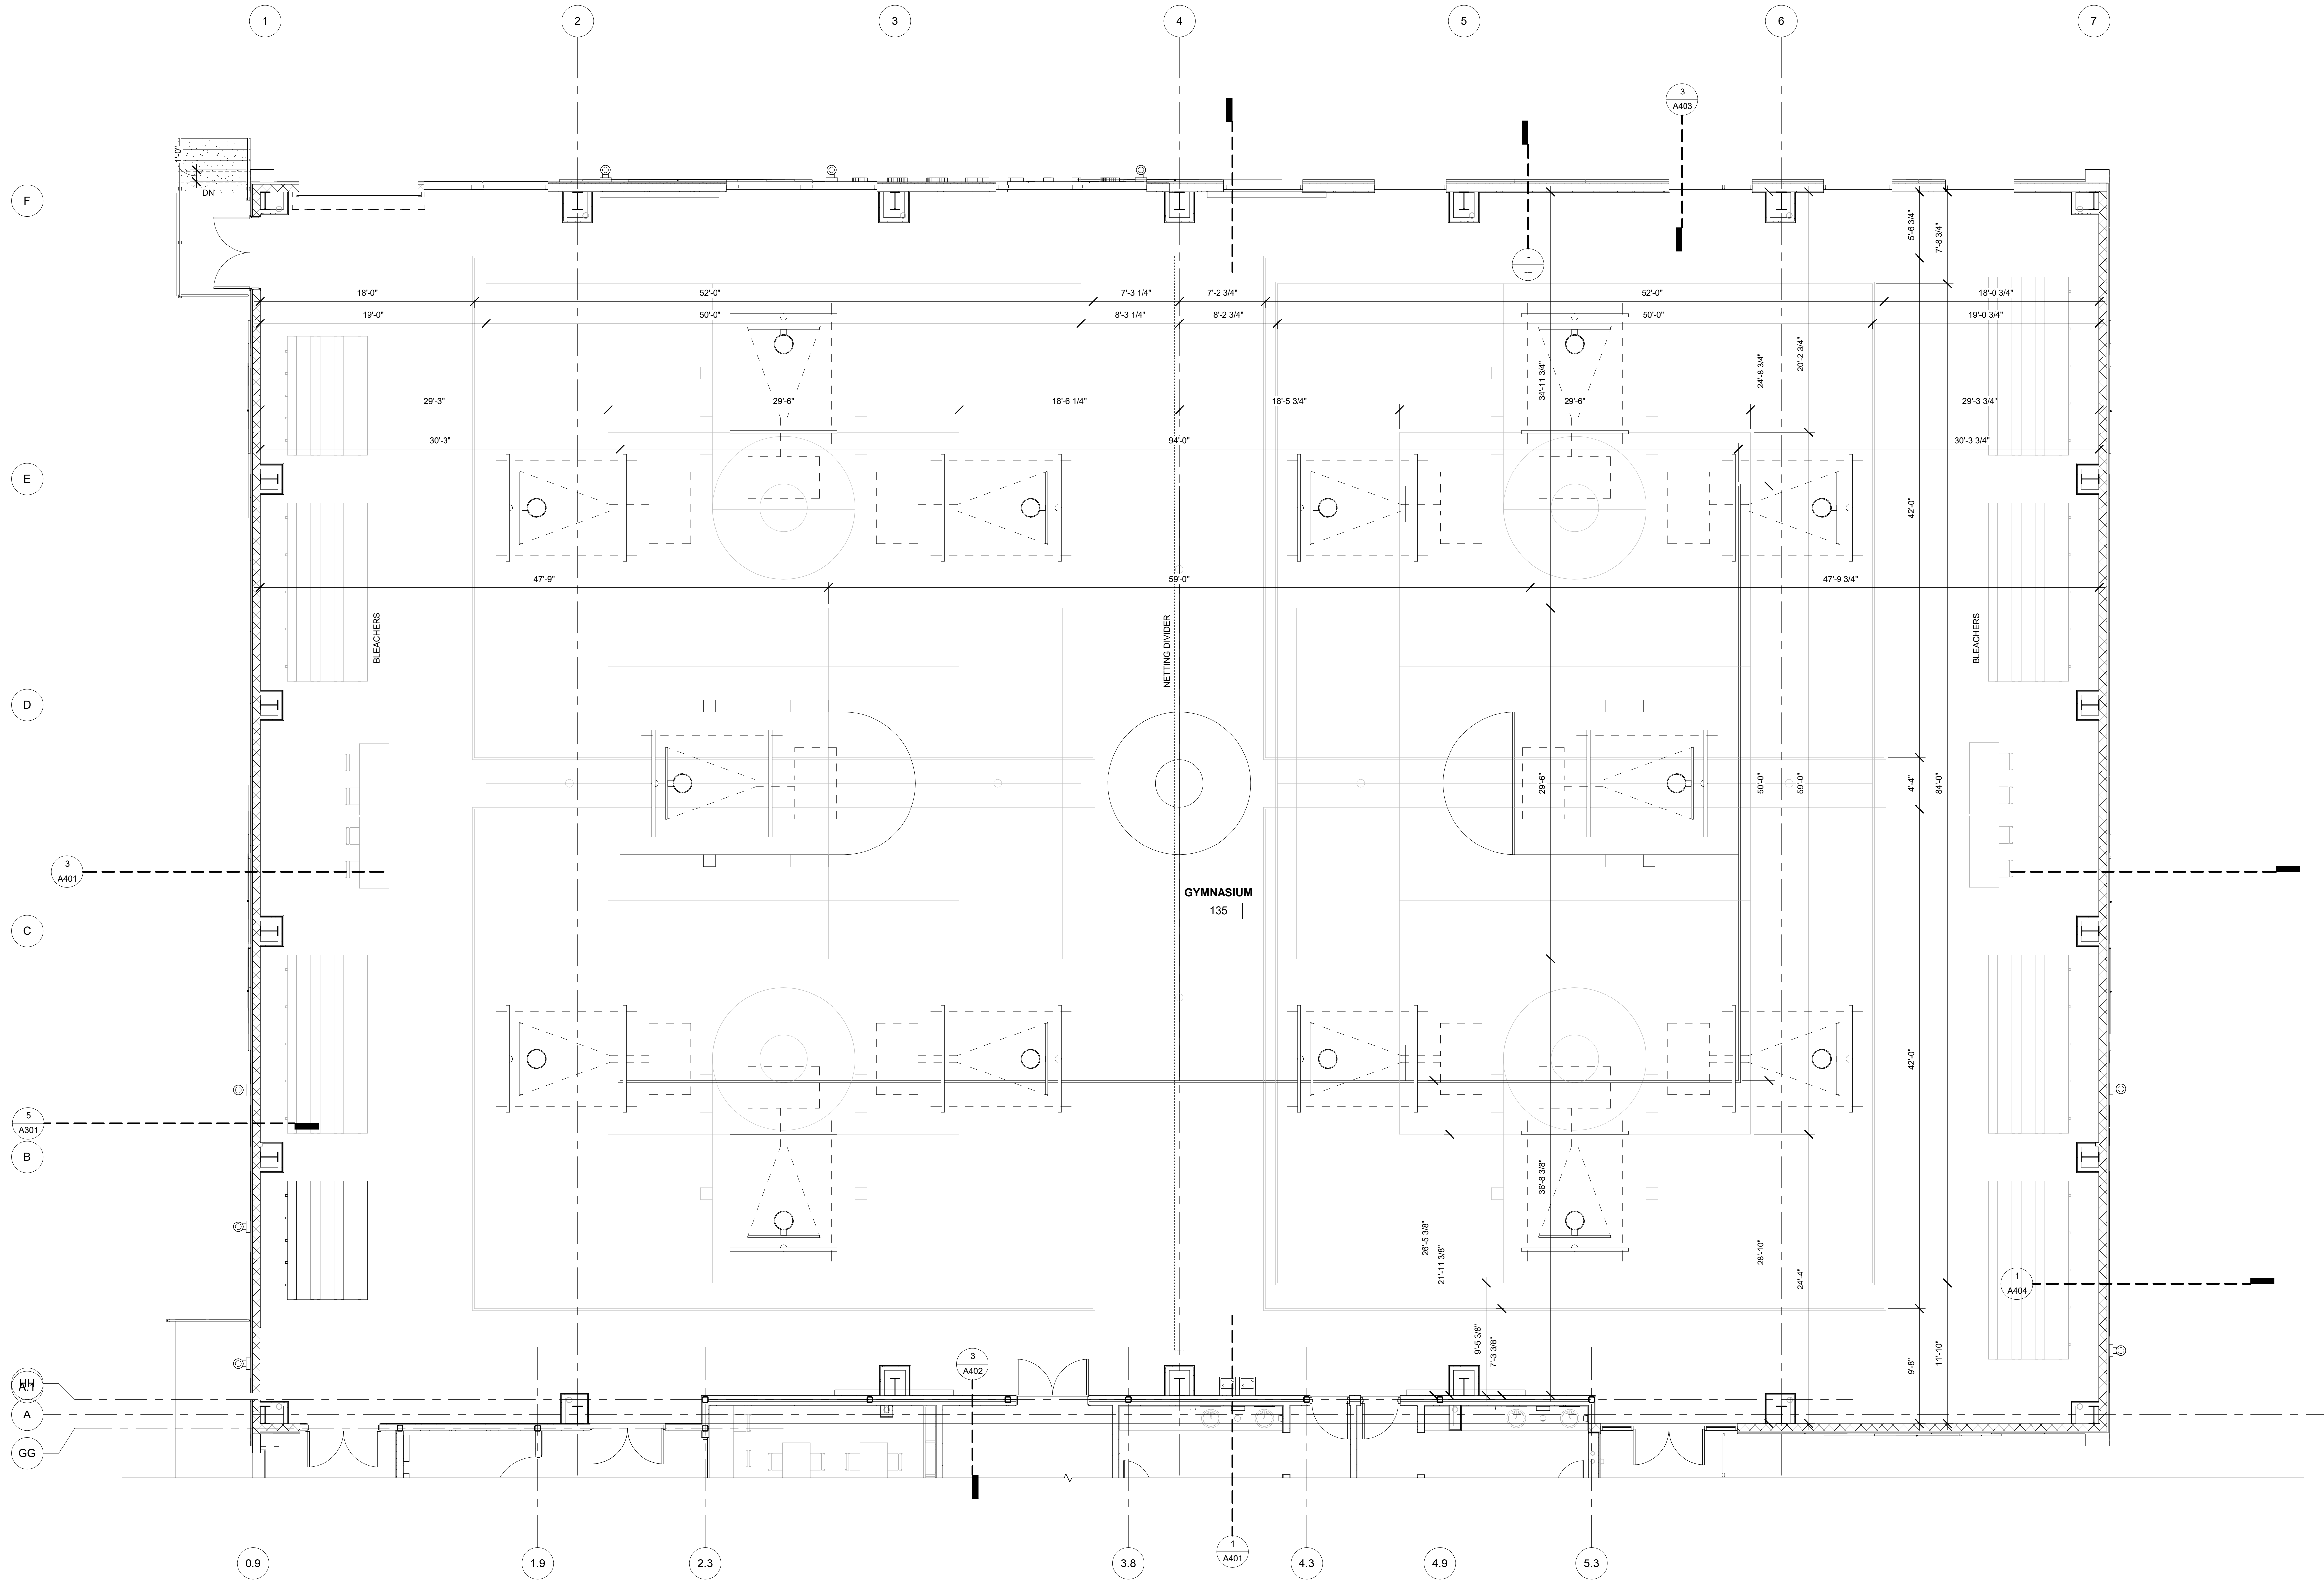

1 ENLARGED PLAN - GYM COURT LAYOUT
3/16" = 1'-0"

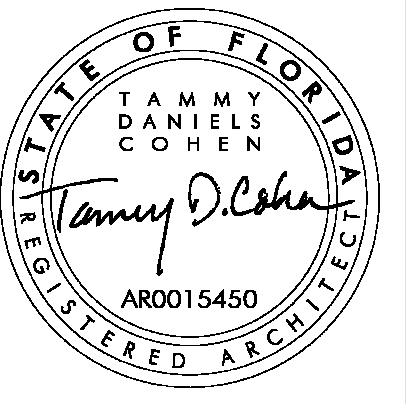

CCR ARCHITECTURE & INTERIORS

MARTIN LUTHER KING JR. RECREATION CENTER

705 14TH COURT EAST
PANAMA CITY, FL 32401

JOB NUMBER:
21109

DATE:
05/18/2023


PRINTED / REVISIONS
DESCRIPTION DATE

SHEET TITLE:
ENLARGED PLAN -
COURT LAYOUT

SHEET NUMBER:

A104


05/18/2023 10:58 AM
2920 FIRST AVENUE SOUTH, PANAMA CITY, FL 32401
THIS DRAWING IS THE PROPERTY OF CCR ARCHITECTURE & INTERIORS AND IS NOT TO BE REPRODUCED, COPIED OR ALTERED IN WHOLE OR IN PART OR USED FOR ANY PURPOSE WITHOUT THE APPROVAL OF CCR ARCHITECTURE & INTERIORS AND IS TO BE RETURNED UPON REQUEST.

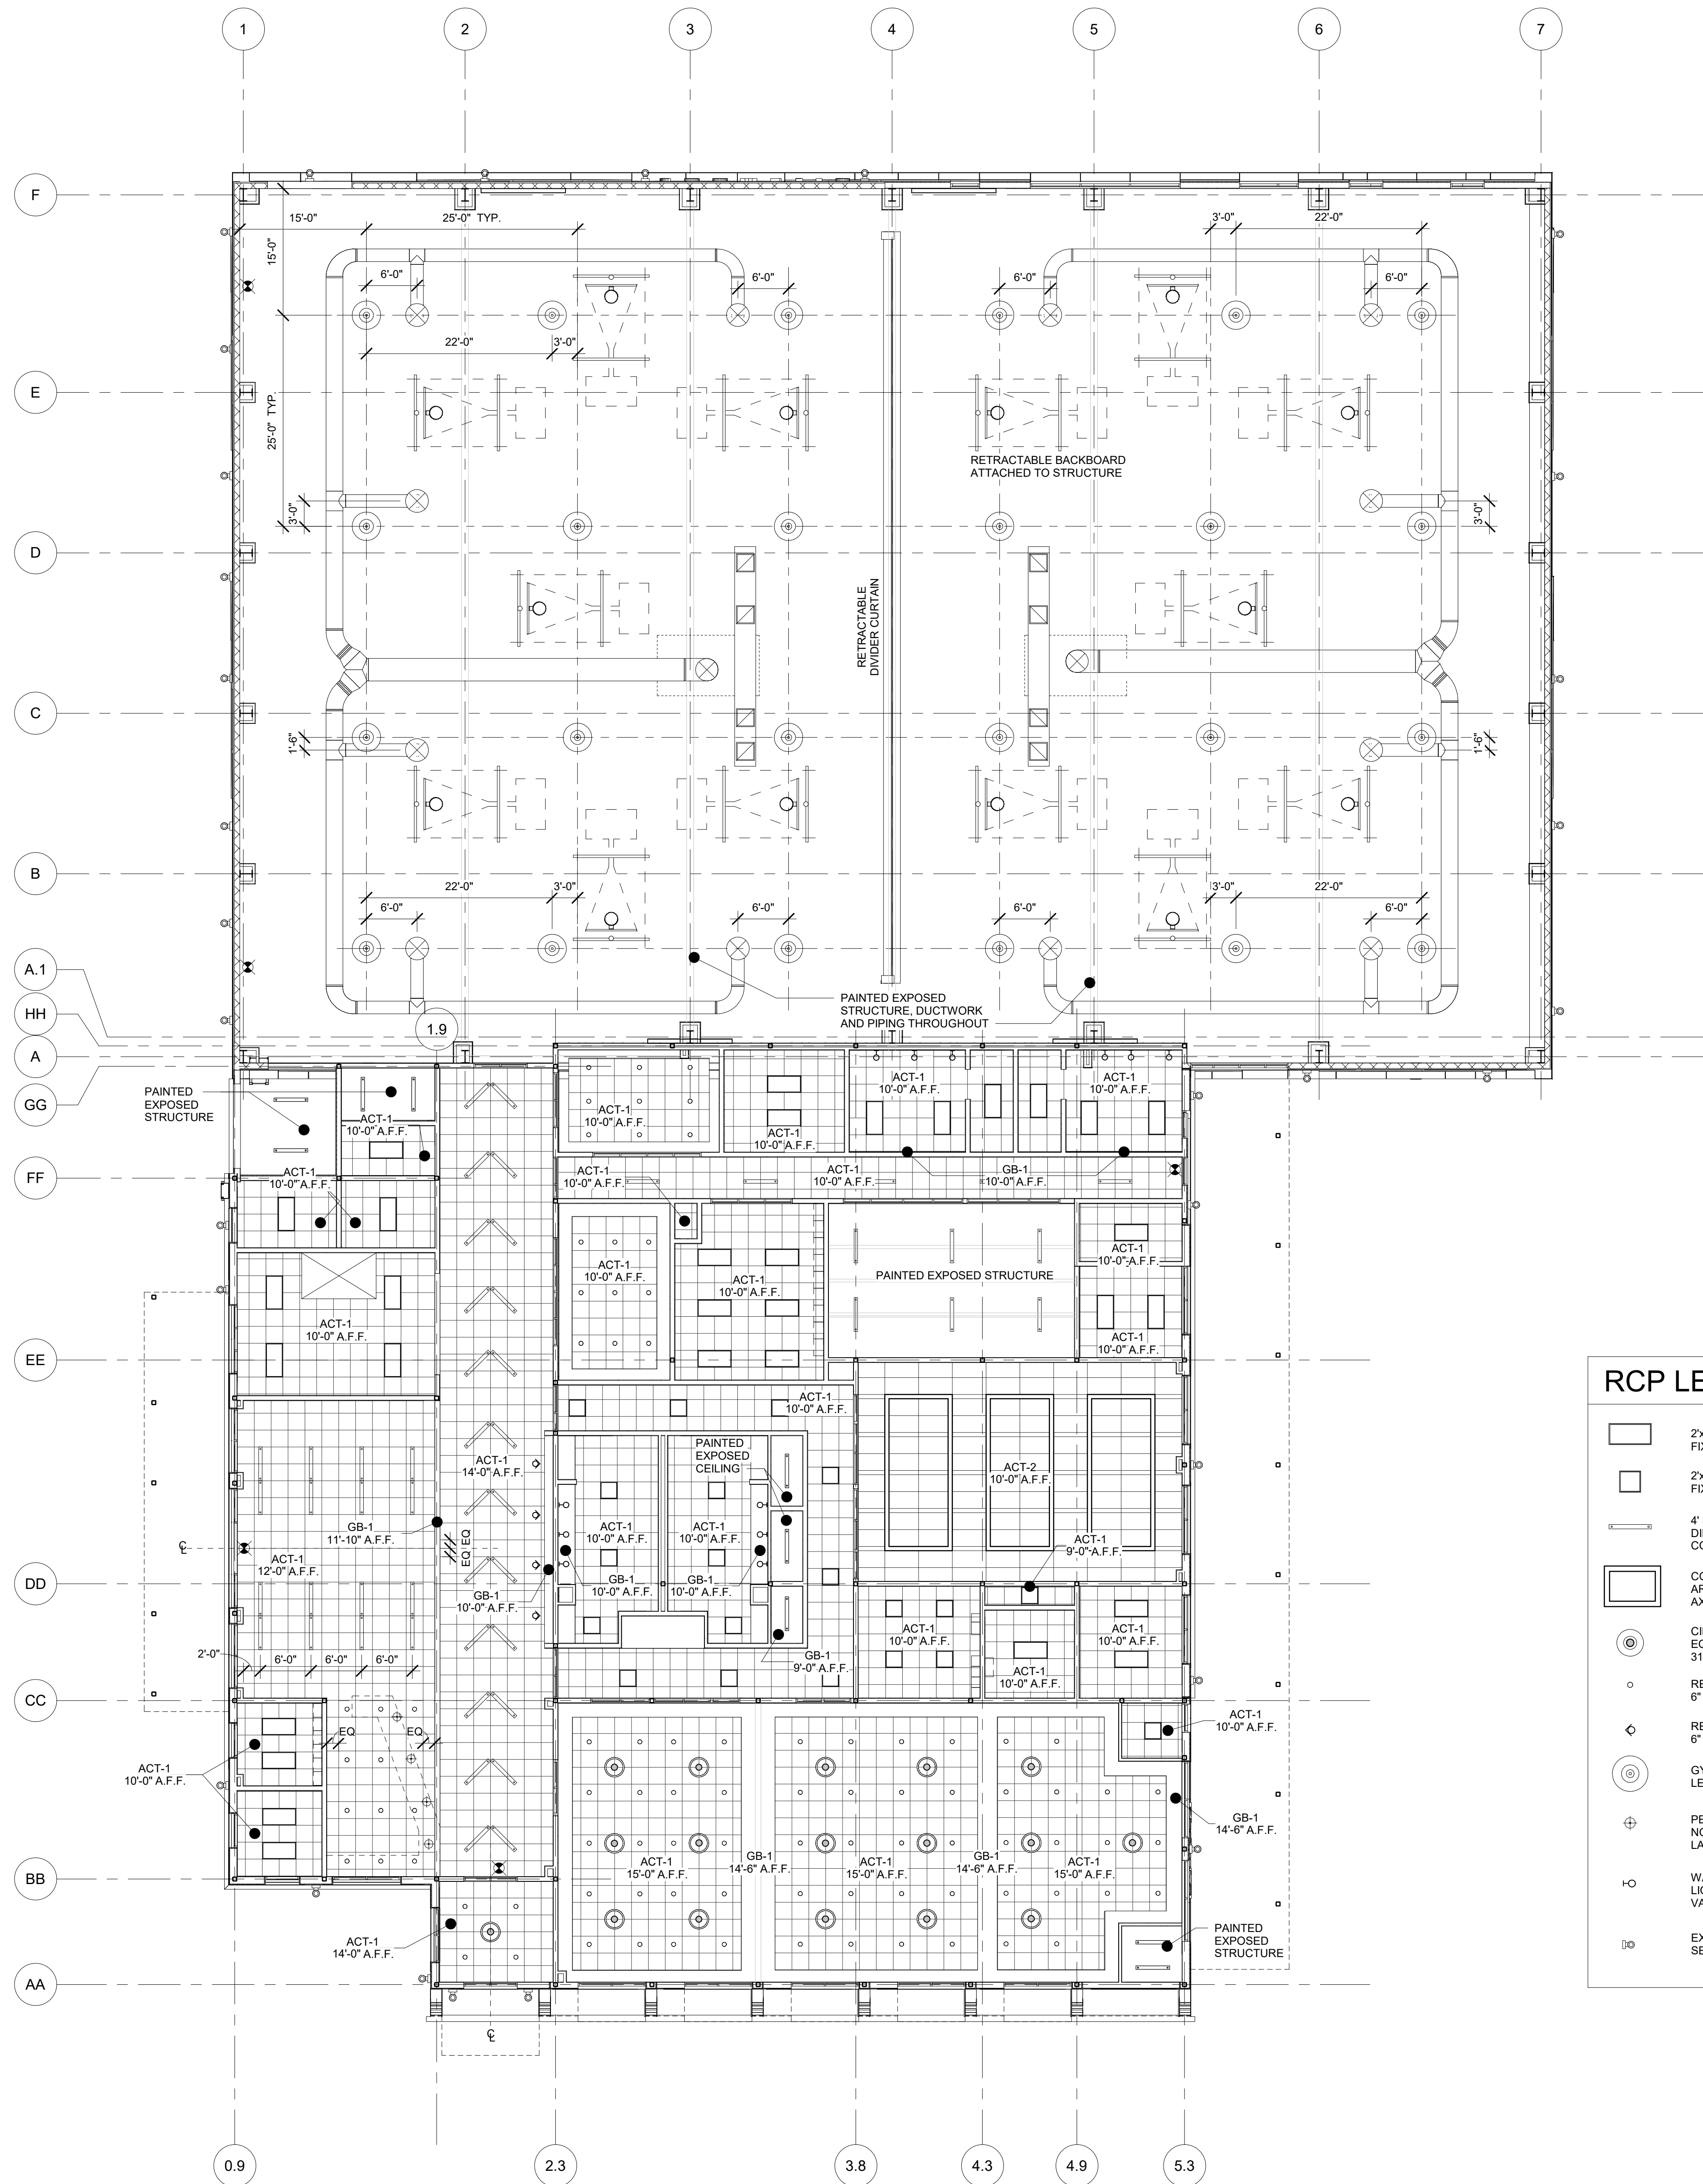

RCP LEGEND

- | | | | |
|--|---|--------------|---|
| | 2'x4' LED RECESSED DIRECT/INDIRECT LIGHT FIXTURE 3000K | ACT-1 | 24" X 24" ACOUSTICAL PANEL CEILING |
| | 2'x2' LED RECESSED DIRECT/INDIRECT LIGHT FIXTURE 3000K | ACT-2 | EQUAL TO TECHZONE ACOUSTIC PANEL CEILING - 6" TECHZONE 2'X4' PANELS |
| | 4' LINEAR PENDANT LED LIGHT FIXTURE DIRECT/INDIRECT, 3000K, DIRECT/INDIRECT COLOR: BLACK | GB-1 | GYPSUM BOARD CEILING - PAINT PER FINISH SCHEDULE |
| | CONTINUOUS LINEAR SLOT FIXTURE ARRANGED AS RECTANGLE: EQUAL TO, AXIS BEAMS | | EXPOSED DUCT AND DIFFUSER - SEE MECH |
| | CIRCULAR PENDANT LIGHT FIXTURE: EQUAL TO, CIRCA LED ROUND PENDANT 31" DIAMETER, BLACK FINISH, 3000K | | |
| | RECESSED DOWNLIGHT 6" LED, 3000K | | |
| | RECESSED DOWNLIGHT - WALL WASHER 6" LED, 3000K | | |
| | GYMNASIUM PENDANT LIGHT FIXTURE LED HIGH BAY LIGHTS | | |
| | PENDANT LIGHT FIXTURE: EQUAL TO, NORMAN COPENHAGEN BELL PENDANT LAMP SMALL, BLACK | | |
| | WALL SCONCE LIGHT FIXTURE: EQUAL TO, LIGHTLOLOGY SANDA BATHROOM VANITY LIGHT, 24", MATTE BLACK | | |
| | EXTERIOR WALL LIGHT SEE ELECTRICAL | | |

PROJECT NORTH
1 LEVEL 1
1" = 10'-0"

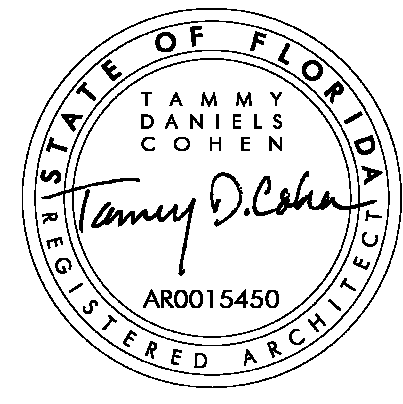

CCR ARCHITECTURE & INTERIORS

MARTIN LUTHER KING JR. RECREATION CENTER

705 14TH COURT EAST
PANAMA CITY, FL 32401

JOB NUMBER:
21109


DATE:
05/18/2023

PRINTED / REVISIONS
DESCRIPTION DATE

SHEET TITLE:
REFLECTED CEILING
PLAN - LEVEL 1

SHEET NUMBER:
A201

05/18/2023, 10:58 AM, PANAMA CITY, FL 32401, 1000 Panama City Ave., New Building - Scheme 2-4, THIS DRAWING IS THE PROPERTY OF CCR ARCHITECTURE & INTERIORS AND IS NOT TO BE REPRODUCED, COPIED OR ALTERED IN WHOLE OR IN PART OR USED FOR ANY PURPOSE WITHOUT THE APPROVAL OF CCR ARCHITECTURE & INTERIORS AND IS TO BE RETURNED UPON REQUEST.

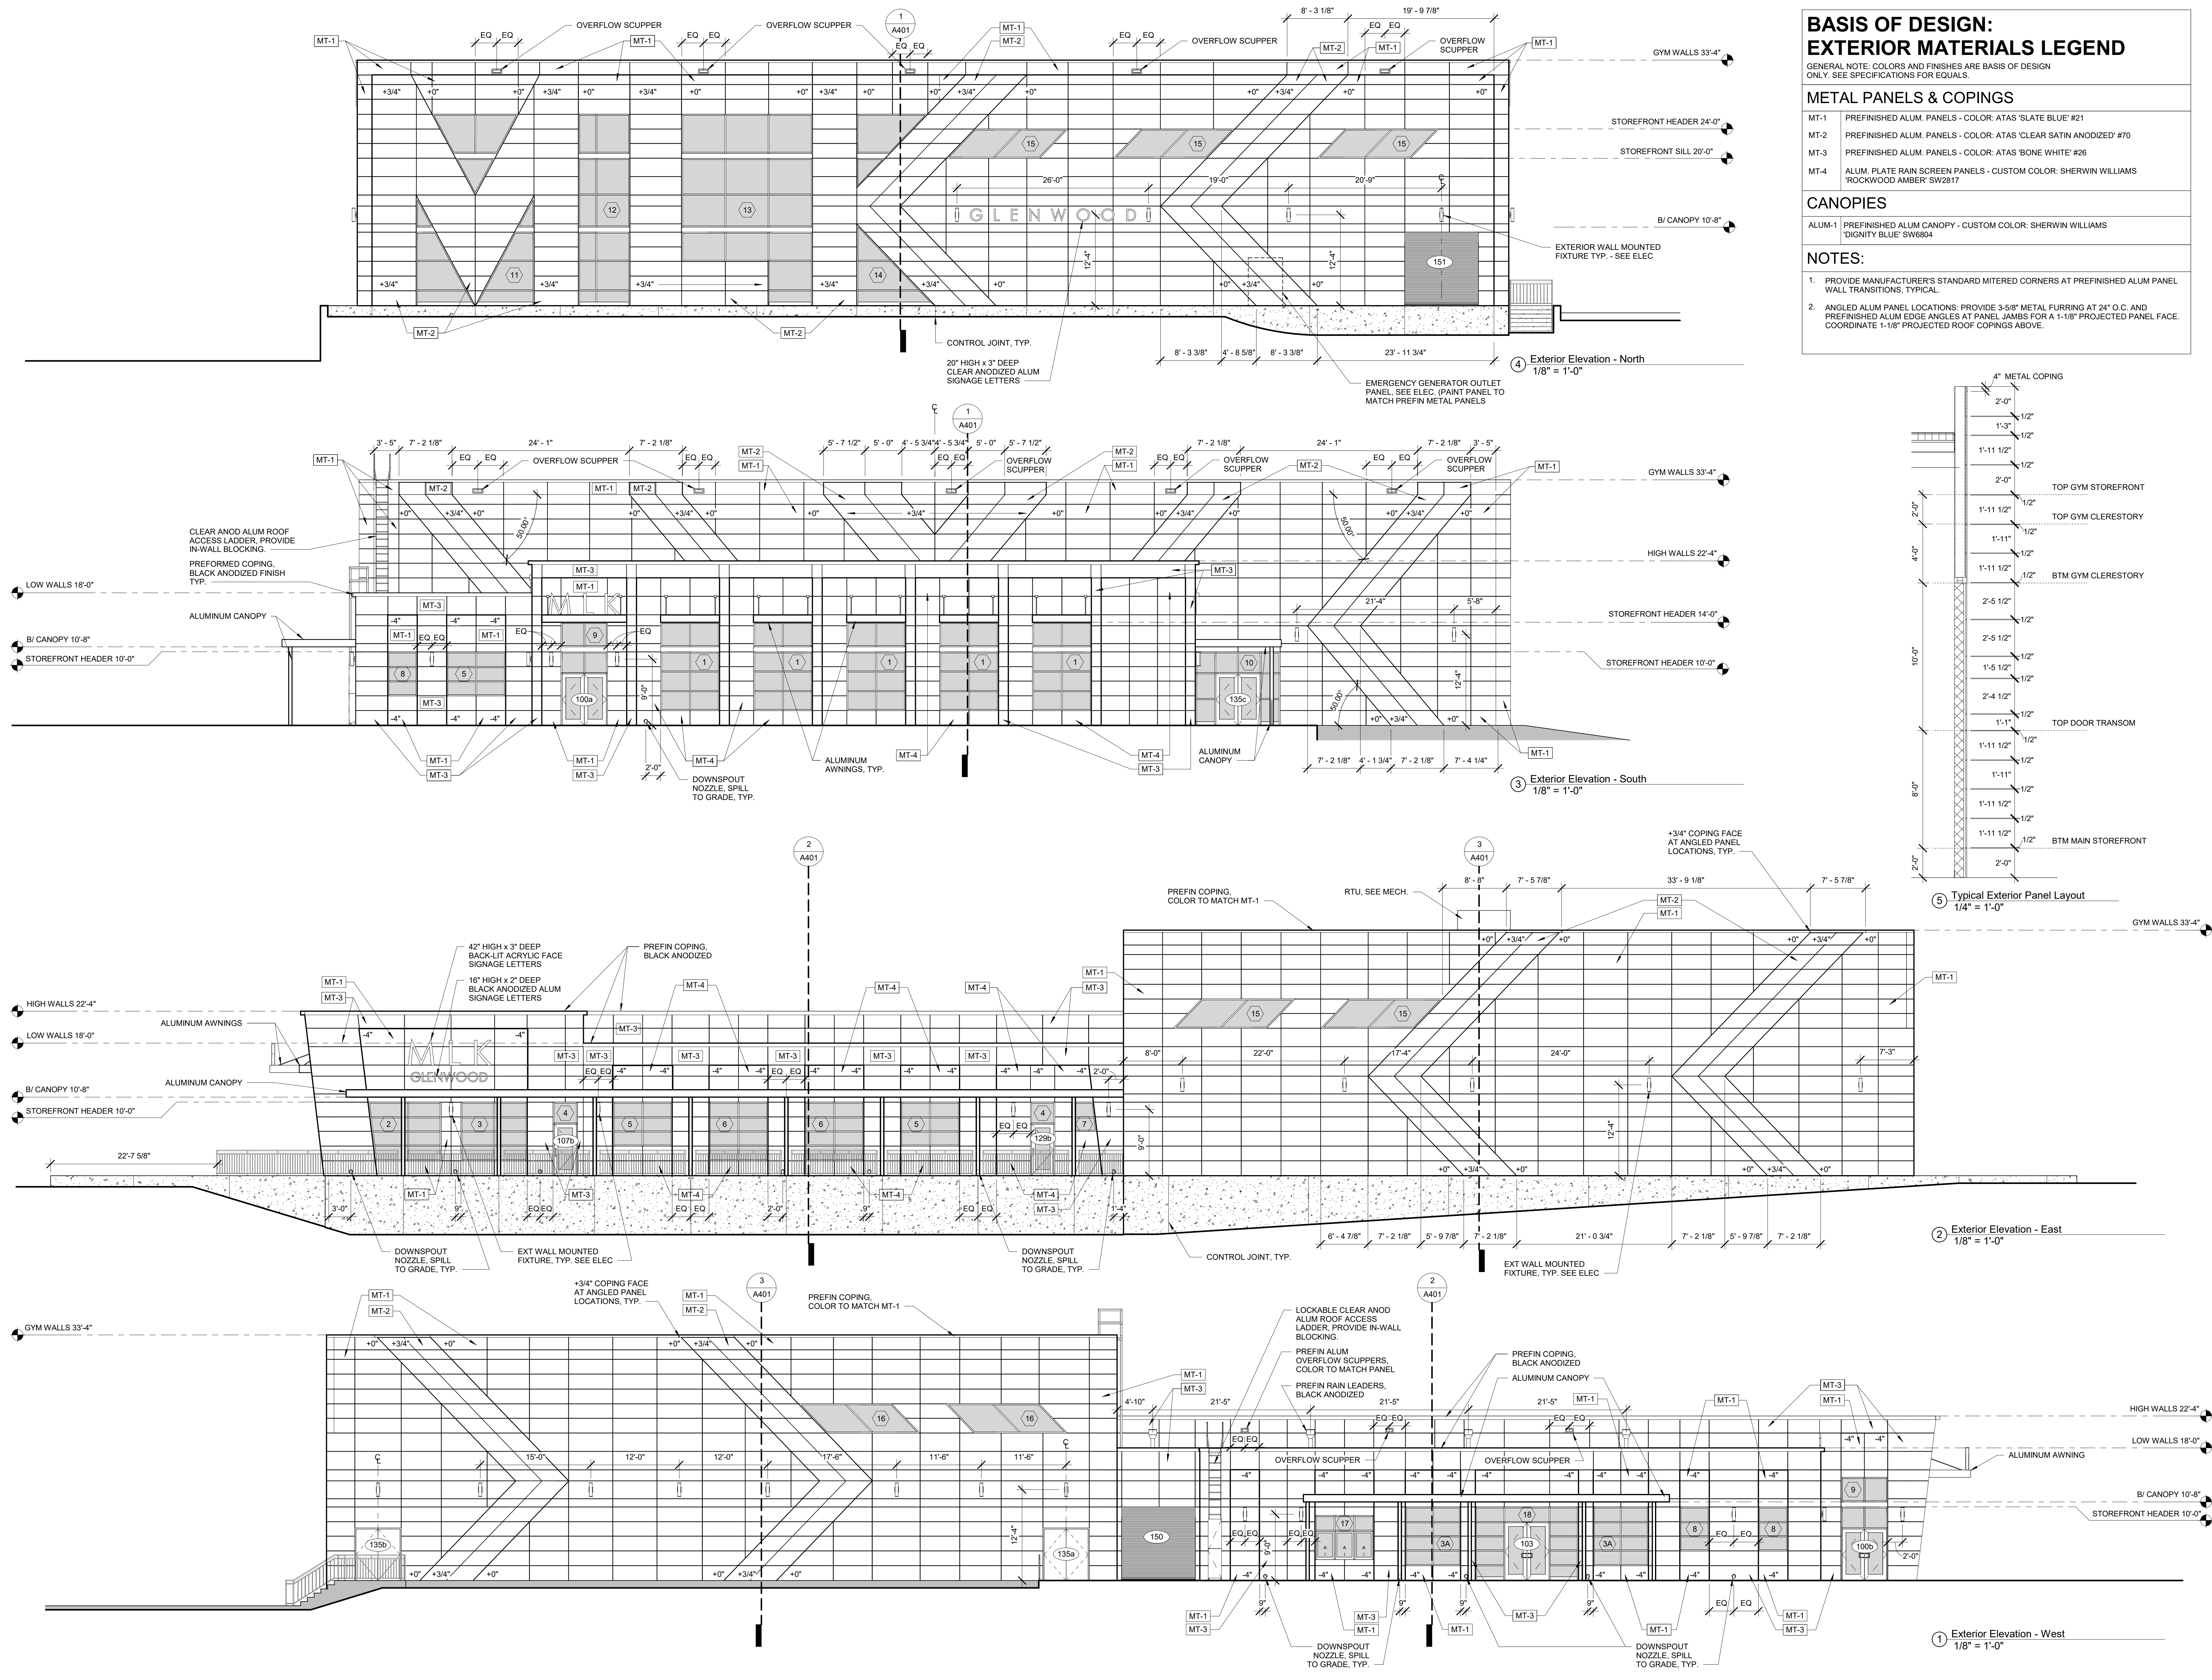

BASIS OF DESIGN: EXTERIOR MATERIALS LEGEND

GENERAL NOTE: COLORS AND FINISHES ARE BASIS OF DESIGN
ONLY. SEE SPECIFICATIONS FOR EQUALS.

METAL PANELS & COPINGS


MT-1	PREFINISHED ALUM. PANELS - COLOR: ATAS 'SLATE BLUE' #21
MT-2	PREFINISHED ALUM. PANELS - COLOR: ATAS 'CLEAR SATIN ANODIZED' #70
MT-3	PREFINISHED ALUM. PANELS - COLOR: ATAS 'BONE WHITE' #26
MT-4	ALUM. PLATE RAIN SCREEN PANELS - CUSTOM COLOR: SHERWIN WILLIAMS 'ROCKWOOD AMBER' SW2817

CANOPIES

ALUM-1	PREFINISHED ALUM CANOPY - CUSTOM COLOR: SHERWIN WILLIAMS 'DIGNITY BLUE' SW6804
--------	--

NOTES:

- PROVIDE MANUFACTURER'S STANDARD MITERED CORNERS AT PREFINISHED ALUM PANEL WALL TRANSITIONS, TYPICAL.
- ANGLED ALUM PANEL LOCATIONS: PROVIDE 3-5/8" METAL FURRING AT 24" O.C. AND PREFINISHED ALUM EDGE ANGLES AT PANEL JAMBS FOR A 1-1/8" PROJECTED PANEL FACE. COORDINATE 1-1/8" PROJECTED ROOF COPINGS ABOVE.

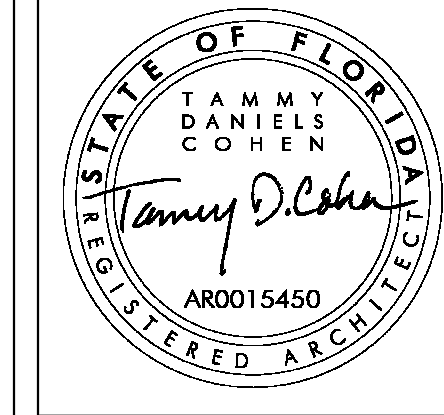

CCR ARCHITECTURE & INTERIORS

MARTIN LUTHER KING JR. RECREATION CENTER
705 14TH COURT EAST
PANAMA CITY, FL 32401

JOB NUMBER:
21109


DATE:
05/18/2023

PRINTED / REVISIONS
DESCRIPTION DATE

SHEET TITLE:
EXTERIOR ELEVATIONS

SHEET NUMBER:

A301

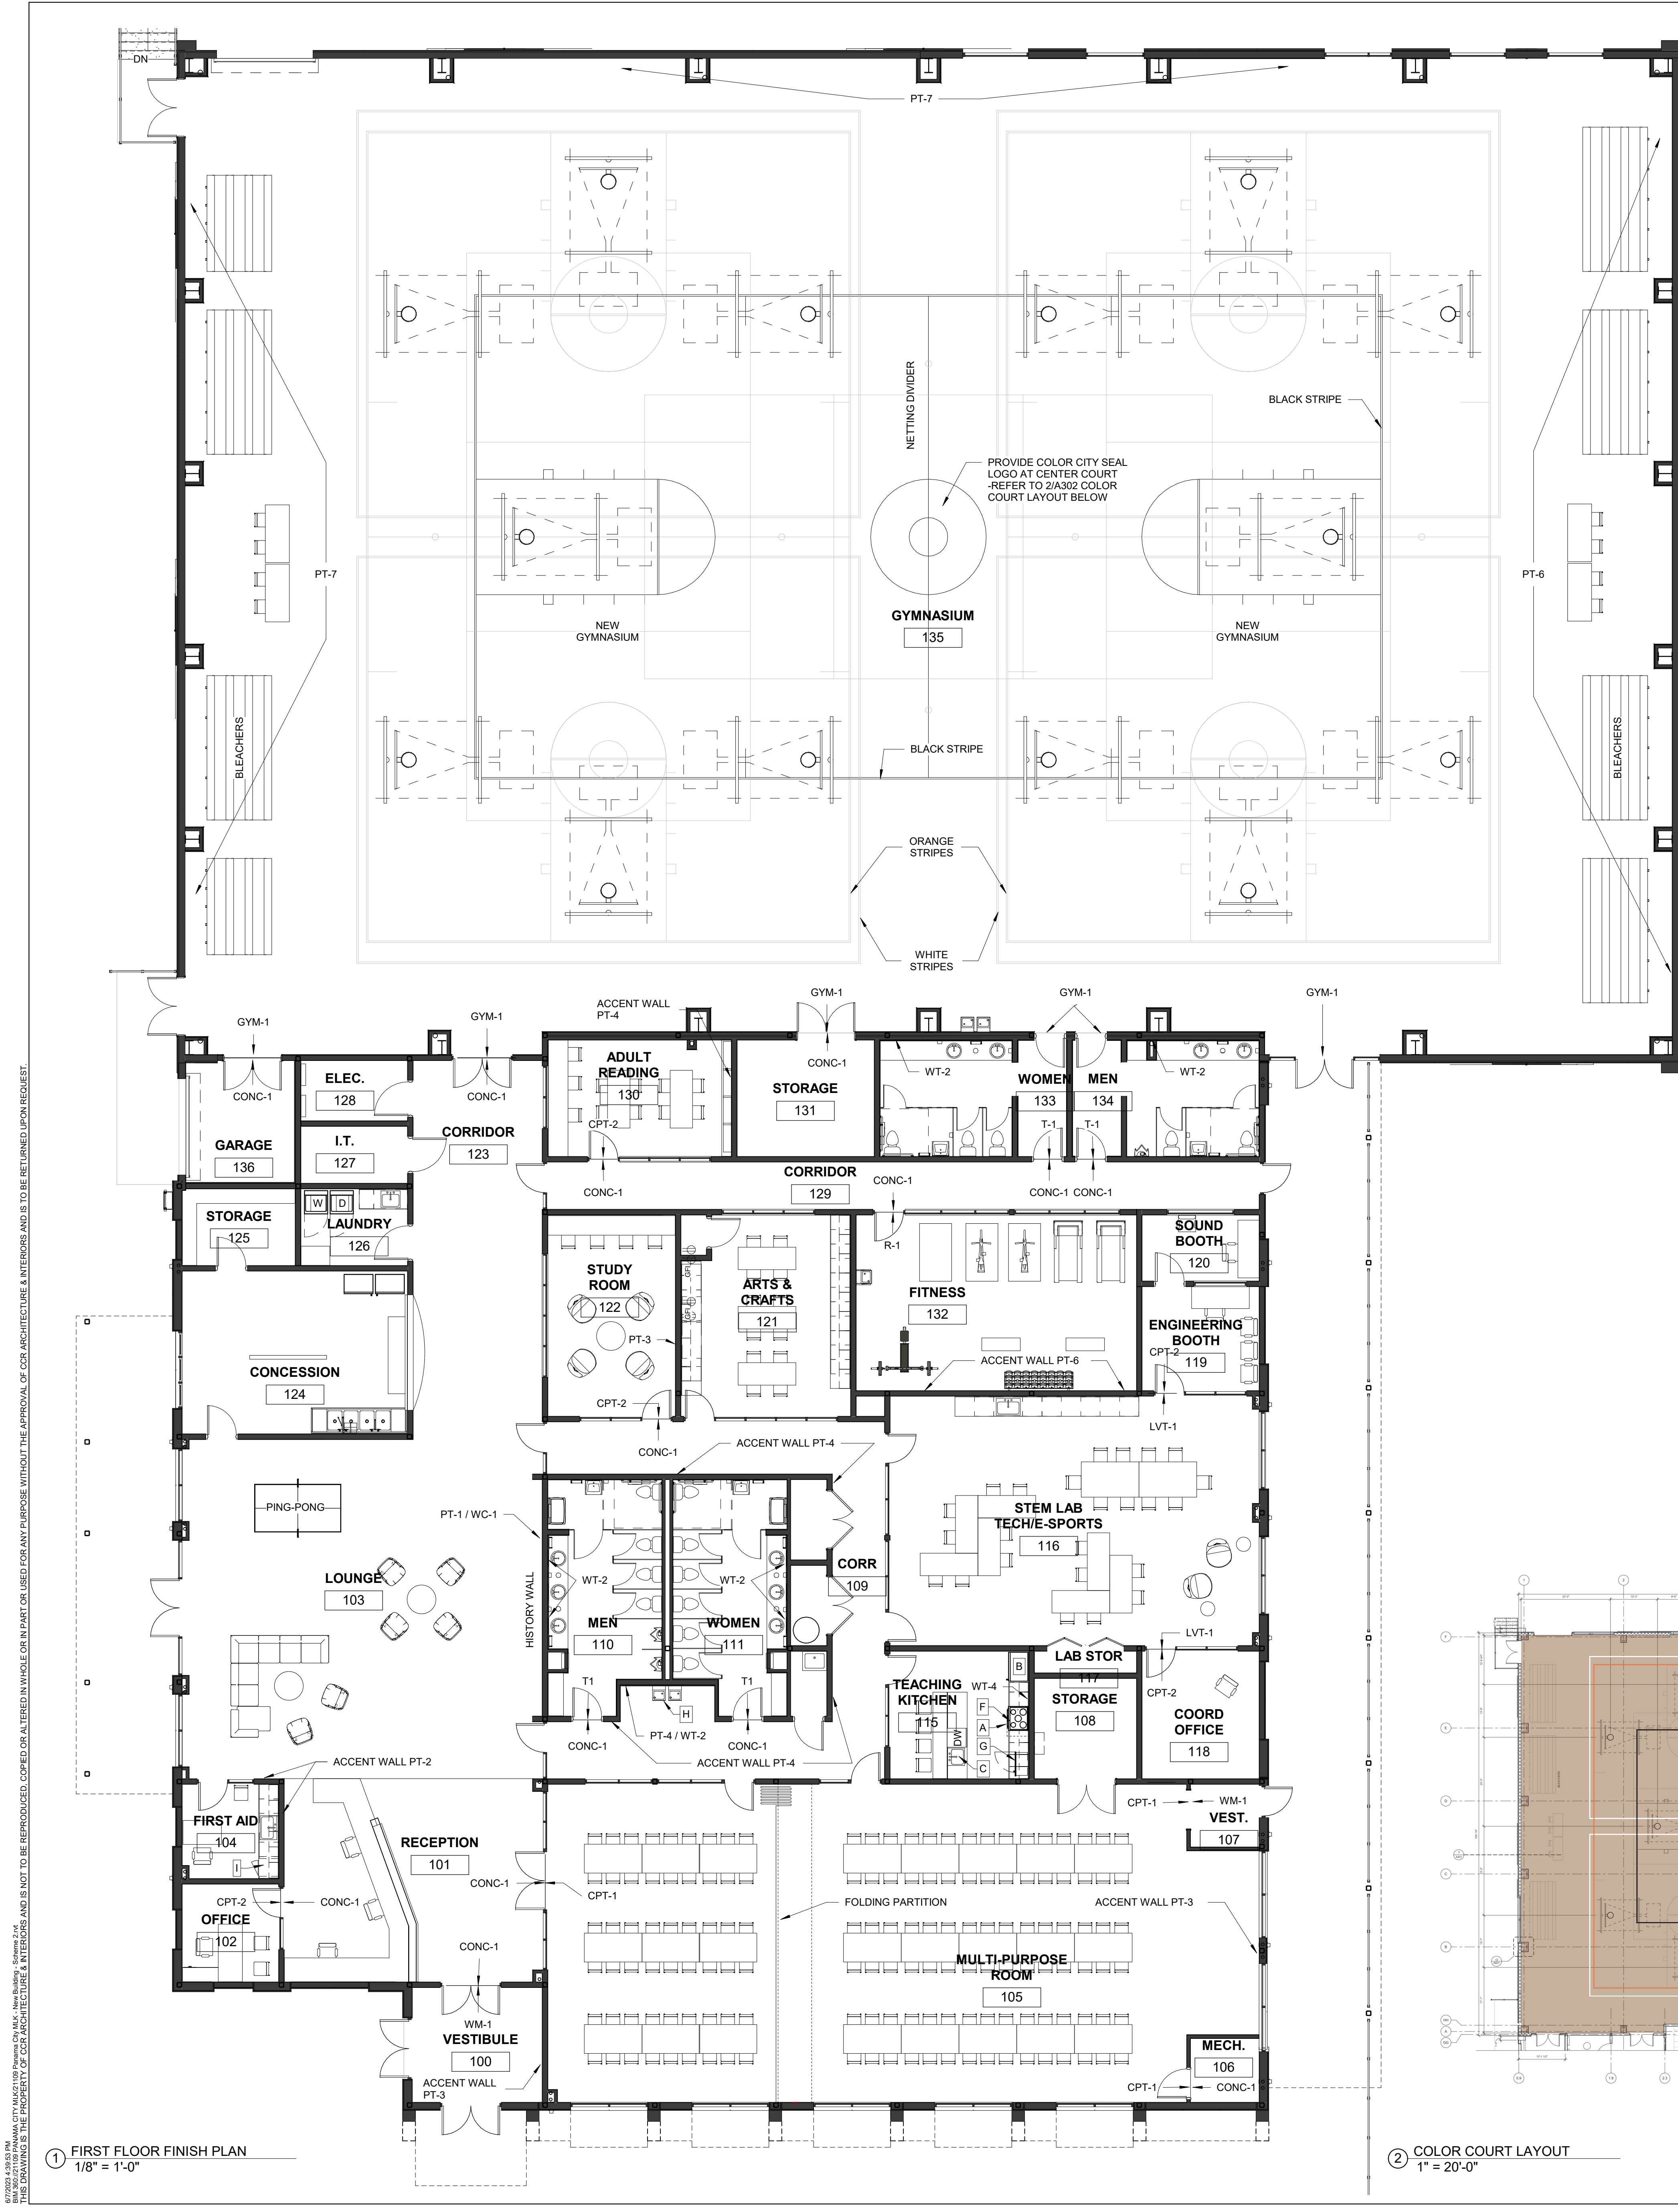

ROOM FINISH SCHEDULE									
#	ROOM NAME	FLOOR	BASE	NORTH	EAST	SOUTH	WEST	CEILING	COMMENTS
100	VESTIBULE	WM-1	RB-1	PT-1	PT-3	PT-1	PT-1	ACT-1	
101	RECEPTION	CONC-1	RB-1	PT-1	PT-1	PT-1	PT-2	ACT-1	
102	OFFICE	CPT-2	RB-1	PT-1	PT-1	PT-1	PT-1	ACT-1	
103	LOUNGE	CONC-1	RB-1	PT-1	PT-1/WC-1	PT-1/2	PT-1	ACT-1	CUSTOM WALLCOVERING ON "HISTORY WALL"
104	FIRST AID	CONC-1	RB-1	PT-1	PT-1	PT-1	PT-1	ACT-1	
105	MULTI-PURPOSE ROOM	CPT-1	RB-1	PT-1	PT-1/3	PT-1	PT-1	ACT-1/GB-1	
106	MECH.	CONC-1	RB-1	PT-1	PT-1	PT-1	PT-1	ACT-1	
107	VEST.	WM-1	RB-1	PT-1	PT-1	PT-1	PT-1	ACT-1	
108	STORAGE	CPT-1	RB-1	PT-1	PT-1	PT-1	PT-1	ACT-1	
109	CORR	CONC-1	RB-1	PT-1	PT-1	PT-1	PT-4	ACT-1	WT-1 BEHIND DRINKING FOUNTAINS FULL HEIGHT / PT-4 AS NEEDED ON FINISH PLAN
110	MEN	T-1	TB-1	WT-1/PT-1	WT-1/PT-1	WT-1/PT-1	WT-2/PT-1	ACT-1/GB-1	5'-0" WT-1 WAINSCOT W/PT-1 ABOVE, WT-2 FULL HEIGHT AT SINK, SEE INTERIOR ELEVATIONS FOR TILE PATTERN AND LOCATIONS
111	WOMEN	T-1	TB-1	WT-1/PT-1	WT-2/PT-1	WT-1/PT-1	WT-1/PT-1	ACT-1/GB-1	5'-0" WT-1 WAINSCOT W/PT-1 ABOVE, WT-2 FULL HEIGHT AT SINK, SEE INTERIOR ELEVATIONS FOR TILE PATTERN AND LOCATIONS
112	JAN.	CONC-1	RB-1	PT-1	PT-1	PT-1	PT-1	ACT-1	
113	MECH.	CONC-1	RB-1	PT-1	PT-1	PT-1	PT-1	EXP	
114	STOR.	CONC-1	RB-1	PT-1	PT-1	PT-1	PT-1	EXP	
115	TEACHING KITCHEN	CONC-1	RB-1	PT-1	PT-1/WT-4	PT-1	PT-1	ACT-1	
116	STEM LAB TECH/E-SPORTS	LVT-1	RB-1	PT-1	PT-1	PT-1	PT-1	ACT-2	
117	LAB STOR	LVT-1	RB-1	PT-1	PT-1	PT-1	PT-1	ACT-1	
118	COORD OFFICE	CPT-1	RB-1	F-1	F-1	F-1	F-1	ACT-1	
119	ENGINEERING BOOTH	CPT-2	RB-1	F-1/F-2	F-1/F-2	F-1/F-2	F-1/F-2	ACT-1	5'-0" F-2 WAINSCOT W/F-1 ABOVE
120	SOUND BOOTH	CPT-2	RB-1	F-1/F-2	F-1/F-2	F-1/F-2	F-1/F-2	ACT-1	5'-0" F-2 WAINSCOT W/F-1 ABOVE
121	ARTS & CRAFTS	CONC-1	RB-1	PT-1	PT-1	PT-1	PT-1	ACT-1	
122	STUDY ROOM	CPT-2	RB-1	PT-1	PT-3	PT-1	PT-1	ACT-1/GB-1	
123	CORRIDOR	CONC-1	RB-1	PT-1	PT-1	PT-1	PT-1	ACT-1	
124	CONCESSION	CONC-1	RB-1	PT-1	PT-1	PT-1	PT-1	ACT-1	
125	STORAGE	CONC-1	RB-1	PT-1	PT-1	PT-1	PT-1	ACT-1	
126	LAUNDRY	CONC-1	RB-1	PT-1	PT-1	PT-1	PT-1	ACT-1	
127	I.T.	CONC-1	RB-1	PT-1	PT-1	PT-1	PT-1	ACT-1	
129	CORRIDOR	CONC-1	RB-1	PT-1	PT-1	PT-1	PT-1	ACT-1	
130	ADULT READING	CPT-2	RB-1	PT-1	PT-4	PT-1	PT-1	ACT-1/GB-1	
131	STORAGE	CONC-1	RB-1	PT-1	PT-1	PT-1	PT-1	ACT-1	
132	FITNESS	R-1	RB-1	PT-1	PT-1	PT-6	PT-1	EXP	
133	WOMEN	T-1	TB-1	WT-2	WT-1/PT-1	WT-1	WT-1/PT-1	GB-1	5'-0" WT-1 WAINSCOT W/PT-1 ABOVE, WT-2 FULL HEIGHT AT SINK, SEE INTERIOR ELEVATIONS FOR TILE PATTERN AND LOCATIONS
134	MEN	T-1	TB-1	WT-2	WT-1/PT-1	WT-1	WT-1/PT-1	GB-1	5'-0" WT-1 WAINSCOT W/PT-1 ABOVE, WT-2 FULL HEIGHT AT SINK, SEE INTERIOR ELEVATIONS FOR TILE PATTERN AND LOCATIONS
135	GYMNASIUM	GYM-1	RB-1	PT-7	PT-6	PT-7	PT-7	EXP	
136	GARAGE	CONC-1	RB-1	PT-1	PT-1	PT-1	PT-1	EXP	
137	EXTERIOR								

BASIS OF DESIGN: APPLIANCE LEGEND



GENERAL NOTE: APPLIANCE MODELS ARE BASIS OF DESIGN ONLY. SEE SPECIFICATIONS FOR EQUALS.

#	ITEM	MODEL NUMBER
A	HOOD	BROAN® 40000 SERIES UNDER-CABINET RANGE HOOD STAINLESS STEEL MODEL: 403004
B	REFRIGERATOR	GE® ENERGY STAR® 27.7 CU. FT. FINGERPRINT RESISTANT FRENCH DOOR REFRIGERATOR MODEL: GFE28GYNFS
C	DISHWASHER	GE PROFILE 18" ADA COMPLIANT DISHWASHER W/STAINLESS STEEL INTERIOR, 32 1/2 H x 17 3/4 W x 22 1/2 D MODEL: PDT145SLSS
W	WASHER	GE PROFILE 5.0 CU FT CAPACITY WASHER MODEL: PTW600BSRWS
D	DRYER	GE PROFILE 7.4 CU. FT. CAPACITY DRYER MODEL: PTD60EBSRWS
F	COOKTOP	GE PROFILE 36" BUILT IN TOUCH CONTROL INDUCTION COOKTOP MODEL: PHP9036DJB
G	MICROWAVE	GE PROFILE 2.2 CU. FT. COUNTERTOP MICROWAVE OVEN MODEL: PES7227SLSS
H	DRINKING FOUNTAIN	ELKAY HIGH EFFICIENCY BI LEVEL WATER COOLER MODEL: LZSTLG8WSK WITH EZH2O BOTTLE FILLING STATION (FILTERED)
I	UNDERCOUNTER REFRIGERATOR	GE COMPACT REFRIGERATOR ADA-COMPLIANT, UNDERCOUNTER INSTALLATION 34 1/8 H x 23 5/8 W x 23 3/4 D MODEL: GCE06GSHSB

BASIS OF DESIGN: FINISH LEGEND

GENERAL NOTE: COLORS AND FINISHES ARE BASIS OF DESIGN ONLY. SEE SPECIFICATIONS FOR EQUALS.

FLOOR	
CONC-1	POLISHED CONCRETE FLOOR
CPT-1	SHAW, NOBLE MATERIALS, ALCHEMY TILE 5T135, COLOSSAL BISMUT 33496
CPT-2	SHAW, NOBLE MATERIALS, ALCHEMY TILE 5T135, ONYX SILVER 33505
WM-3	CARPET TILE, WALK OFF CARPET TILE, MILLIKEN, OBEX, TILE EUROPE, TDC154 GREY
T-1	PORCELAIN TILE, DALTI, HAUT MONDE, GLITTERATTI GRANITE HM03, UNPOLISHED
R-1	RUBBER FLOORING (FITNESS) ROBBINS SPORTS SURFACES, GALAXY CLASSIC, BLUE GREY
GYM-1	GYMNASIUM FLOORING, TARKETT, TRAINING WE SHEET 3709001 BEECH WB, 129 SILK WB, SOLID WELD ROD 1291363 STRIPE COLORS: PULASTIC SPORTS FLOORING BLACK - CHAMPIONSHIP COURT RED ORANGE - JUNIOR COURTS WHITE - VOLLEYBALL
LVT-1	LUXURY VINYL TILE, INTERFACE, DRAWN LINES, COLOR: A00907 ONYX
BASE	
RB-1	6" RUBBER BASE, NO PREFORMED CORNERS, ROPPE, COLOR: P100 BLACK
TB-1	SCHLUTER, COVE SHAPED PROFILE, FLOOR-WALL TRANSITION, DILEX-AHK, SATIN ANODIZED
WALL	
PT-1	TYPICAL WALL PAINT, SHERWIN WILLIAMS, COLOR: (WHITE) SW 7009 PEARLY WHITE, EGGSHELL FINISH
PT-2	ACCENT WALL PAINT, SHERWIN WILLIAMS, COLOR: (RED) SW 6321 RED BAY, EGGSHELL FINISH
PT-3	ACCENT WALL PAINT, SHERWIN WILLIAMS, COLOR: (GOLD) SW 2817 ROOKWOOD AMBER, EGGSHELL FINISH
PT-4	ACCENT WALL PAINT, SHERWIN WILLIAMS, COLOR: (DARK BLUE) SW6244 NAVAL, EGGSHELL FINISH
PT-5	TRIM PAINT, SHERWIN WILLIAMS, COLOR: (BLACK) SW 6258 TRICORN BLACK, SEMI GLOSS FINISH
PT-6	GYM WALL (BLUE), SHERWIN WILLIAMS, COLOR: (LIGHT BLUE) SW6507 RESOLUTE BLUE, EGGSHELL FINISH
PT-7	GYM WALL, SHERWIN WILLIAMS, COLOR: (GREY) SW7663 MONORAIL SILVER, EGGSHELL FINISH
WT-1	PORCELAIN WALL TILE: (WHITE) GARDENSTATE TILE, OUTFIT BRICK, GLOSSY 3" X 12" BRIGHT WHITE
WT-2	PORCELAIN WALL TILE: (YELLOW CHEVRON) DALTI MOSAICS 1" X 3" HERRINGBONE COLOR: MUSTARD 1012 (3)
WT-3	PORCELAIN WALL TILE: (BLUE) GARDENSTATE TILE STORM 3" X 12" BRICK GLOSSY GSW167116
WT-4	PORCELAIN WALL TILE: (RED) GARDENSTATE TILE, OUTFIT, HEXAGON 6" X 7", SCARLET GSW167128
F-1	FELT WALLCOVERING: BUZZISPACE, BUZZISKIN, SK OFFWHITE 63
F-2	FELT WALLCOVERING: BUZZISPACE, BUZZISKIN, SK STONEGREY 67
WC-1	CUSTOM WALLCOVERING: TBD
ND-1	NETTING DIVIDER @GYM.DARK ROYAL BLUE VINYL W/GREY MESH ABOVE
CEILING	
GB-1	GYPSUM BOARD CEILING, PAINTED, (PNT-1 TYPICAL)
ACT-1	ACOUSTIC CEILING TILE, ARMSTRONG OPTIMA 24" X 24" 9/16" REGULAR TILE, SUPRAFINE XL 9/16" EXPOSED TEE GRID
ACT-2	ACOUSTIC CEILING TILE, ARMSTRONG TECHZONE 30" X 60" SQUARE REGULAR WITH 6" WIDE TECHNICAL PANELS
EXP	EXPOSED CEILING
MILLWORK	
PL-1	PLASTIC LAMINATE: COLOR: FORMICA 5794, BEIGE ELM, NATURAL GRAIN - NG
Q-1	QUARTZ COUNTER, 3CM, EASED EDGE, CAMBRIA, SANDGATE
Q-2	QUARTZ COUNTER, 3CM, EASED EDGE, CAMBRIA, BLACKBROOK
Q-3	QUARTZ COUNTER, 3CM, EASED EDGE, CORIAN QUARTZ, COLOR: DOVE GREY (3)

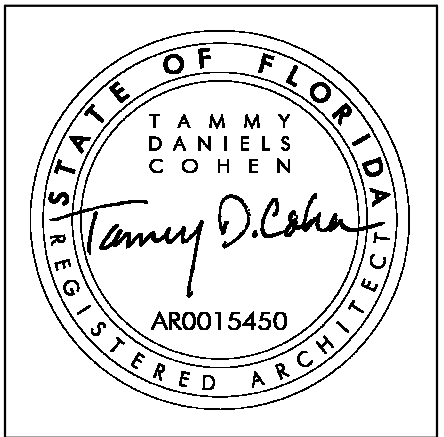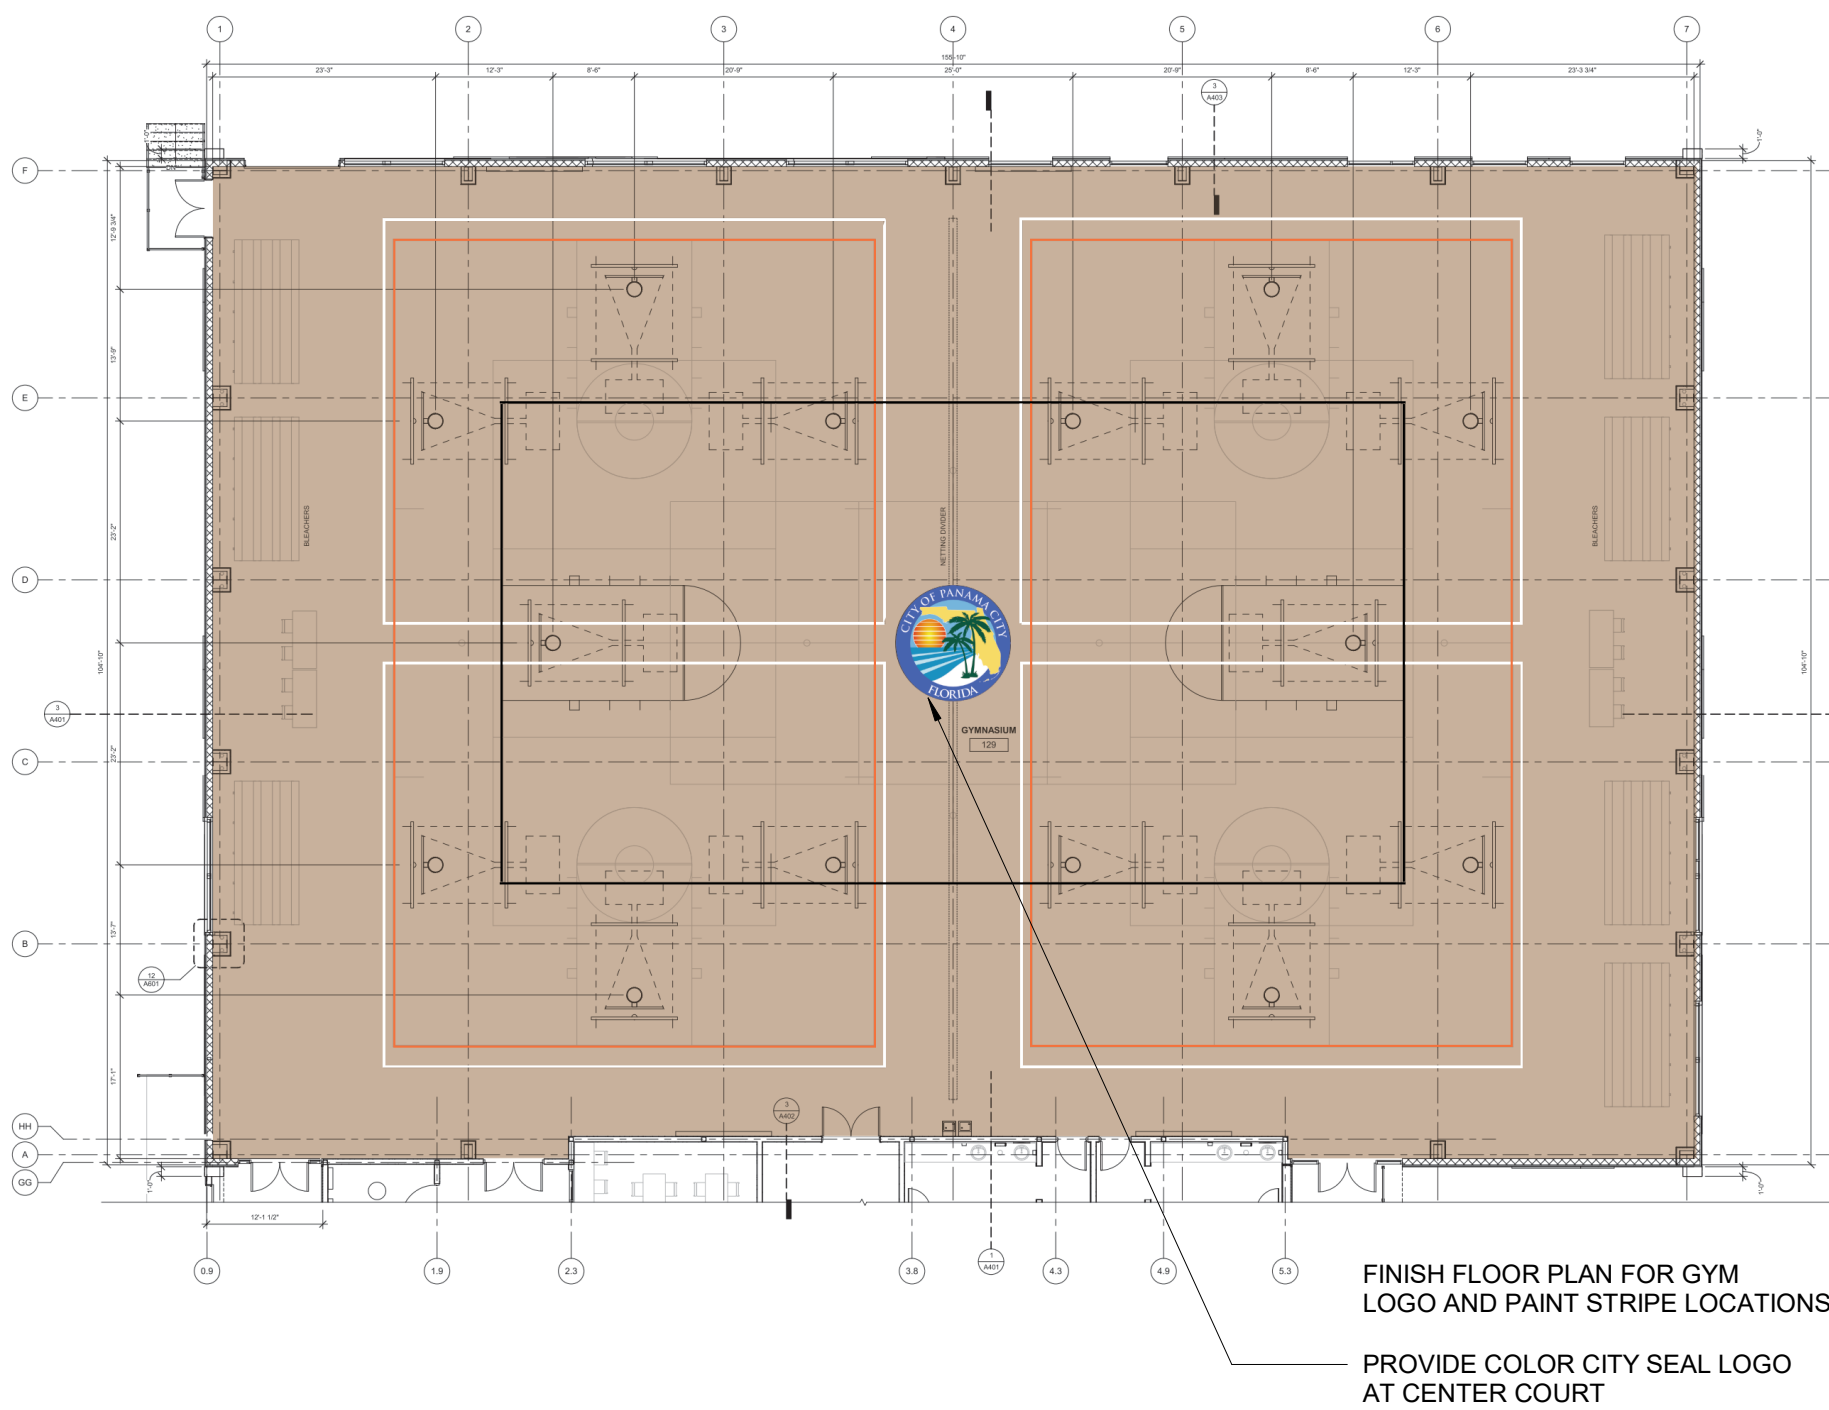

CCR ARCHITECTURE & INTERIORS

MARTIN LUTHER KING JR. RECREATION CENTER

705 14TH COURT EAST
PANAMA CITY, FL 32401

JOB NUMBER:
21109

DATE:
05/18/2023


PRINTED / REVISIONS
DESCRIPTION DATE

SHEET TITLE:
FINISH PLAN - LEVEL 1

SHEET NUMBER:

A302


05/18/2023 10:52 AM C:\PROJECTS\A303\MULTI-PURPOSE\A303-MULTI-PURPOSE-2.dwg - New Building - Scheme 2.dwg
THIS DRAWING IS THE PROPERTY OF CCR ARCHITECTURE & INTERIORS AND IS NOT TO BE REPRODUCED, COPIED OR ALTERED IN WHOLE OR IN PART OR USED FOR ANY PURPOSE WITHOUT THE APPROVAL OF CCR ARCHITECTURE & INTERIORS AND IS TO BE RETURNED UPON REQUEST.

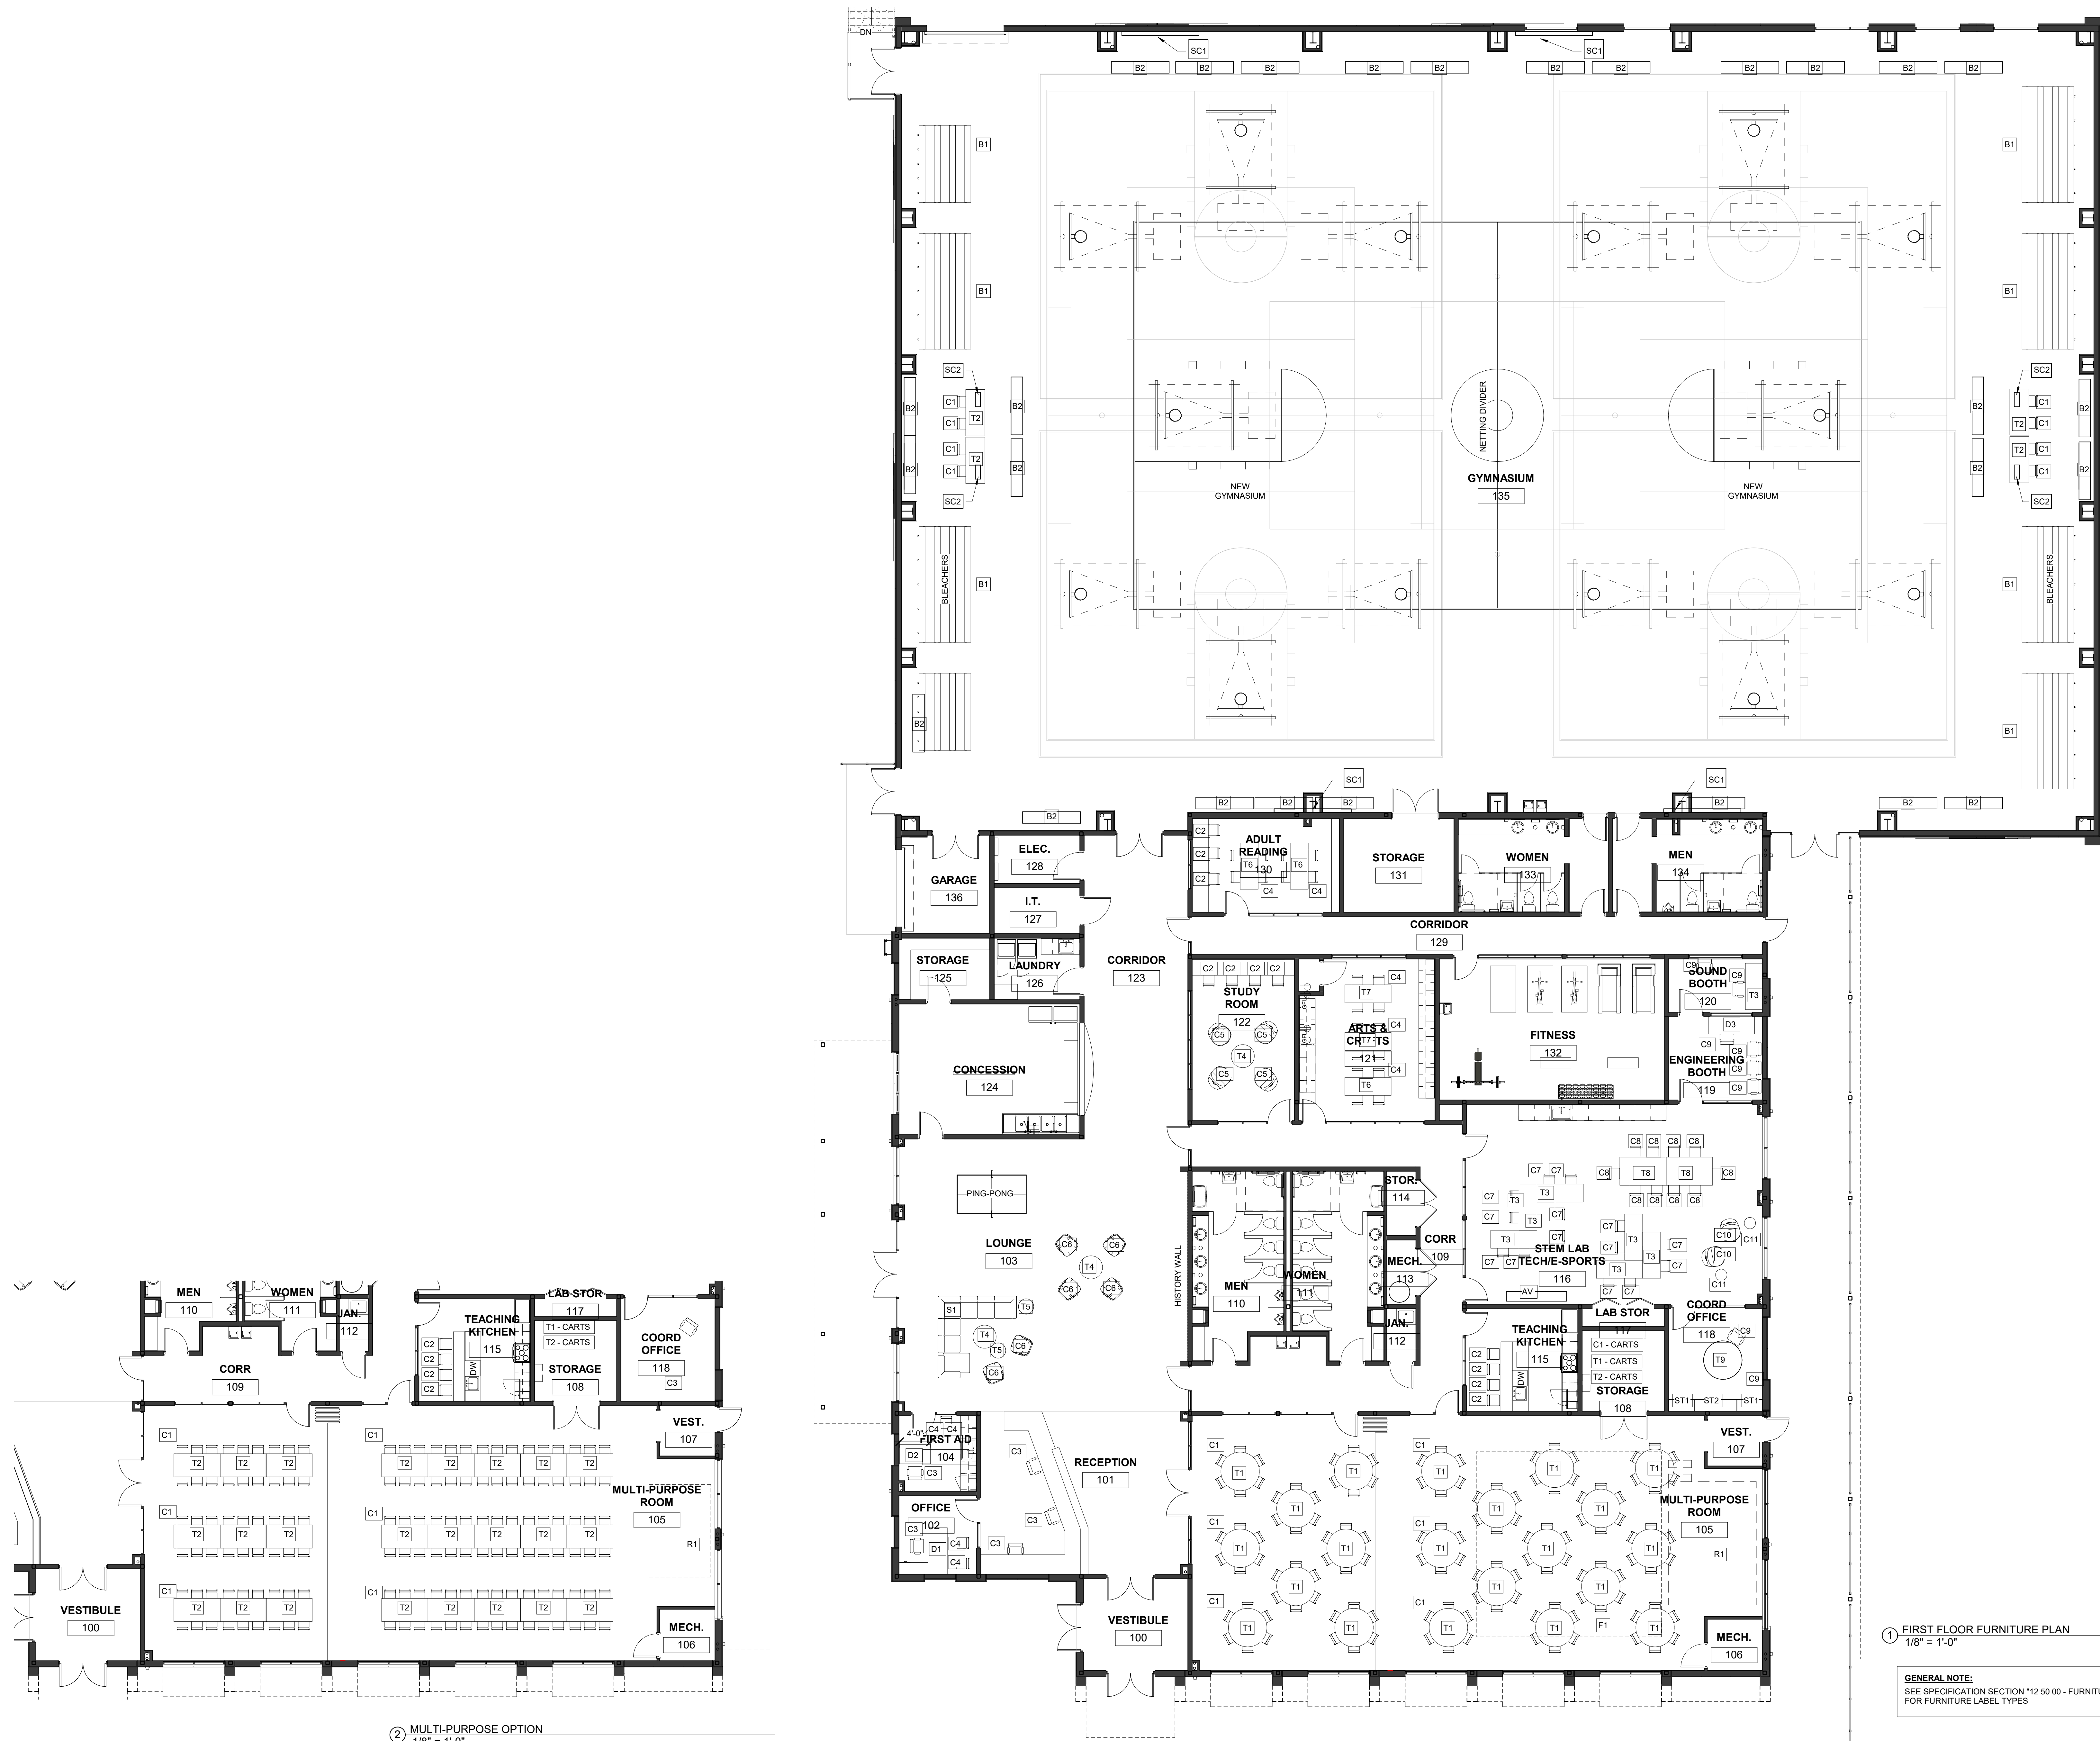

② MULTI-PURPOSE OPTION
1/8" = 1'-0"

① FIRST FLOOR FURNITURE PLAN
1/8" = 1'-0"

GENERAL NOTE:
SEE SPECIFICATION SECTION "12 50 00 - FURNITURE"
FOR FURNITURE LABEL TYPES

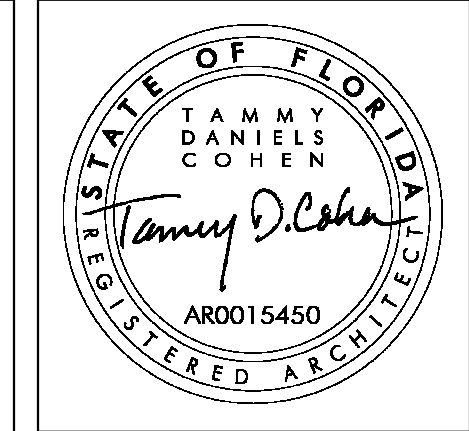

CCR ARCHITECTURE & INTERIORS

MARTIN LUTHER KING JR. RECREATION CENTER

705 14TH COURT EAST
PANAMA CITY, FL 32401

JOB NUMBER:
21109

DATE:
05/18/2023

PRINTED / REVISIONS
DESCRIPTION DATE

SHEET TITLE:
FURNITURE PLAN

SHEET NUMBER:

A303

MARTIN LUTHER KING JR. RECREATION CENTER
705 14TH COURT EAST
PANAMA CITY, FL 32401

JOB NUMBER:
21109




DATE:
05/18/2023

PRINTED / REVISIONS
DESCRIPTION DATE

SHEET TITLE:
BUILDING SECTIONS

SHEET NUMBER:

A401

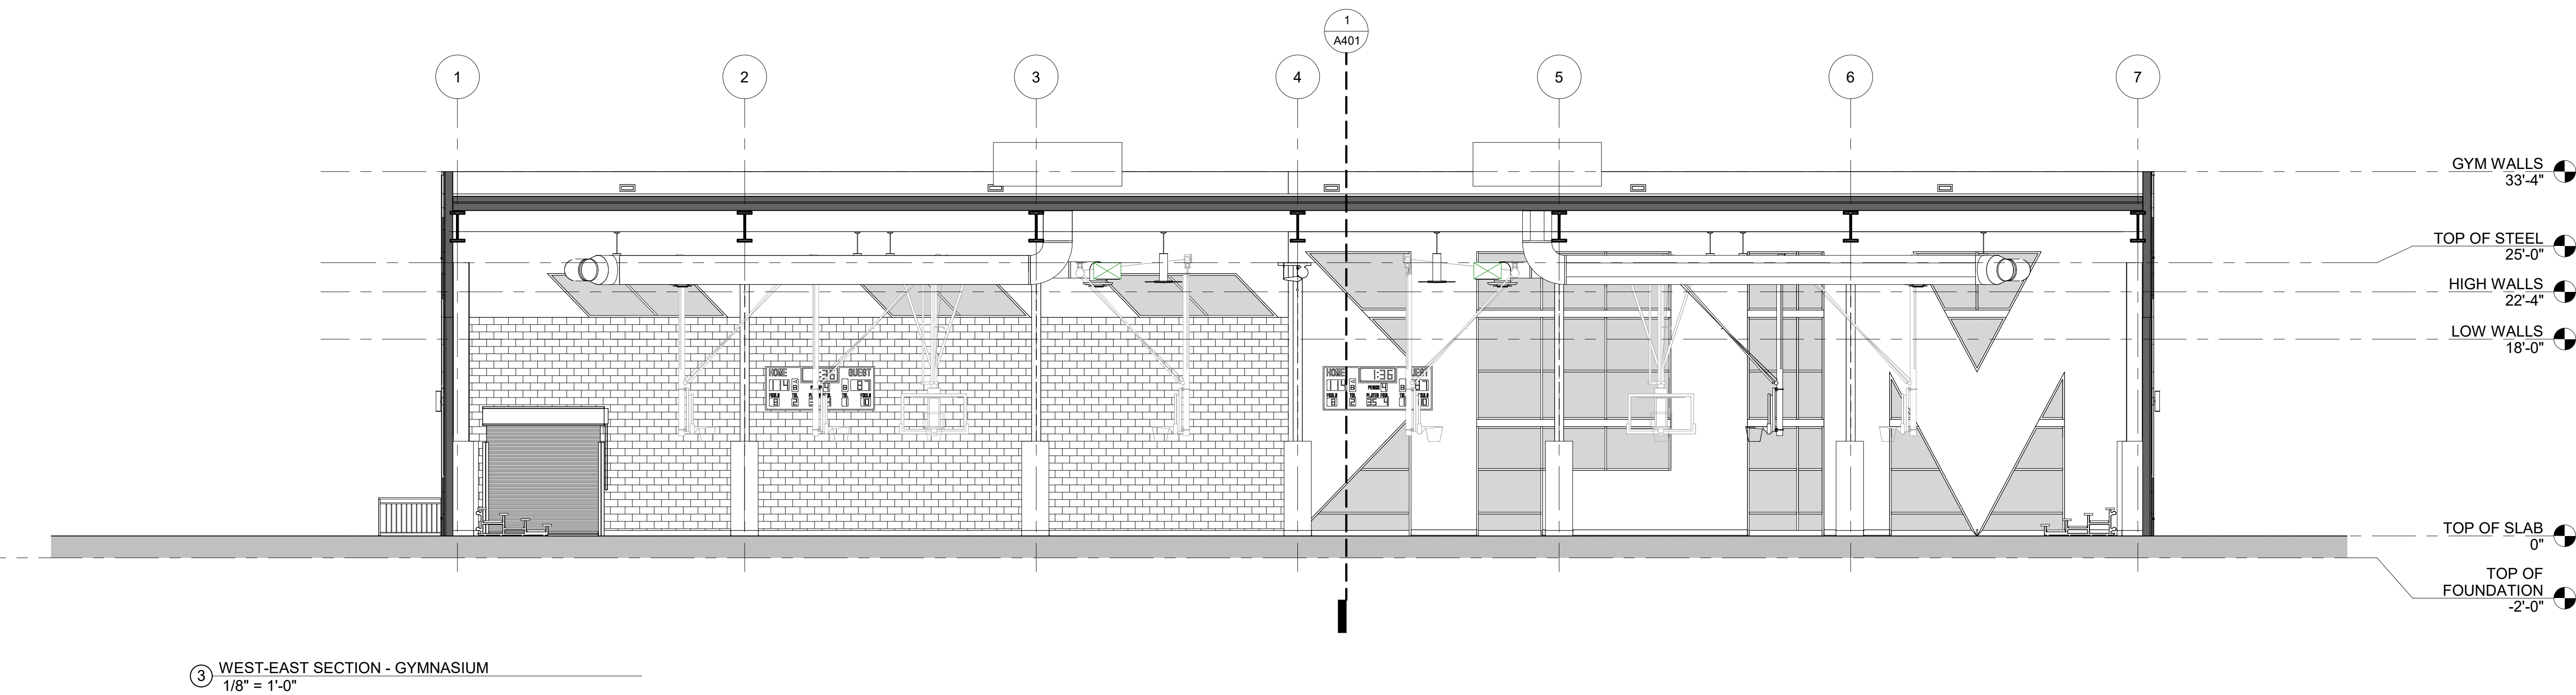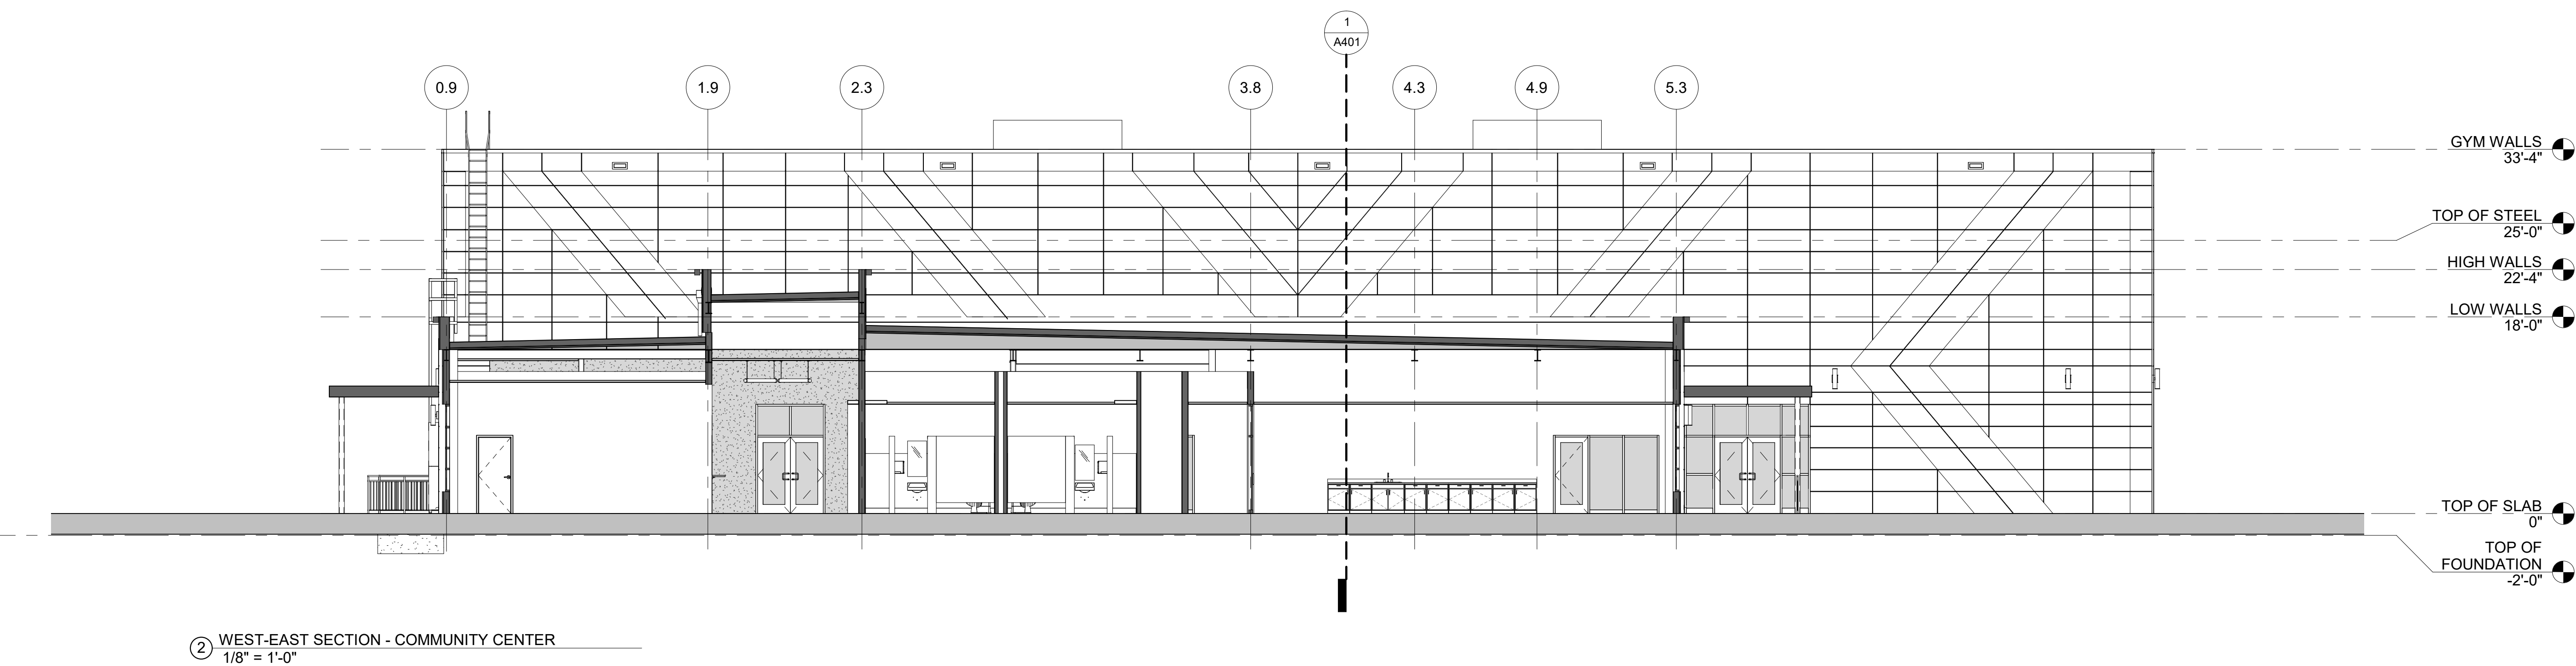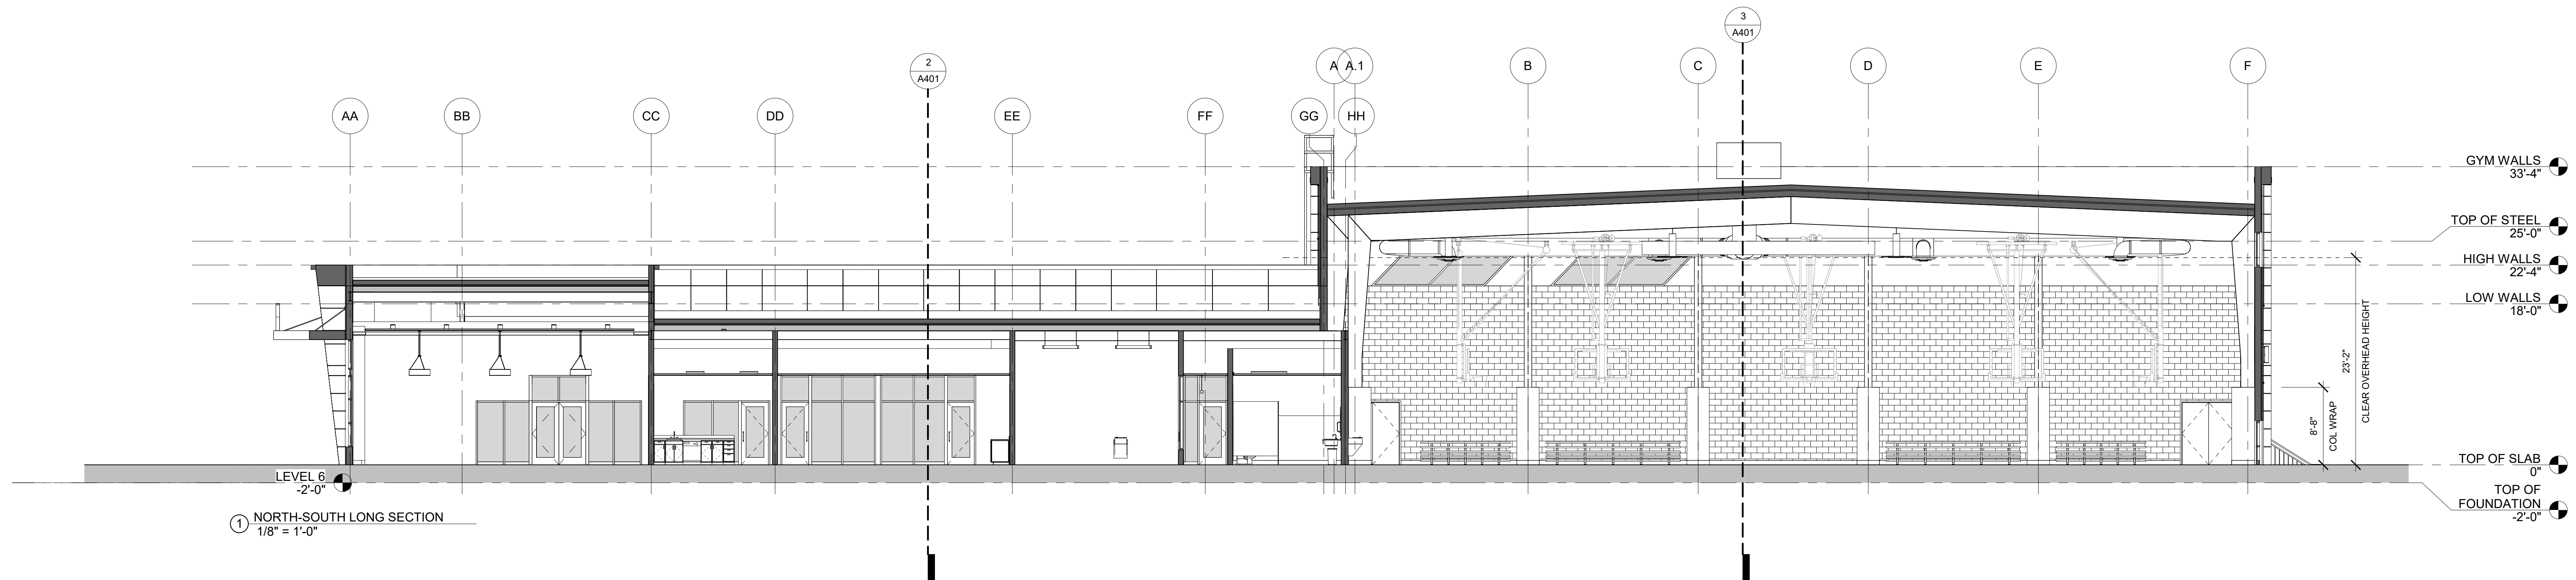

BASIS OF DESIGN:
EXTERIOR MATERIALS LEGEND

GENERAL NOTE: COLORS AND FINISHES ARE BASIS OF DESIGN
ONLY. SEE SPECIFICATIONS FOR EQUALS.

METAL PANELS & COPINGS

MT-1	PREFINISHED ALUM. PANELS - COLOR: ATAS 'SLATE BLUE' #21
MT-2	PREFINISHED ALUM. PANELS - COLOR: ATAS 'CLEAR SATIN ANODIZED' #70
MT-3	PREFINISHED ALUM. PANELS - COLOR: ATAS 'BONE WHITE' #26
MT-4	ALUM. PLATE RAIN SCREEN PANELS - CUSTOM COLOR: SHERWIN WILLIAMS 'ROCKWOOD AMBER' SW2817


CANOPIES

ALUM-1	PREFINISHED ALUM CANOPY - CUSTOM COLOR: SHERWIN WILLIAMS 'DIGNITY BLUE' SW6804
--------	--


NOTES:

- PROVIDE MANUFACTURER'S STANDARD MITERED CORNERS AT PREFINISHED ALUM PANEL WALL TRANSITIONS, TYPICAL.
- ANGLED ALUM PANEL LOCATIONS: PROVIDE 3-5/8" METAL FURRING AT 24" O.C. AND PREFINISHED ALUM EDGE ANGLES AT PANEL JAMBS FOR A 1-1/8" PROJECTED PANEL FACE. COORDINATE 1-1/8" PROJECTED ROOF COPINGS ABOVE.


THIS DRAWING IS THE PROPERTY OF CCR ARCHITECTURE & INTERIORS AND IS NOT TO BE REPRODUCED, COPIED OR ALTERED IN WHOLE OR IN PART OR USED FOR ANY PURPOSE WITHOUT THE APPROVAL OF CCR ARCHITECTURE & INTERIORS AND IS TO BE RETURNED UPON REQUEST.

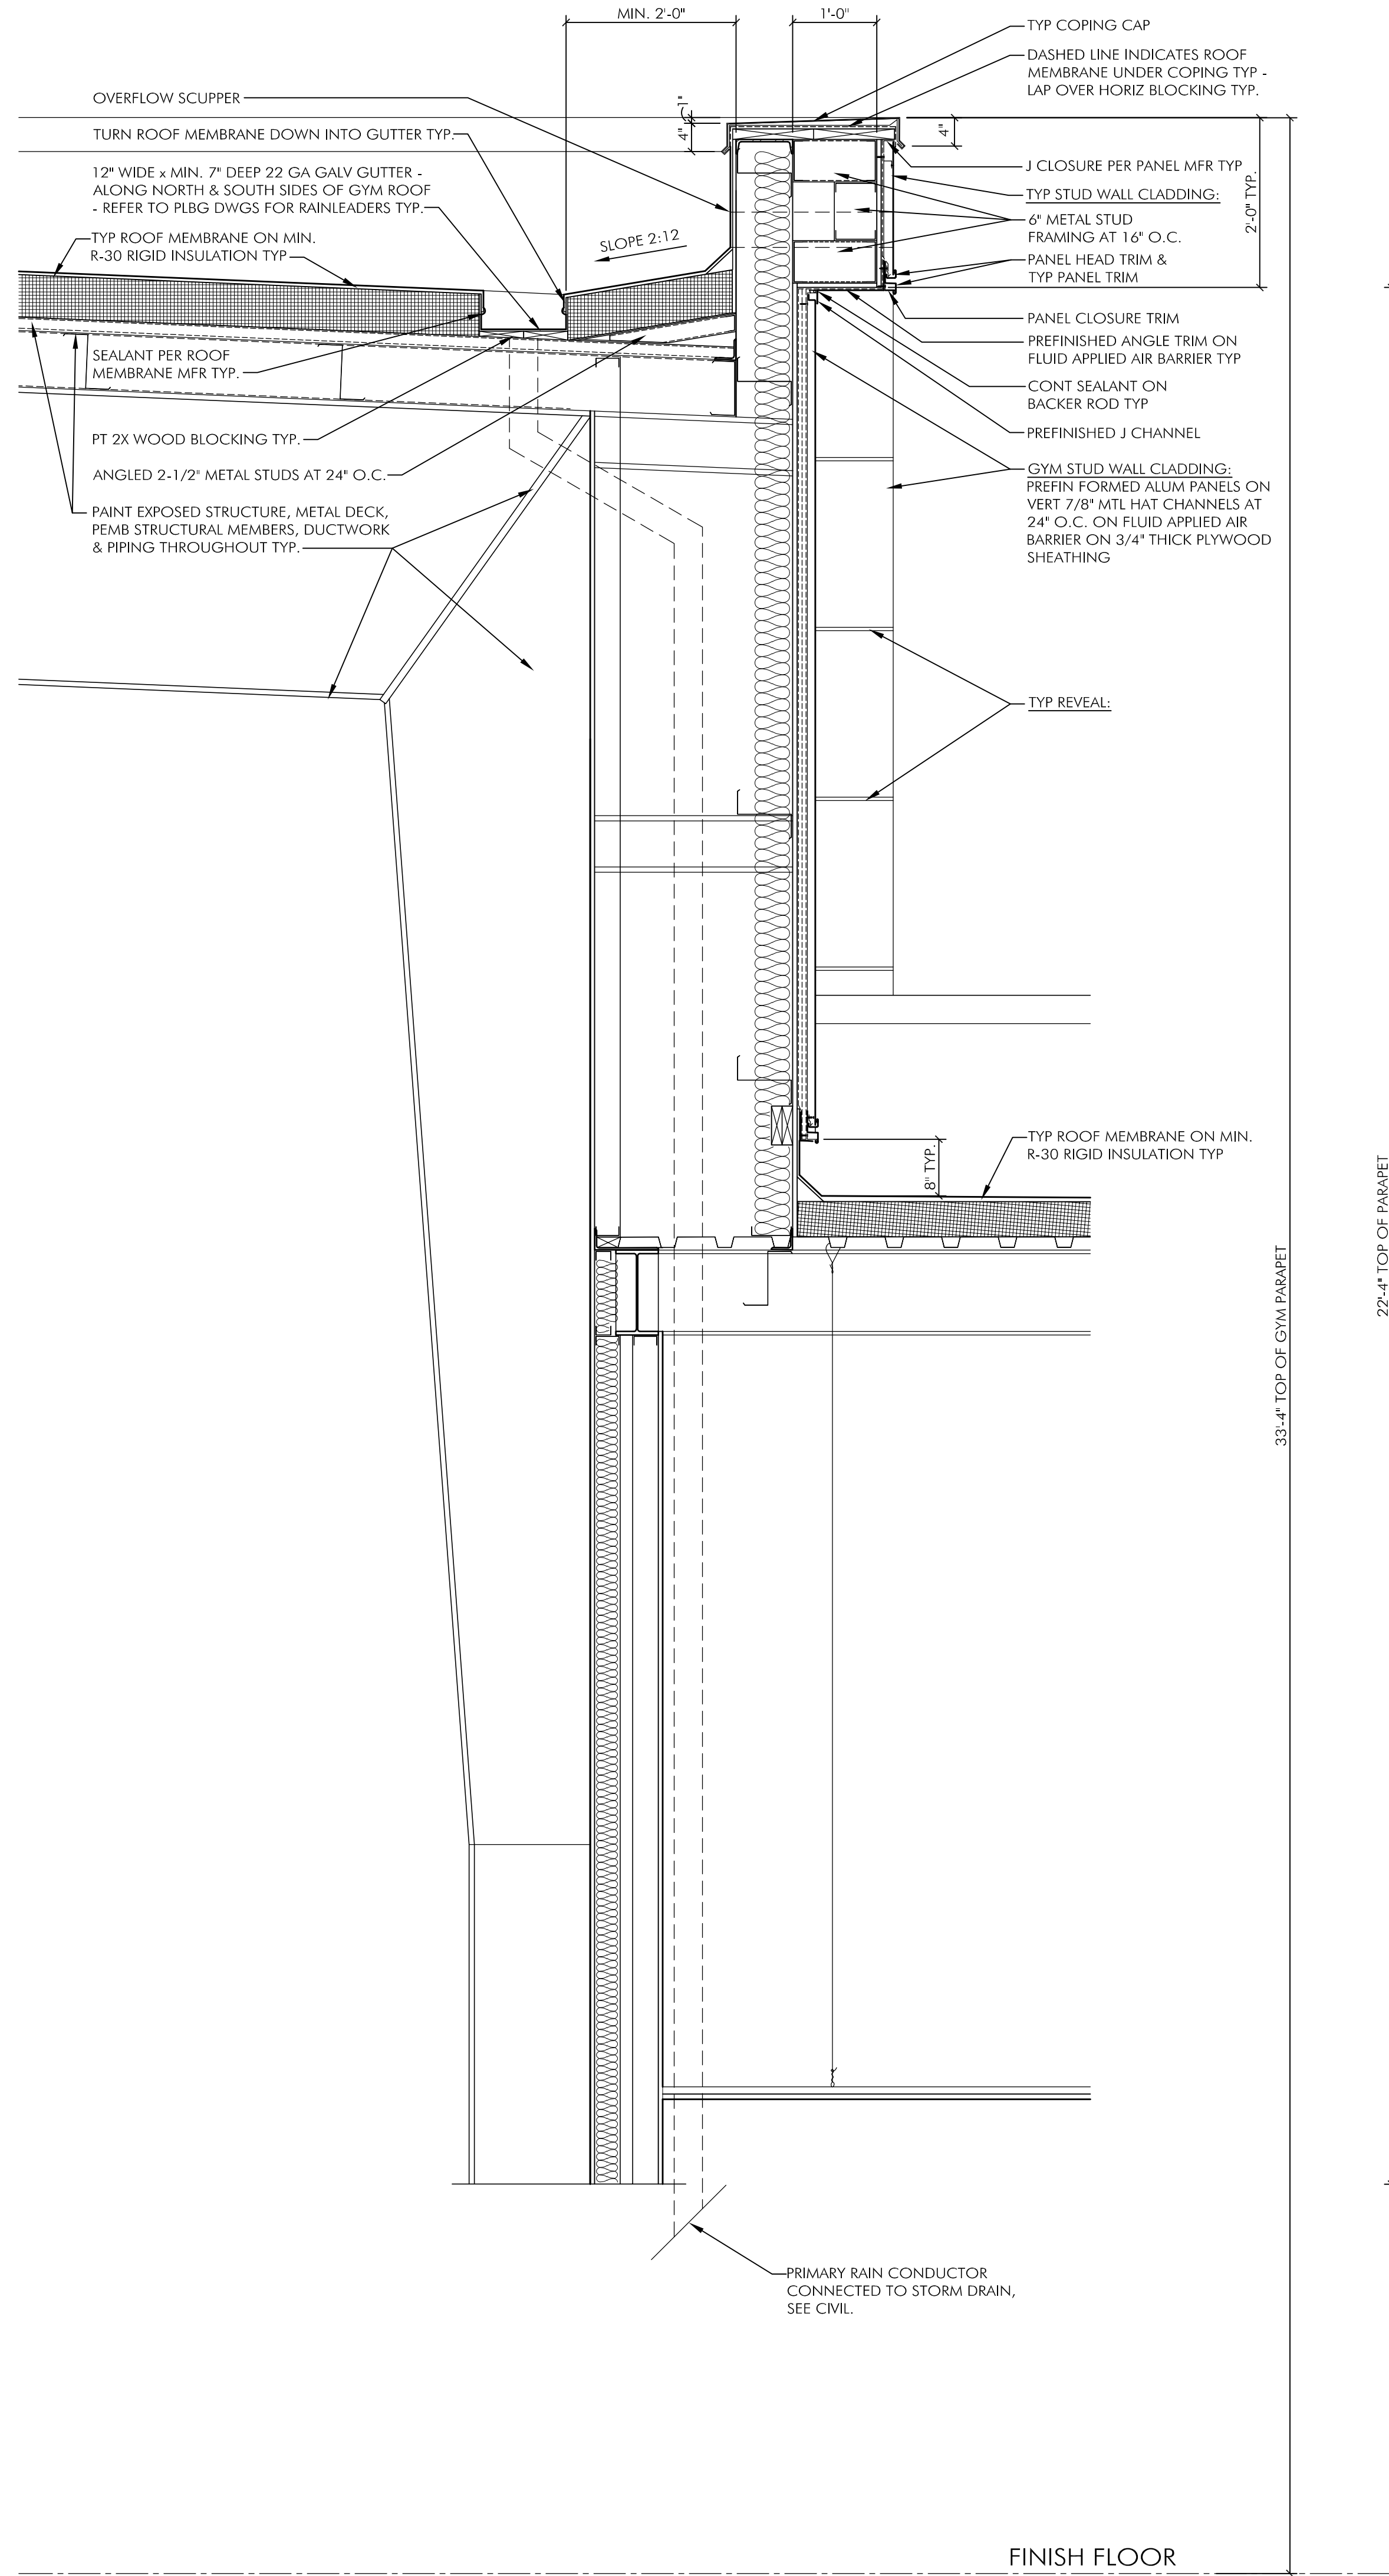


3 WALL SECTION AT HIGH/LOW ROOF TRANSITION
3/4\" = 1'-0"

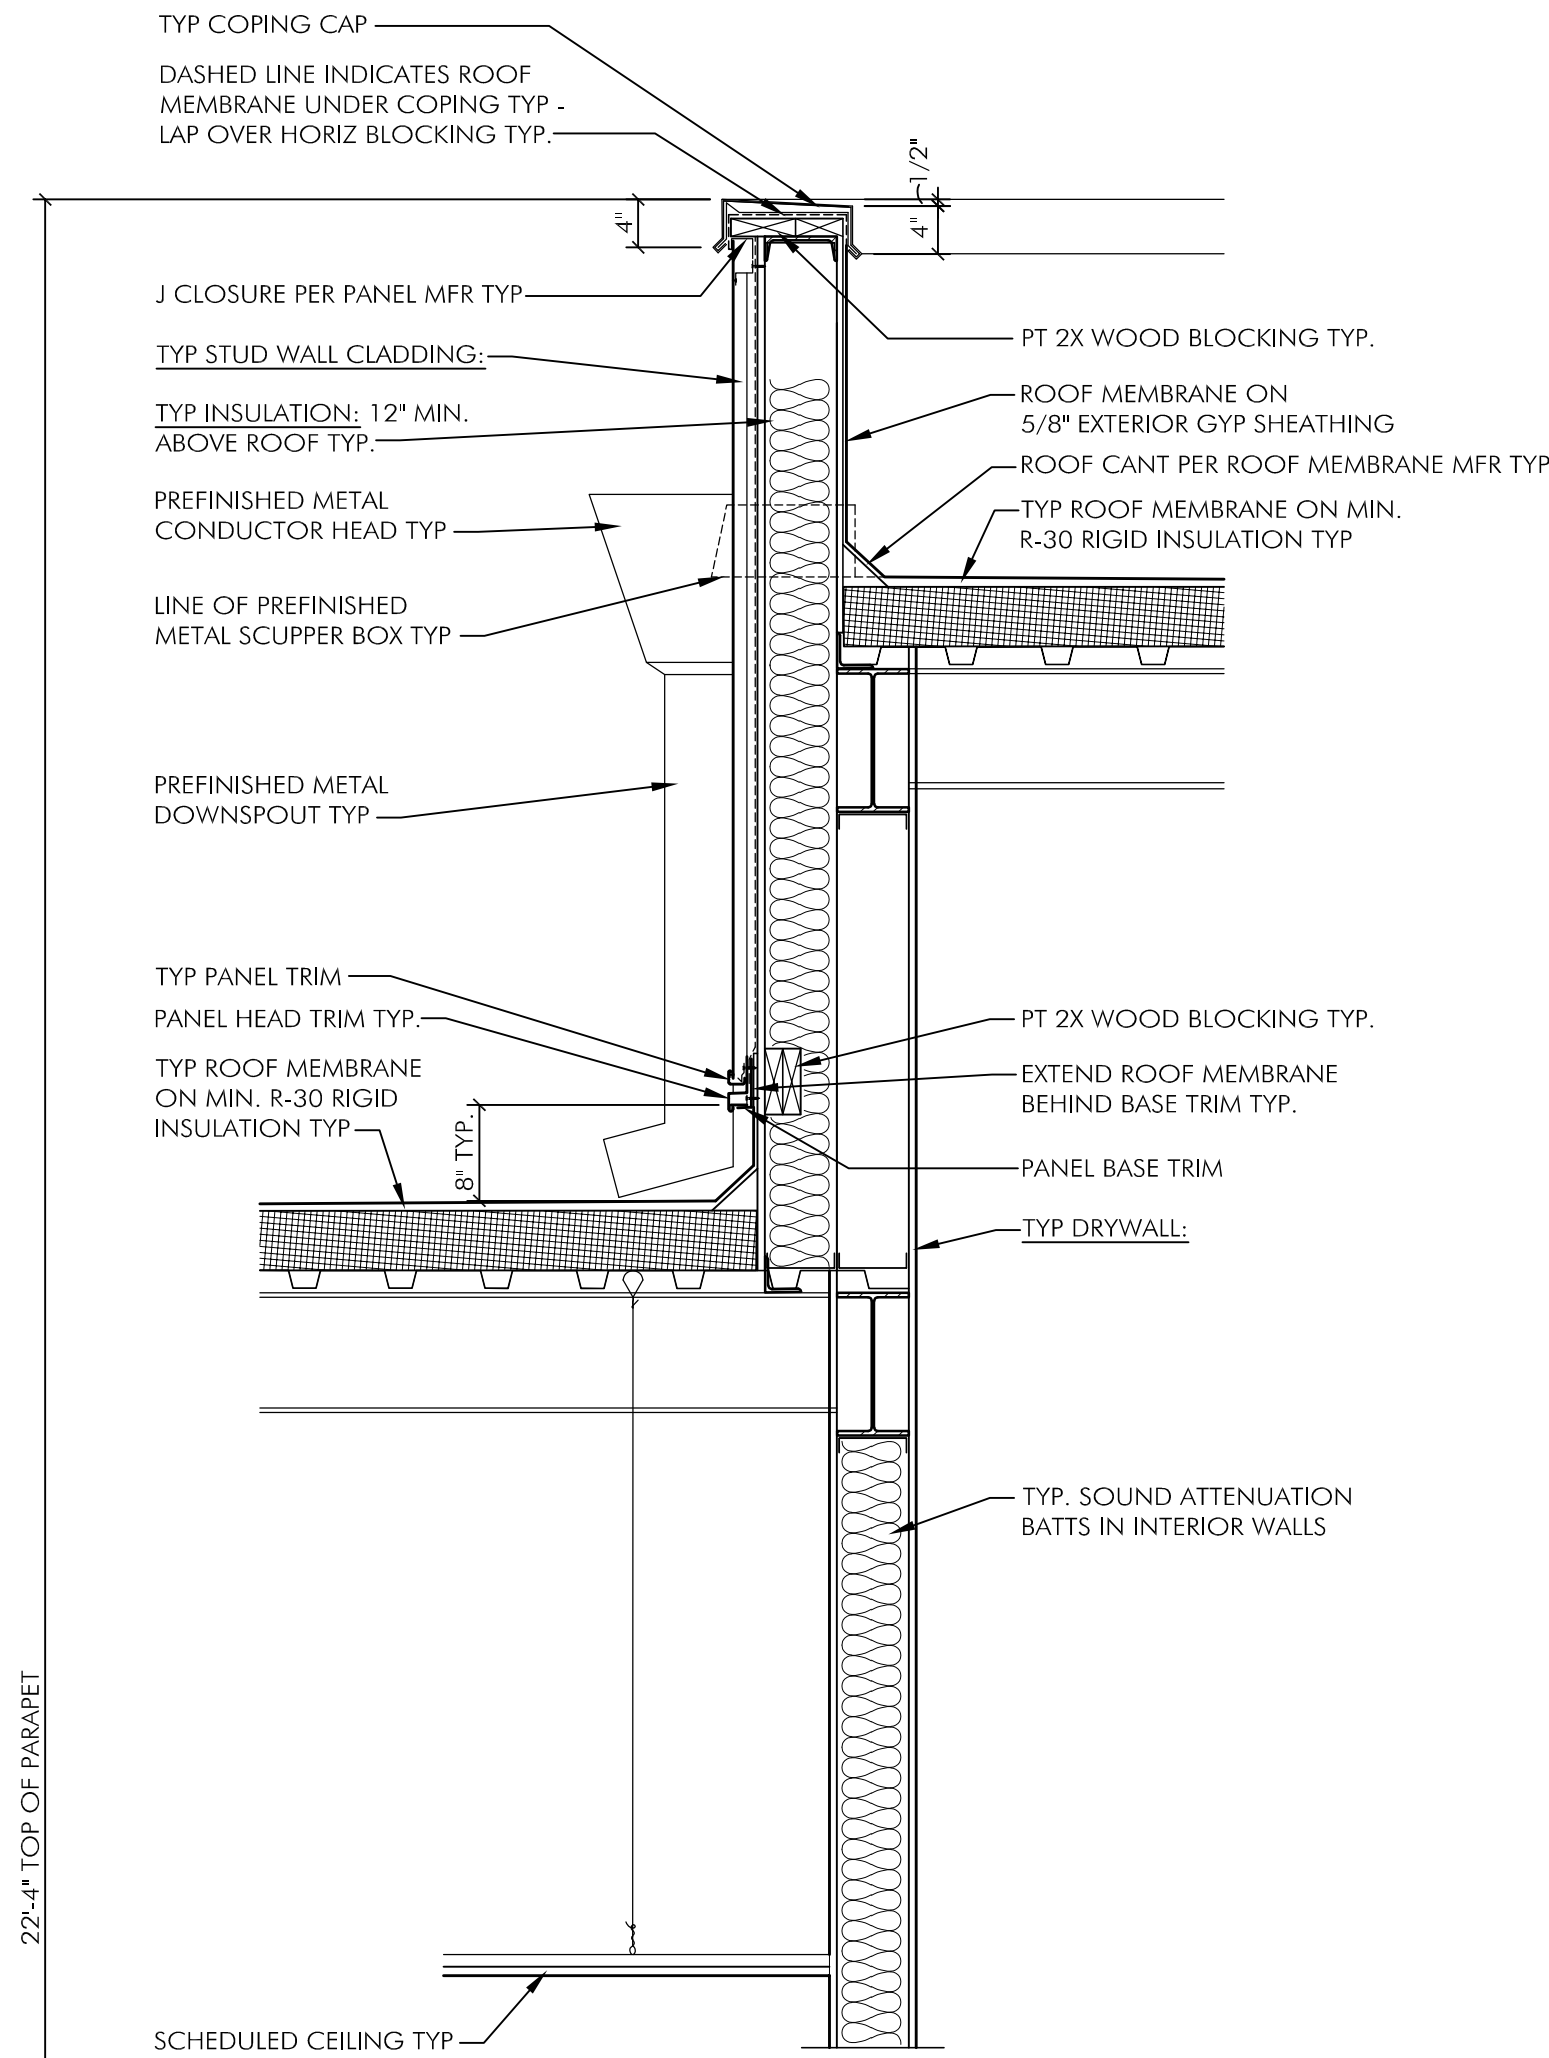

2 WALL SECTION AT INTERMEDIATE ROOF TRANSITION
3/4\" = 1'-0"

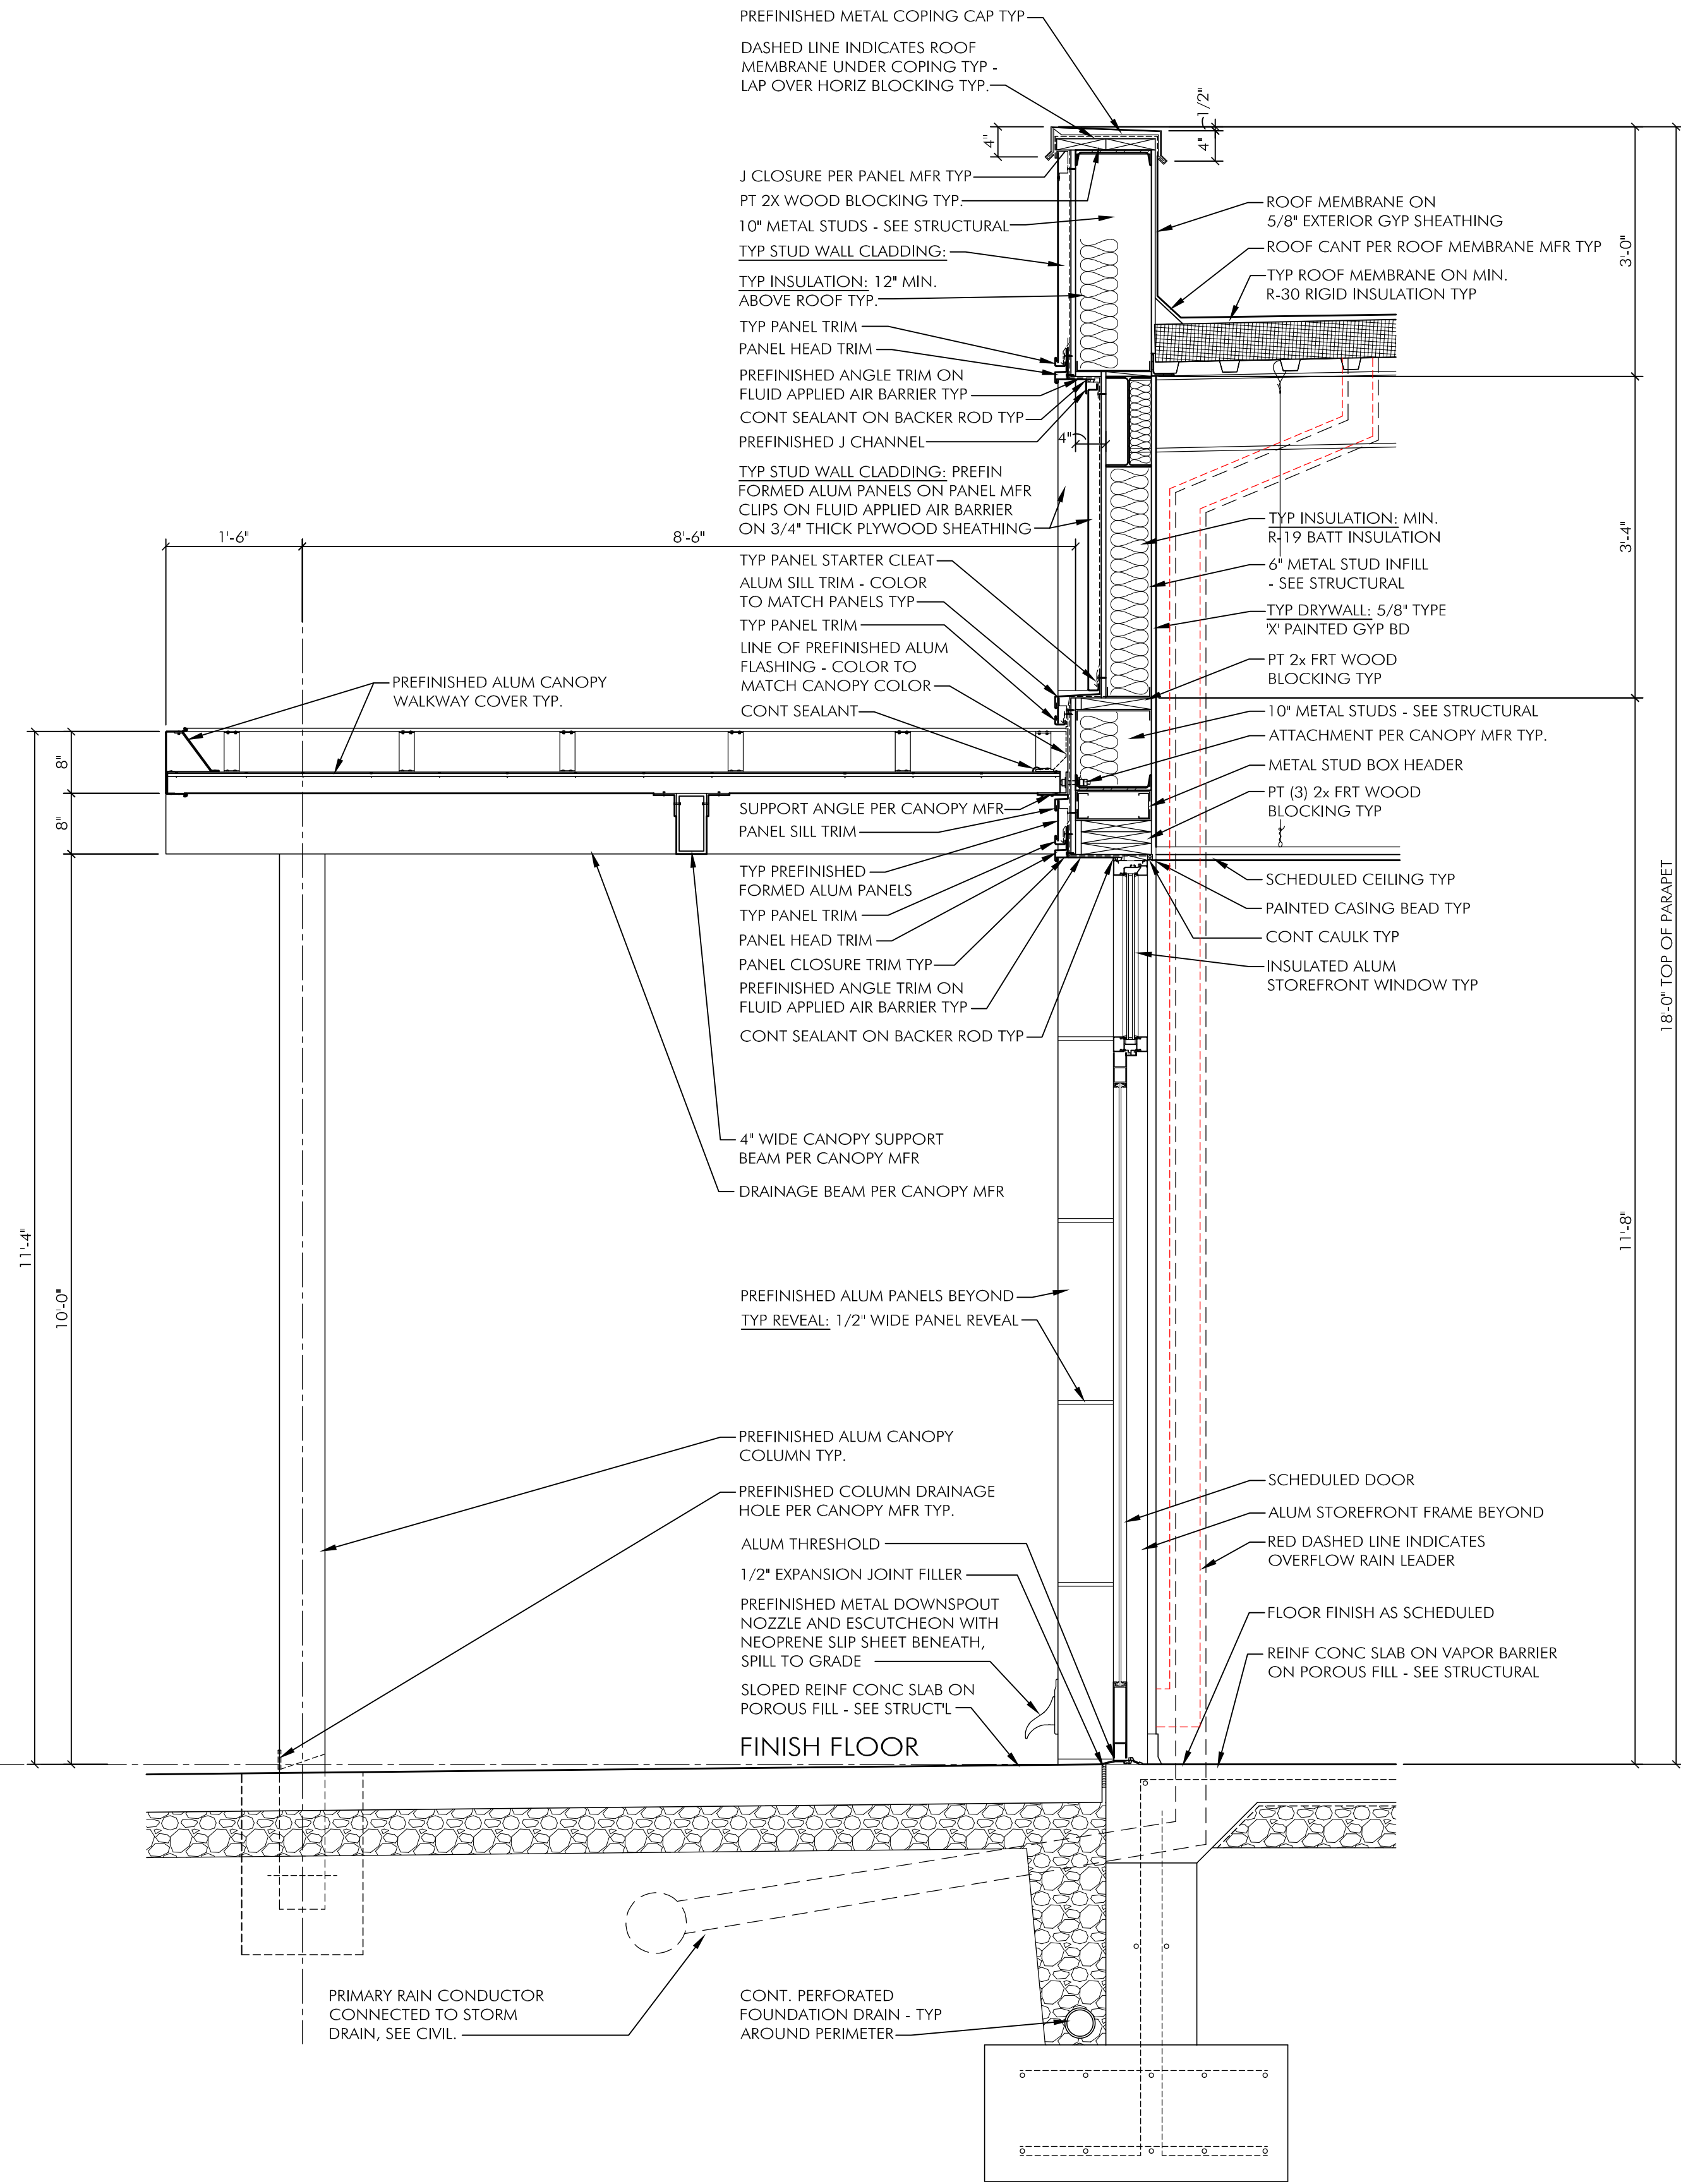

1 WALL SECTION AT LOUNGE
3/4\" = 1'-0"

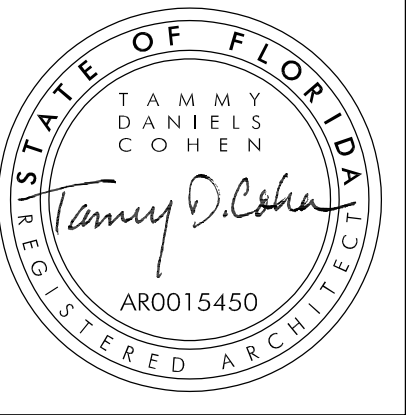

CCR ARCHITECTURE & INTERIORS

MARTIN LUTHER KING JR. RECREATION CENTER
705 14TH COURT EAST
PANAMA CITY, FL 32401

JOB NUMBER:
21109

DATE:
05/18/2023


PRINTED / REVISIONS
DESCRIPTION DATE

SHEET TITLE:
TYPICAL WALL SECTIONS


SHEET NUMBER:

A402

THIS DRAWING IS THE PROPERTY OF CCR ARCHITECTURE & INTERIORS AND IS NOT TO BE REPRODUCED, COPIED OR ALTERED IN WHOLE OR IN PART OR USED FOR ANY PURPOSE WITHOUT THE APPROVAL OF CCR ARCHITECTURE & INTERIORS AND IS TO BE RETURNED UPON REQUEST.

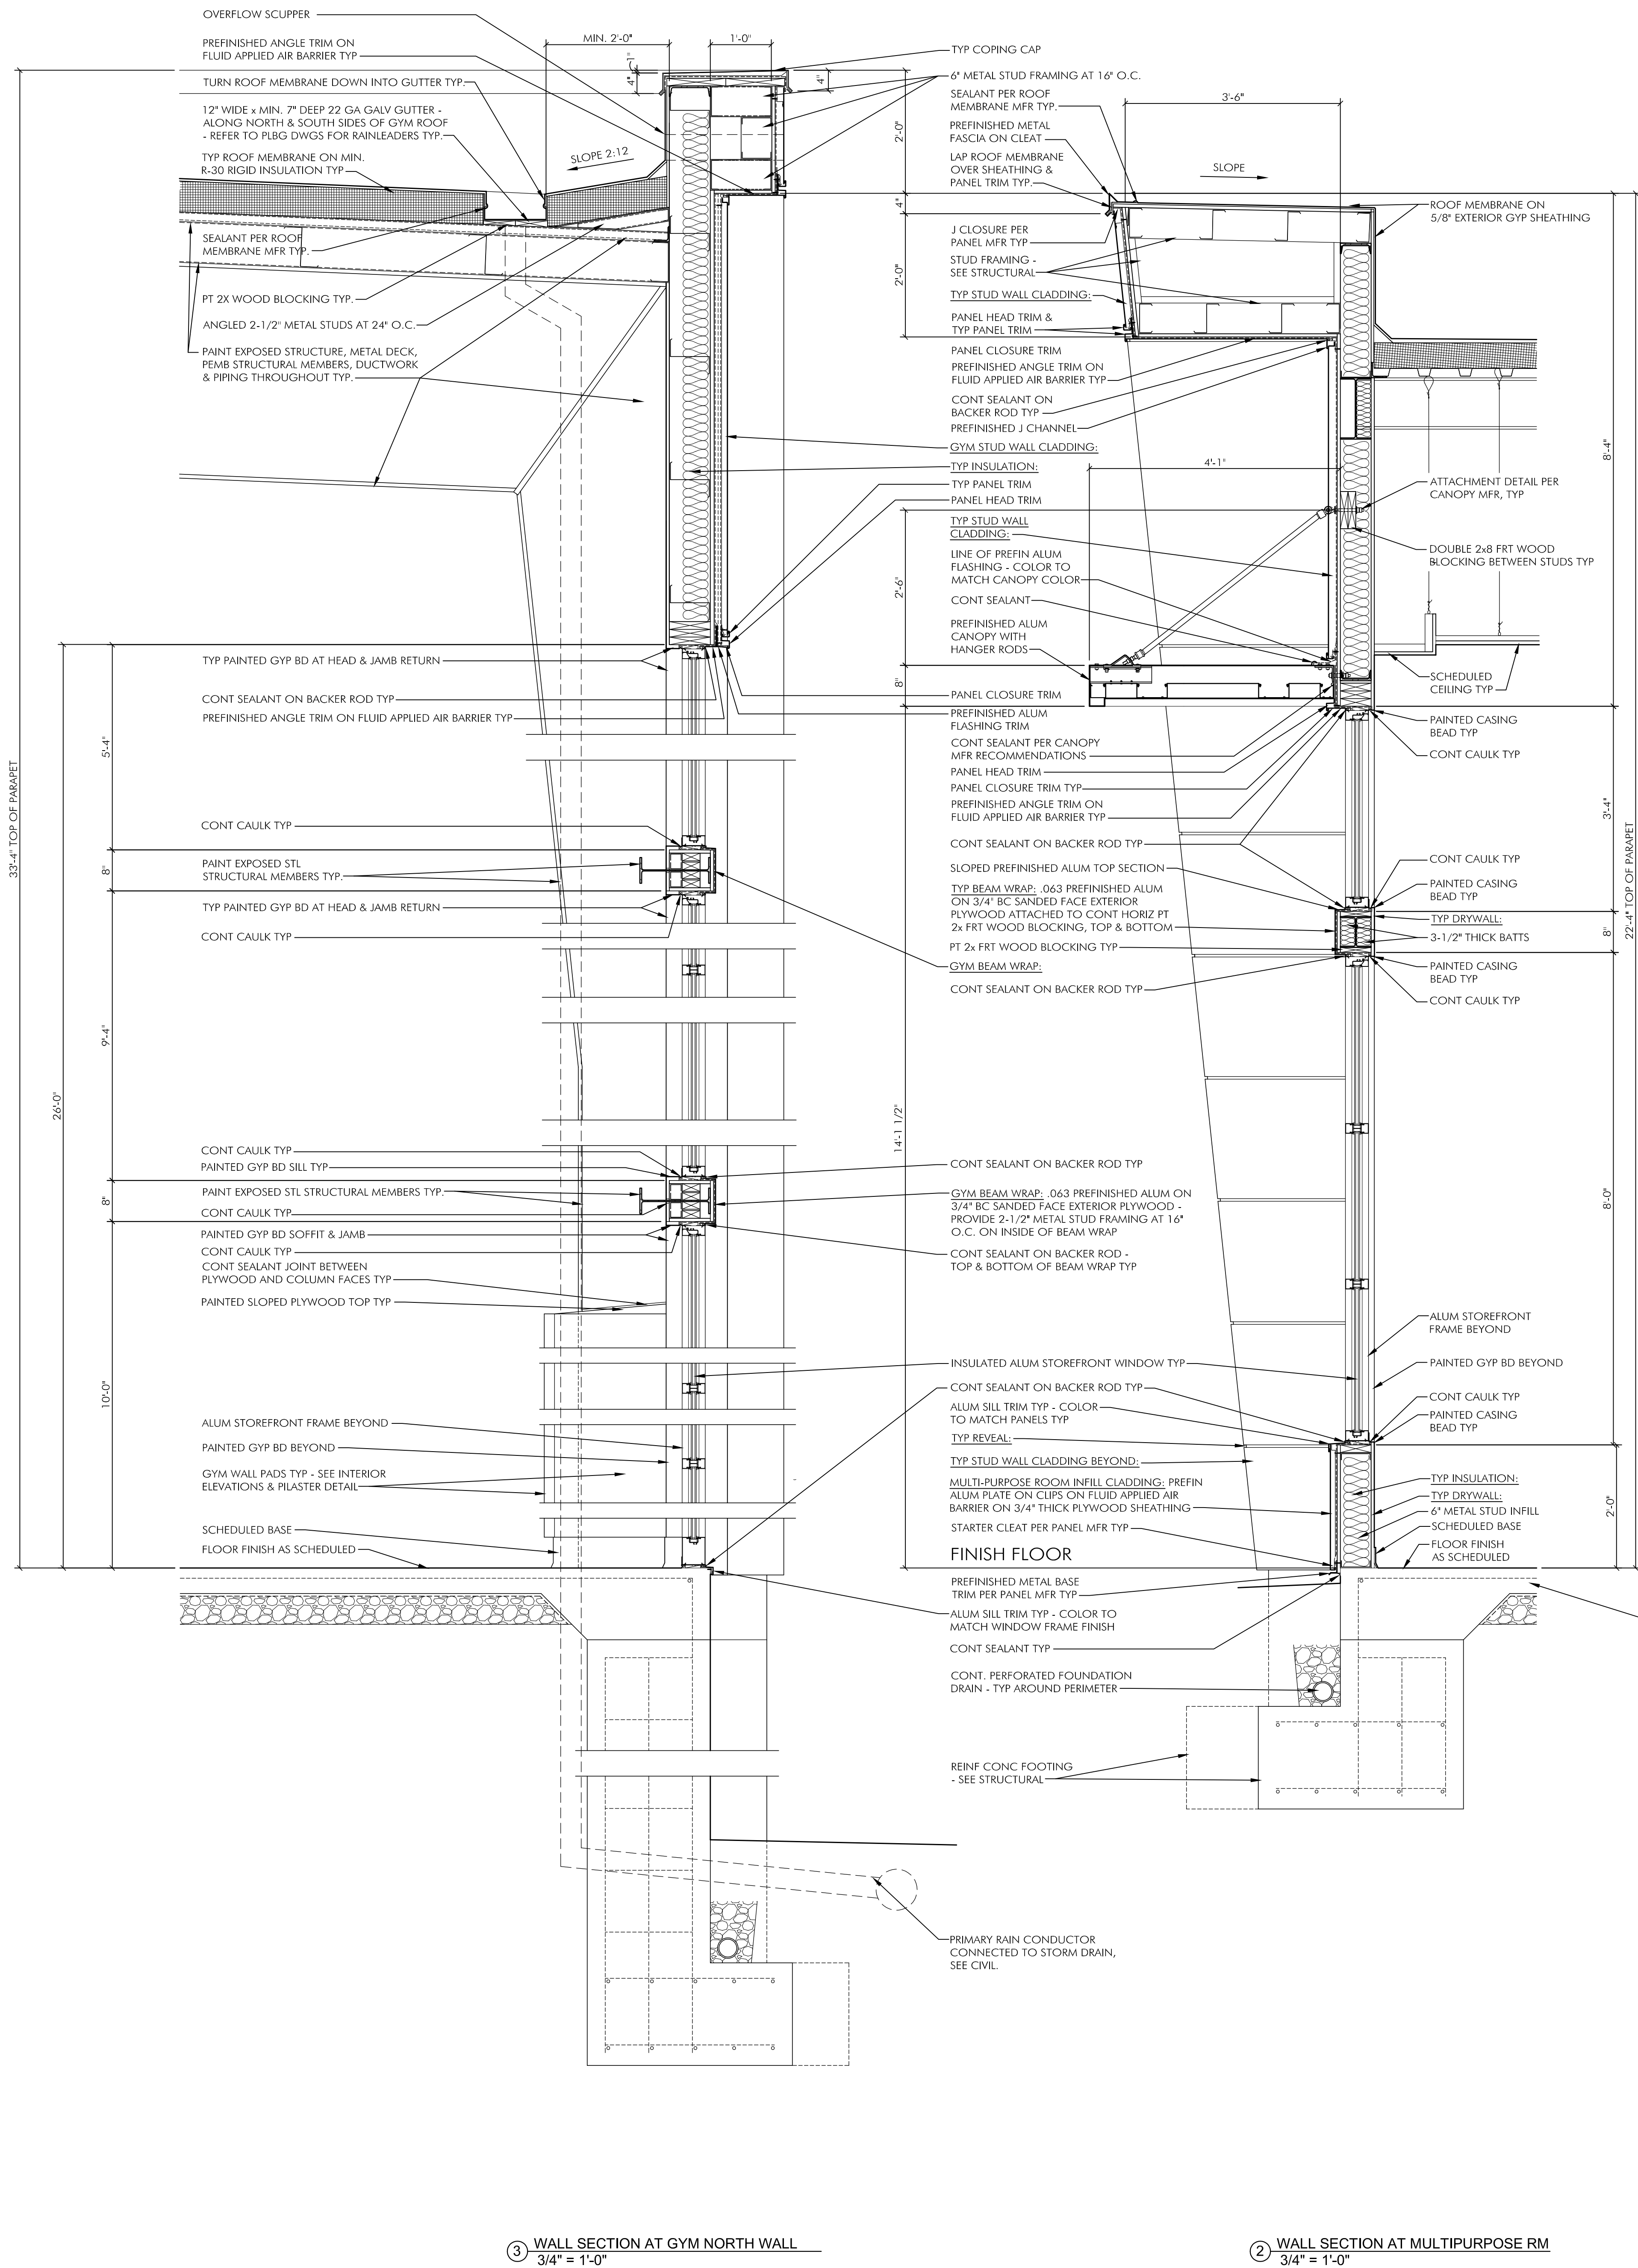


3 WALL SECTION AT GYM NORTH WALL
3/4\" = 1'-0"

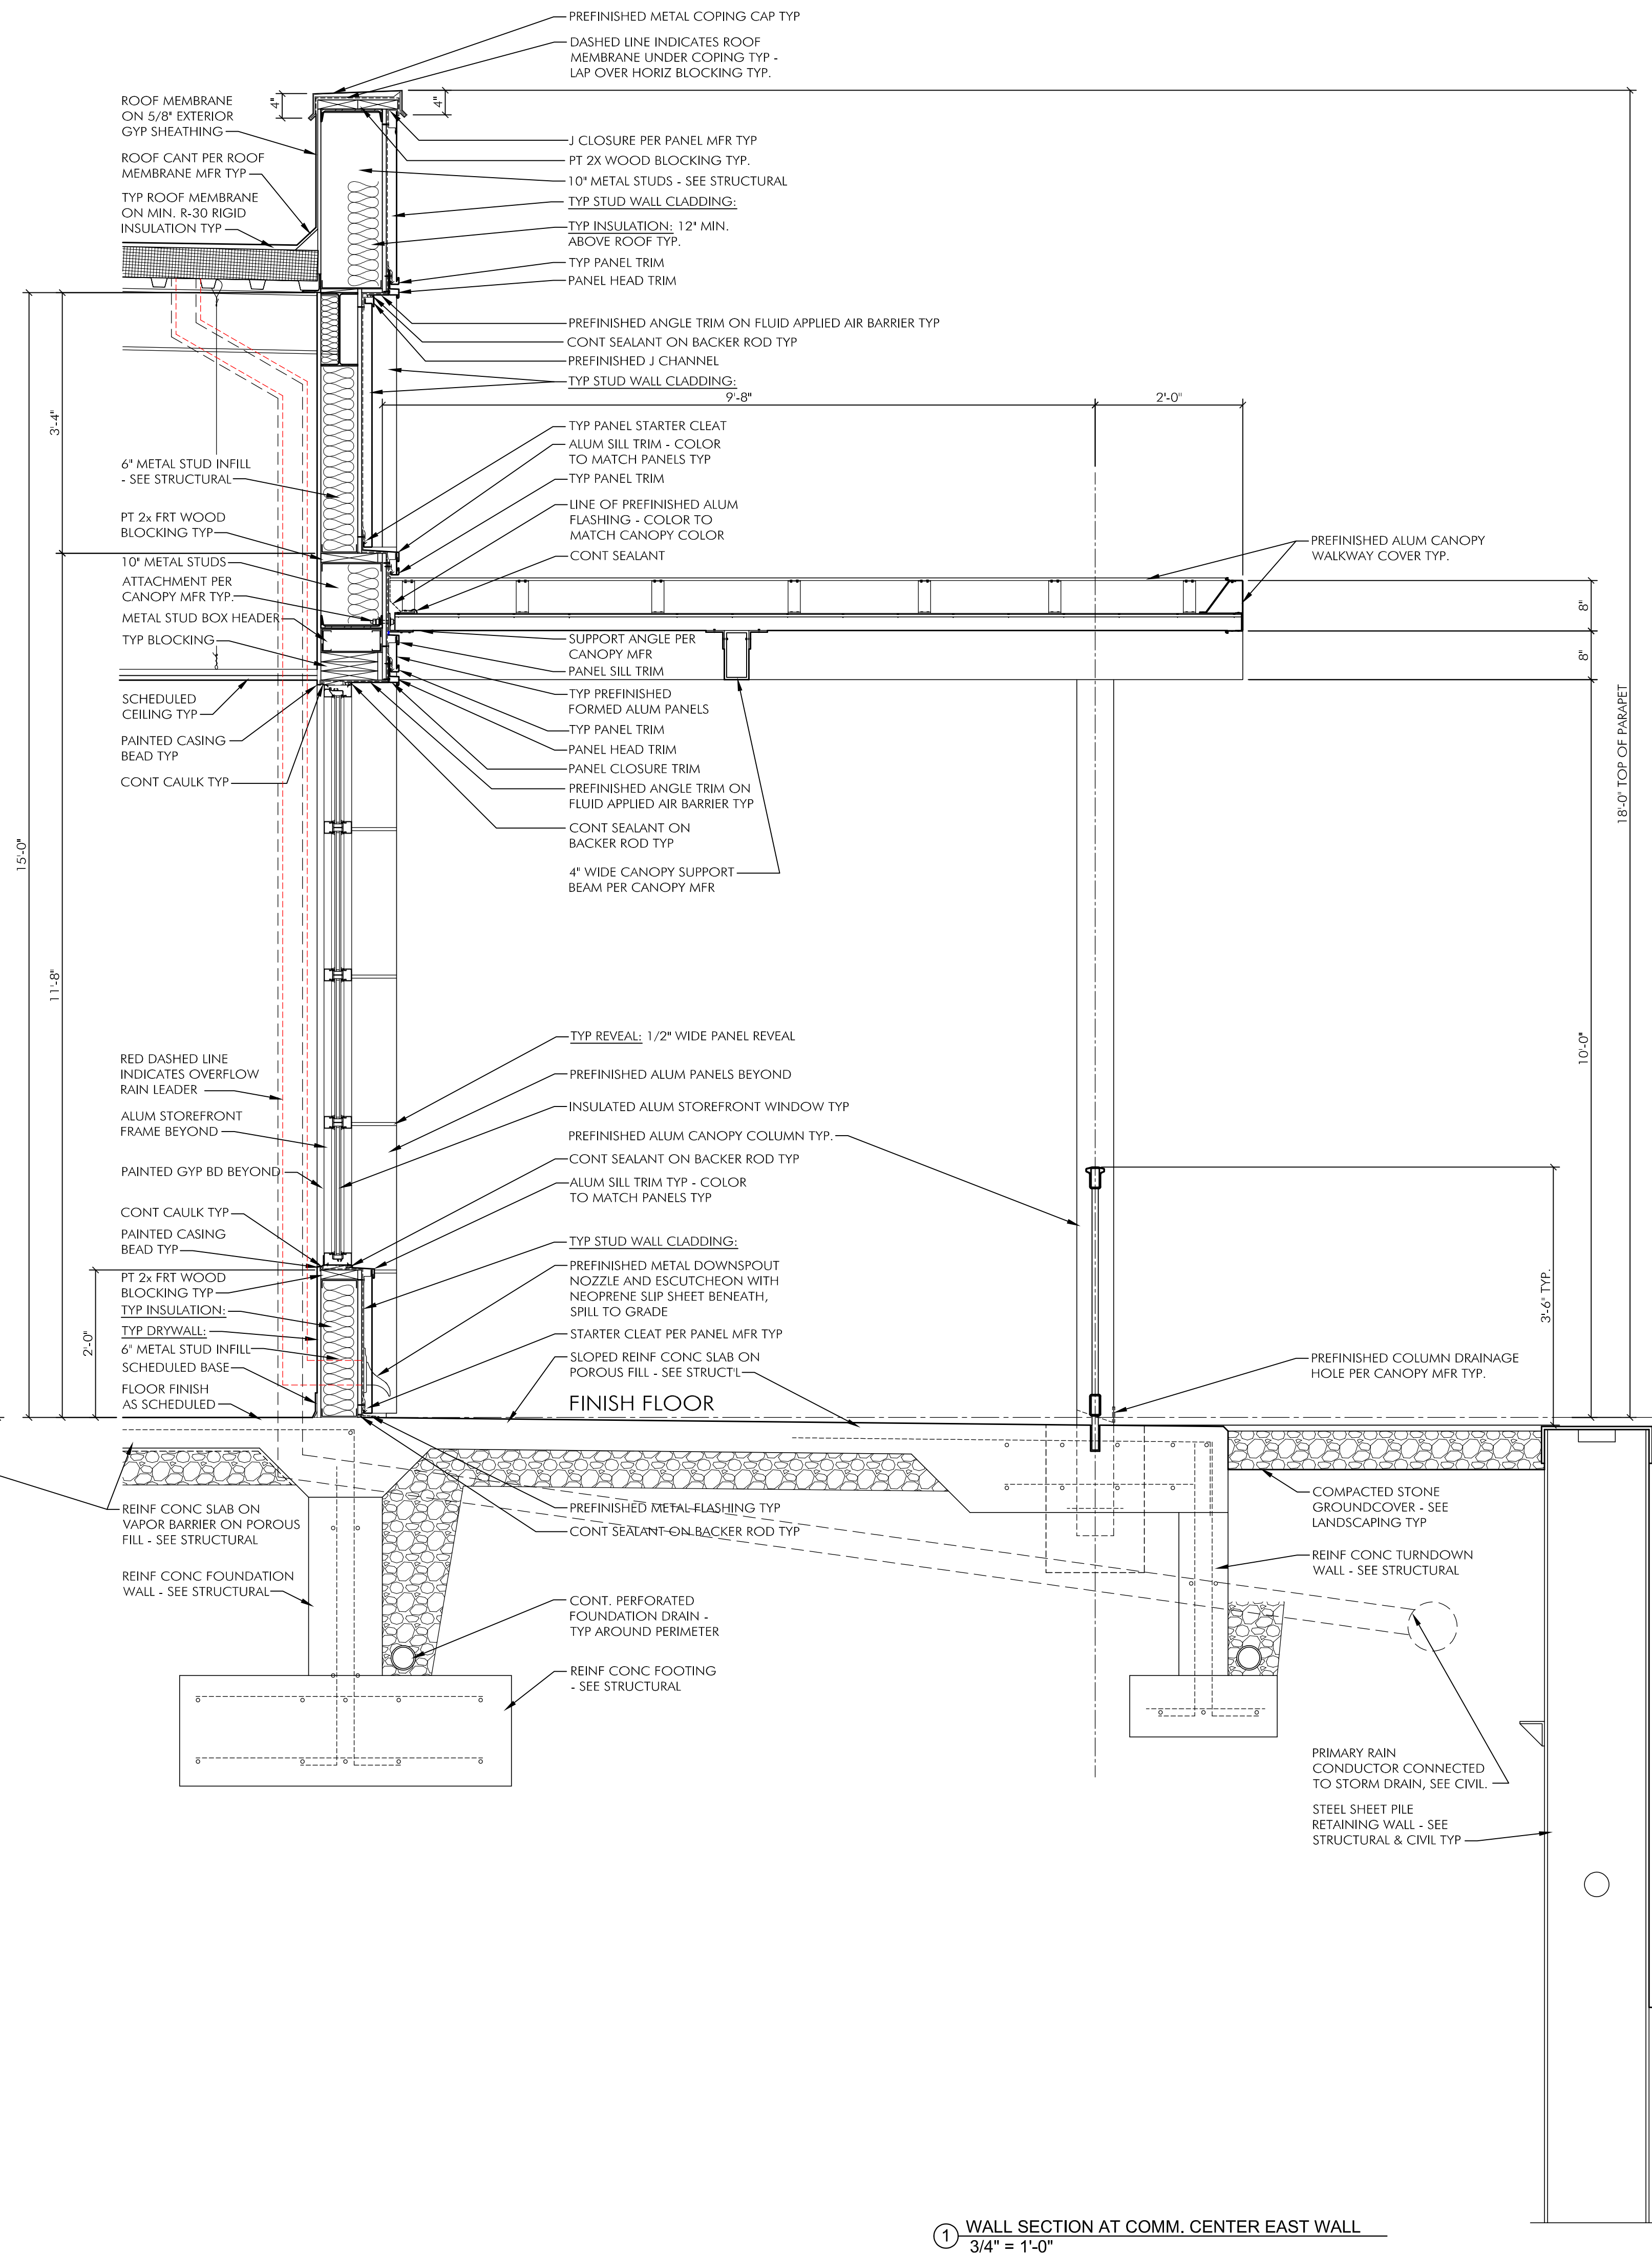

2 WALL SECTION AT MULTIPURPOSE RM
3/4\" = 1'-0"

1 WALL SECTION AT COMM. CENTER EAST WALL
3/4\" = 1'-0"

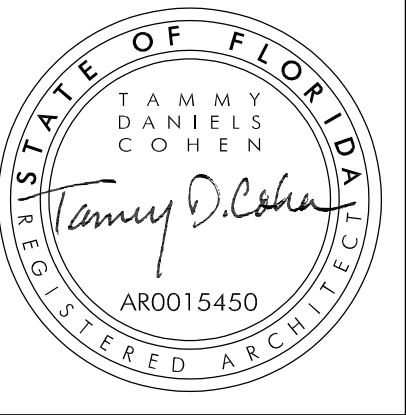

CCR ARCHITECTURE & INTERIORS

MARTIN LUTHER KING JR. RECREATION CENTER
705 14TH COURT EAST
PANAMA CITY, FL 32401

JOB NUMBER:
21109

DATE:
05/18/2023


PRINTED / REVISIONS
DESCRIPTION DATE

SHEET TITLE:
TYPICAL WALL
SECTIONS


SHEET NUMBER:

A403


THIS DRAWING IS THE PROPERTY OF CCR ARCHITECTURE & INTERIORS AND IS NOT TO BE REPRODUCED, COPIED OR ALTERED IN WHOLE OR IN PART OR USED FOR ANY PURPOSE WITHOUT THE APPROVAL OF CCR ARCHITECTURE & INTERIORS AND IS TO BE RETURNED UPON REQUEST.

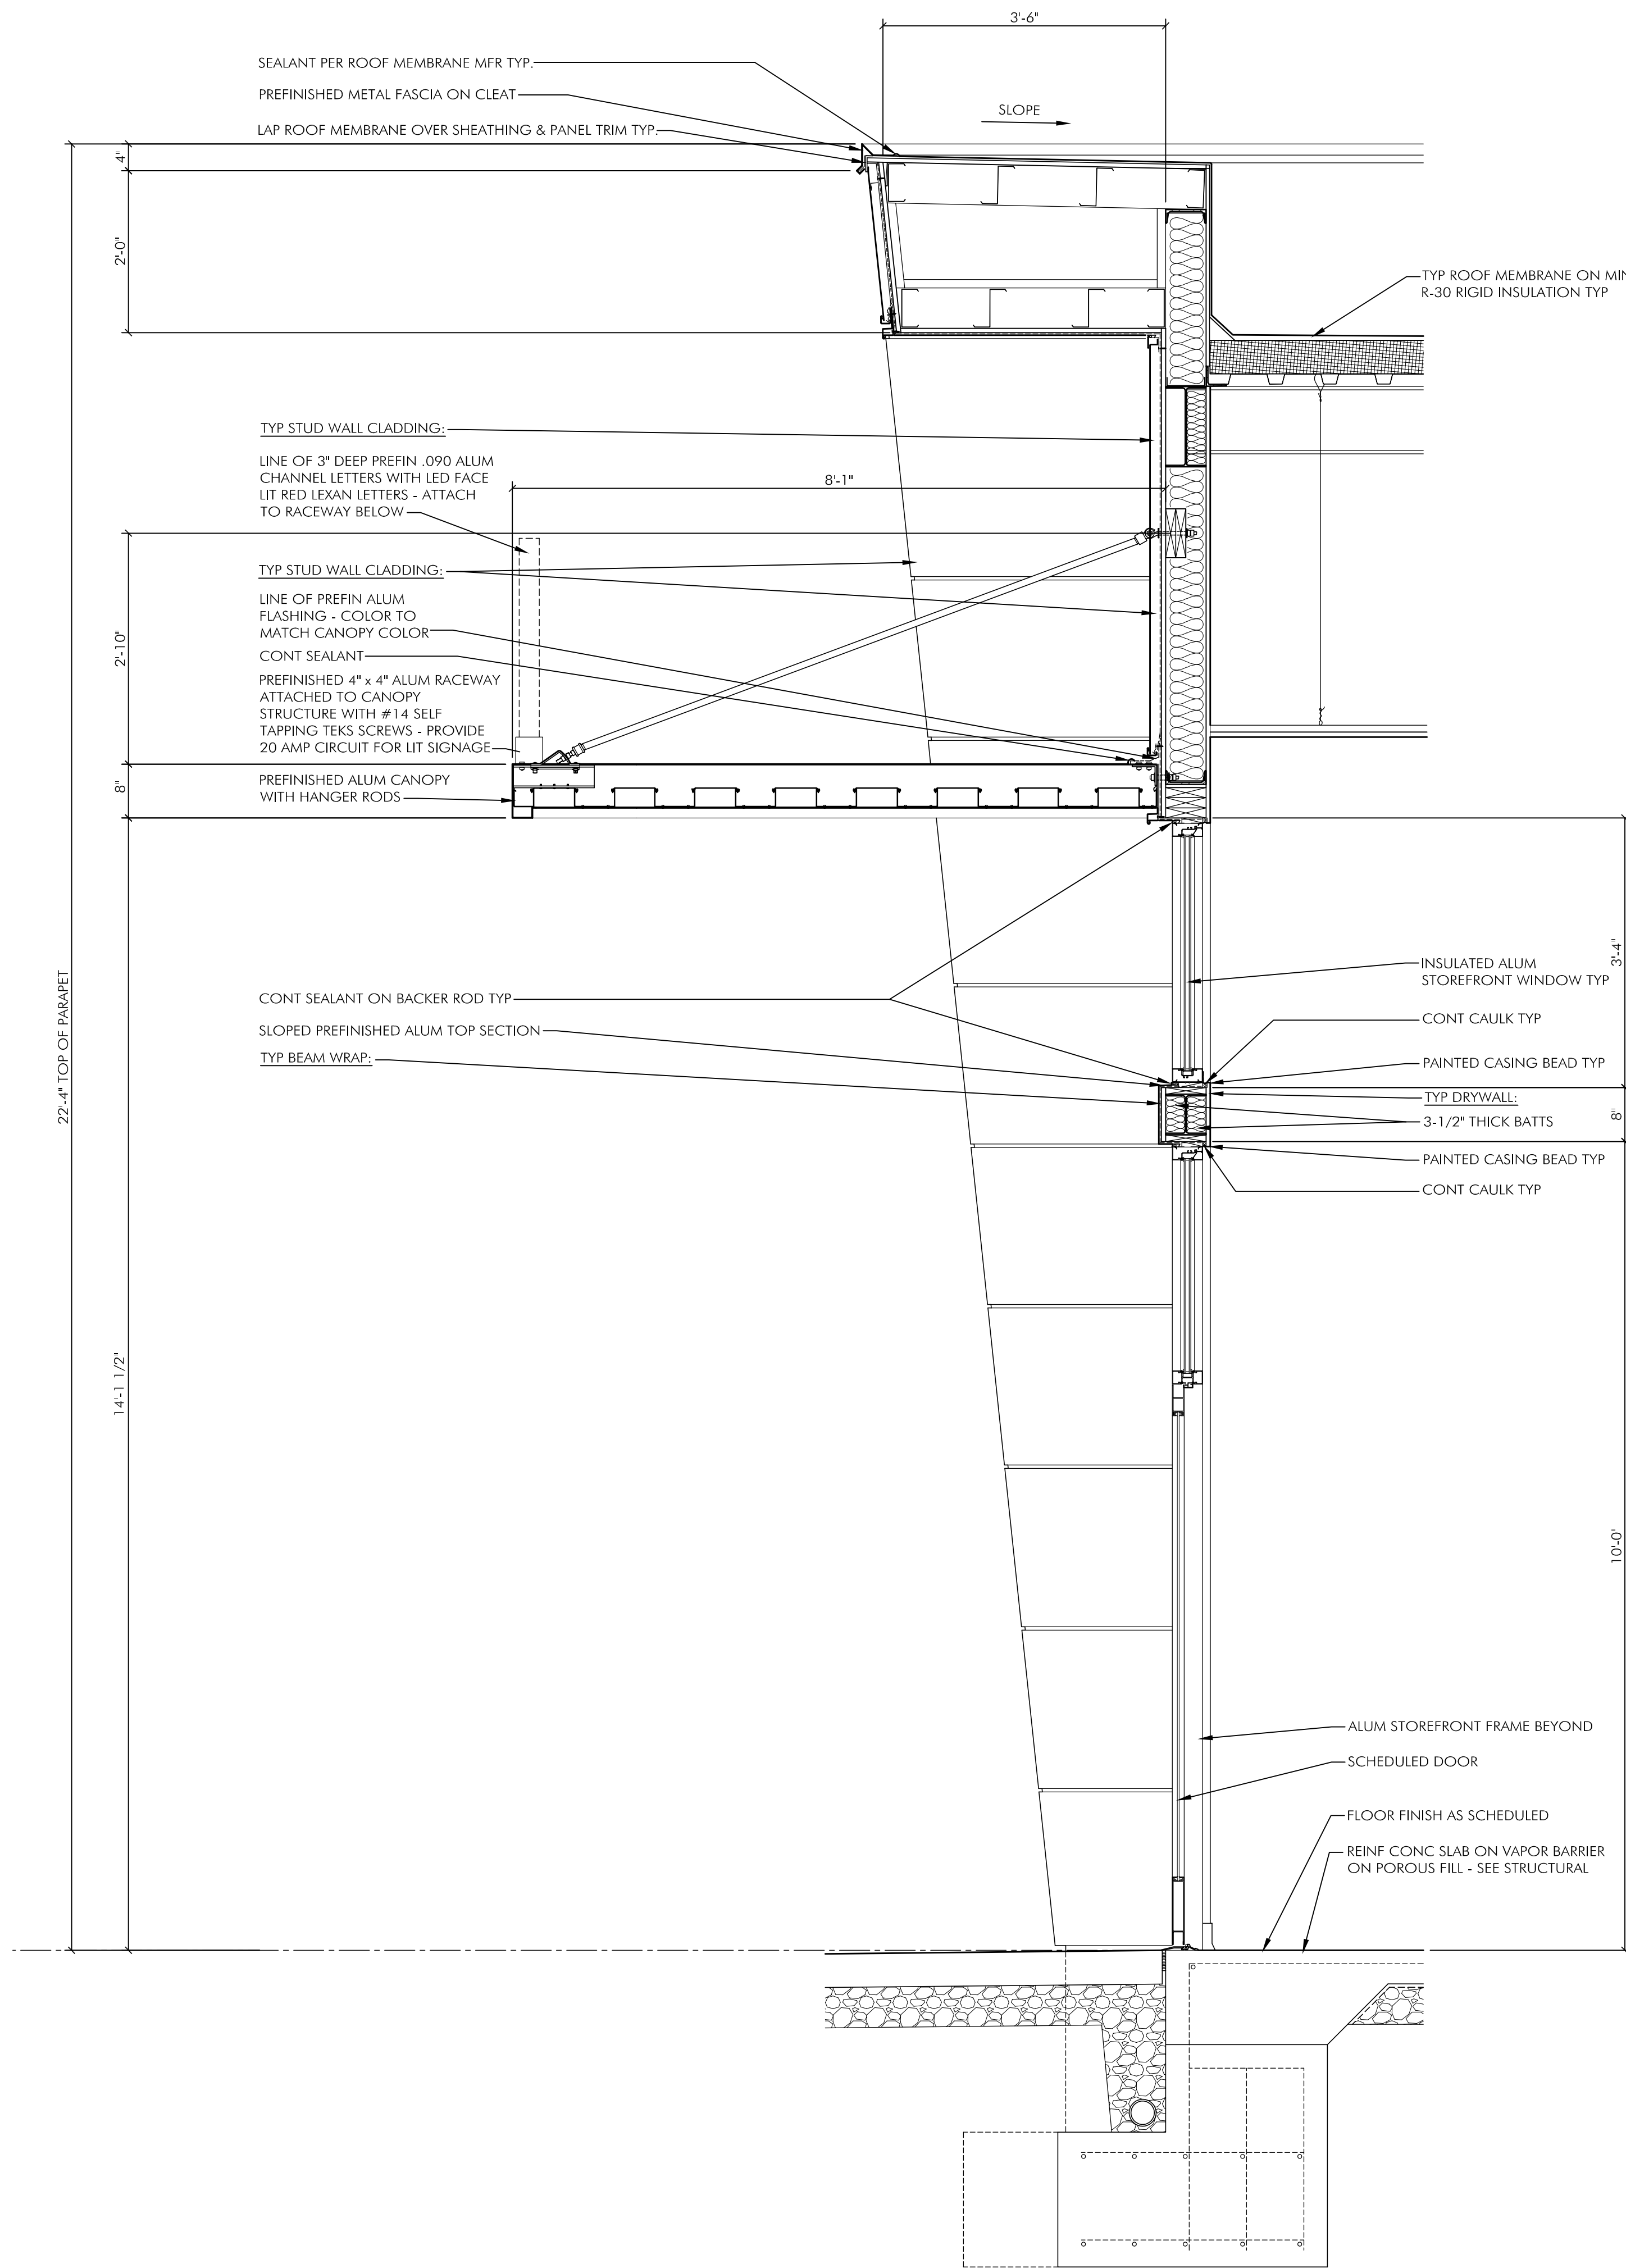

② WALL SECTION AT VESTIBULE
3/4" = 1'-0"

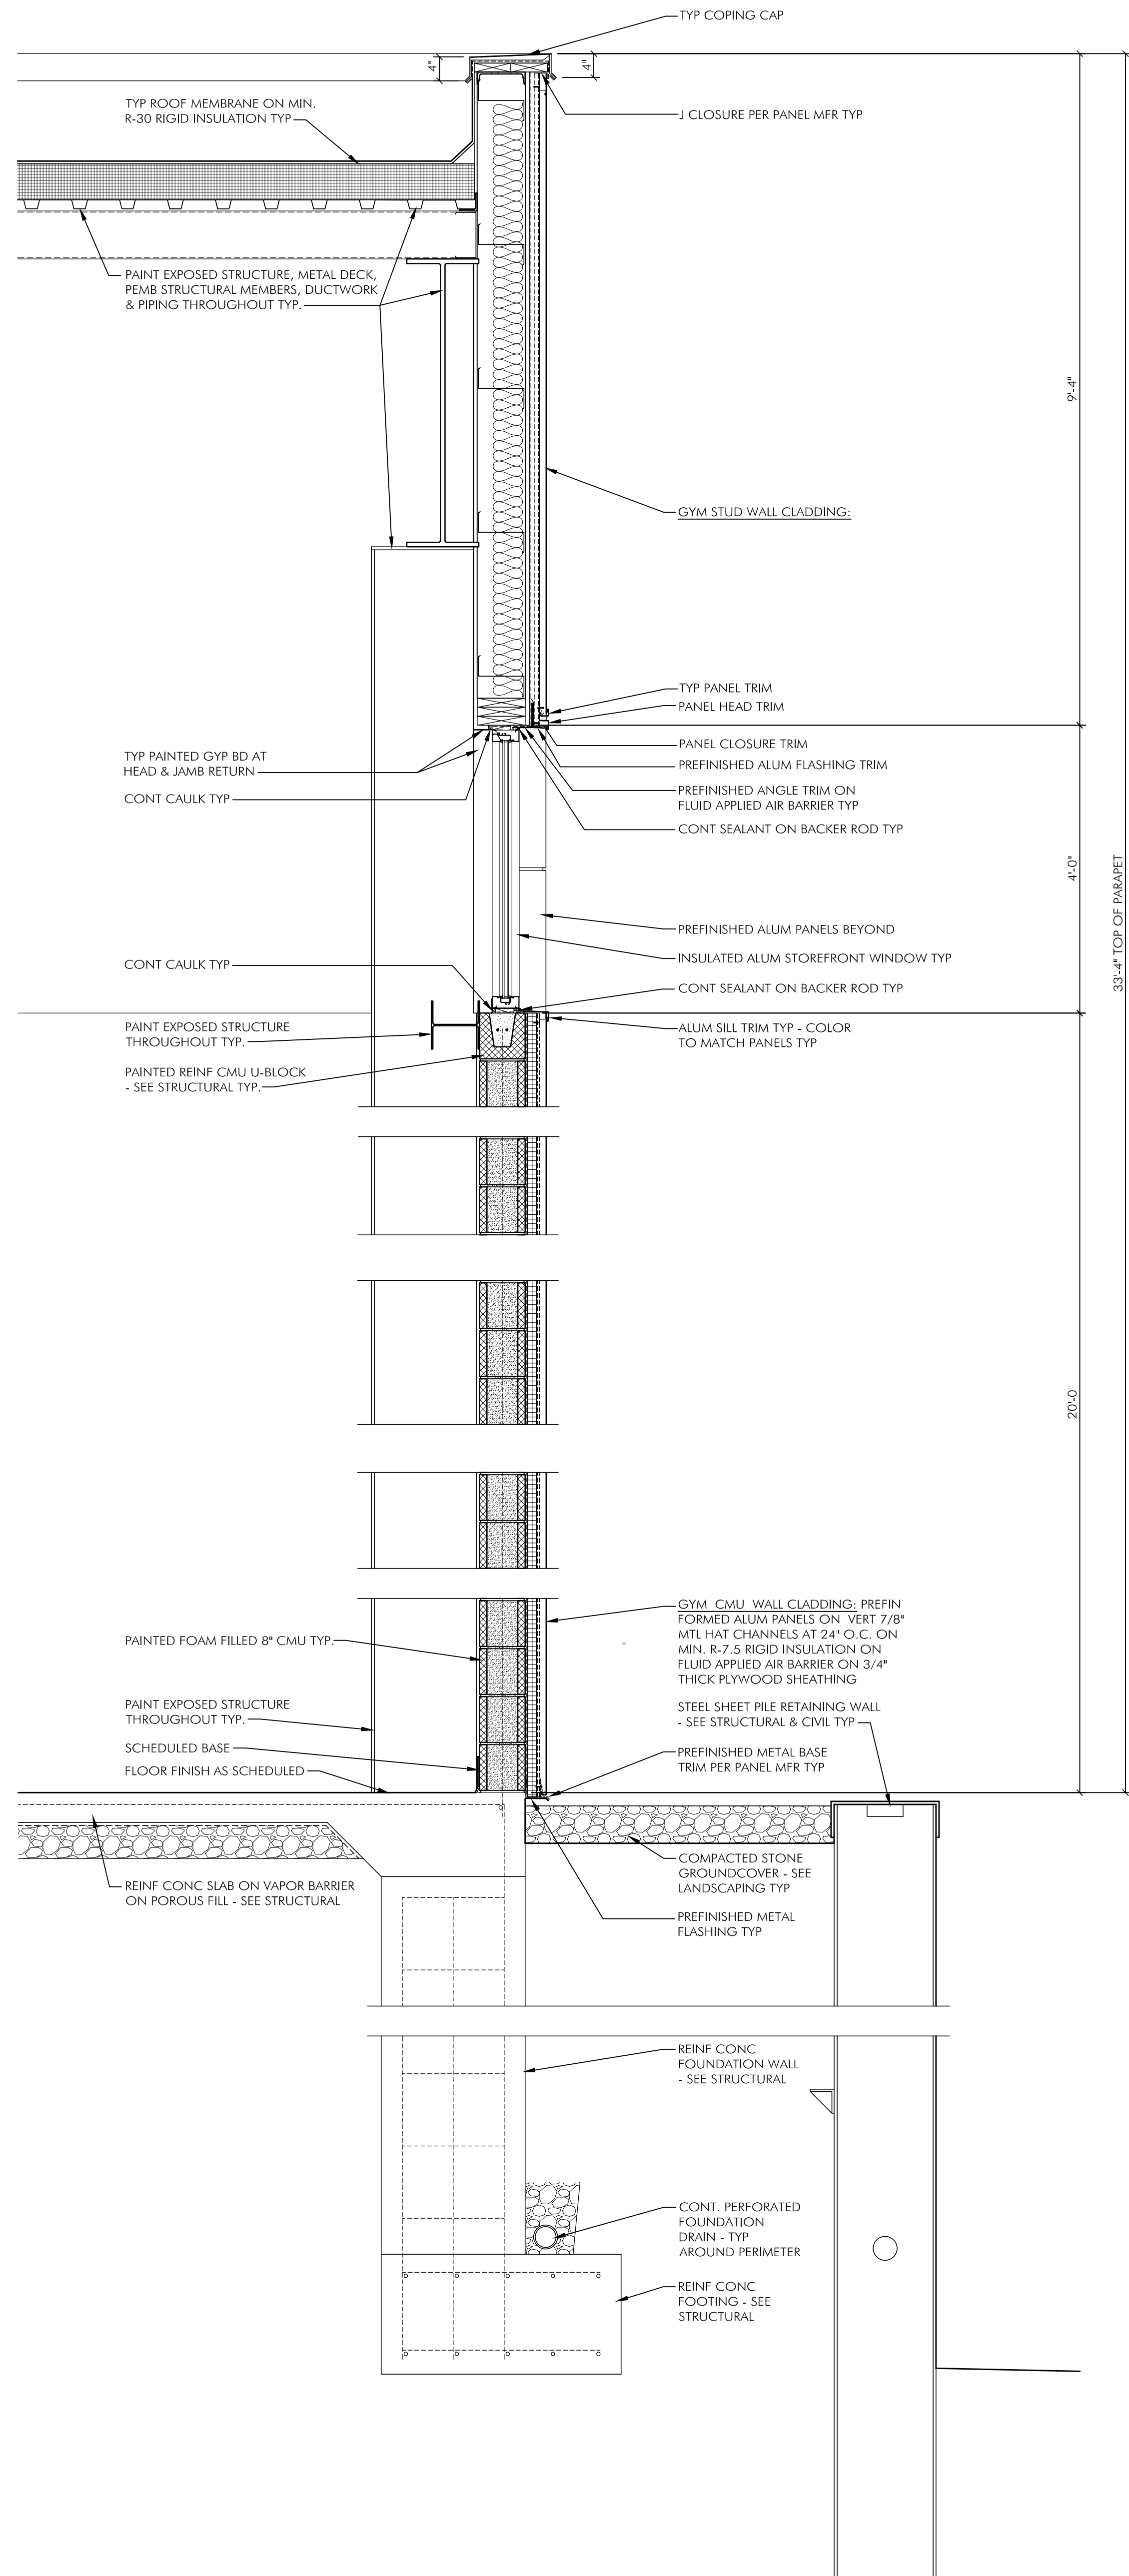

① WALL SECTION AT GYM EAST WALL
3/4" = 1'-0" WEST WALL SIMILAR, OPPOSITE HAND

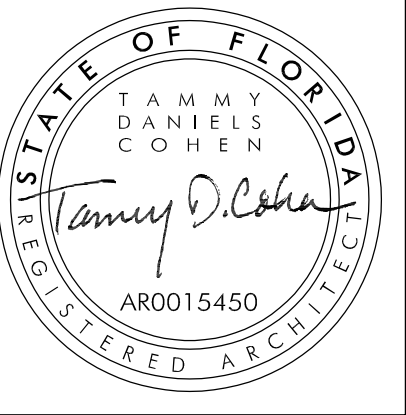

CCR ARCHITECTURE & INTERIORS

MARTIN LUTHER KING JR. RECREATION CENTER
705 14TH COURT EAST
PANAMA CITY, FL 32401

JOB NUMBER:
21109

DATE:
05/18/2023

PRINTED / REVISIONS
DESCRIPTION DATE

SHEET TITLE:
TYPICAL WALL
SECTIONS

SHEET NUMBER:

A404

① ENLARGED RESTROOM PLAN - GYM
1/2" = 1'-0"

CHEVRONS TO RUN LEFT TO RIGHT

PAINTED GYP BD

MOSAIC WALL TILE

WALL SCONCE

QUARTZ COUNTER AND APRON


WASTE RECEPTACLE

WALL TILE

2'-0"

(A) INTERIOR ELEVATION - MEN
1/4" = 1'-0"

BASIS OF DESIGN: PLUMBING & ACCESSORY LEGEND			
GENERAL NOTE: BASIS OF DESIGN MODELS ARE BASIS OF DESIGN ONLY. SEE SPECIFICATIONS FOR EQUALS.			
A	GRAB BAR 42" : 1-1/4" DIA. STRAIGHT GRAB BAR.	BOBRICK, B-5806 X 42	PROVIDE BLOCKING AS REQUIRED.
B	GRAB BAR 18" : 1-1/4" DIA. STRAIGHT GRAB BAR.	BOBRICK, B-5806 X 36	PROVIDE BLOCKING AS REQUIRED.
C	GRAB BAR 36" : 1-1/4" DIA. STRAIGHT GRAB BAR.	BOBRICK, B-5806 X 18	PROVIDE BLOCKING AS REQUIRED.
D	TOILET PAPER DISPENSER, SURFACE MOUNTED, MULTI ROLL.	BOBRICK, B-686	
E	SANITARY NAPKIN DISPOSAL	ULINE, H-3454	
F	DOUBLE ROBE HOOK	BOBRICK, B-76727	INSTALL ON INTERIOR OF STALL SIDE OF DOOR
G	MIRROR, 24" X 36"	BOBRICK, B-290 2436	STAINLESS STEEL
H	ELECTRIC HAND DRYER	XLERATOR XL-GR	ZINC DIE-CAST TEXTURED GRAPHITE PROVIDE POWER FOR HAND DRYER
J	RESTROOM FAUCET	SEE PLUMBING DRAWINGS	
K	UNDERMOUNT SINK	SEE PLUMBING DRAWINGS	
L	TOILET	SEE PLUMBING DRAWINGS	
M	KITCHEN FAUCET	SEE PLUMBING DRAWINGS	
N	KITCHEN SINK, UNDERMOUNT, DOUBLE BOWL	SEE PLUMBING DRAWINGS	
P	WALL HUNG SINK	SEE PLUMBING DRAWINGS	
Q	SOAP DISPENSER	TO BE PROVIDED BY OWNER N.I.C TYP.	
R	URINAL	SEE PLUMBING DRAWINGS	
S	BABY CHANGE STATION	BOBRICK B-39003	
DF	B-I-LEVEL DRINKING FOUNTAIN W/BOTTLE FILLER	HALSEY TAYLOR HYDROBOOST BOTTLE FILLING STATION & B-I-LEVEL INTEGRAL OVL-II FOUNTAIN FILTERED REFRIGERATED STAINLESS, HTHBWF-OVLSEI-I	
T	RECESSED PAPER TOWEL DISPENSER / WASTE RECEPTACLE	BOBRICK B-39003	
U	WASTE RECEPTACLE AND COUNTERTOP MOUNTED CIRCULAR CHUTE	BOBRICK B-2260 & B-529	
V	MOP & BROOM HOLDER WITH SHELF ABOVE	BOBRICK, B-239	PROVIDE IN JANITOR CLOSET.

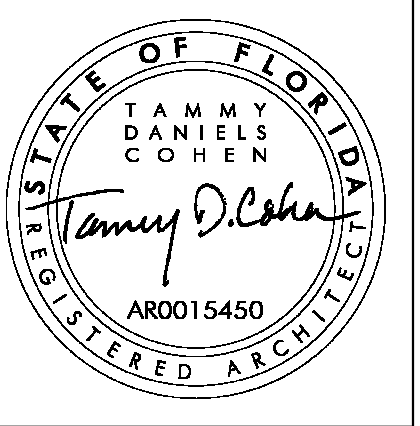

CR ARCHITECTURE & INTERIORS

MARTIN LUTHER KING JR. RECREATION CENTER
705 14TH COURT EAST
PANAMA CITY, FL 32401

705 14TH COURT EAST
PANAMA CITY, FL 32401

JOB NUMBER:
21109

DATE: 05/18/2023

PRINTED / REVISIONS		
#	DESCRIPTION	DATE

SHEET TITLE:
ENLARGED PLANS

SHEET NUMBER:

A501

Diagram illustrating a wall assembly with the following layers:

- PAINTED GYP BD (Painted Gypsum Board)
- WALL TILE (Wall Tile)

Diagram illustrating a wall assembly. The assembly consists of a **PAINTED GYP BD** (Gypsum Board) and **WALL TILE**.

PAINTED GYP BD

AT TOP OF SUBWAY TILE AND AT EDGE OF MOSAIC TILE

MOSAIC WALL TILE

PAINTED GYP BD

WALL TILE

PHENOLIC PA
PAINTED GYP
WALL TILE

Architectural section drawing of a kitchen island. The drawing shows a cross-section of the island with a countertop and cabinets below. The wall above the countertop is labeled 'WALL TILE' on the left and 'ACCENT WALL TILE' on the right. The upper part of the wall is labeled 'PAINTED GYP BD'. The countertop is labeled 'QUARTZ COUNTER &'. Below the countertop, there are three cabinets with doors and drawers. The left side of the island is labeled 'AS SCHEDULED' and 'WASTE'. A vertical dashed line runs through the center of the island, with a circular callout at the top containing the number '22' and the text 'A804'.

A cross-section diagram of a tiled wall assembly. The wall is composed of a brick masonry base. On top of the brick is a layer of 'PAINTED GYP BD' (gypsum board). Above the gypsum board is a layer of 'SCHLUTER JOLLY STRIP AT TOP OF TILE, TYPICAL'. The top of the wall is finished with 'WALL TILE'. The diagram shows four toilet stalls, each with a toilet fixture. The Schluter Jolly Strip is shown running horizontally across the top of the wall, above the toilet stalls, and vertically along the side walls of the stalls. The wall tiles are shown as a brick pattern.


















Diagram illustrating the placement of a wall hung sink and a steel framed mirror. The diagram shows a cross-section of a wall with a brick pattern. A sink is mounted on the wall, and a mirror is mounted above it. Labels indicate the 'PAINTED GYP BD' (Painted Gypsum Board) at the top, the 'WALL HUNG SINK', and the 'STEEL FRAMED MIRROR'.

This diagram illustrates the installation of Schluter Jolly Strip over wall tile. The wall is covered in wall tile, and the ceiling is painted gypsum board. The Schluter Jolly Strip is installed at the top of the wall tile, creating a transition between the wall and the ceiling. The strip is shown in cross-section, with the wall tile on one side and the painted gypsum board on the other. The strip is labeled "SCHLUTER JOLLY STRIP AT TOP OF TILE, TYPICAL".

Diagram illustrating the Schlüter Jolly Strip at the top of a wall tile installation. The strip is shown between the wall tile and the painted gypsum board.

- WALL TILE
- PAINTED GYPSUM
- SCHLÜTER JOLLY STRIP AT TOP OF TILE, TYPICAL

05/18/2023 05:18 PM CCR ARCHITECTURE & INTERIORS, LLC 705 14TH COURT EAST PANAMA CITY, FL 32401
THIS DRAWING IS THE PROPERTY OF CCR ARCHITECTURE & INTERIORS, LLC. IT IS NOT TO BE REPRODUCED, COPIED OR ALTERED IN WHOLE OR IN PART OR USED FOR ANY PURPOSE WITHOUT THE APPROVAL OF CCR ARCHITECTURE & INTERIORS, LLC. IT IS TO BE RETURNED UPON REQUEST.

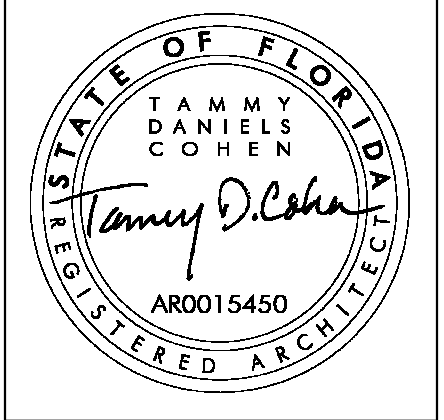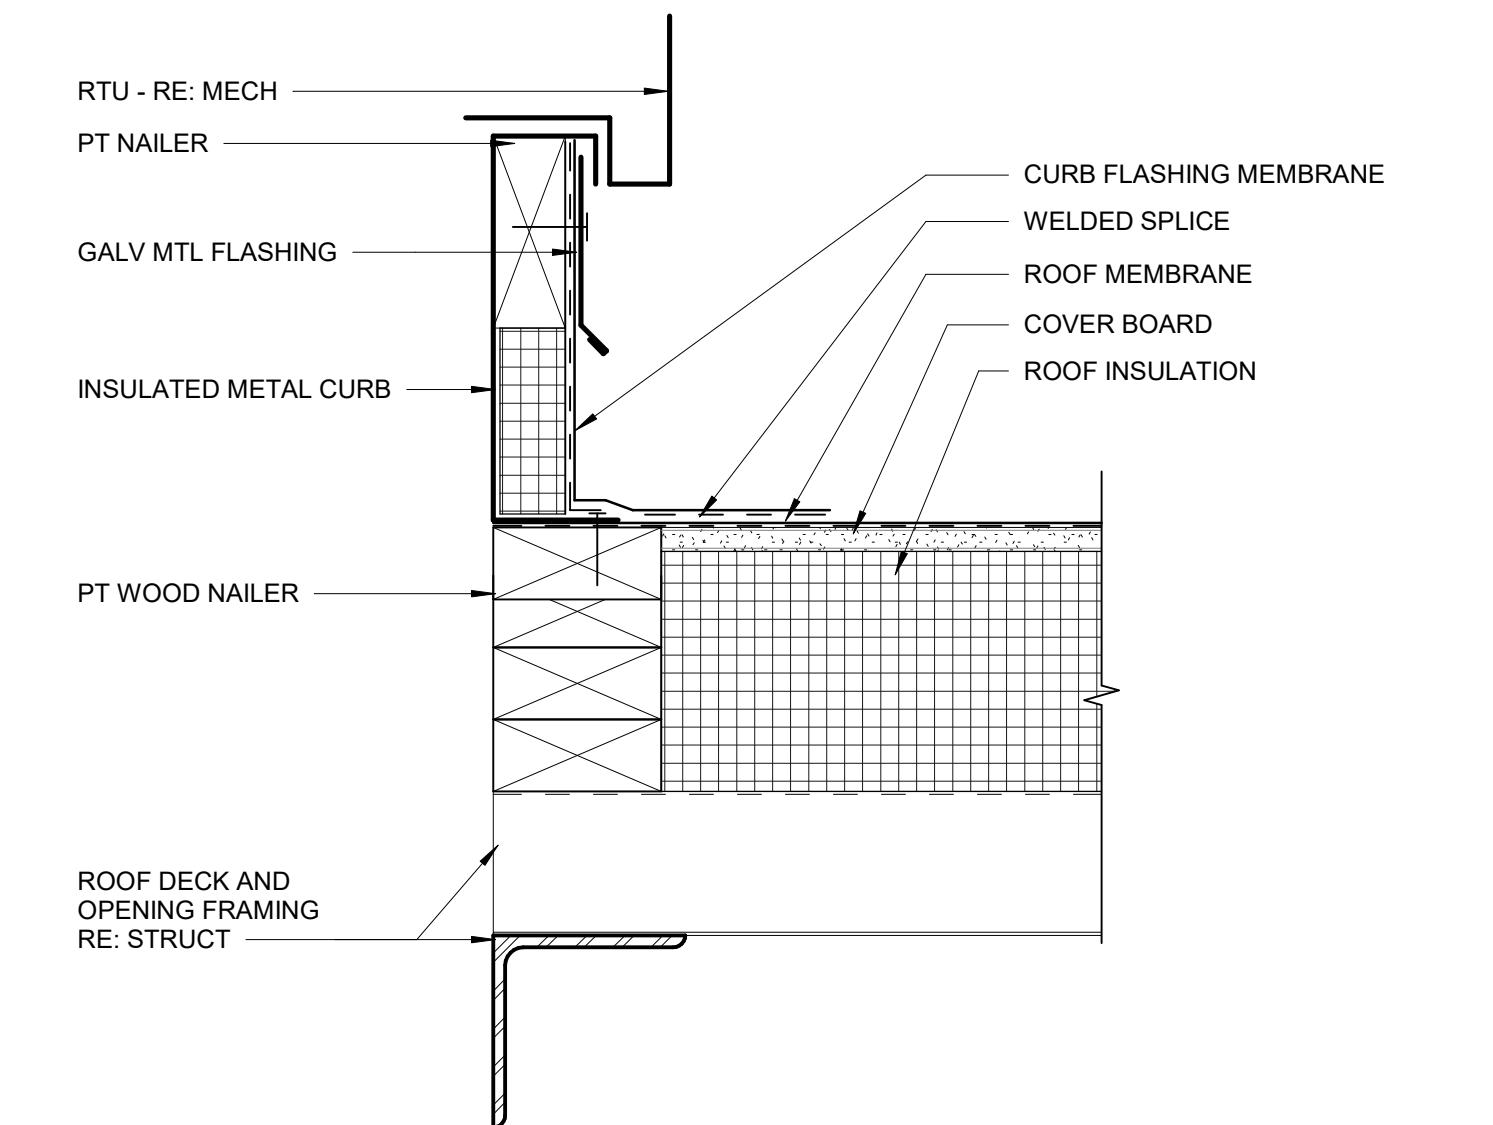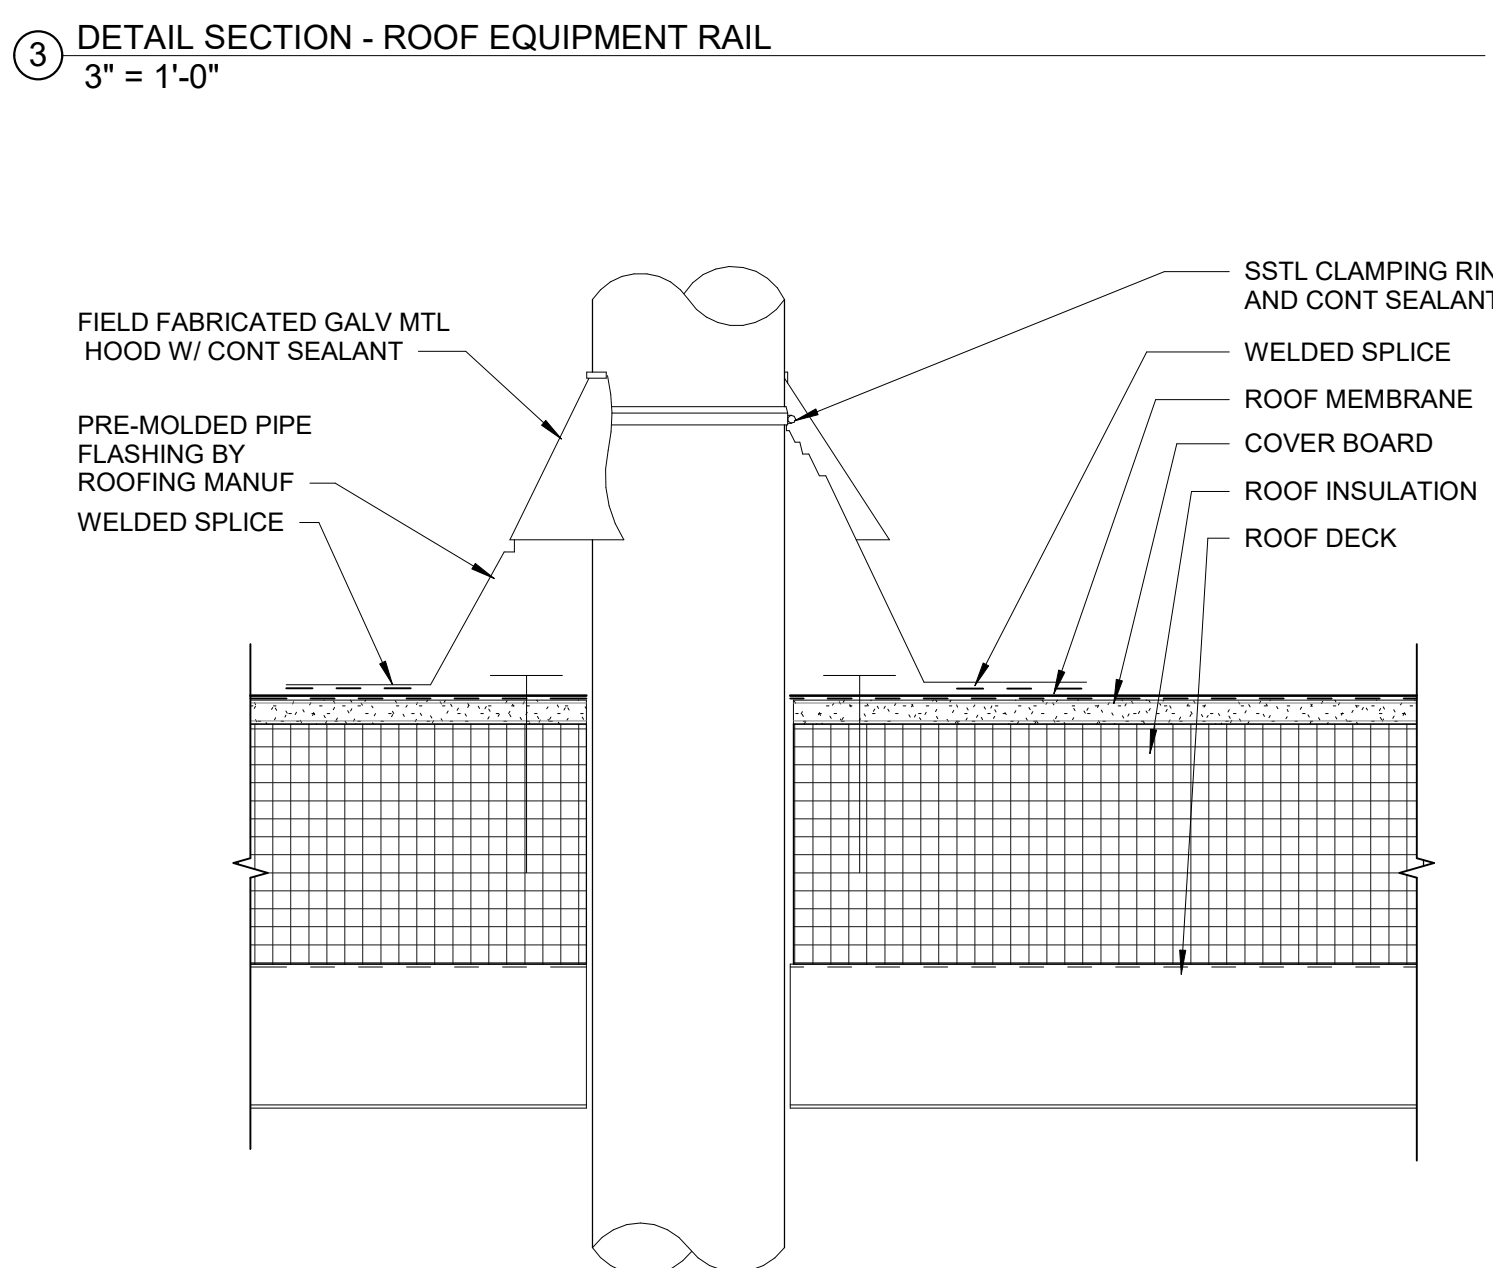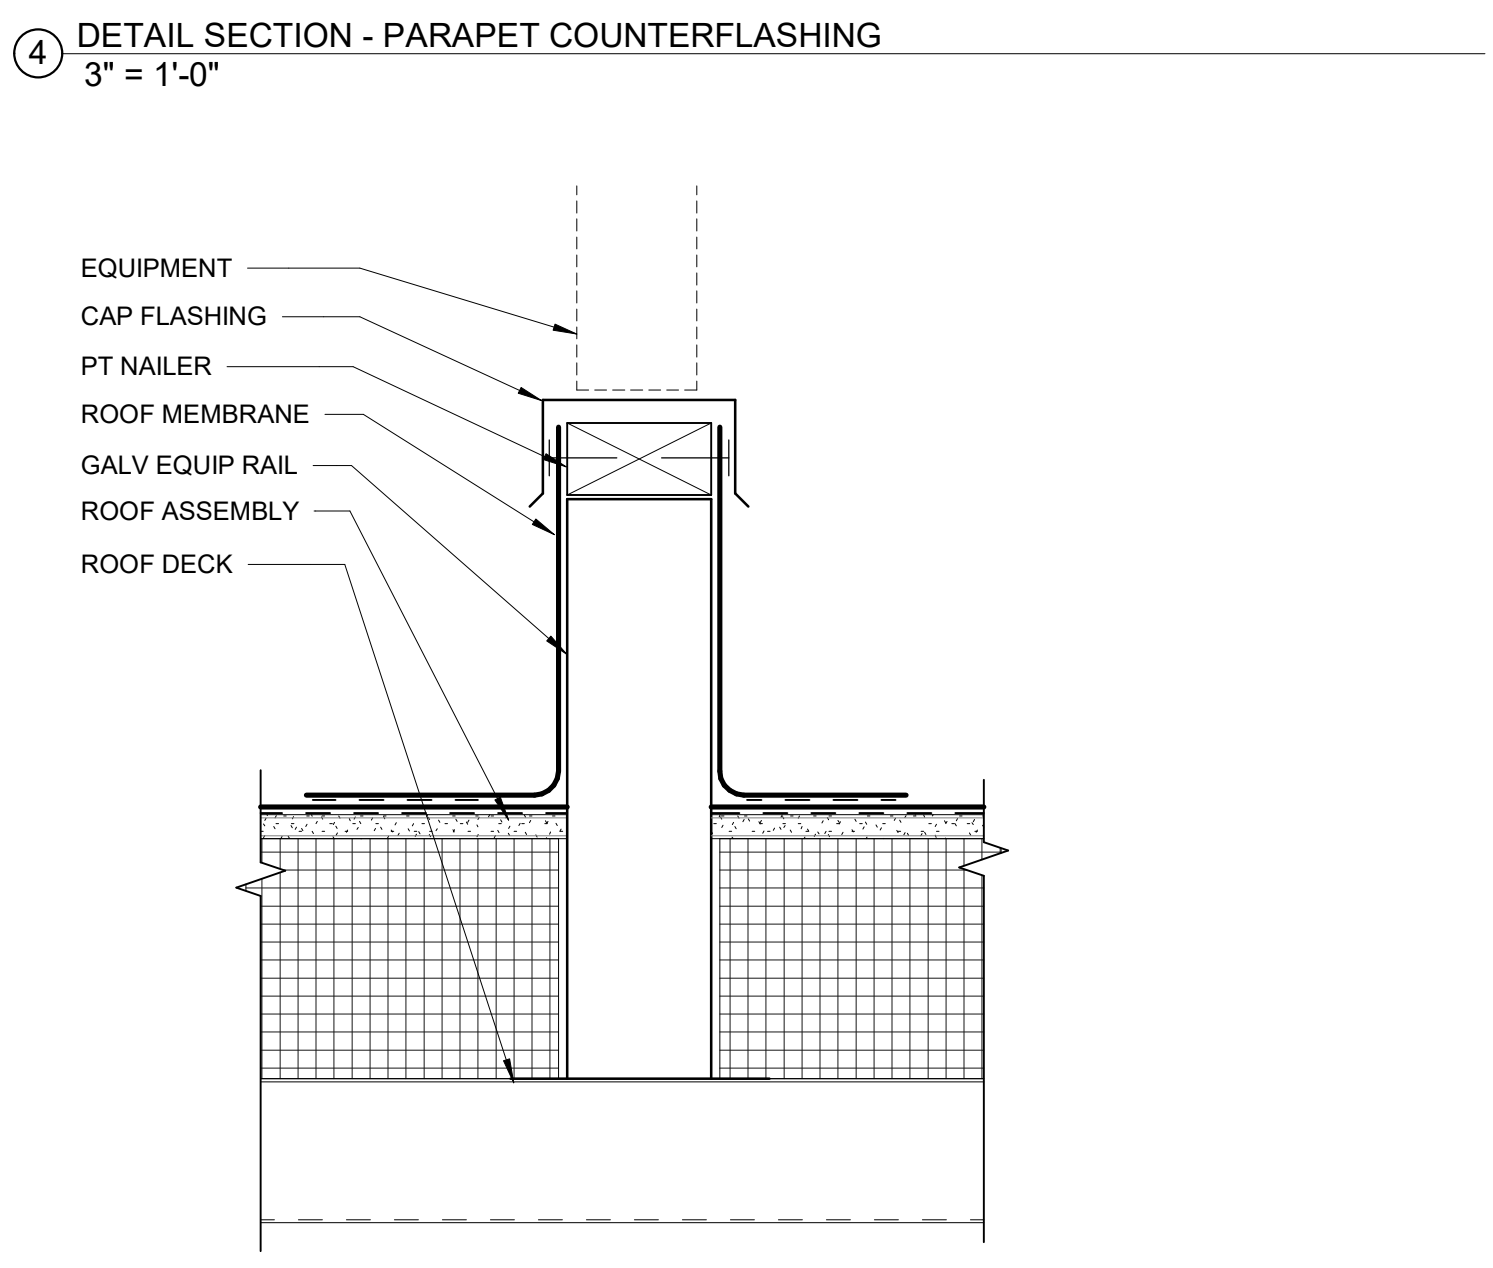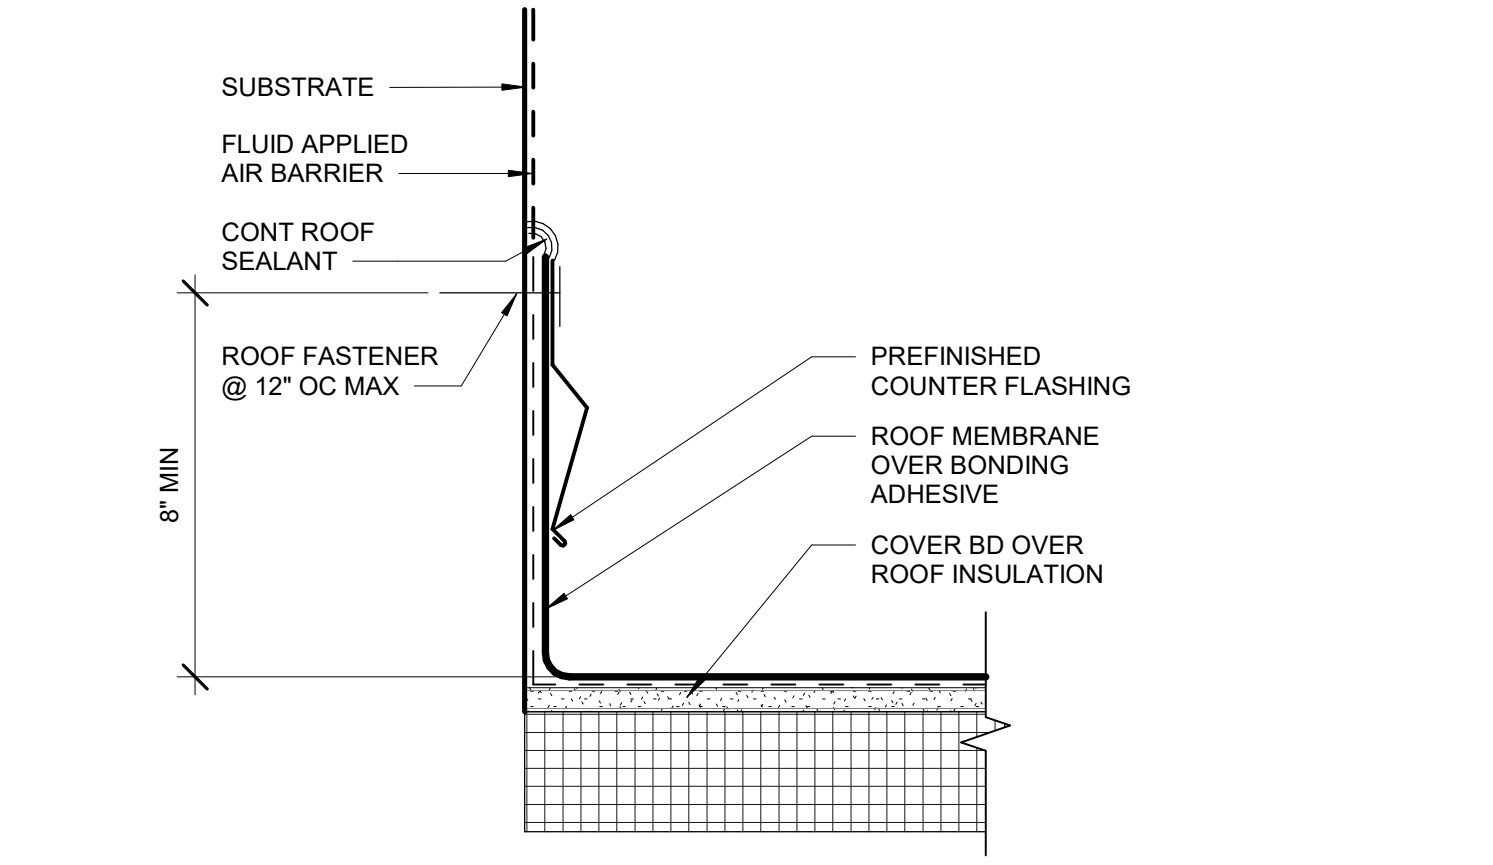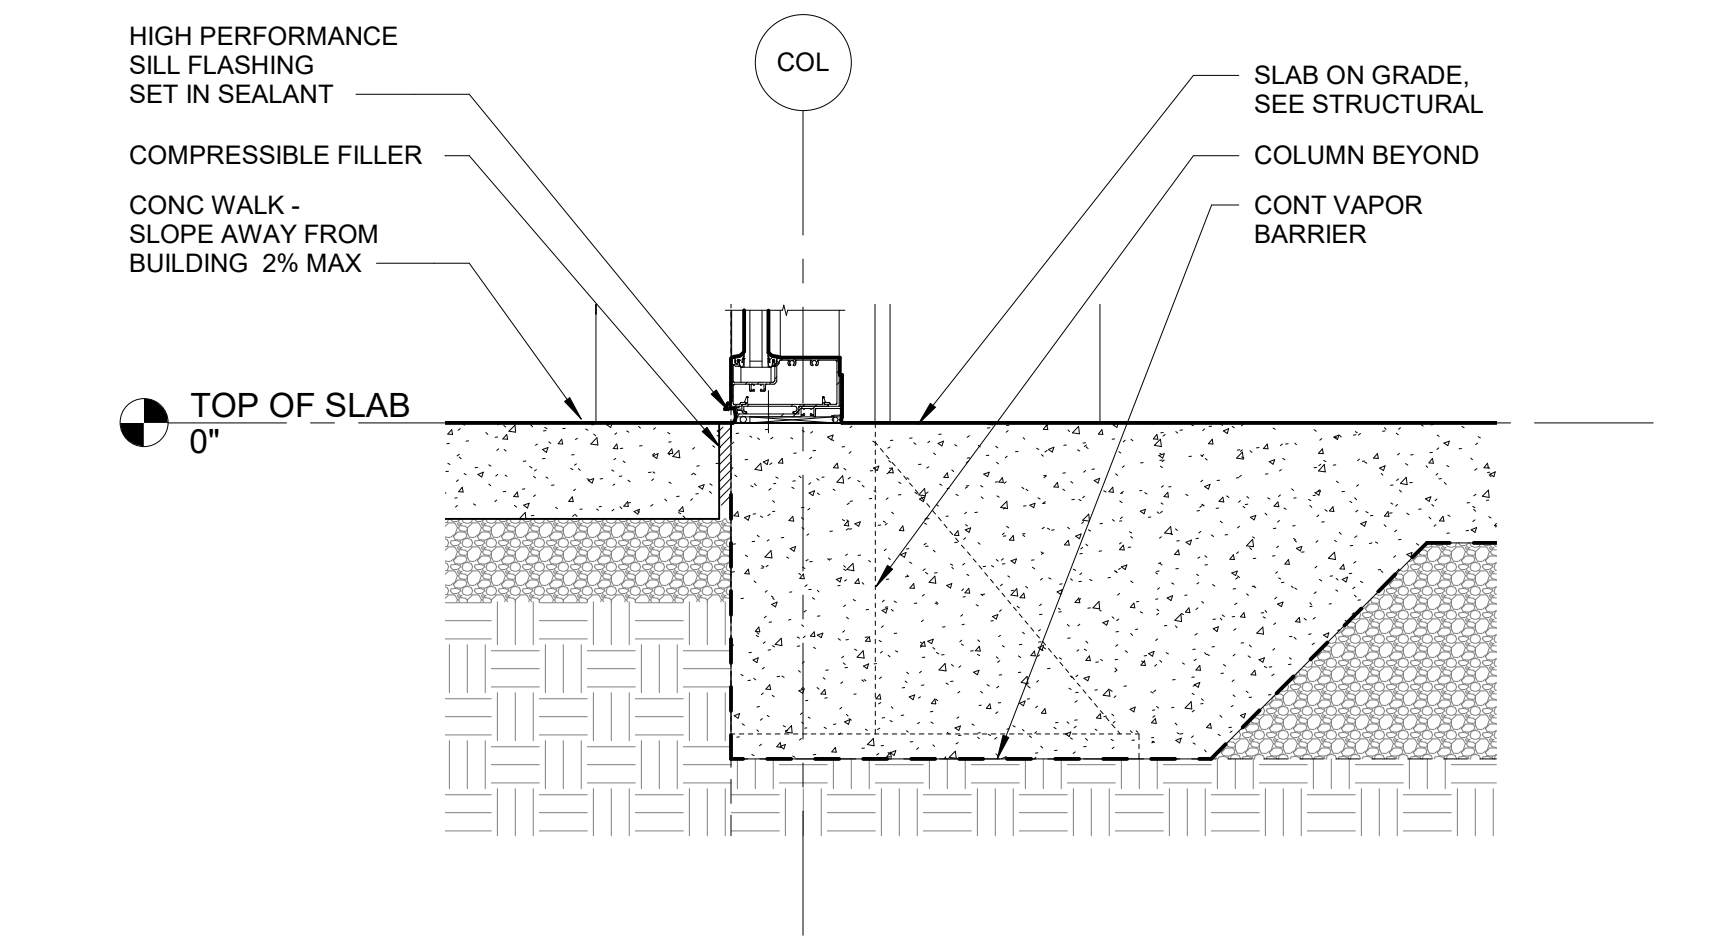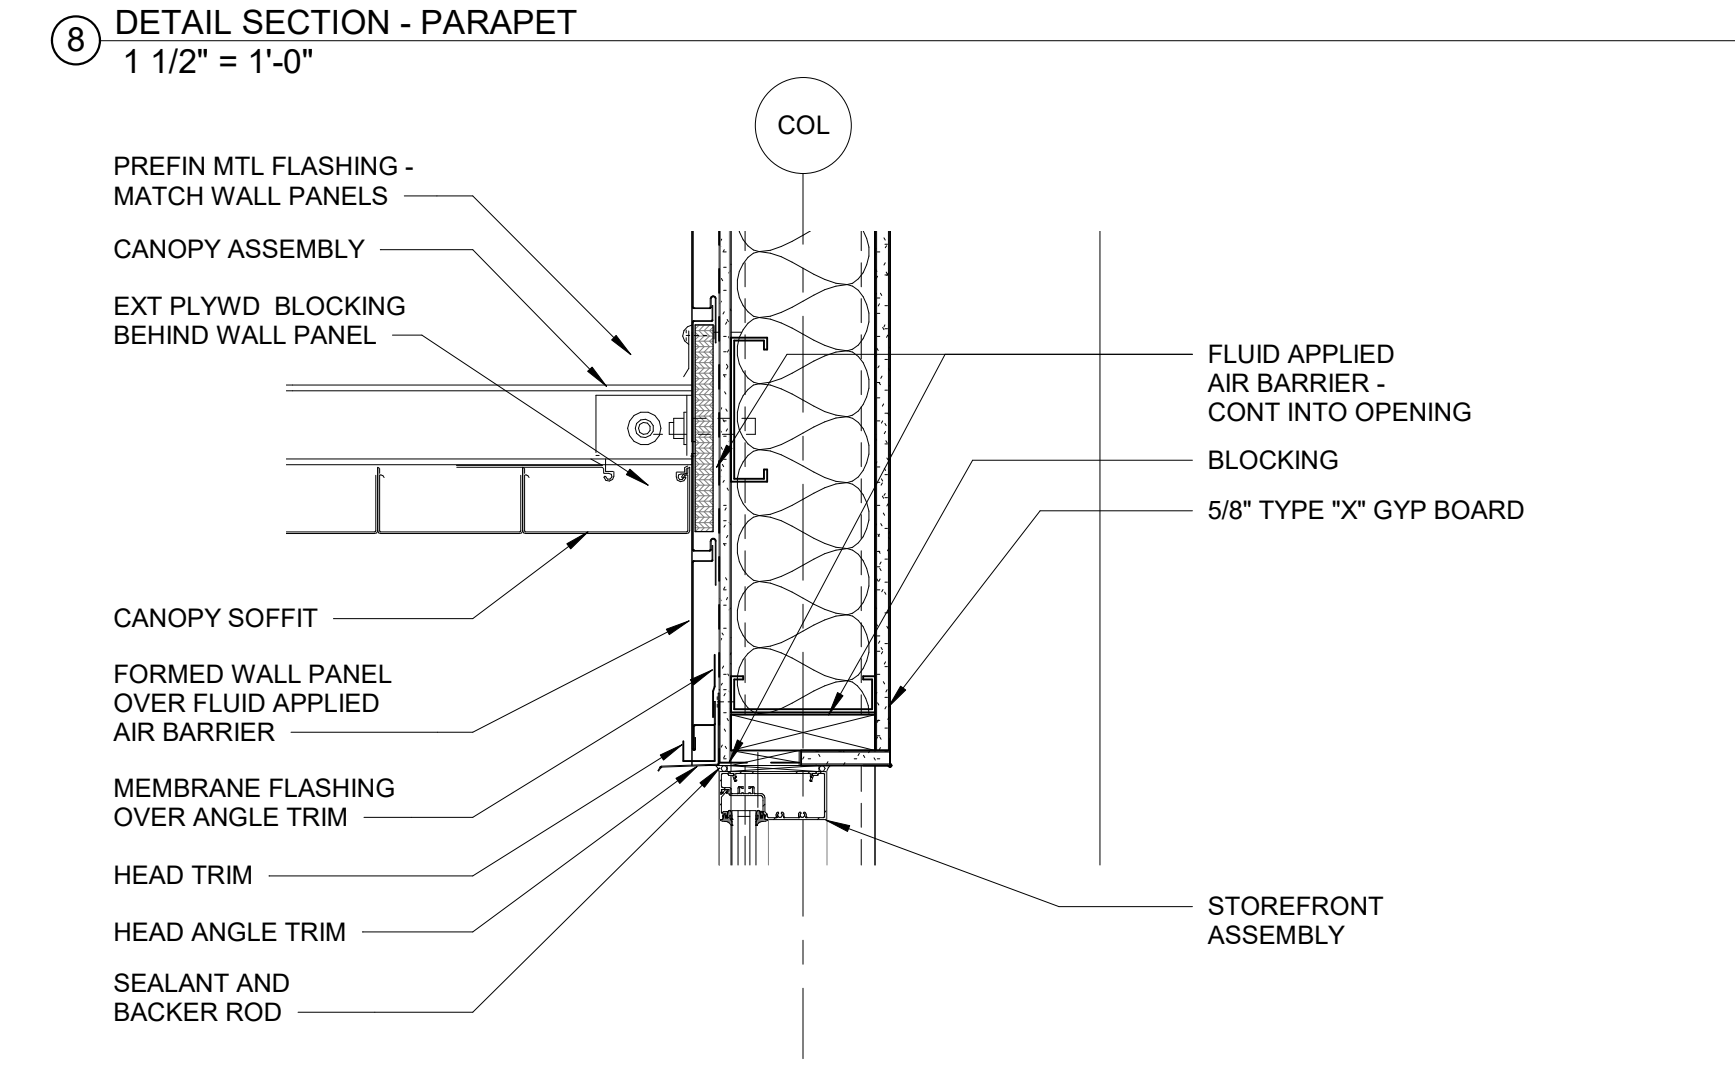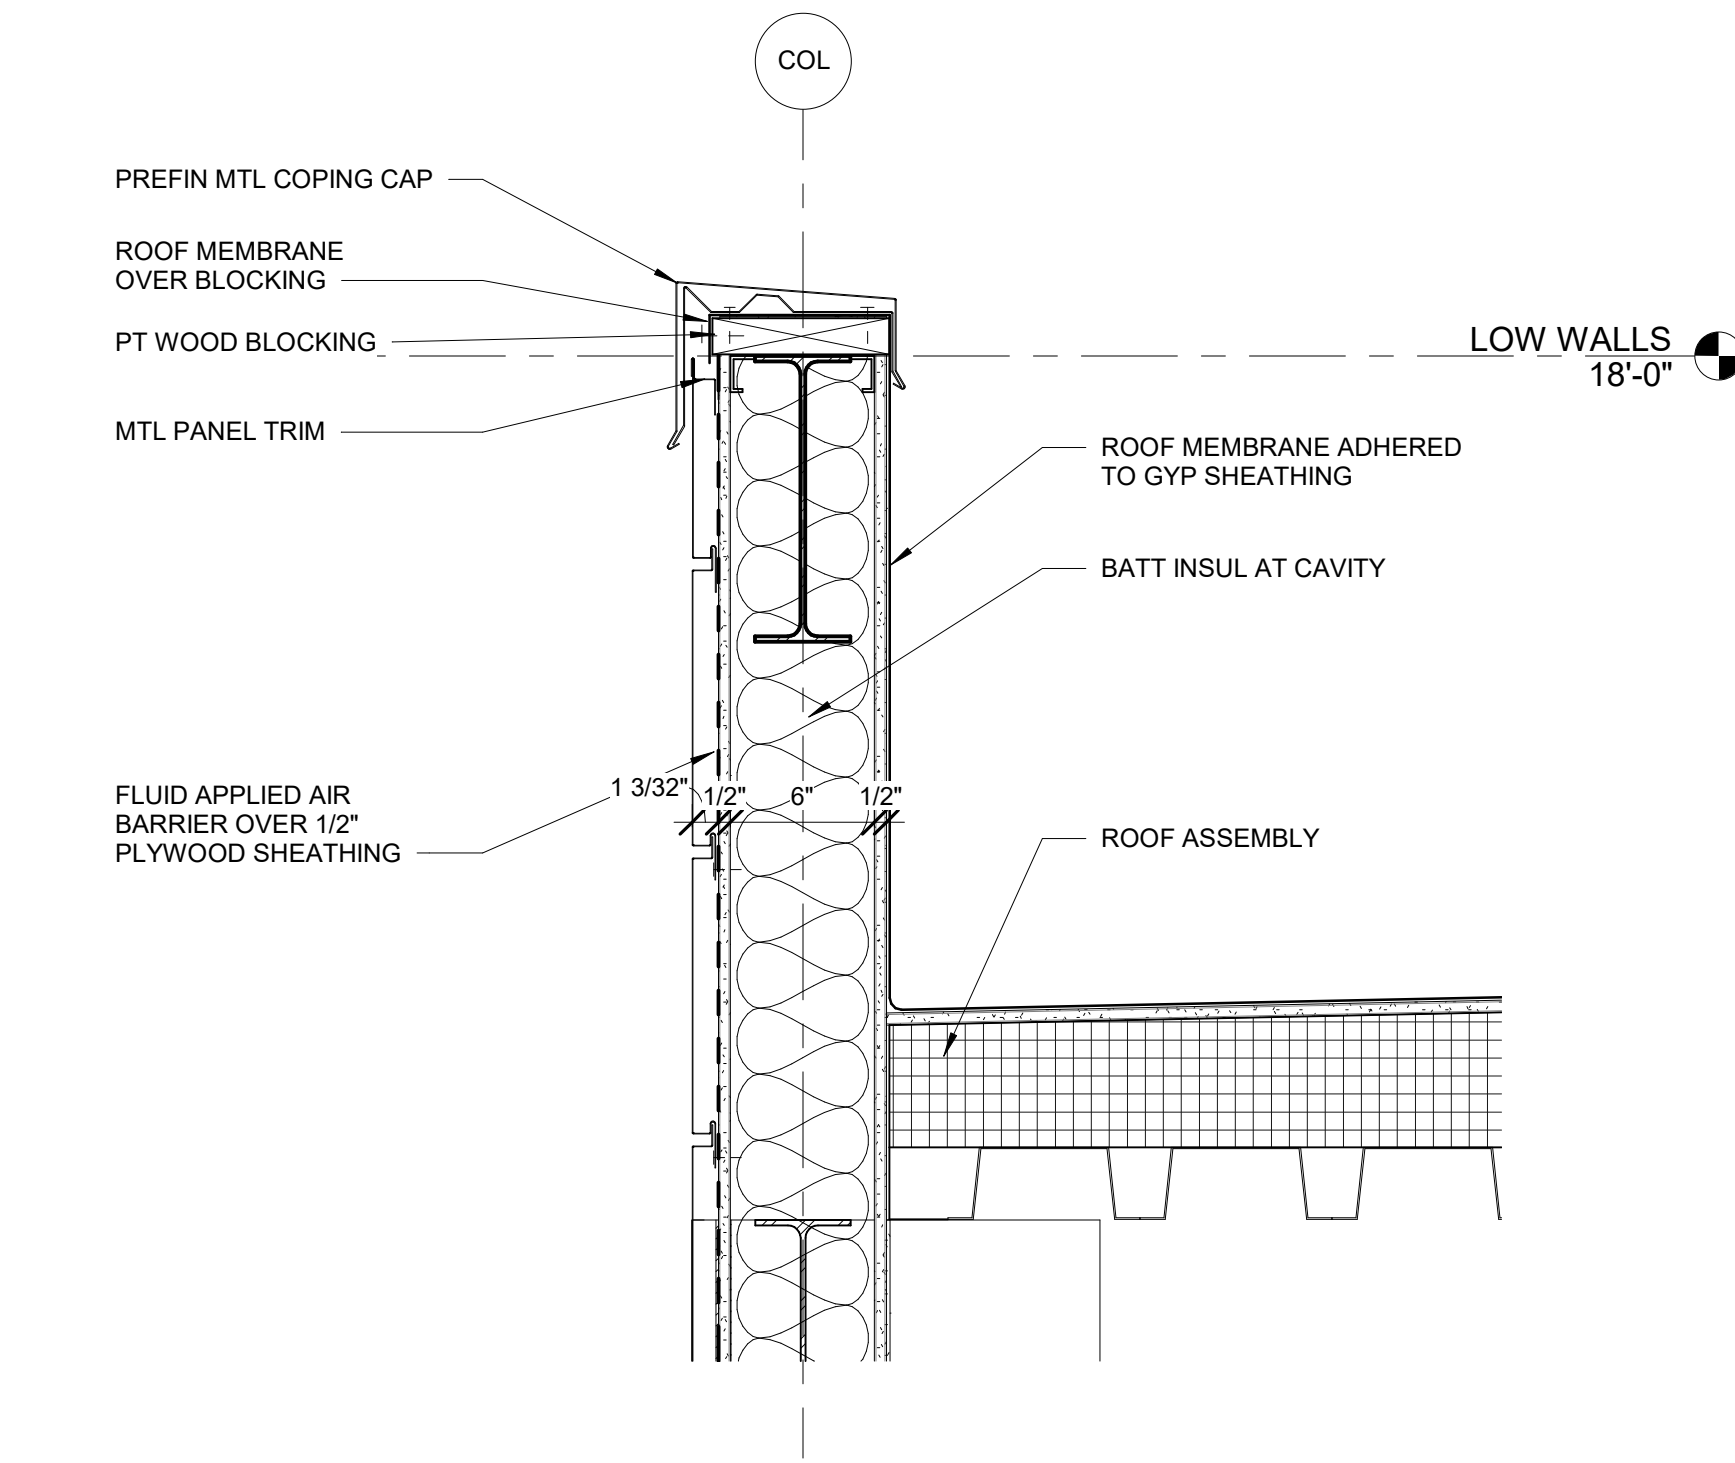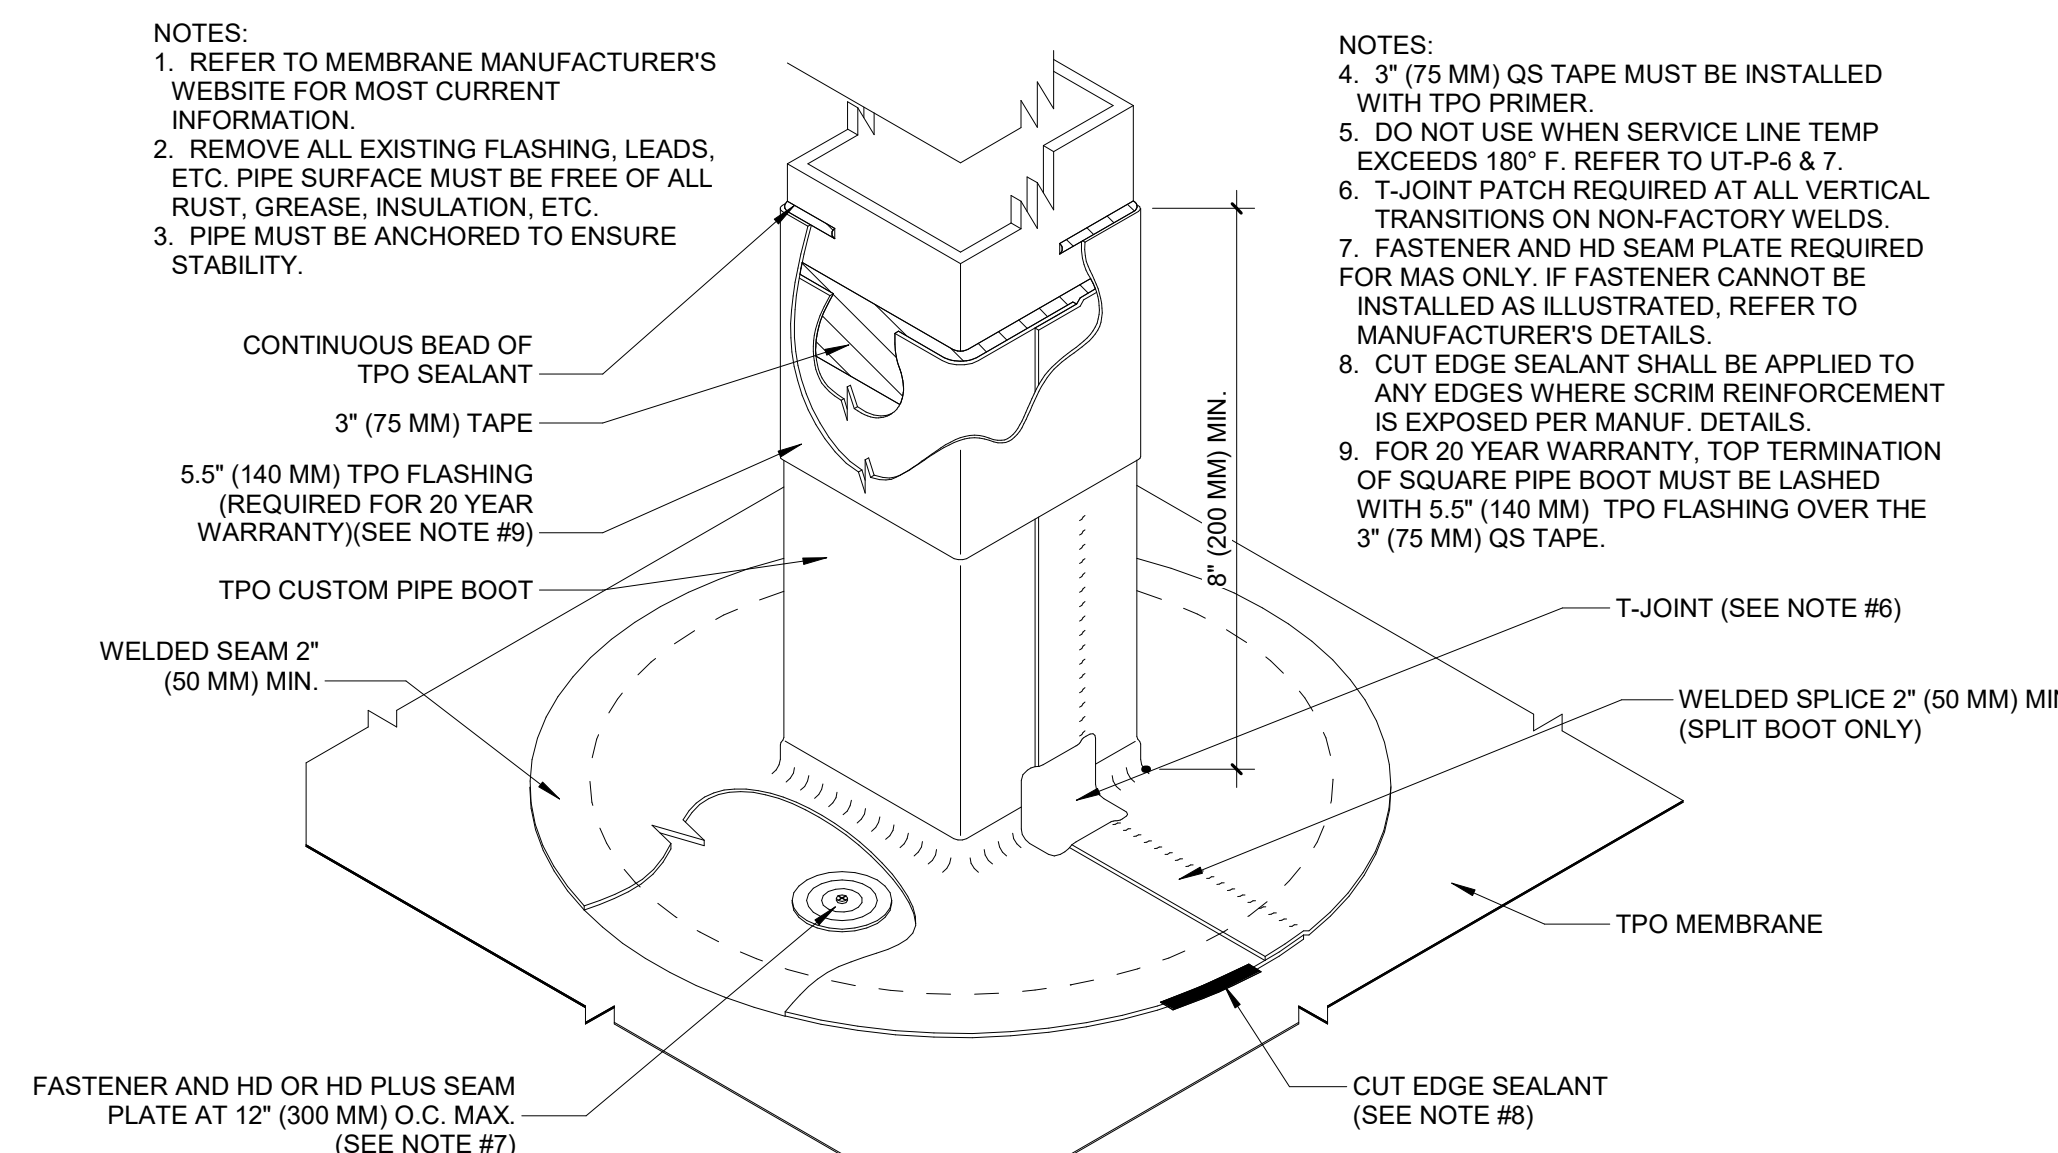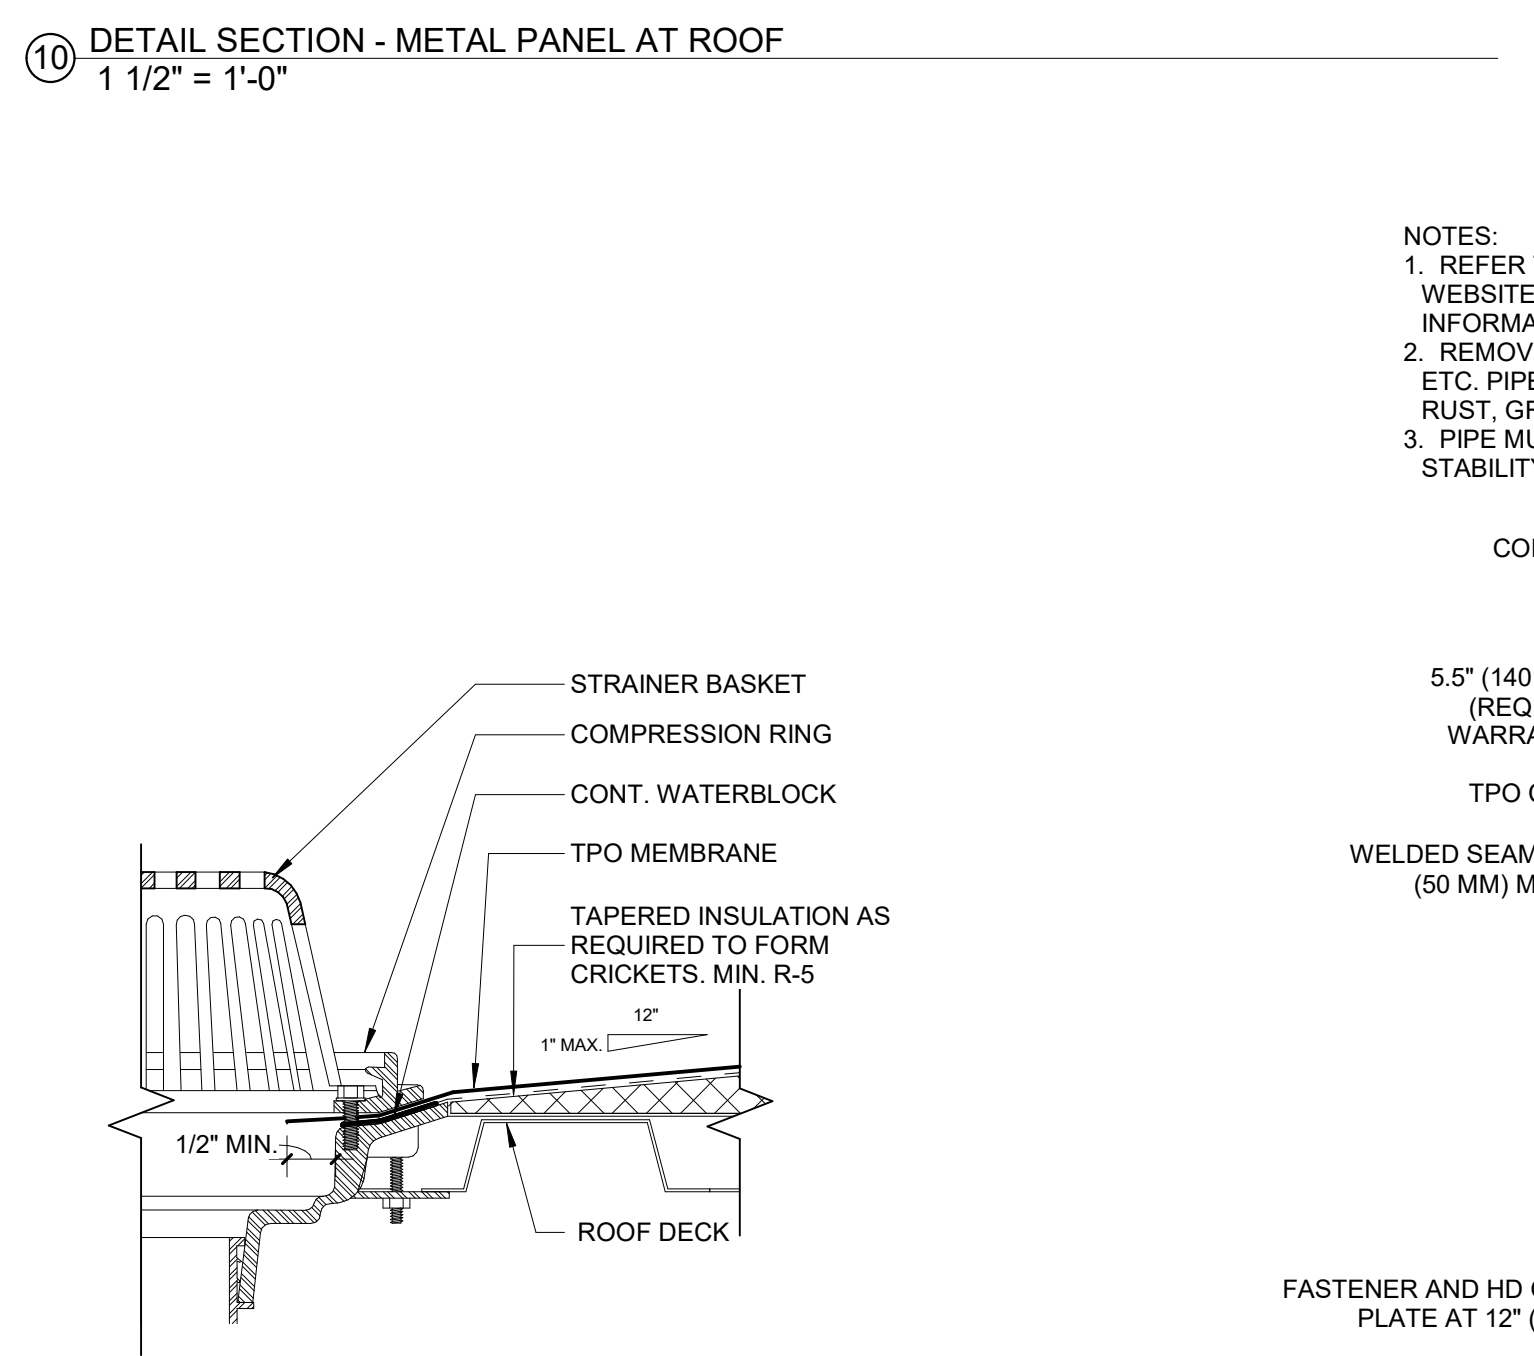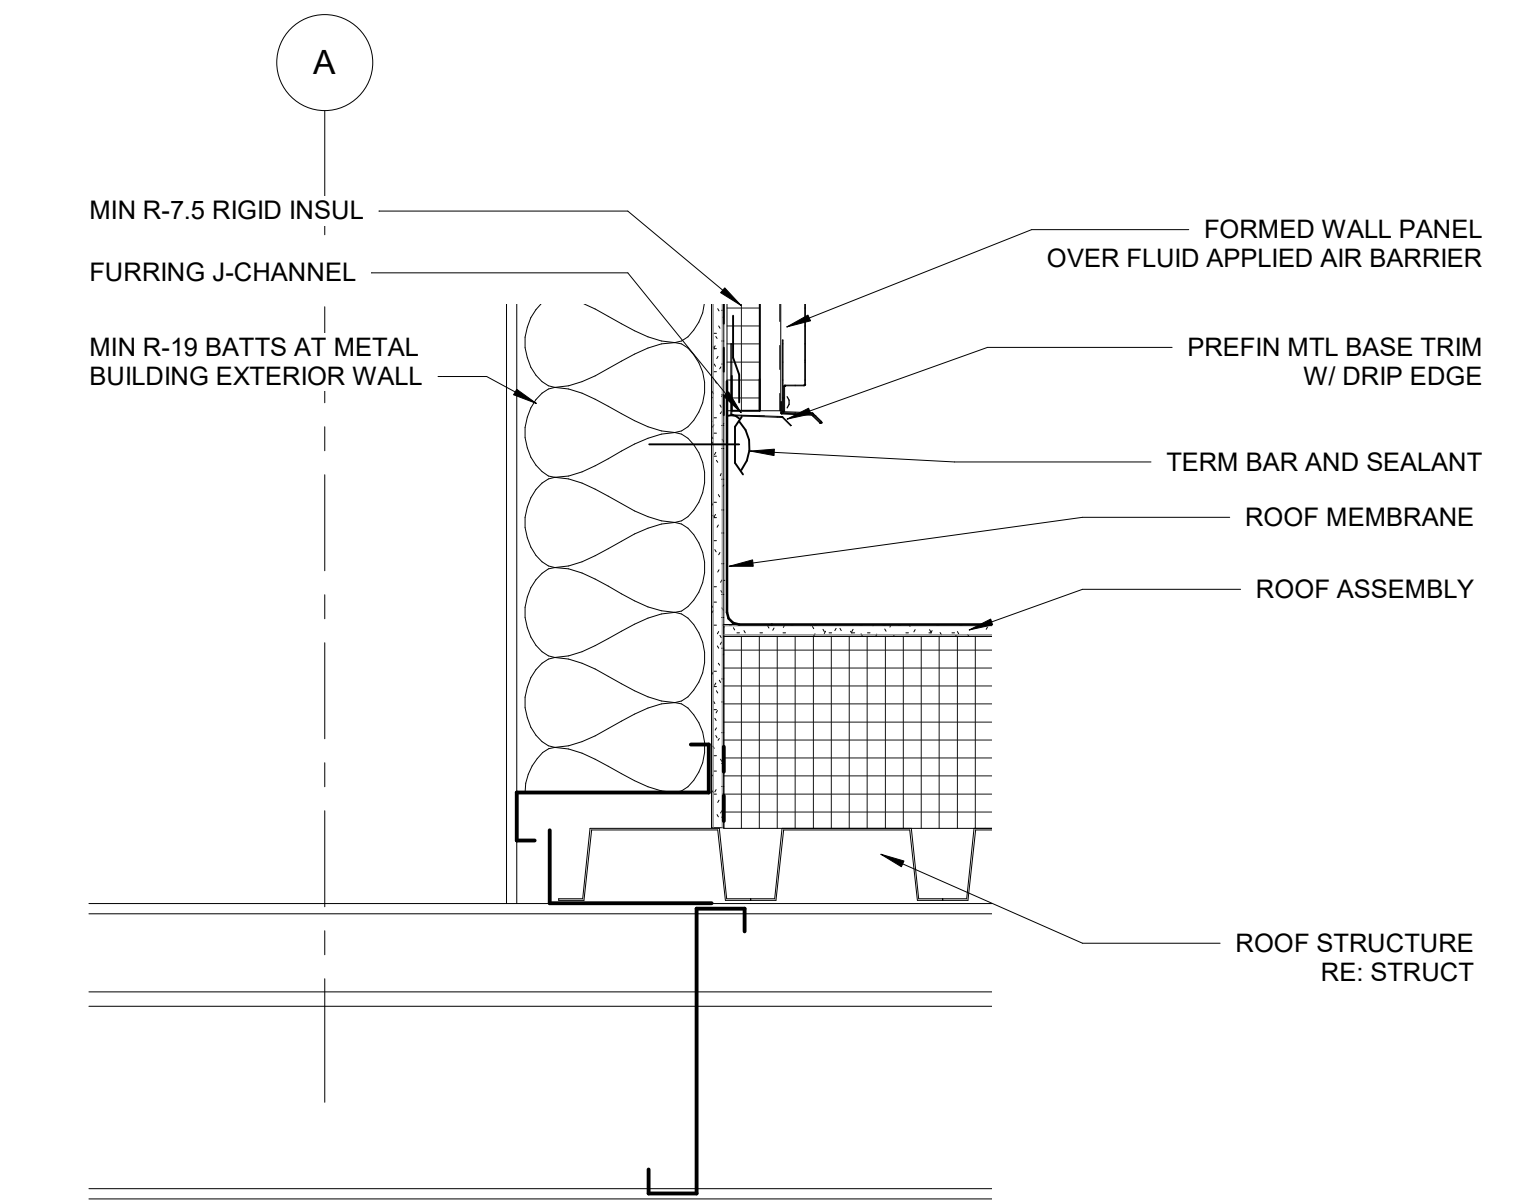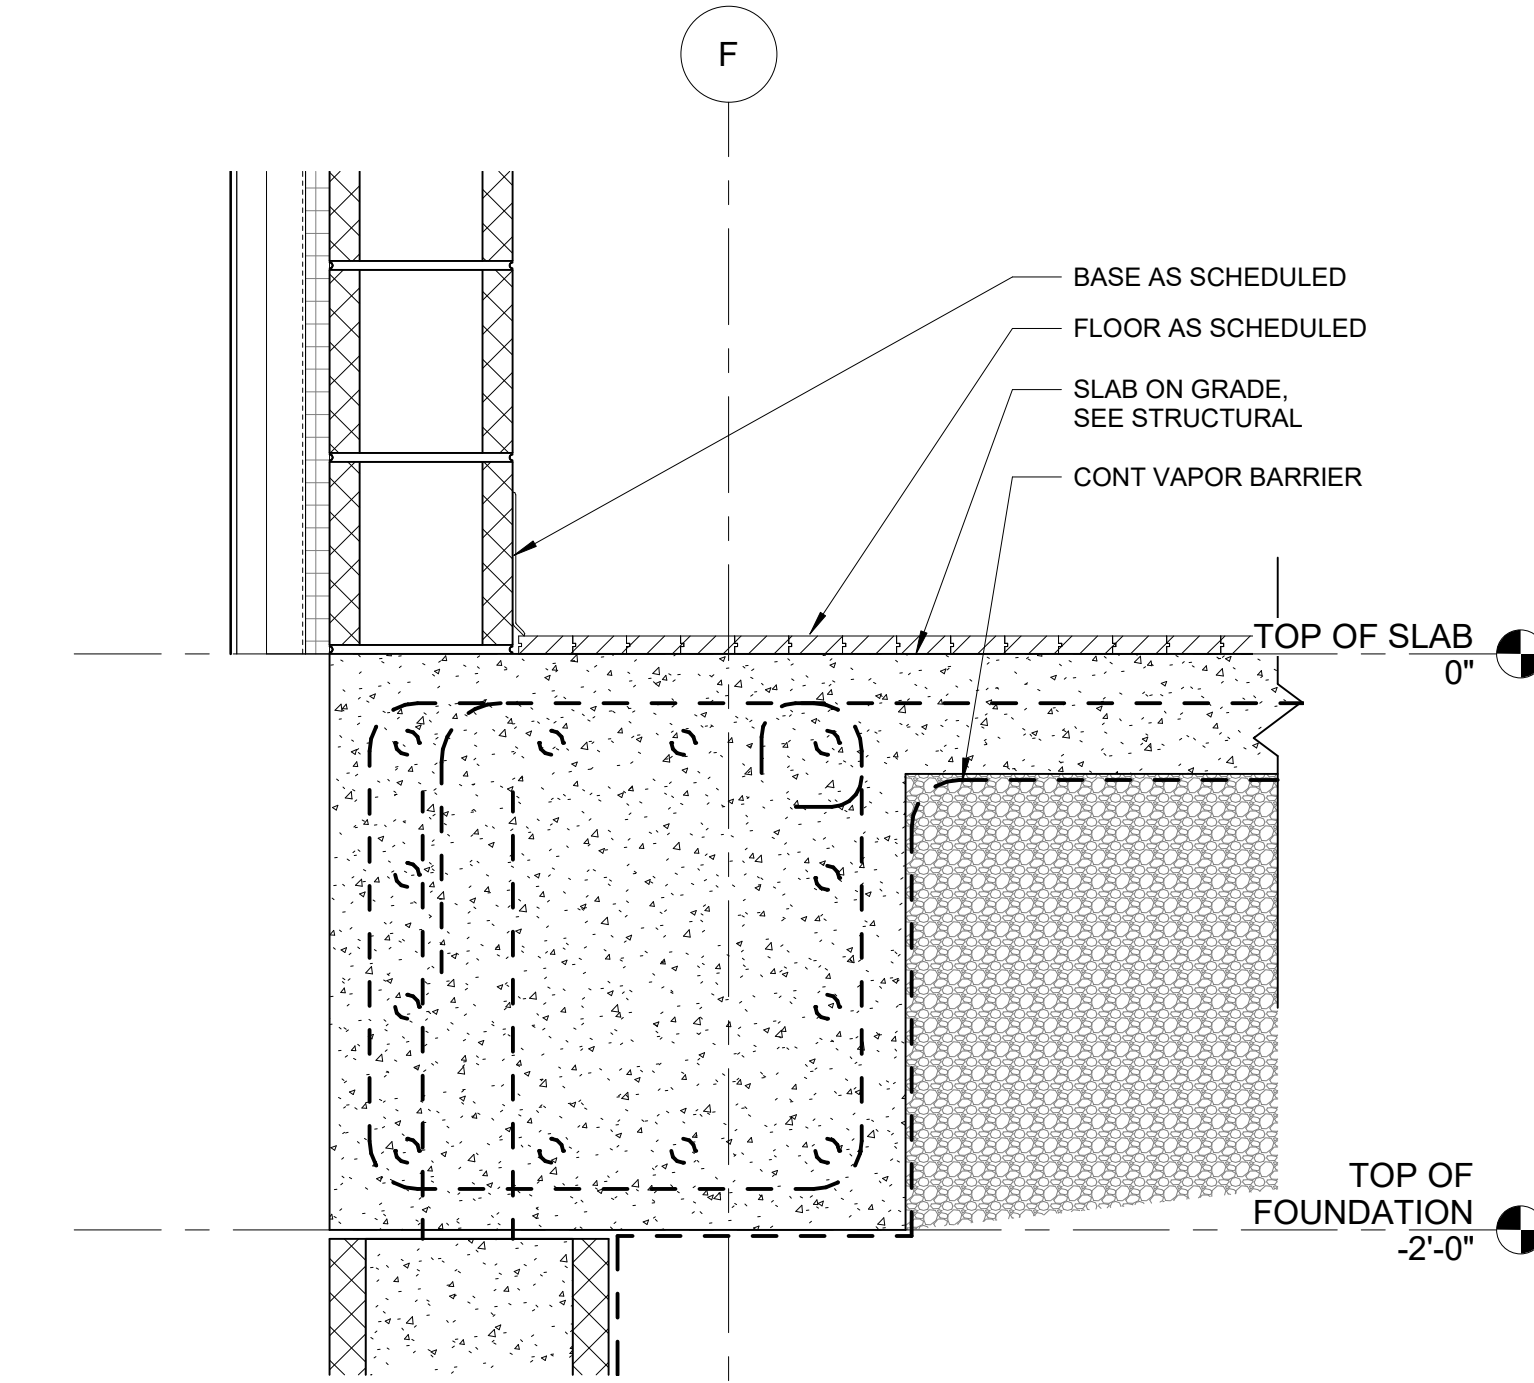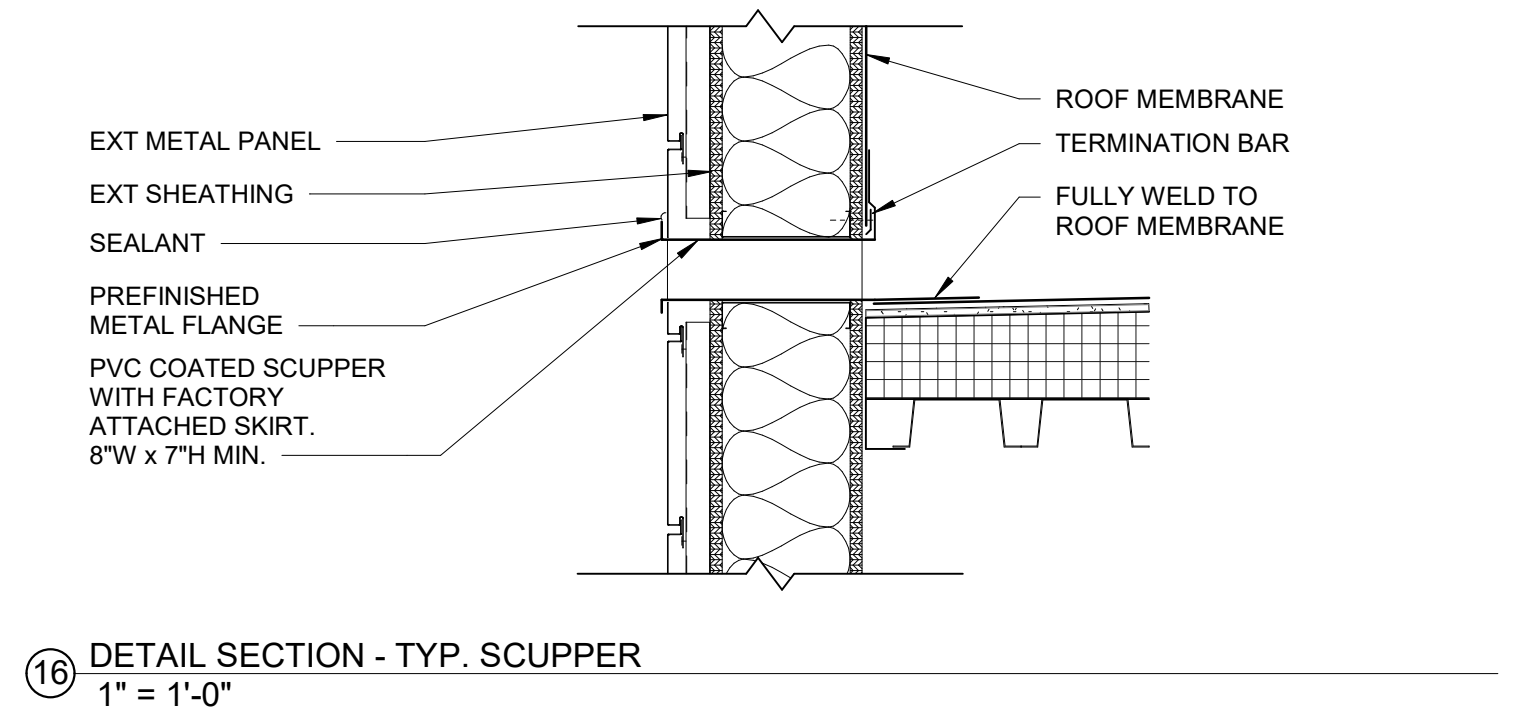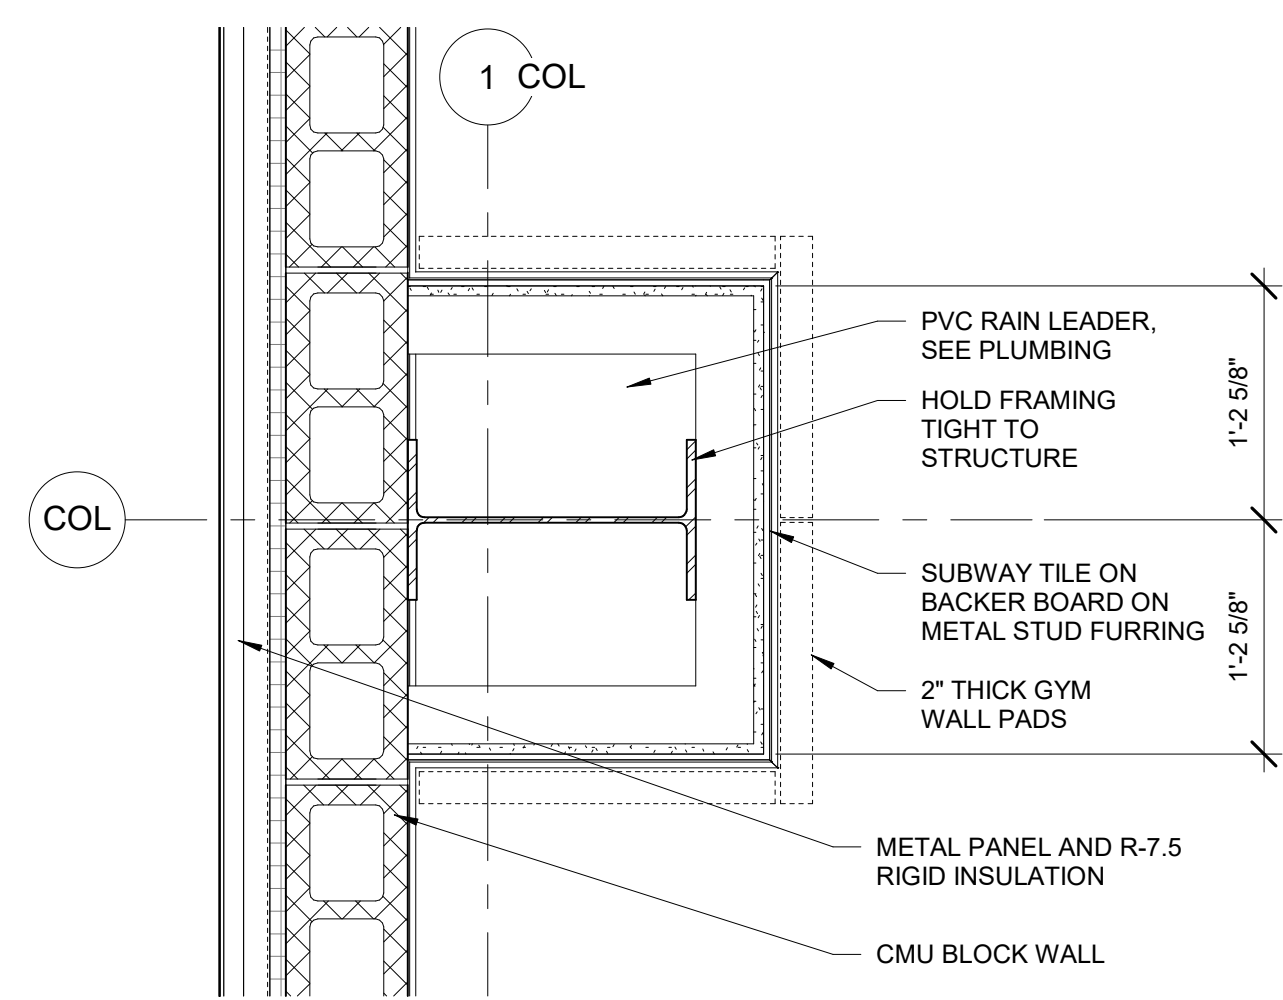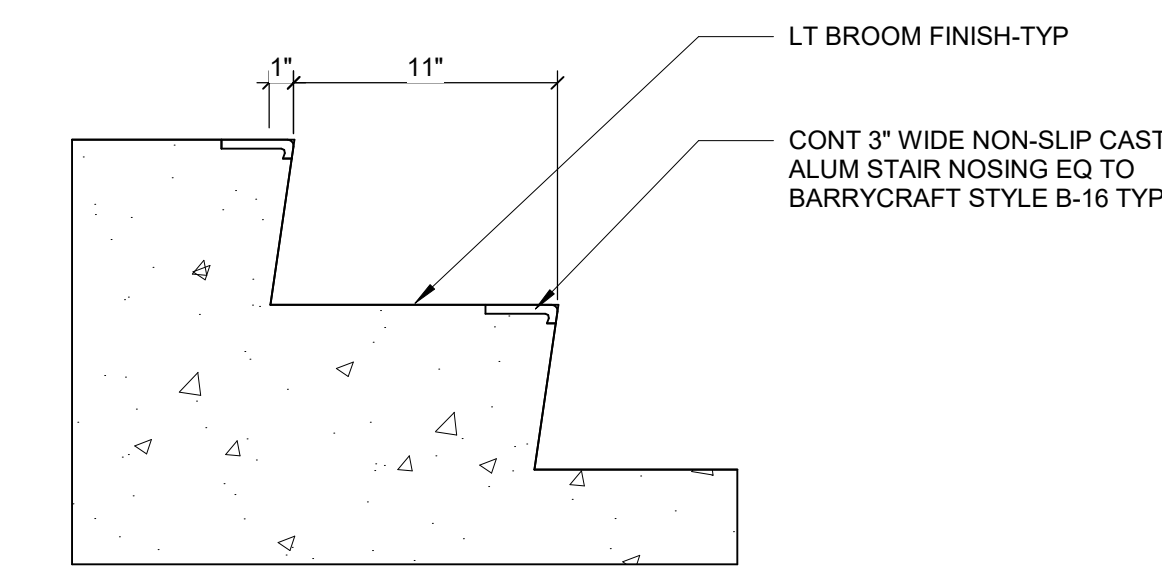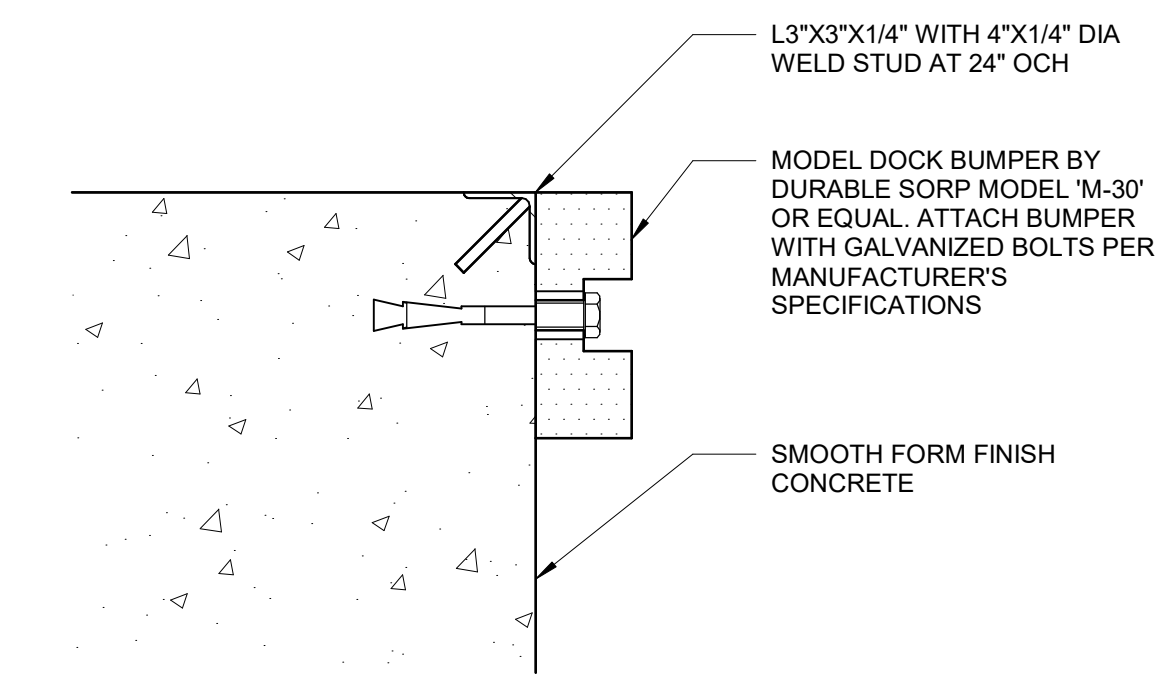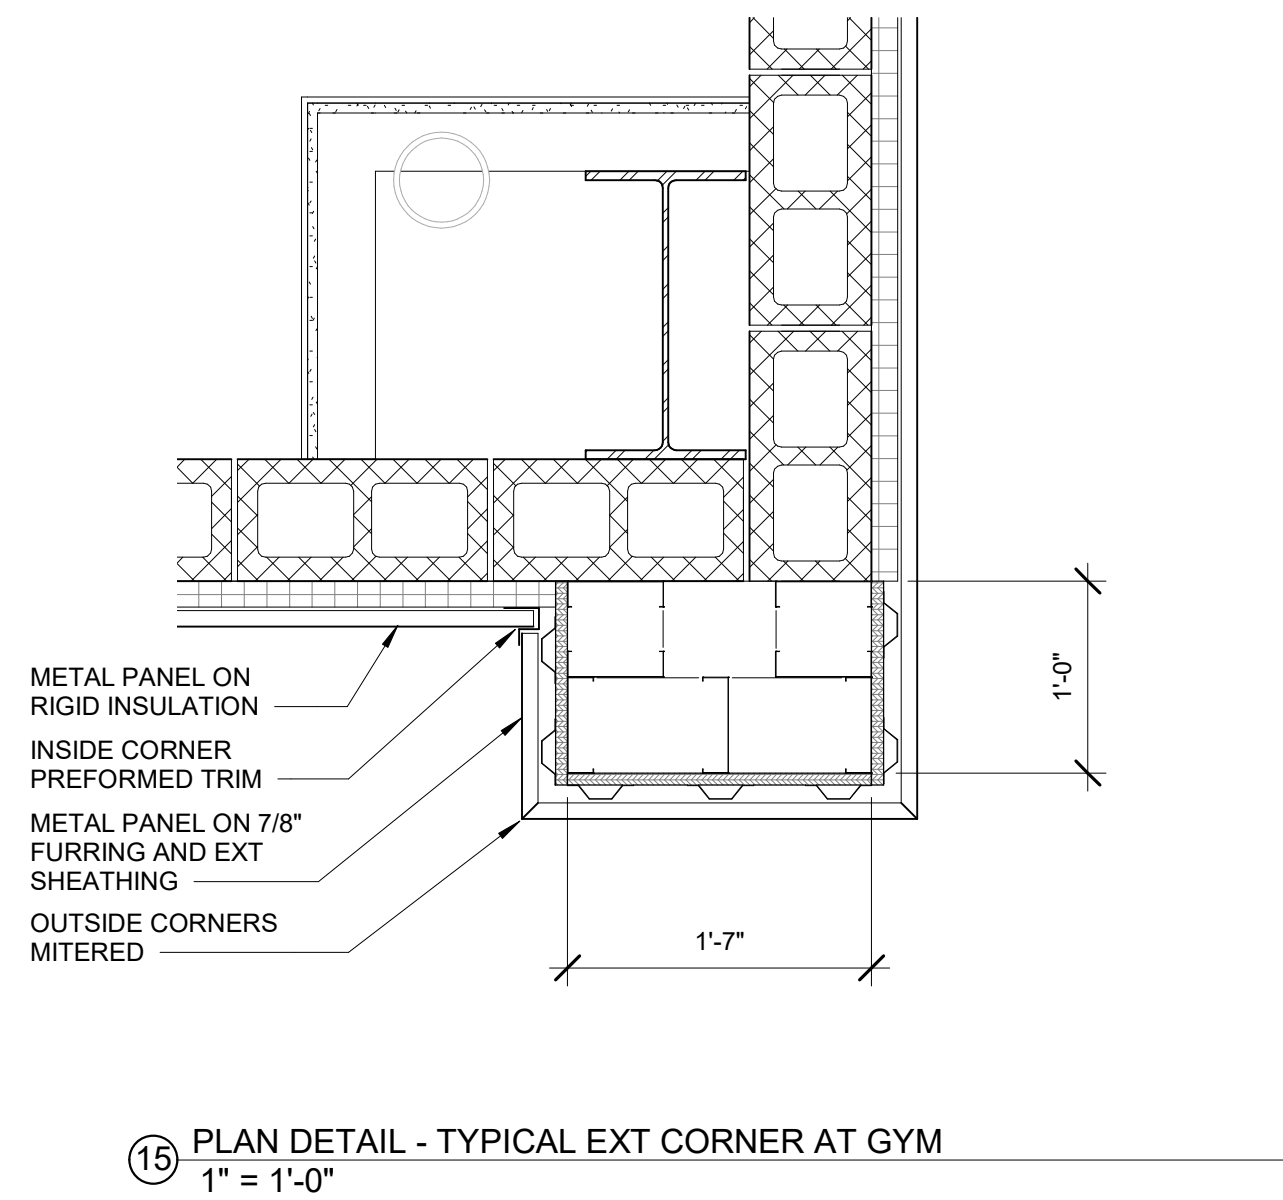

MARTIN LUTHER KING JR. RECREATION CENTER
705 14TH COURT EAST
PANAMA CITY, FL 32401

JOB NUMBER:
21109


DATE:
05/18/2023

PRINTED / REVISIONS
DESCRIPTION DATE


SHEET TITLE:
BUILDING DETAILS

SHEET NUMBER:
A601


05/2023, 10/23 REV. PANAMA CITY, ALABAMA CITY 36623-100 Panama City, AL - New Building - Scheme 2 of 4
THIS DRAWING IS THE PROPERTY OF CCR ARCHITECTURE & INTERIORS AND IS NOT TO BE REPRODUCED, COPIED OR ALTERED IN WHOLE OR IN PART OR USED FOR ANY PURPOSE WITHOUT THE APPROVAL OF CCR ARCHITECTURE & INTERIORS AND IS TO BE RETURNED UPON REQUEST.

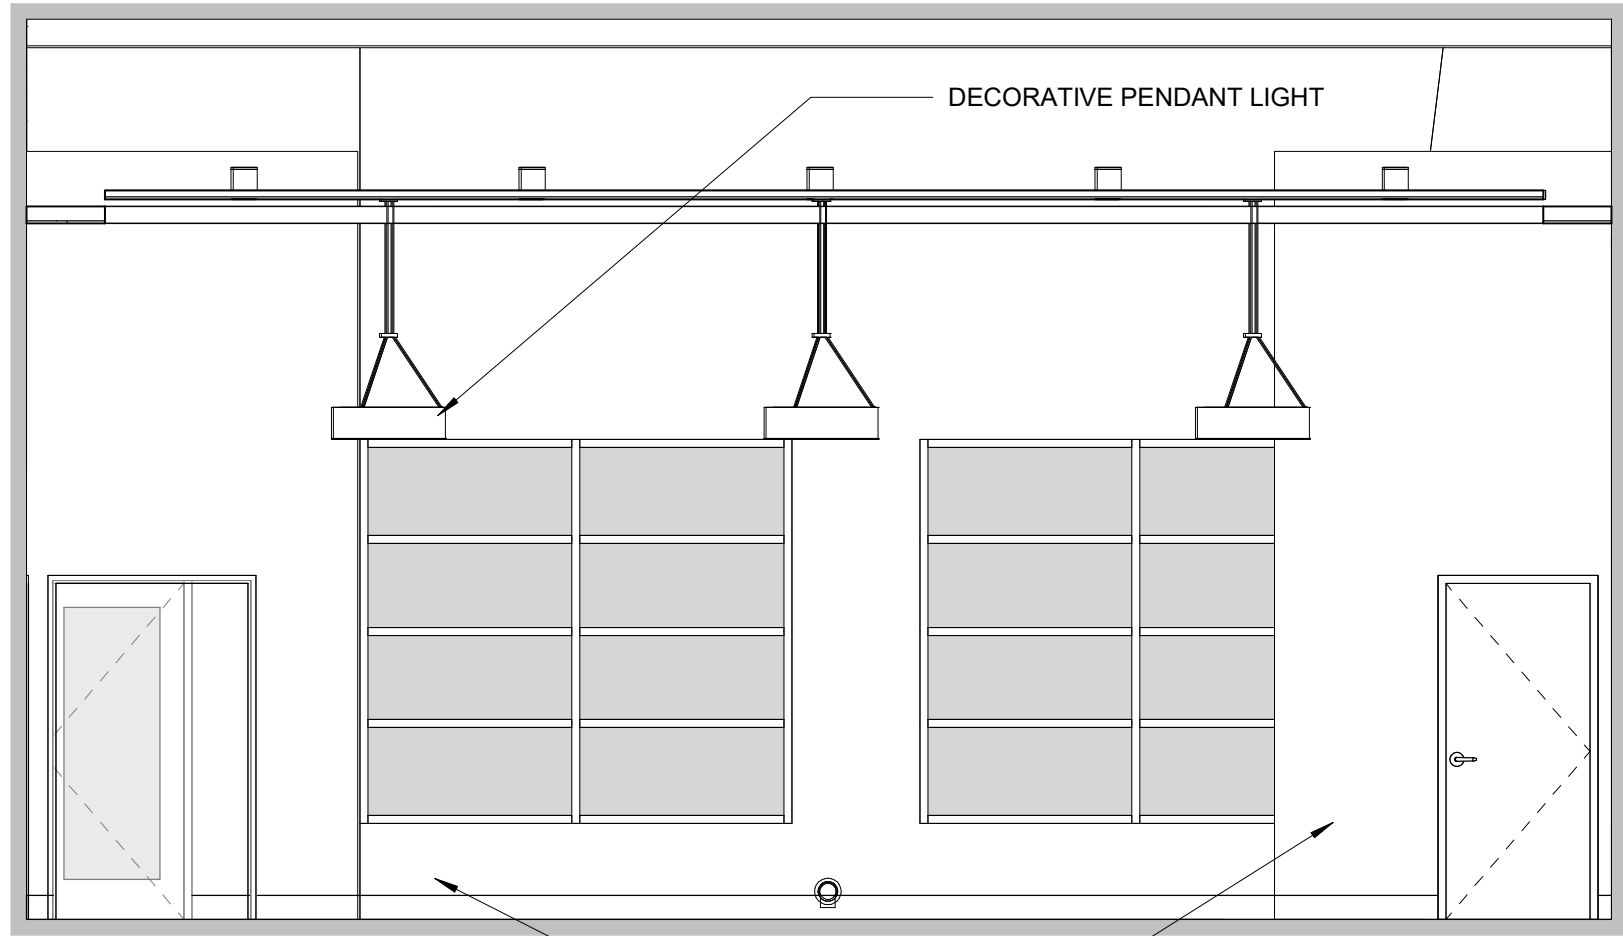


6 MULTI-PURPOSE
1/4" = 1'-0"

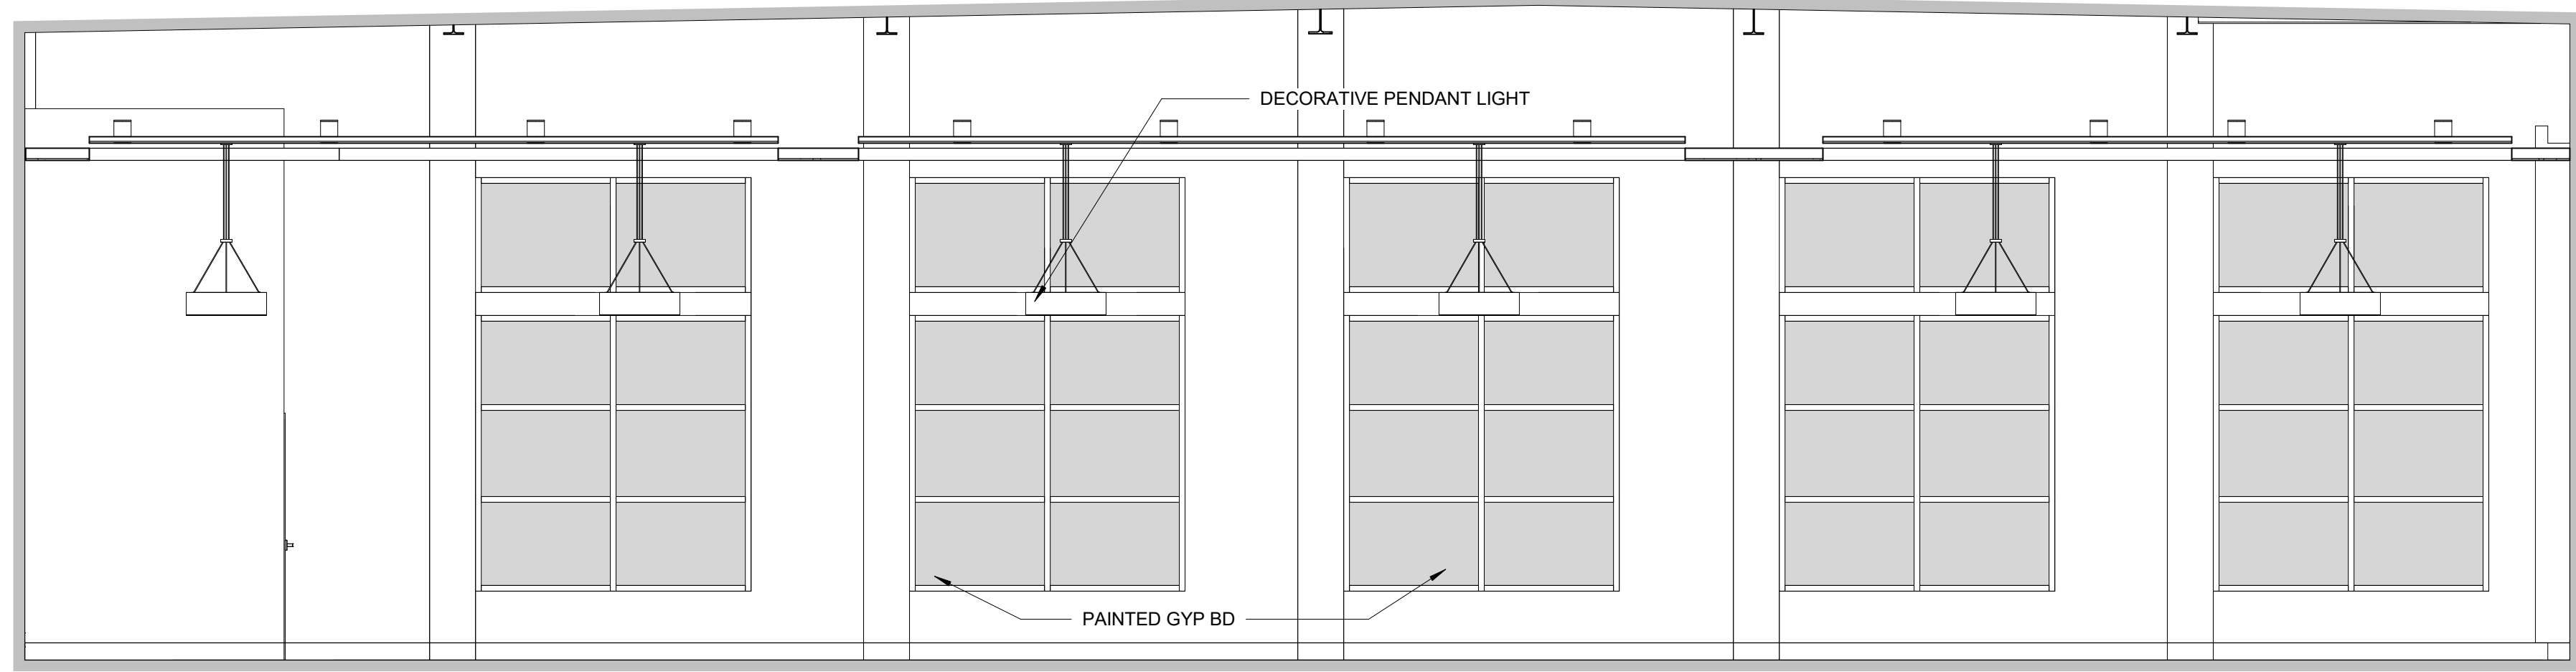


7 MULTI-PURPOSE
1/4" = 1'-0"

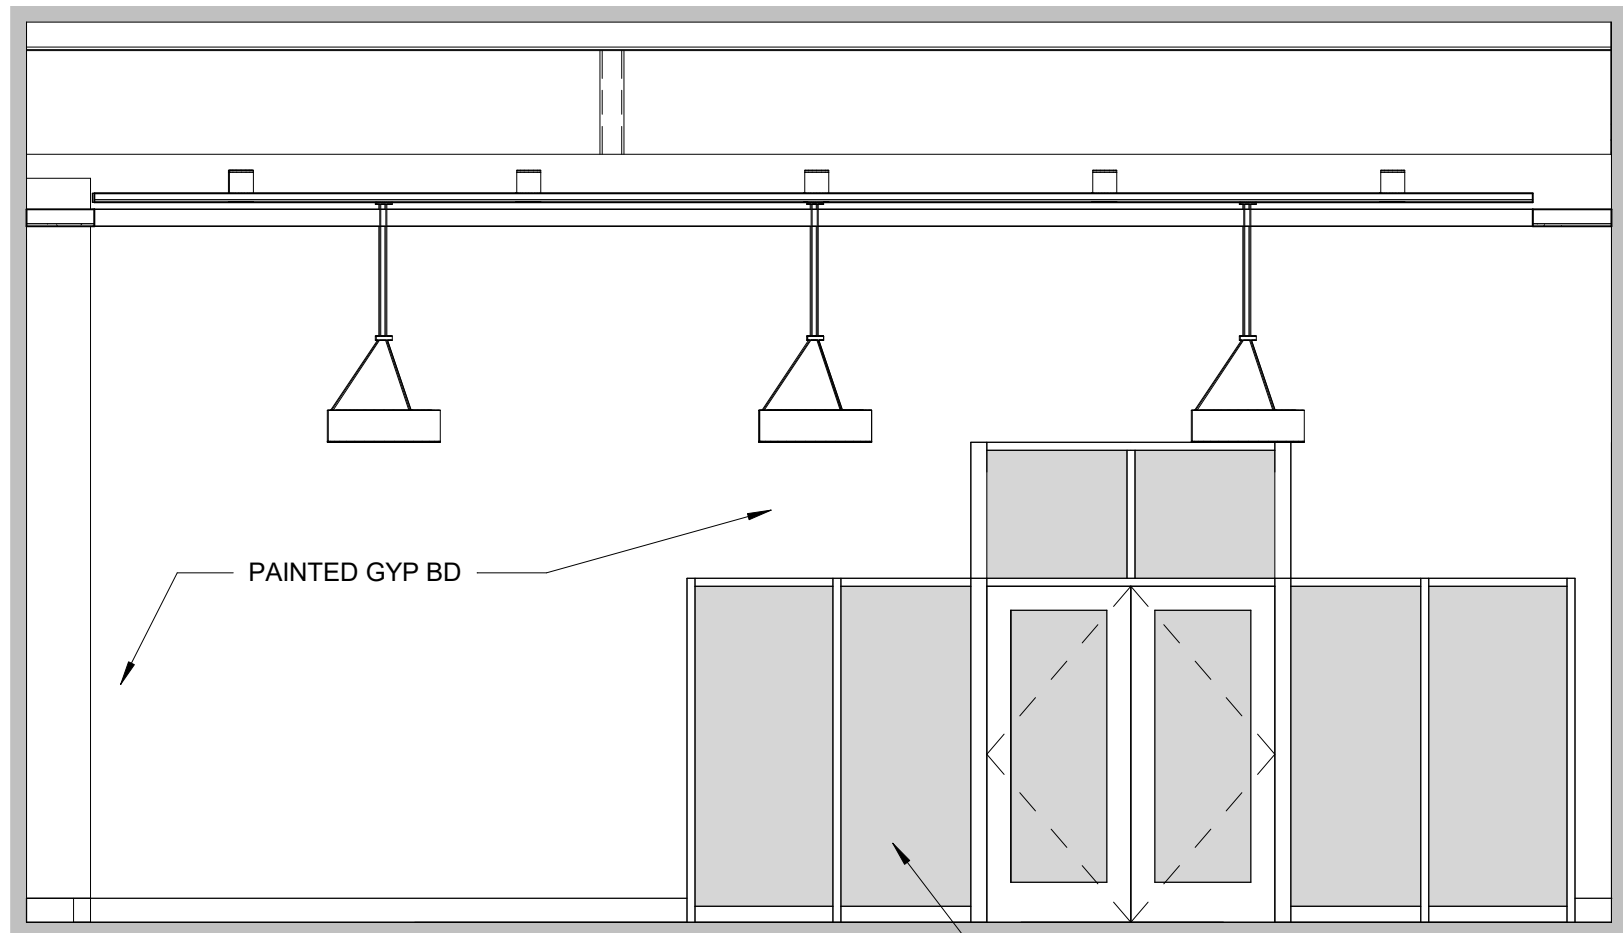


6 MULTI-PURPOSE
1/4" = 1'-0"

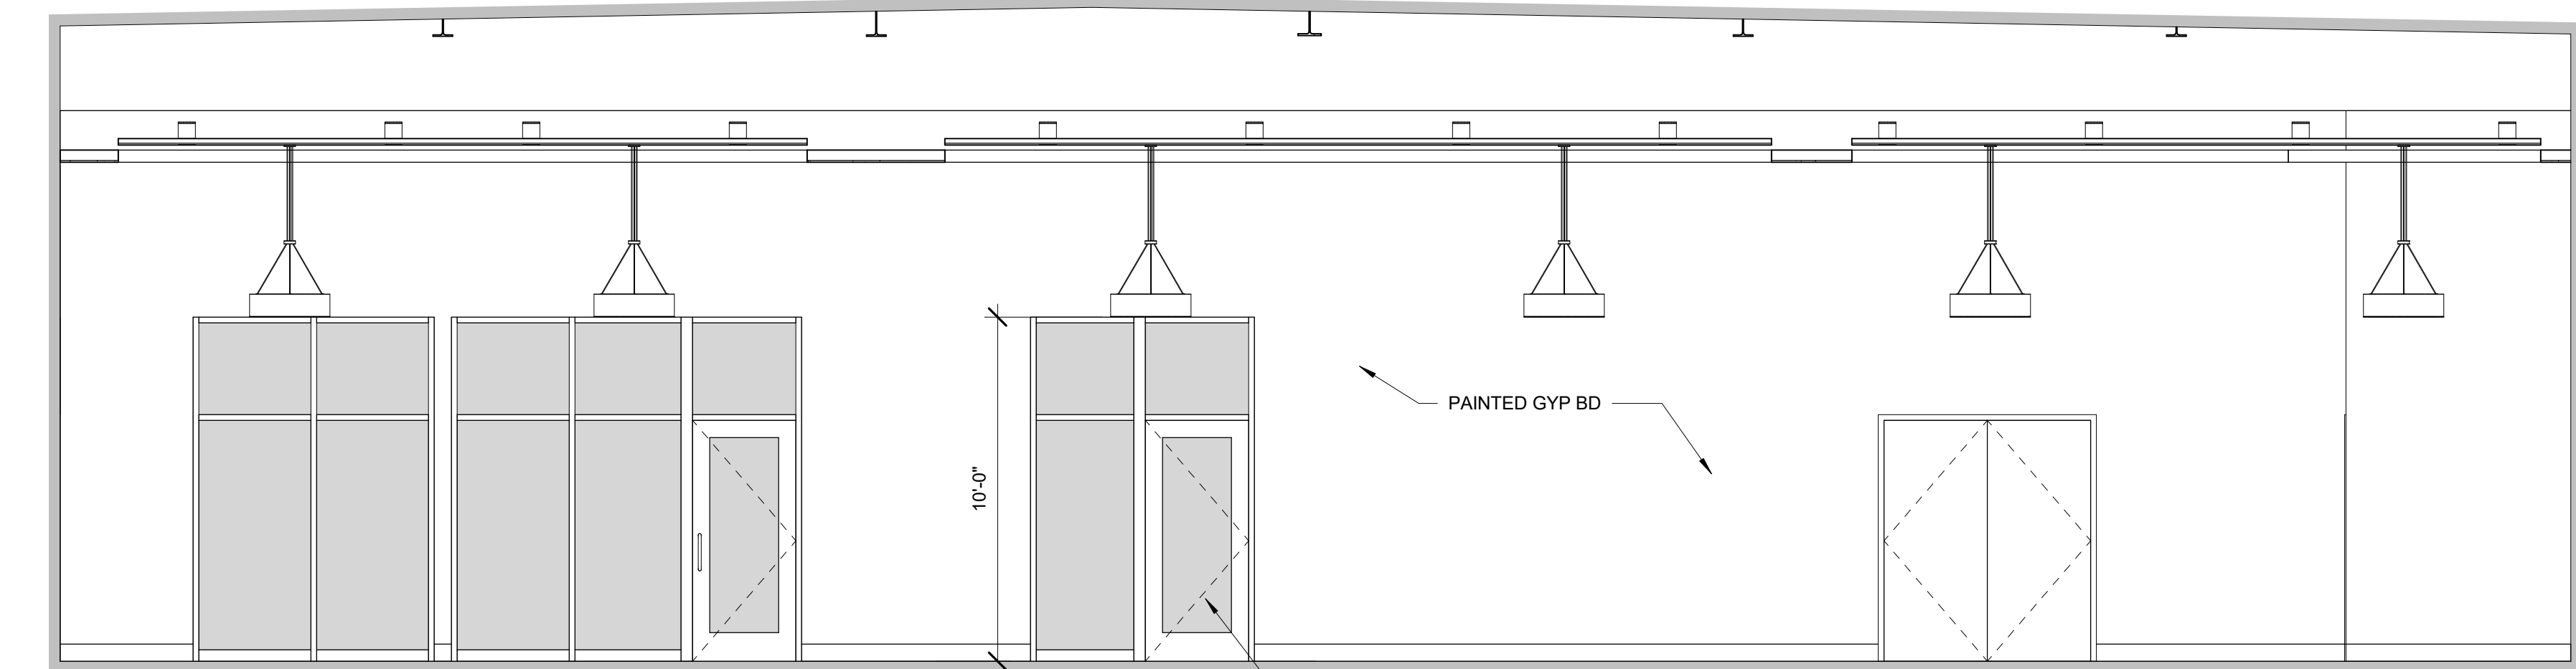


5 MULTI-PURPOSE
1/4" = 1'-0"

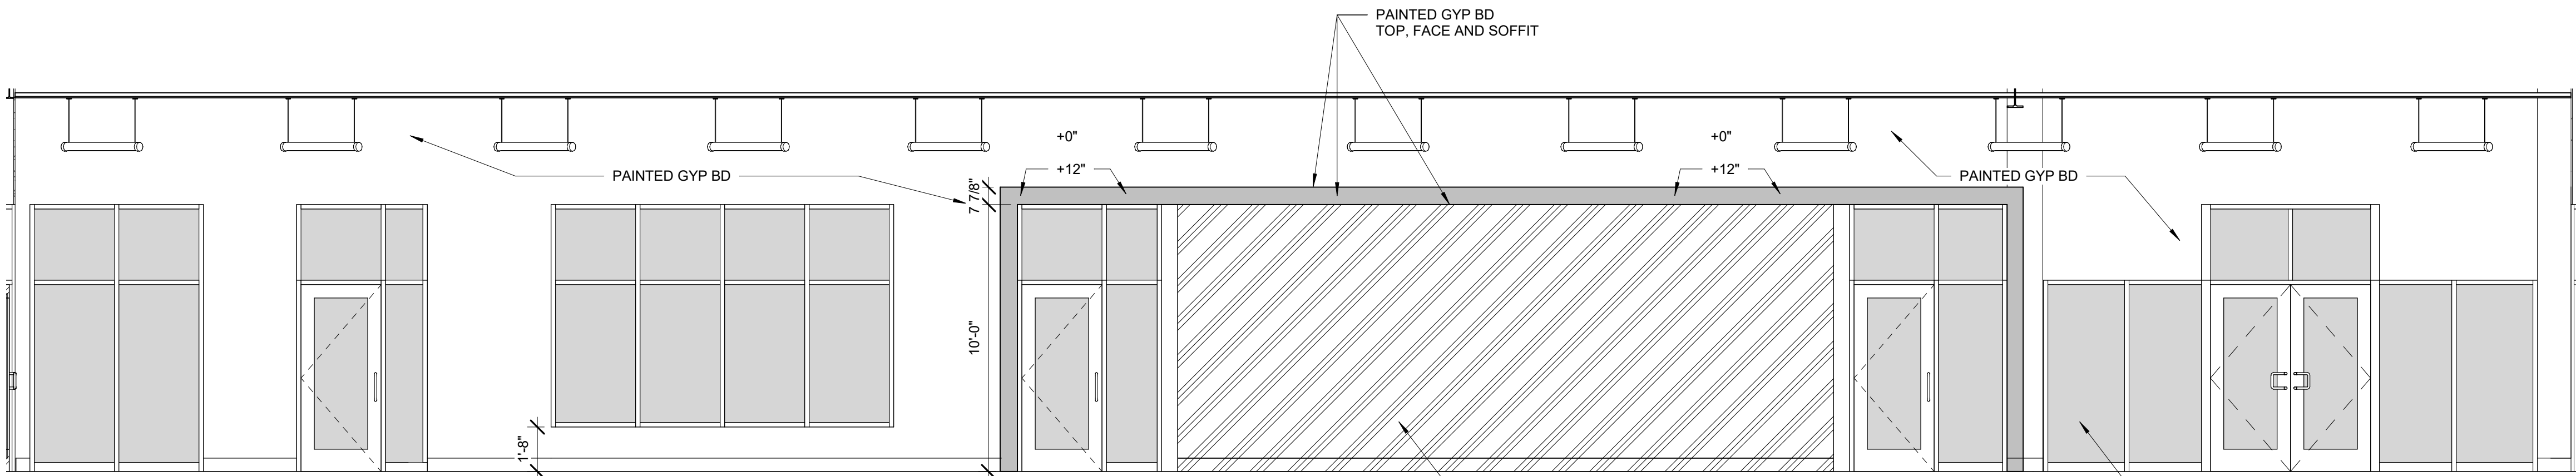


4 RECEPTION 101
1/4" = 1'-0"

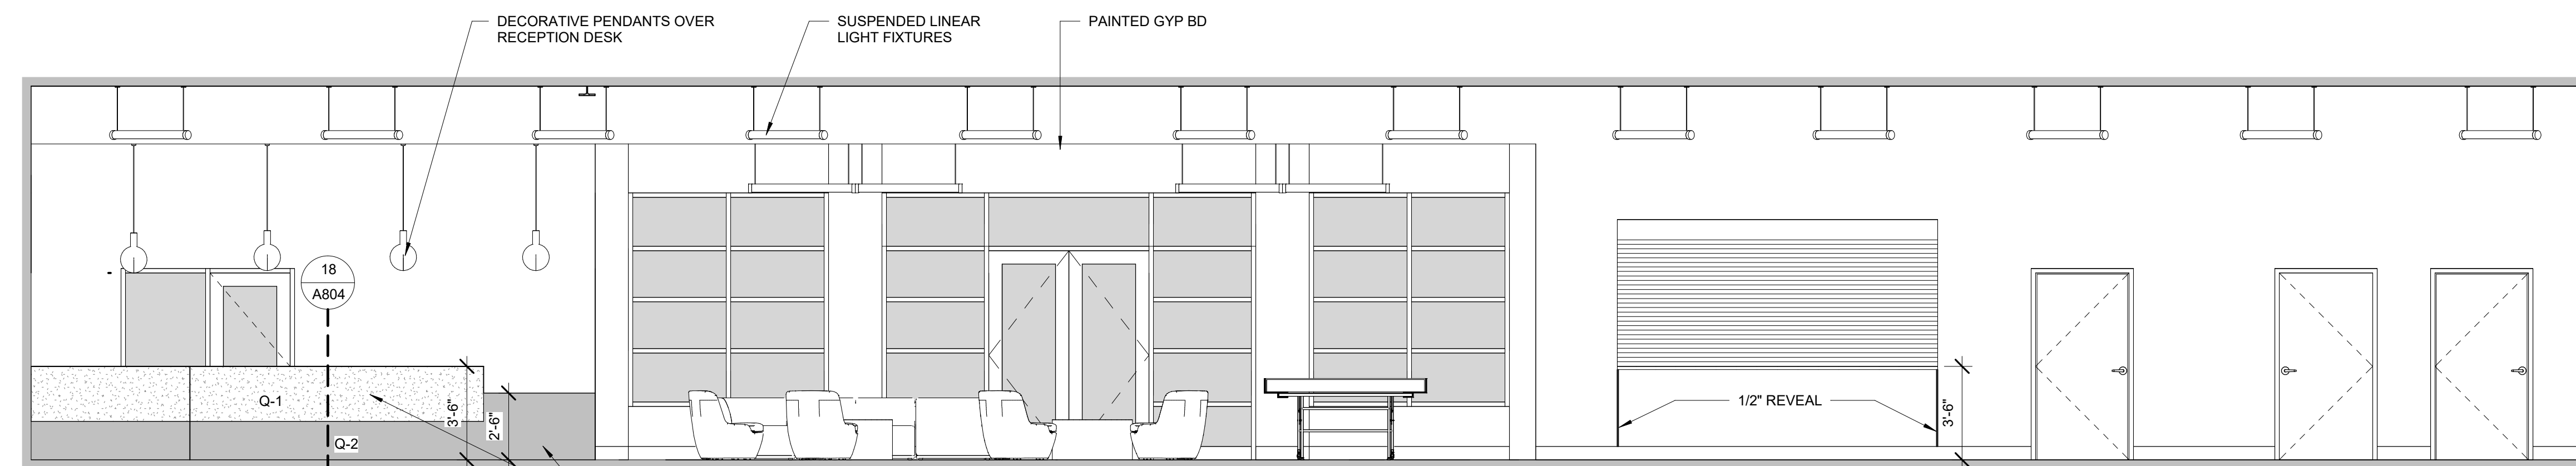

2 RECEPTION 101
1/4" = 1'-0"

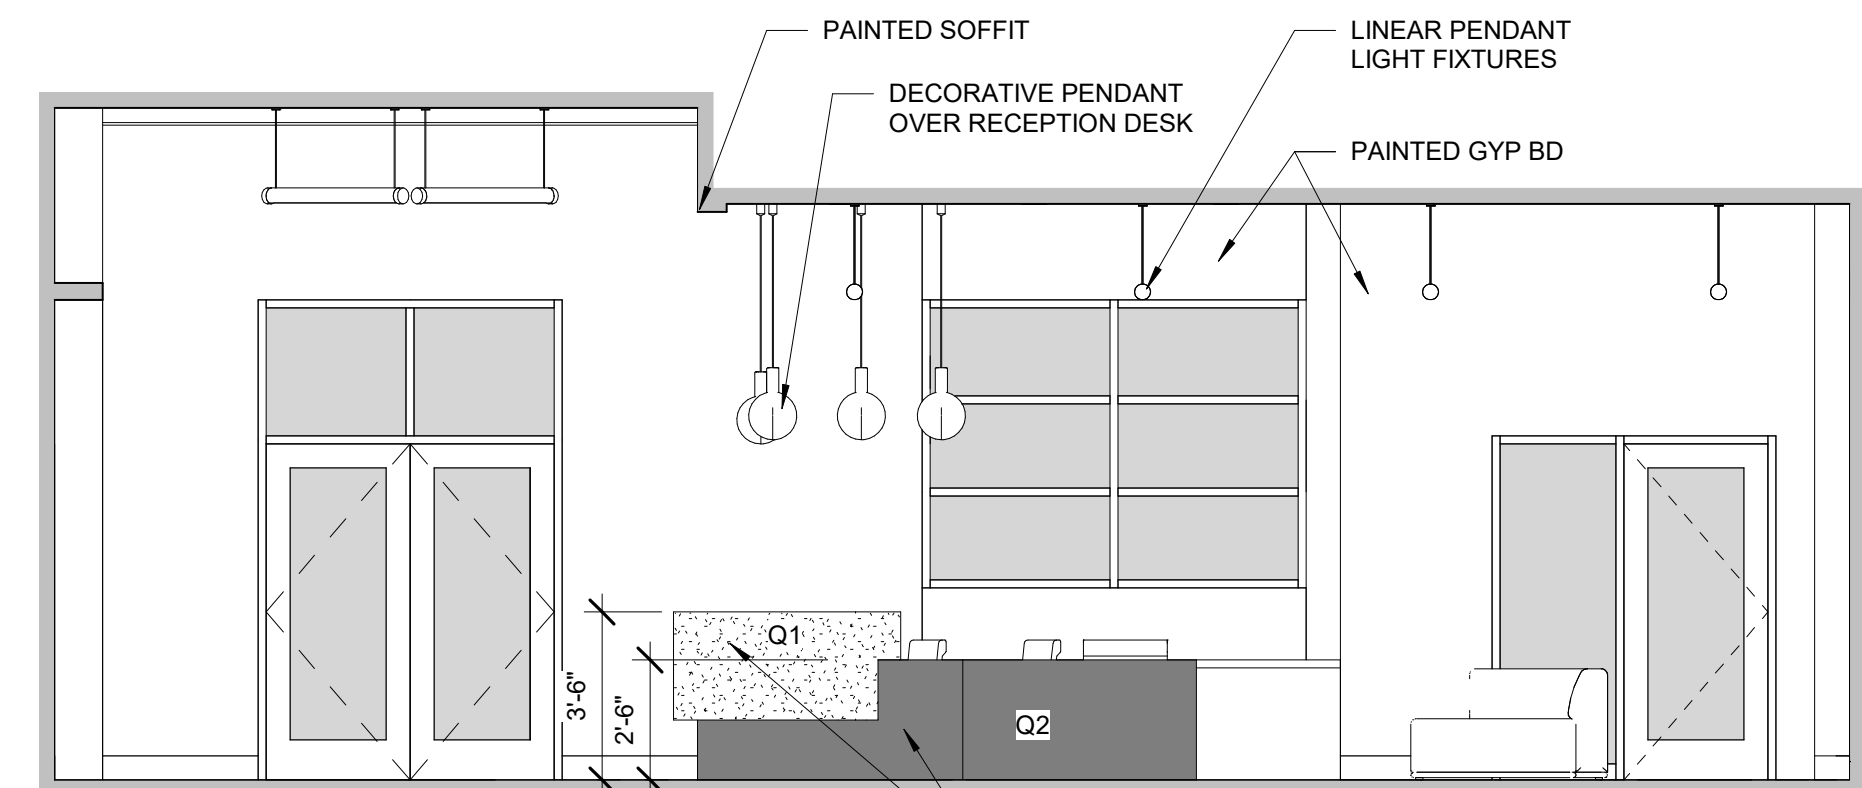

3 RECEPTION 101
1/4" = 1'-0"

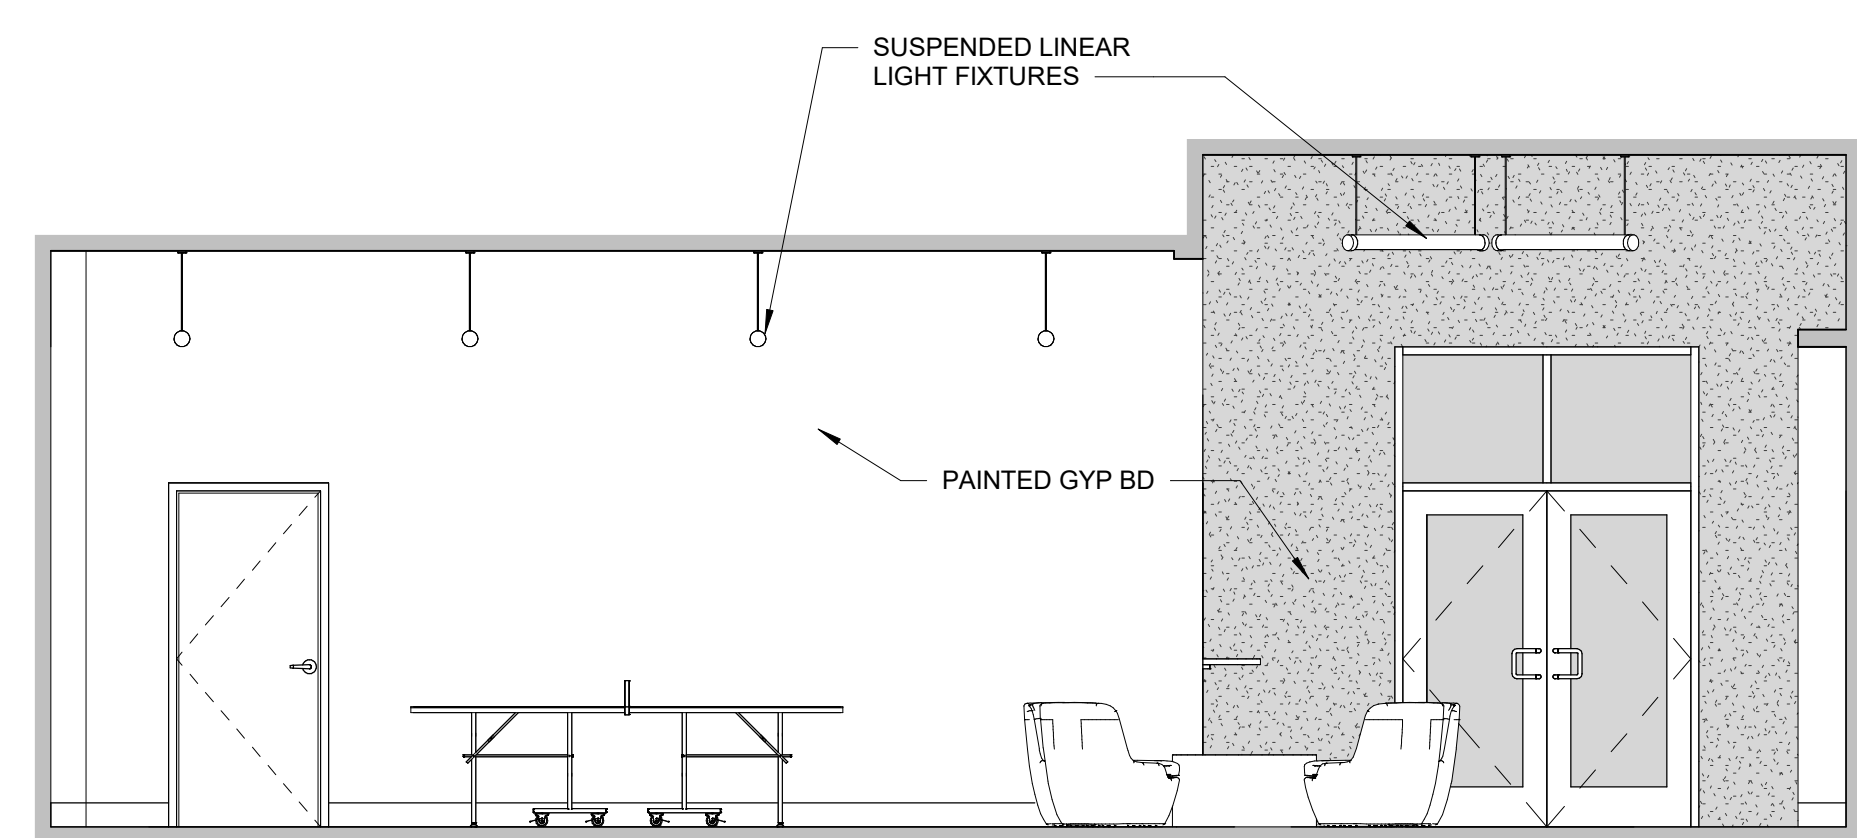

1 RECEPTION 101
1/4" = 1'-0"

BASIS OF DESIGN: FINISH LEGEND

GENERAL NOTE: COLORS AND FINISHES ARE BASIS OF DESIGN ONLY. SEE SPECIFICATIONS FOR EQUALS.

FLOOR

CONC-1	POLISHED CONCRETE FLOOR
CPT-1	SHAW, NOBLE MATERIALS, ALCHEMY TILE 5T135, COLOSSAL BISMUT 33496
CPT-2	SHAW, NOBLE MATERIALS, ALCHEMY TILE 5T135, ONYX SILVER 33505
WM-3	CARPET TILE, WALK OFF CARPET TILE, MILLIKEN, OBEX, TILE EUROPE, TDC154 GREY
T-1	PORCELAIN TILE, DAL TILE, HAUT MONDE, GLITTERATTI GRANITE HM03, UNPOLISHED
R-1	RUBBER FLOORING (FITNESS) ROBBINS SPORTS SURFACES, GALAXY CLASSIC, BLUE GREY
GYM-1	GYMNASIUM FLOORING, TARKETT TRAINING HE SHEET 3708001 BEECH WB, 129 SILK WB, SOLID WELD ROD 1291363 STRIPES COLORS: PULASTIC SPORTS FLOORING BLACK - CHAMPIONSHIP COURT RED ORANGE - JUNIOR COURTS WHITE - VOLLEYBALL
LVT-1	LUXURY VINYL TILE, INTERFACE, DRAWN LINES, COLOR: A00907 ONYX

BASE

RB-1	6" RUBBER BASE, NO PREFORMED CORNERS, ROPPE, COLOR: P100 BLACK
TB-1	SCHLUTER, COVE SHAPED PROFILE, FLOOR-WALL TRANSITION, DILEX-AHK, SATIN ANODIZED

WALL


PT-1	TYPICAL WALL PAINT, SHERWIN WILLIAMS, COLOR: (WHITE) SW 7009 PEARLY WHITE, EGGSHELL FINISH
PT-2	ACCENT WALL PAINT, SHERWIN WILLIAMS, COLOR: (RED) SW 6321 RED BAY, EGGSHELL FINISH
PT-3	ACCENT WALL PAINT, SHERWIN WILLIAMS, COLOR: (GOLD) SW 2817 ROOKWOOD AMBER, EGGSHELL FINISH
PT-4	ACCENT WALL PAINT, SHERWIN WILLIAMS, COLOR: (DARK BLUE) SW6244 NAVAL, EGGSHELL FINISH
PT-5	TRIM PAINT, SHERWIN WILLIAMS, COLOR: (BLACK) SW 6258 TRICORN BLACK, SEMI GLOSS FINISH
PT-6	GYM WALL (BLUE), SHERWIN WILLIAMS, COLOR: (LIGHT BLUE) SW6507 RESOLUTE BLUE, EGGSHELL FINISH
PT-7	GYM WALL, SHERWIN WILLIAMS, COLOR: (GREY) SW7663 MONORAIL SILVER, EGGSHELL FINISH
WT-1	PORCELAIN WALL TILE: (WHITE) GARDENSTATE TILE, OUTFIT BRICK, GLOSSY 3" X 12" BRIGHT WHITE
WT-2	PORCELAIN WALL TILE: (YELLOW CHEVRON) DAL TILE MOSAICS 1" X 3" HERRINGBONE COLOR: MUSTARD 1012 (3)
WT-3	PORCELAIN WALL TILE: (BLUE) GARDENSTATE TILE STORM 3" X 12" BRICK GLOSSY GSW167116
WT-4	PORCELAIN WALL TILE: (RED) GARDENSTATE TILE, OUTFIT, HEXAGON 6" X 7", SCARLET GSW167128
F-1	FELT WALLCOVERING: BUZZISPACE, BUZZISKIN, SK OFFWHITE 63
F-2	FELT WALLCOVERING: BUZZISPACE, BUZZISKIN, SK STONEGREY 67
WC-1	CUSTOM WALLCOVERING: TBD
ND-1	NETTING DIVIDER @GYM:DARK ROYAL BLUE VINYL W/GREY MESH ABOVE

CEILING

GB-1	GYPSUM BOARD CEILING, PAINTED, (PNT-1 TYPICAL)
ACT-1	ACOUSTIC CEILING TILE, ARMSTRONG OPTIMA 24" X 24" 9/16" REGULAR TILE, SUPRAFINE XL 9/16" EXPOSED TEE GRID
ACT-2	ACOUSTIC CEILING TILE, ARMSTRONG TECHZONE 30" X 60" SQUARE REGULAR WITH 6" WIDE TECHNICAL PANELS
EXP	EXPOSED CEILING

MILLWORK

PL-1	PLASTIC LAMINATE: COLOR: FORMICA 5794, BEIGE ELM, NATURAL GRAIN - NG
Q-1	QUARTZ COUNTER, 3CM, EASED EDGE, CAMBRIA, SANDGATE
Q-2	QUARTZ COUNTER, 3CM, EASED EDGE, CAMBRIA, BLACKBROOK
Q-3	QUARTZ COUNTER, 3CM, EASED EDGE, CORIAN QUARTZ, COLOR: DOVE GREY (3)

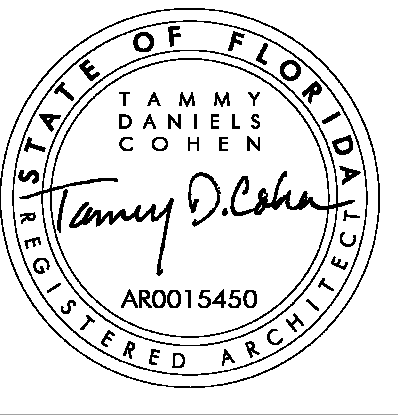

CCR ARCHITECTURE & INTERIORS

MARTIN LUTHER KING JR. RECREATION CENTER

705 14TH COURT EAST
PANAMA CITY, FL 32401

JOB NUMBER:
21109

DATE:
05/18/2023


PRINTED / REVISIONS
DESCRIPTION DATE

SHEET TITLE:
INTERIOR ELEVATIONS


SHEET NUMBER:

A801


05/18/2023, 10:28 PM
2420 FIRST AVENUE SOUTH, PANAMA CITY, FL 32401
THIS DRAWING IS THE PROPERTY OF CCR ARCHITECTURE & INTERIORS AND IS NOT TO BE REPRODUCED, COPIED OR ALTERED IN WHOLE OR IN PART OR USED FOR ANY PURPOSE WITHOUT THE APPROVAL OF CCR ARCHITECTURE & INTERIORS AND IS TO BE RETURNED UPON REQUEST.

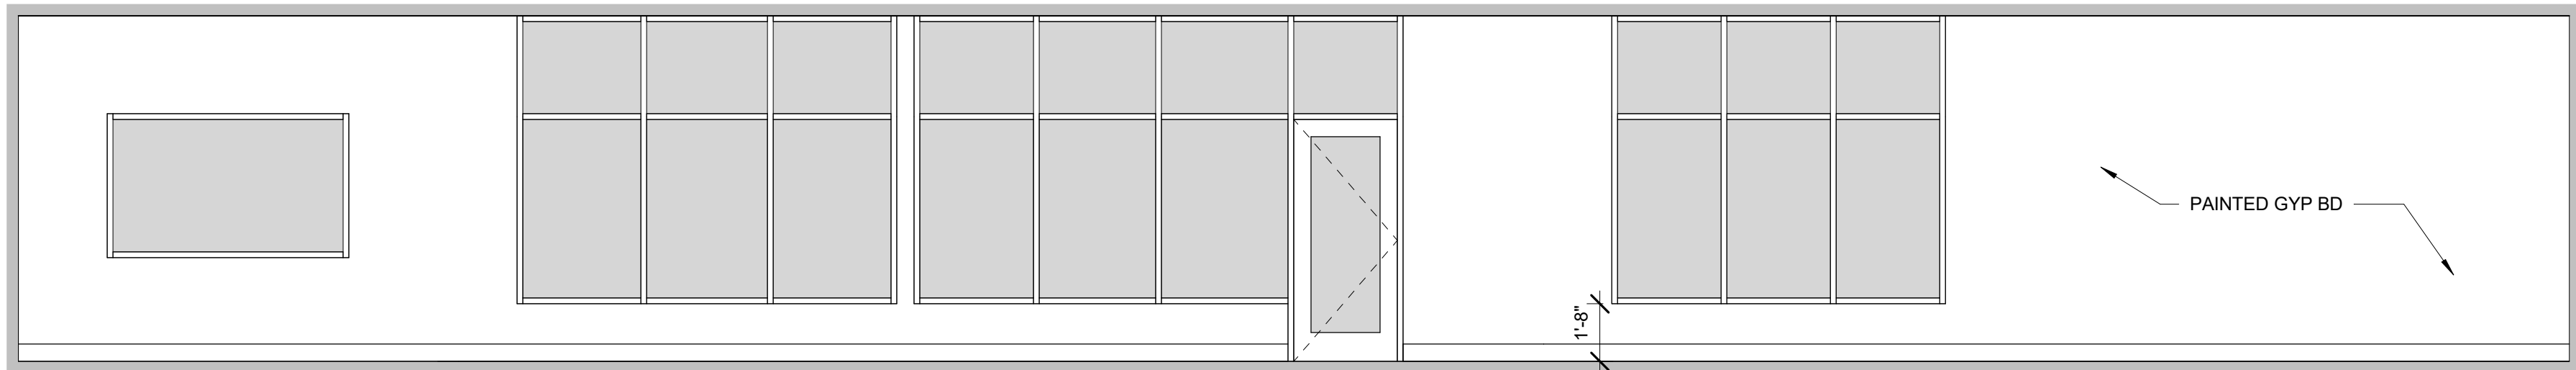


Ⓛ CORRIDOR
1/4" = 1'-0"

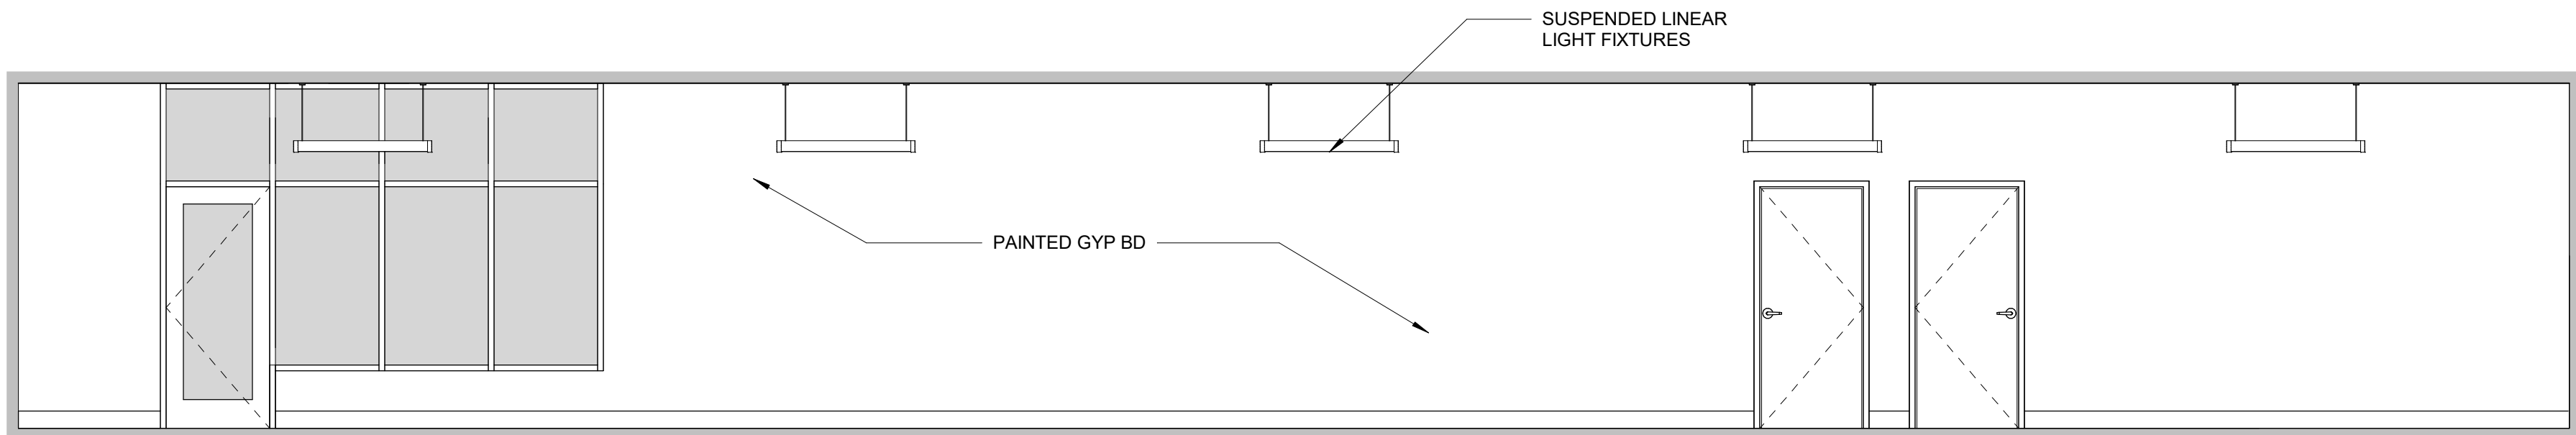


Ⓚ CORRIDOR
1/4" = 1'-0"

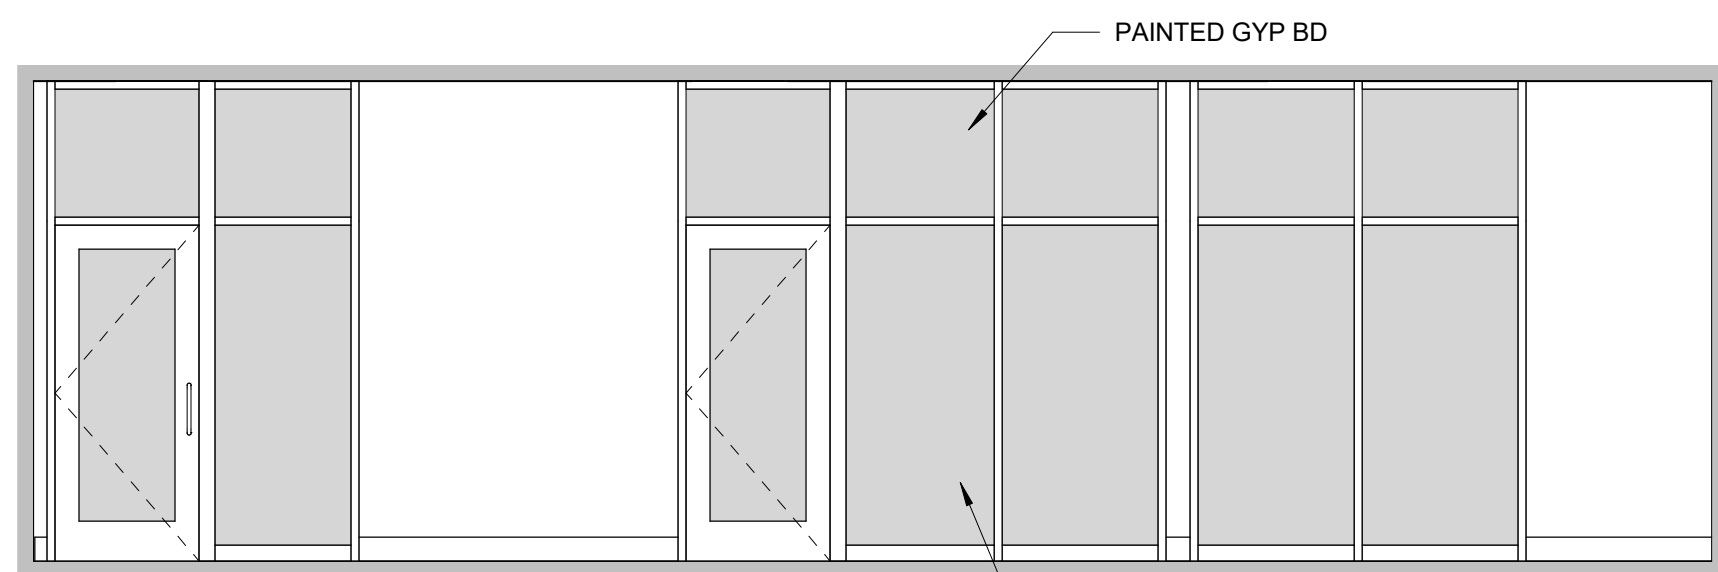


Ⓝ CORRIDOR
1/4" = 1'-0"

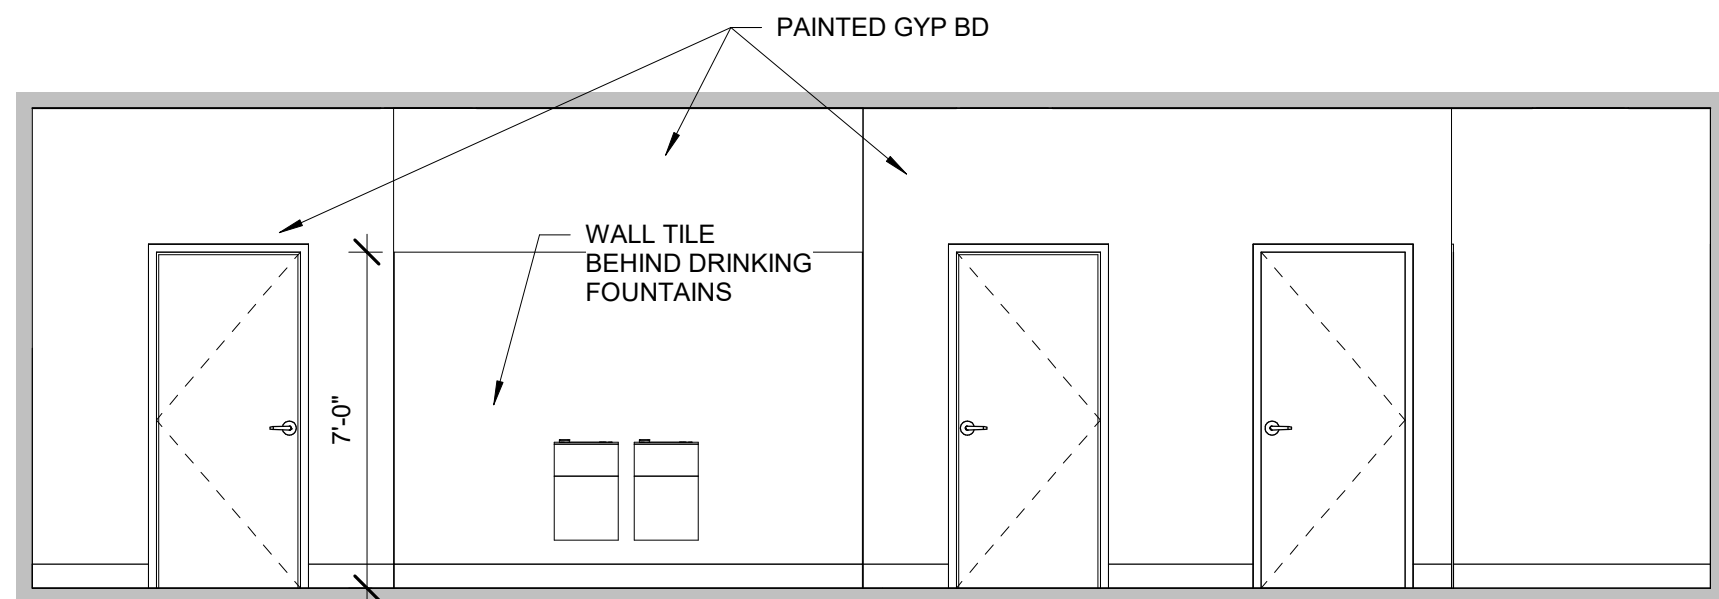


Ⓛ CORRIDOR
1/4" = 1'-0"

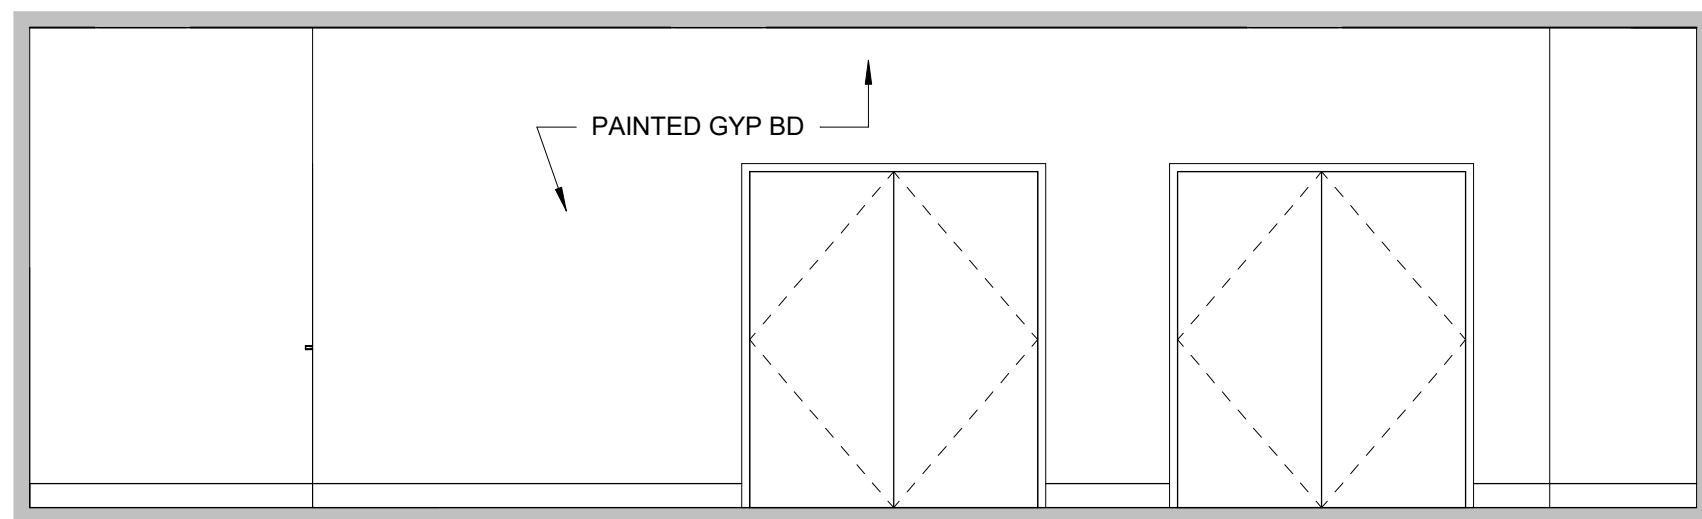


ⓐ CORRIDOR
1/4" = 1'-0"

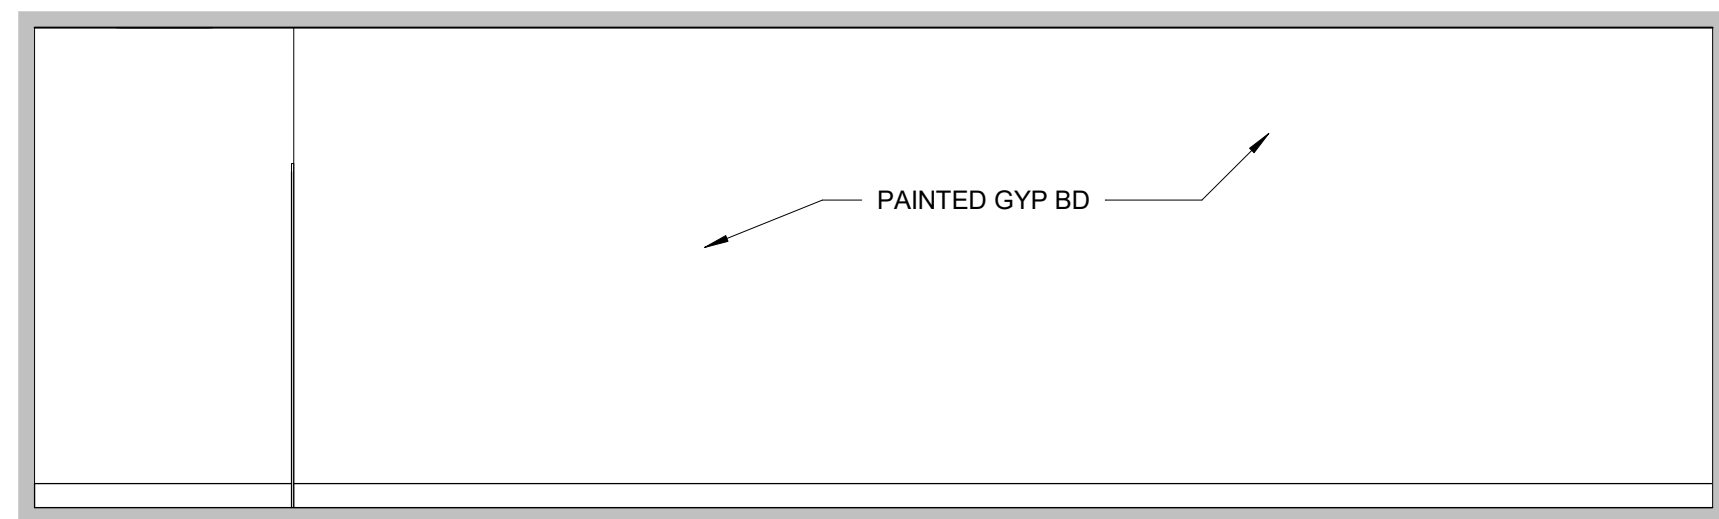


ⓑ CORRIDOR
1/4" = 1'-0"

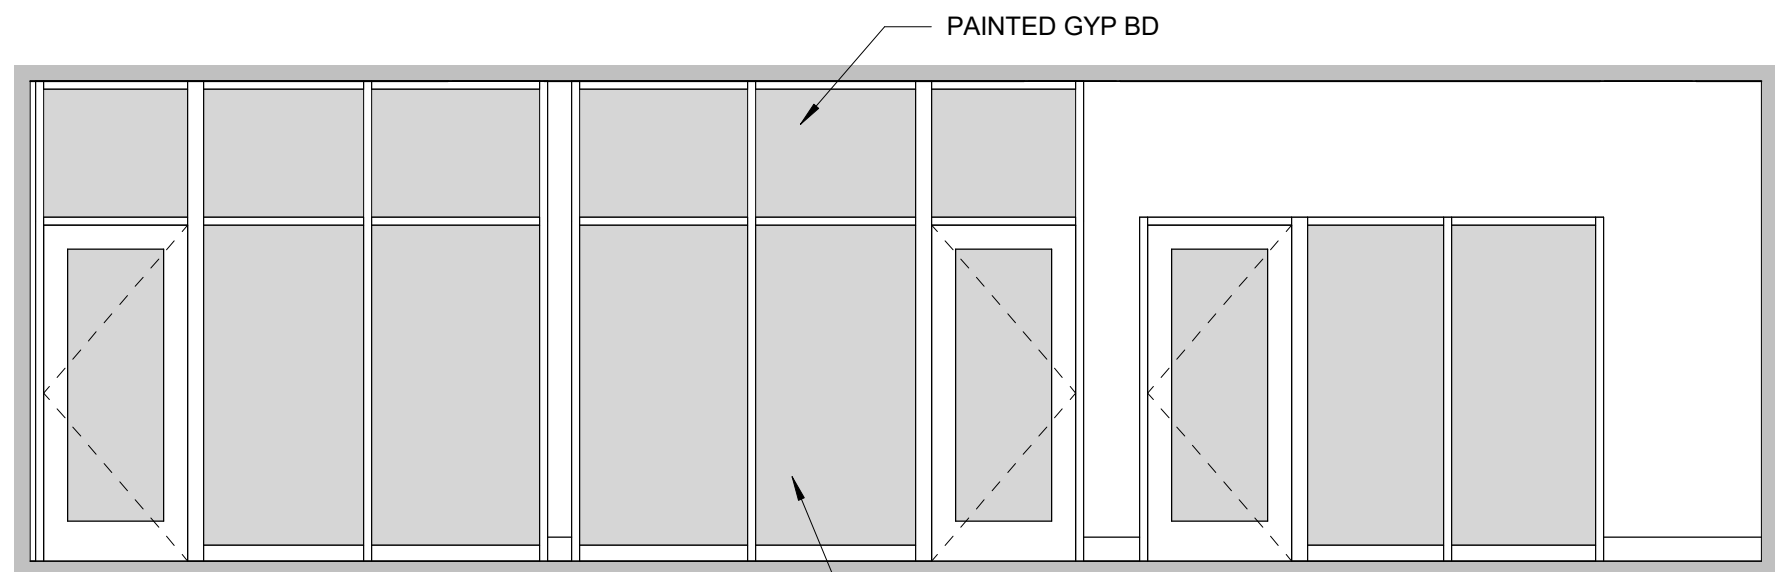


ⓓ CORRIDOR
1/4" = 1'-0"

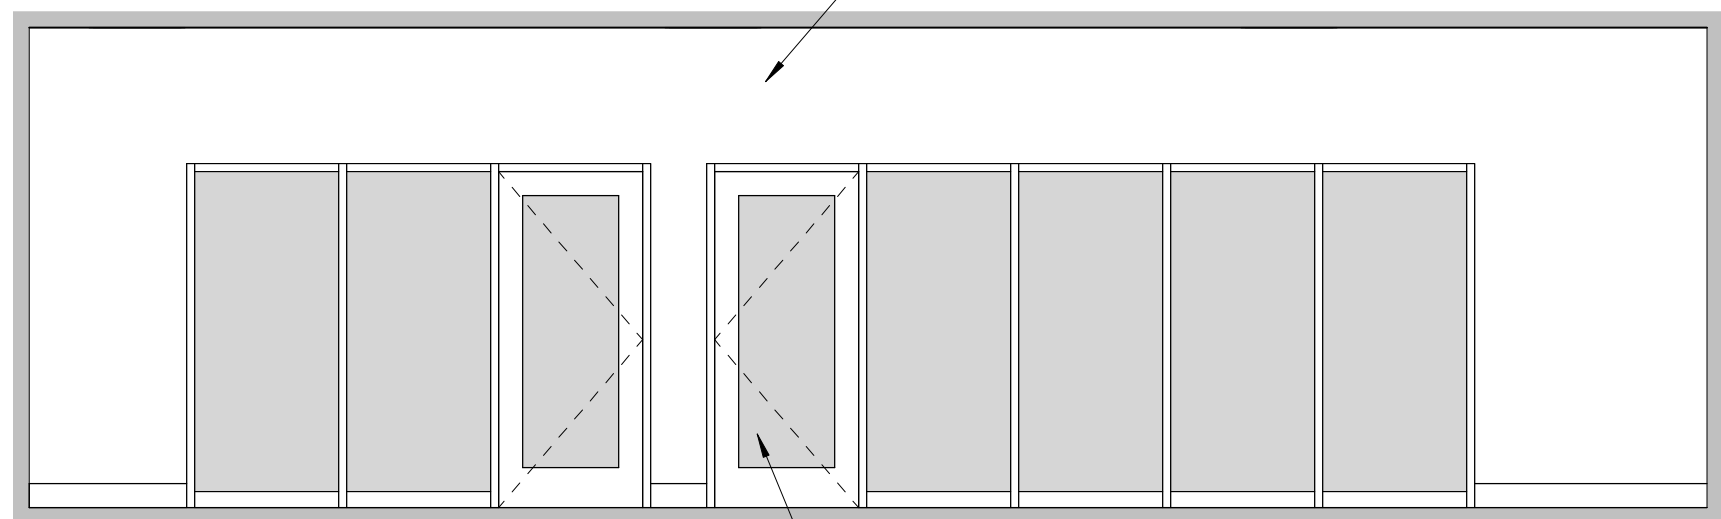


ⓔ CORRIDOR
1/4" = 1'-0"

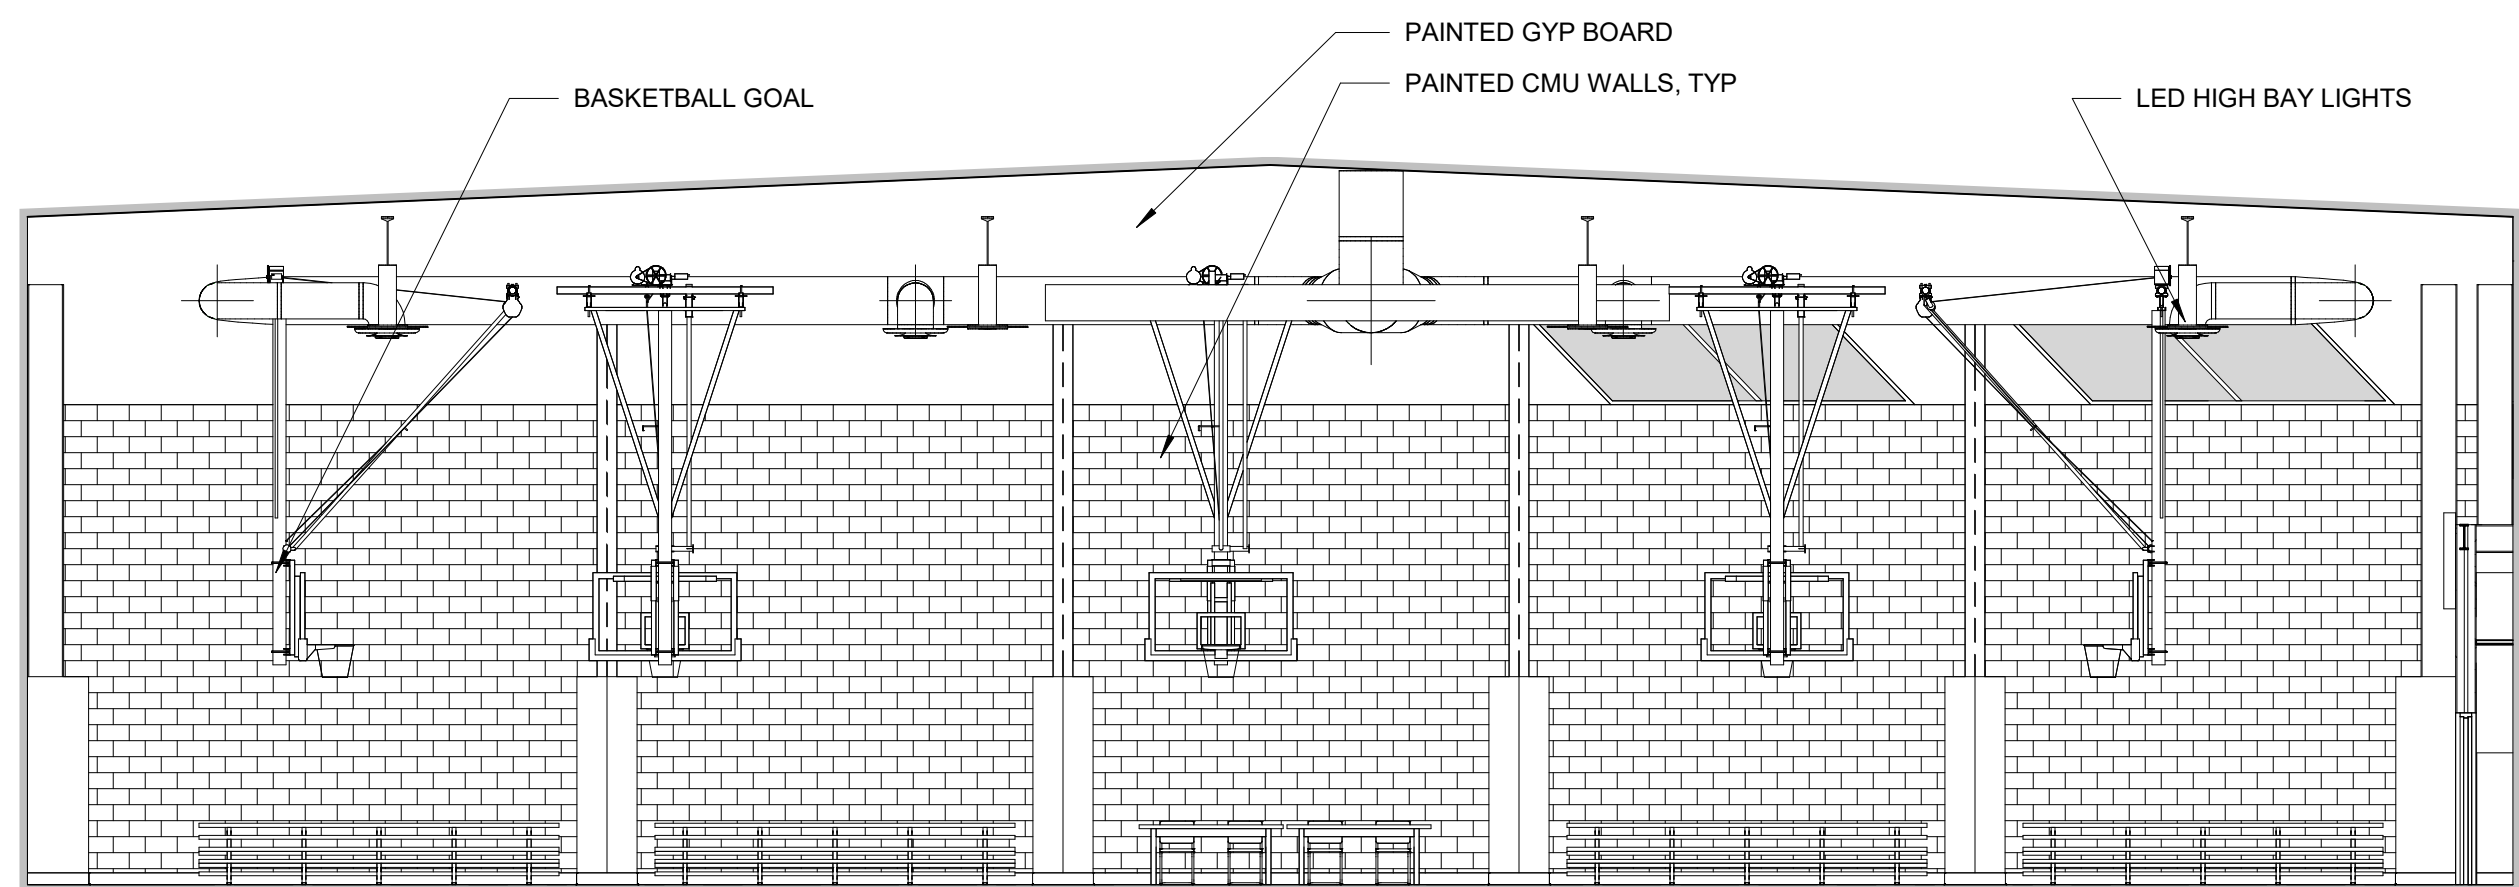


ⓓ GYMNASIUM
1/8" = 1'-0"

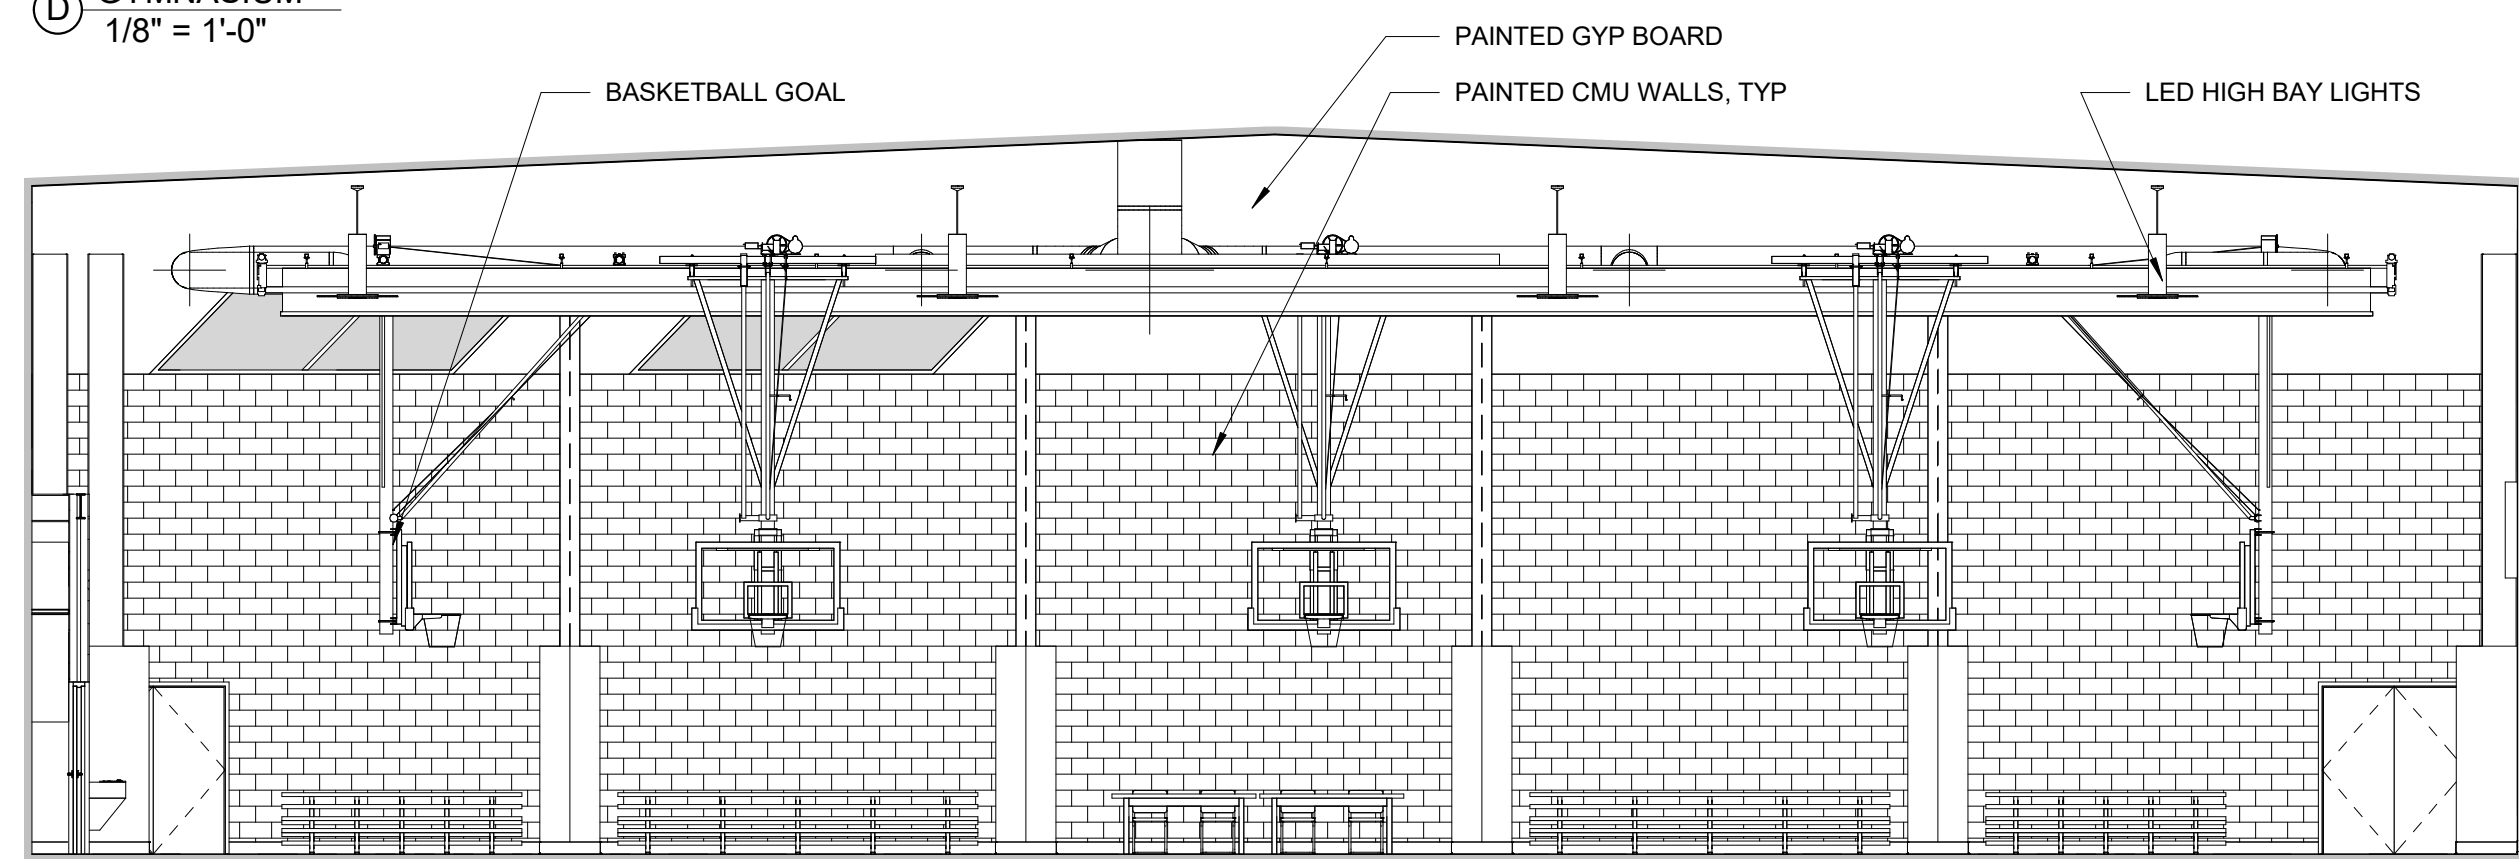

ⓑ GYMNASIUM
1/8" = 1'-0"

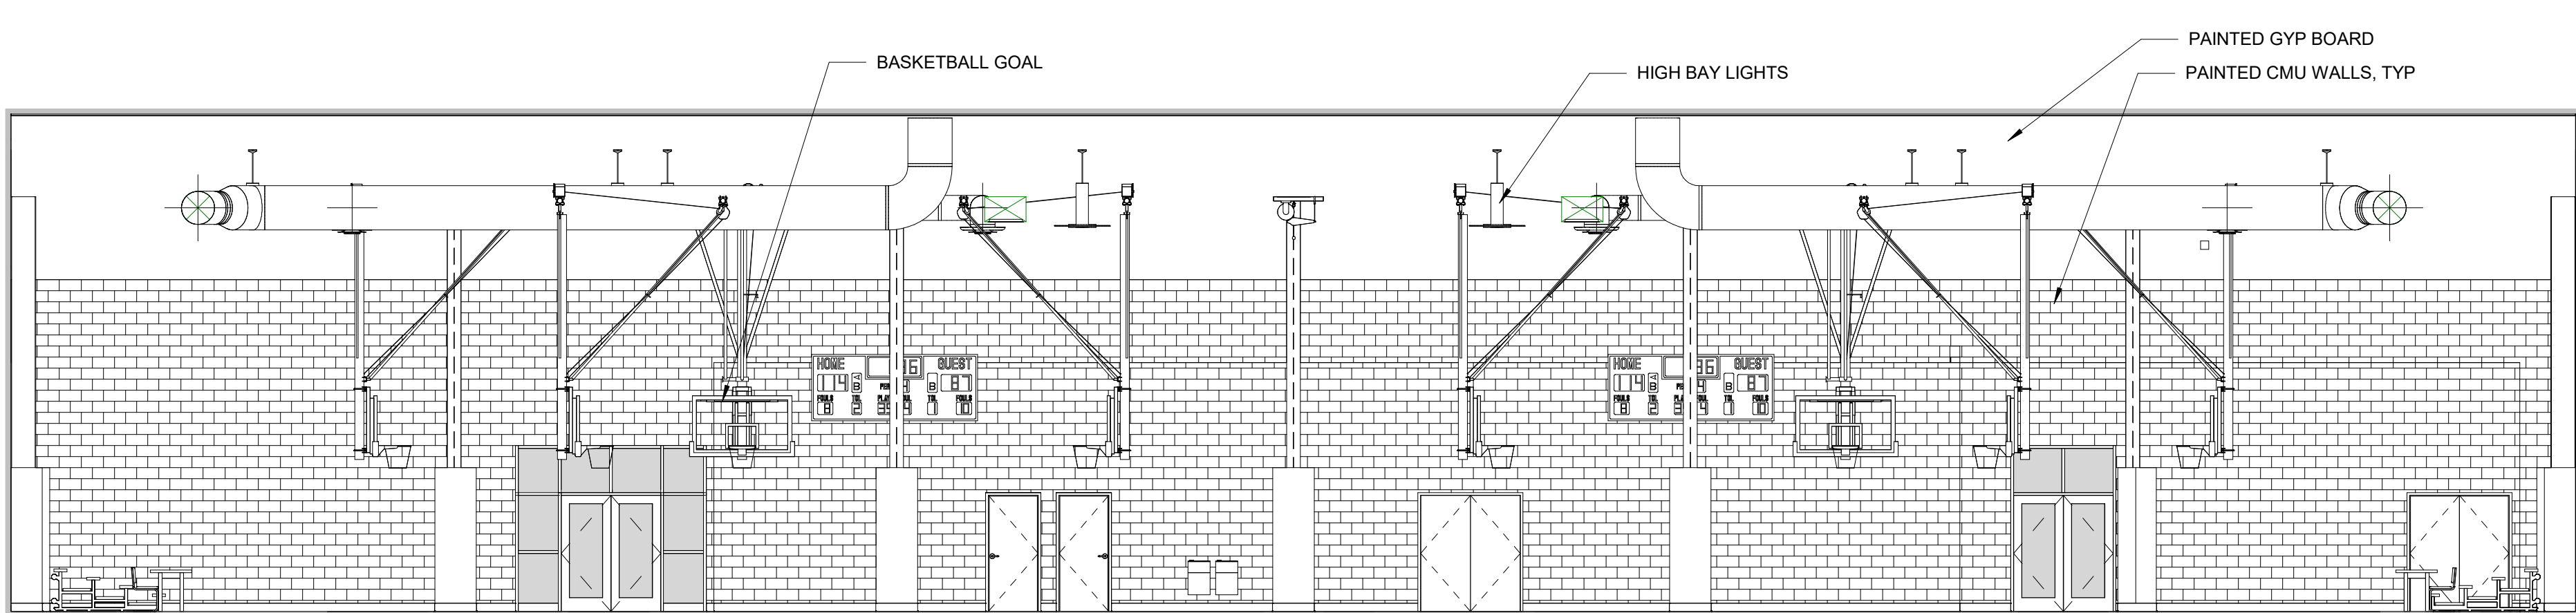

Ⓚ GYMNASIUM
1/8" = 1'-0"

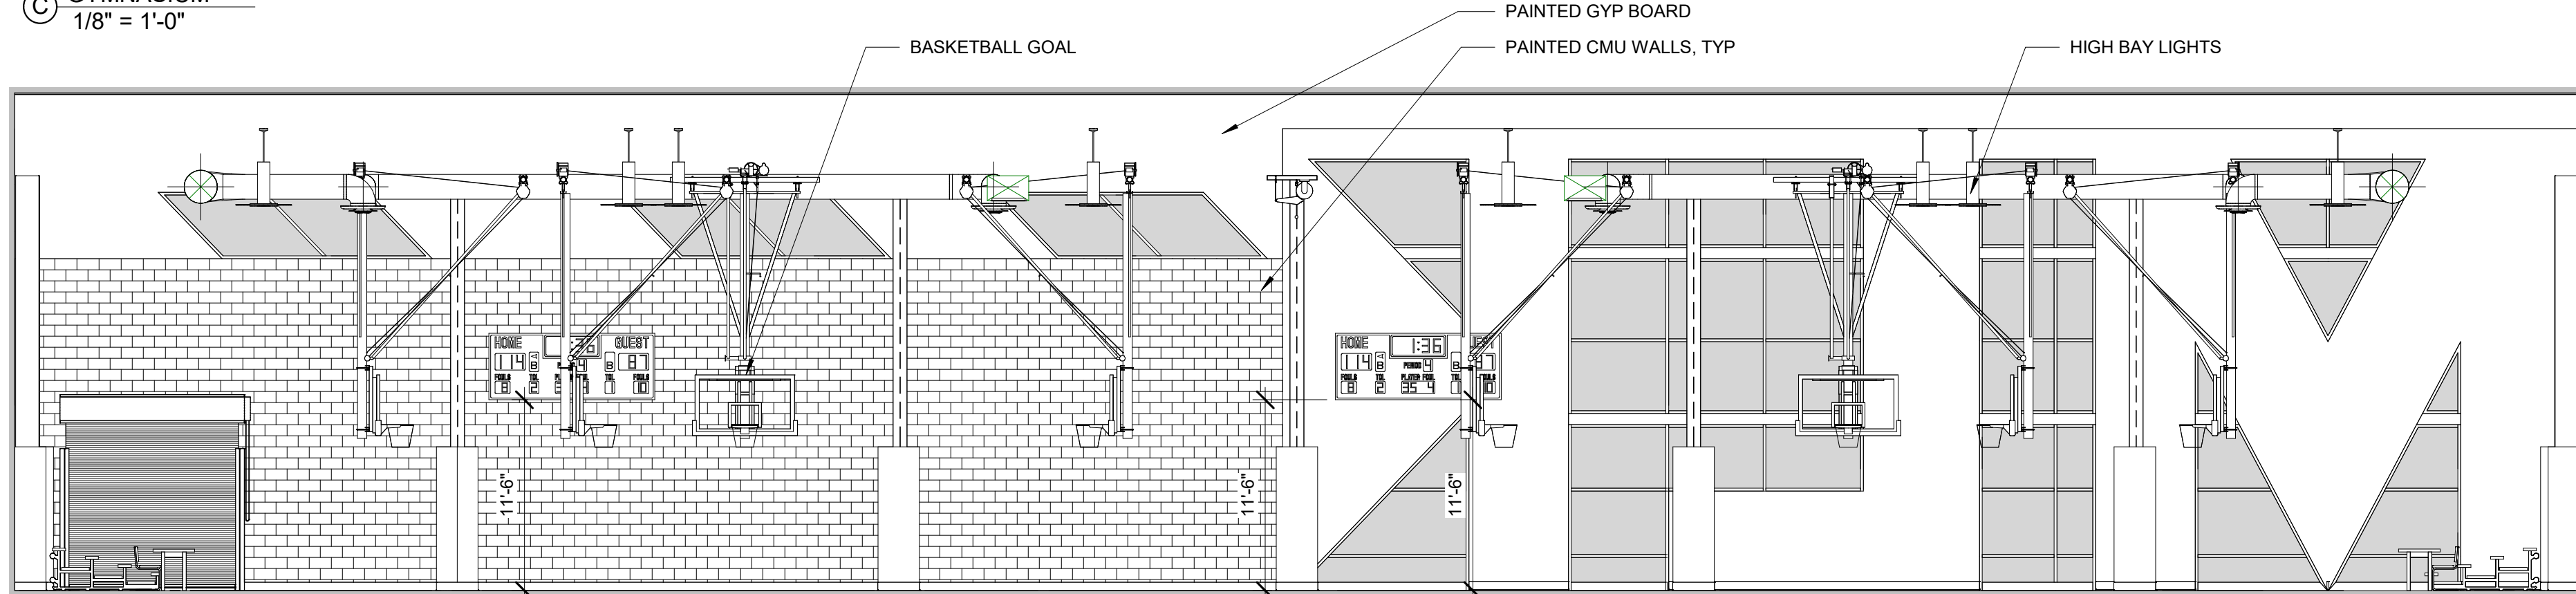

ⓐ GYMNASIUM
1/8" = 1'-0"

BASIS OF DESIGN: FINISH LEGEND

GENERAL NOTE: COLORS AND FINISHES ARE BASIS OF DESIGN ONLY. SEE SPECIFICATIONS FOR EQUALS.

FLOOR

CONC-1	POLISHED CONCRETE FLOOR
CPT-1	SHAW, NOBLE MATERIALS, ALCHEMY TILE 5T135, COLOSSAL BISLUT 33496
CPT-2	SHAW, NOBLE MATERIALS, ALCHEMY TILE 5T135, ONYX SILVER 33505
WM-3	CARPET TILE, WALK OFF CARPET TILE, MILLIKEN, OBEY, TILE EUROPE, TDC154 GREY
T-1	PORCELAIN TILE, DAL TILE, HAUT MONDE, GLITTERATTI GRANITE HM03, UNPOLISHED
R-1	RUBBER FLOORING (FITNESS) ROBBINS SPORTS SURFACES, GALAXY CLASSIC, BLUE GREY
GYM-1	GYMNASIUM FLOORING, TARKETT, TRAINING HE SHEET 3708001 BEECH WB, 129 SILK WB, SOLID WELD ROD 1291363 STRIPE COLORS PULASTIC SPORTS FLOORING BLACK - CHAMPIONSHIP COURT RED ORANGE - JUNIOR COURTS WHITE - VOLLEYBALL
LVT-1	LUXURY VINYL TILE, INTERFACE, DRAWN LINES, COLOR: A00907 ONYX

BASE

RB-1	6" RUBBER BASE, NO PREFORMED CORNERS, ROPPE, COLOR: P100 BLACK
TB-1	SCHLUTER, COVE SHAPED PROFILE, FLOOR-WALL TRANSITION, DILEX-AHK, SATIN ANODIZED

WALL


PT-1	TYPICAL WALL PAINT, SHERWIN WILLIAMS, COLOR: (WHITE) SW 7009 PEARLY WHITE, EGGSHELL FINISH
PT-2	ACCENT WALL PAINT, SHERWIN WILLIAMS, COLOR: (RED) SW 6321 RED BAY, EGGSHELL FINISH
PT-3	ACCENT WALL PAINT, SHERWIN WILLIAMS, COLOR: (GOLD) SW 2817 ROOKWOOD AMBER, EGGSHELL FINISH
PT-4	ACCENT WALL PAINT, SHERWIN WILLIAMS, COLOR: (DARK BLUE) SW6244 NAVAL, EGGSHELL FINISH
PT-5	TRIM PAINT, SHERWIN WILLIAMS, COLOR: (BLACK) SW 6258 TRICORN BLACK, SEMI GLOSS FINISH
PT-6	GYM WALL (BLUE), SHERWIN WILLIAMS, COLOR: (LIGHT BLUE) SW6507 RESOLUTE BLUE, EGGSHELL FINISH
PT-7	GYM WALL, SHERWIN WILLIAMS, COLOR: (GREY) SW7663 MONORAIL SILVER, EGGSHELL FINISH
WT-1	PORCELAIN WALL TILE: (WHITE) GARDENSTATE TILE, OUTFIT BRICK, GLOSSY 3" X 12" BRIGHT WHITE
WT-2	PORCELAIN WALL TILE: (YELLOW CHEVRON) DAL TILE MOSAICS 1" X 3" HERRINGBONE COLOR: MUSTARD 1012 (3)
WT-3	PORCELAIN WALL TILE: (BLUE) GARDENSTATE TILE STORM 3" X 12" BRICK GLOSSY GSW167116
WT-4	PORCELAIN WALL TILE: (RED) GARDENSTATE TILE, OUTFIT, HEXAGON 6" X 7", SCARLET GSW167128
F-1	FELT WALLCOVERING: BUZZISPACE, BUZZISKIN, SK OFFWHITE 63
F-2	FELT WALLCOVERING: BUZZISPACE, BUZZISKIN, SK STONEGREY 67
WC-1	CUSTOM WALLCOVERING: TBD
ND-1	NETTING DIVIDER @GYM:DARK ROYAL BLUE VINYL W/GREY MESH ABOVE

CEILING

GB-1	GYPSUM BOARD CEILING, PAINTED, (PNT-1 TYPICAL)
ACT-1	ACOUSTIC CEILING TILE, ARMSTRONG OPTIMA 24" X 24" 9/16" REGULAR TILE, SUPRAFINE XL 9/16" EXPOSED TEE GRID
ACT-2	ACOUSTIC CEILING TILE, ARMSTRONG TECHZONE 30" X 60" SQUARE REGULAR WITH 6" WIDE TECHNICAL PANELS
EXP	EXPOSED CEILING

MILLWORK

PL-1	PLASTIC LAMINATE: COLOR: FORMICA 5794, BEIGE ELM, NATURAL GRAIN - NG
Q-1	QUARTZ COUNTER, 3CM, EASED EDGE, CAMBRIA, SANDGATE
Q-2	QUARTZ COUNTER, 3CM, EASED EDGE, CAMBRIA, BLACKBROOK
Q-3	QUARTZ COUNTER, 3CM, EASED EDGE, CORIAN QUARTZ, COLOR: DOVE GREY (3)

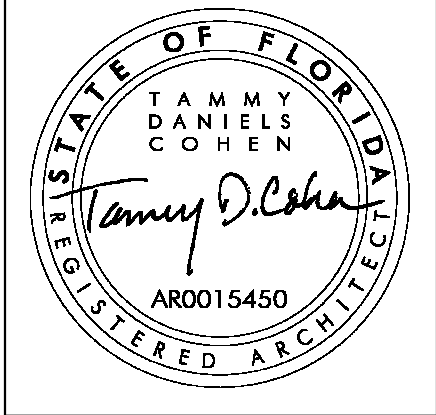

CCR ARCHITECTURE & INTERIORS

MARTIN LUTHER KING JR. RECREATION CENTER
705 14TH COURT EAST
PANAMA CITY, FL 32401

JOB NUMBER:
21109

DATE:
05/18/2023


PRINTED / REVISIONS
DESCRIPTION DATE

SHEET TITLE:
INTERIOR ELEVATIONS


SHEET NUMBER:

A802


05/18/2023 10:28 PM PANAMA CITY 66021100 Panama City, FL - New Building - Scheme 2 of 4
THIS DRAWING IS THE PROPERTY OF CCR ARCHITECTURE & INTERIORS AND IS NOT TO BE REPRODUCED, COPIED OR ALTERED IN WHOLE OR IN PART OR USED FOR ANY PURPOSE WITHOUT THE APPROVAL OF CCR ARCHITECTURE & INTERIORS AND IS TO BE RETURNED UPON REQUEST.

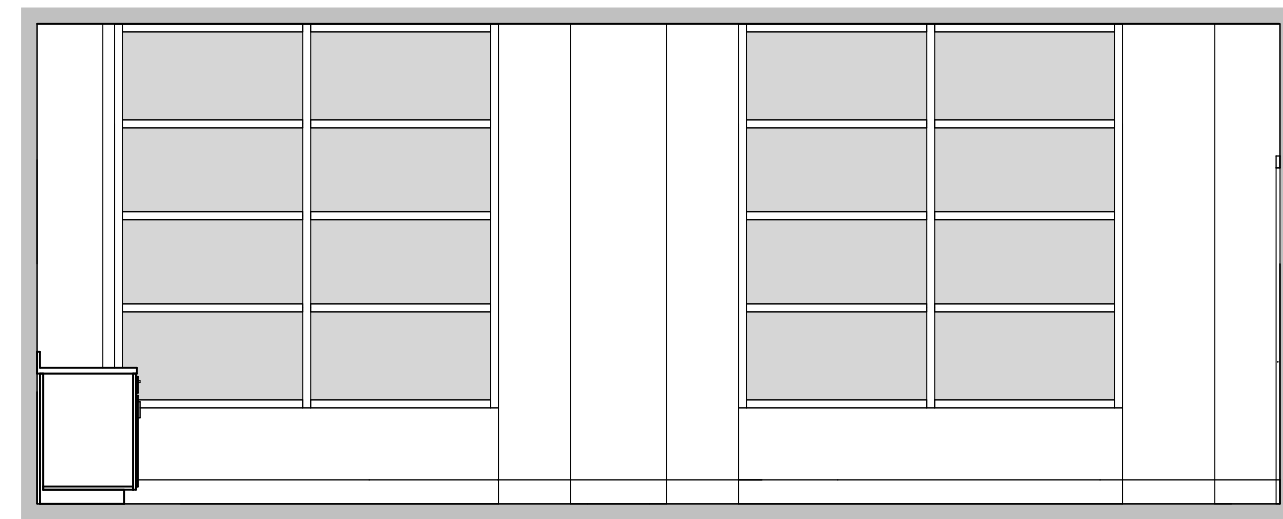


24 STEM LAB
1/4" = 1'-0"

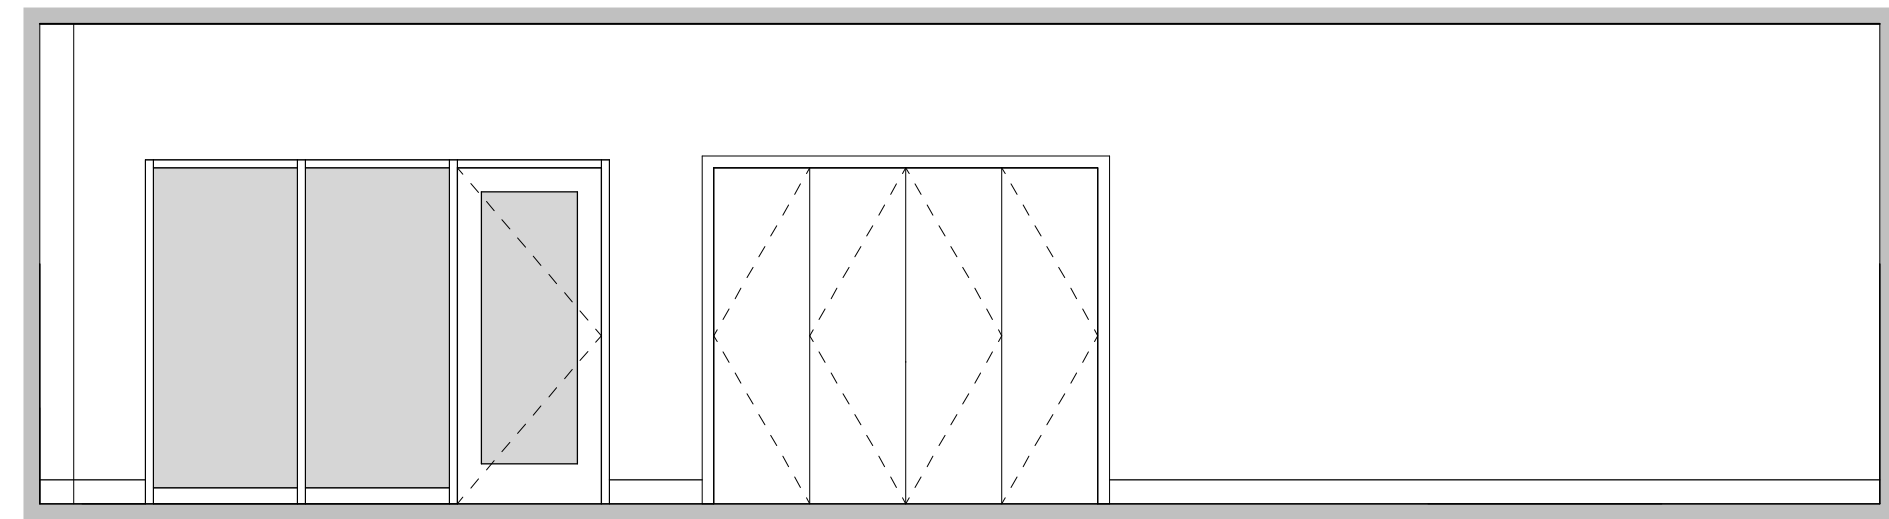


23 STEM LAB
1/4" = 1'-0"

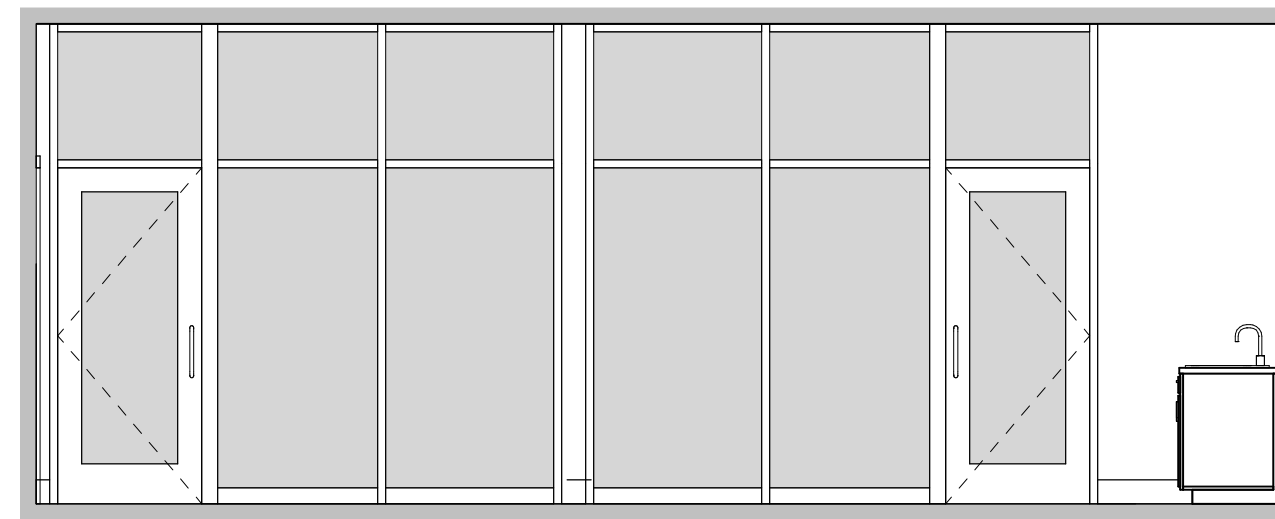


22 STEM LAB
1/4" = 1'-0"

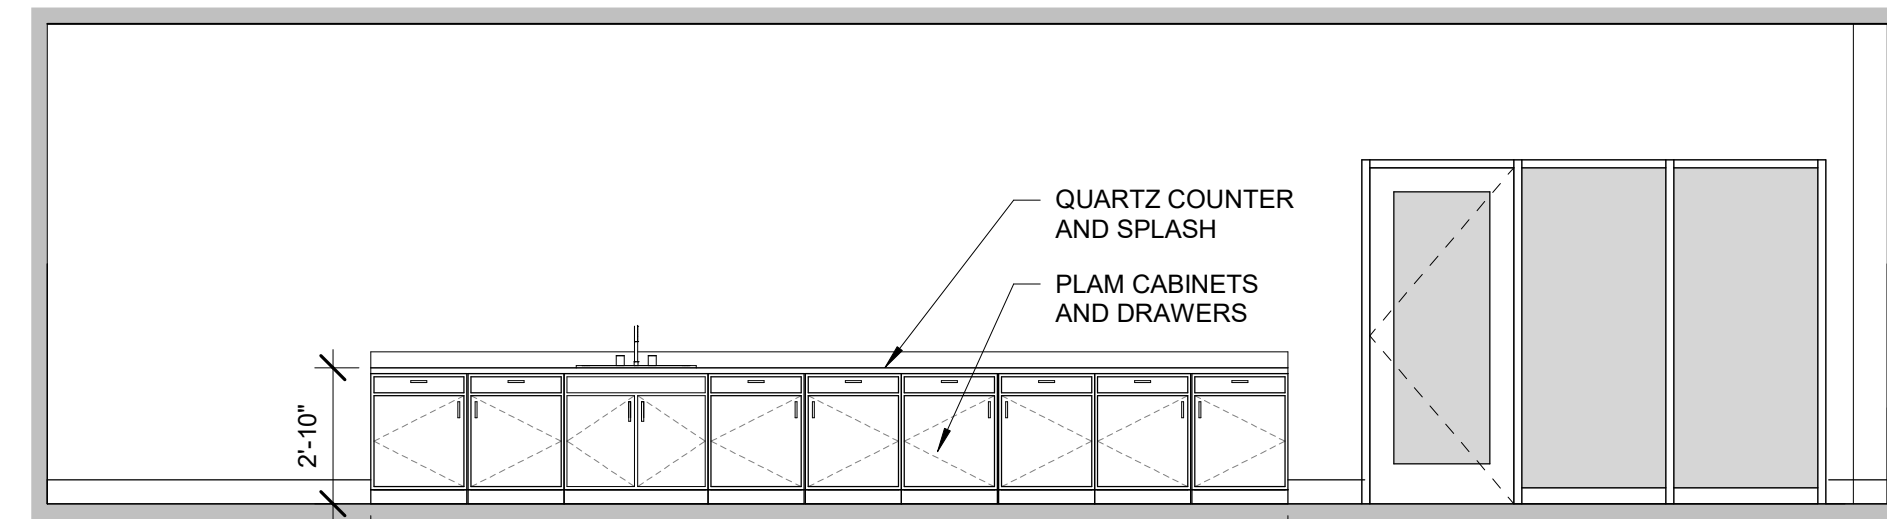


21 STEM LAB
1/4" = 1'-0"

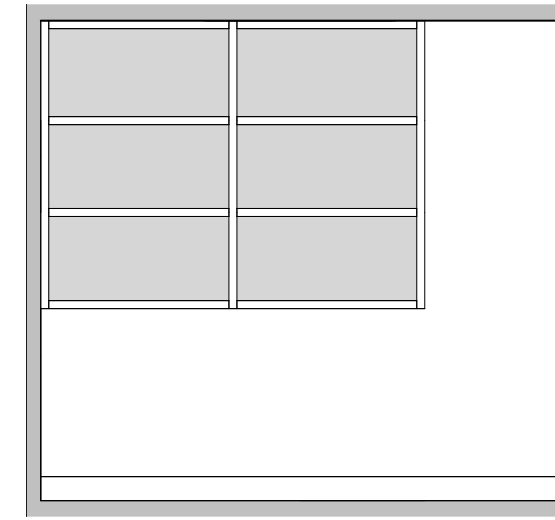


20 ENGINEERING BOOTH
1/4" = 1'-0"

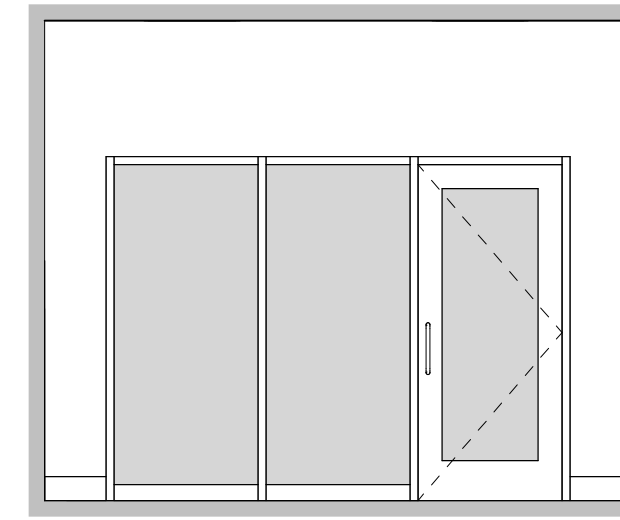


19 ENGINEERING BOOTH
1/4" = 1'-0"

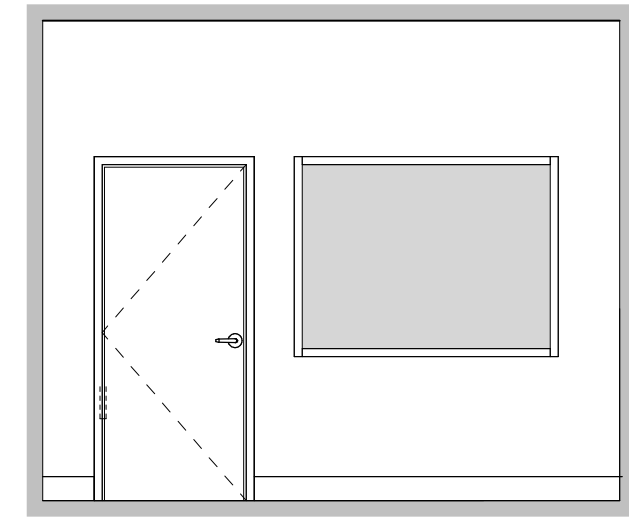


17 ENGINEERING BOOTH
1/4" = 1'-0"

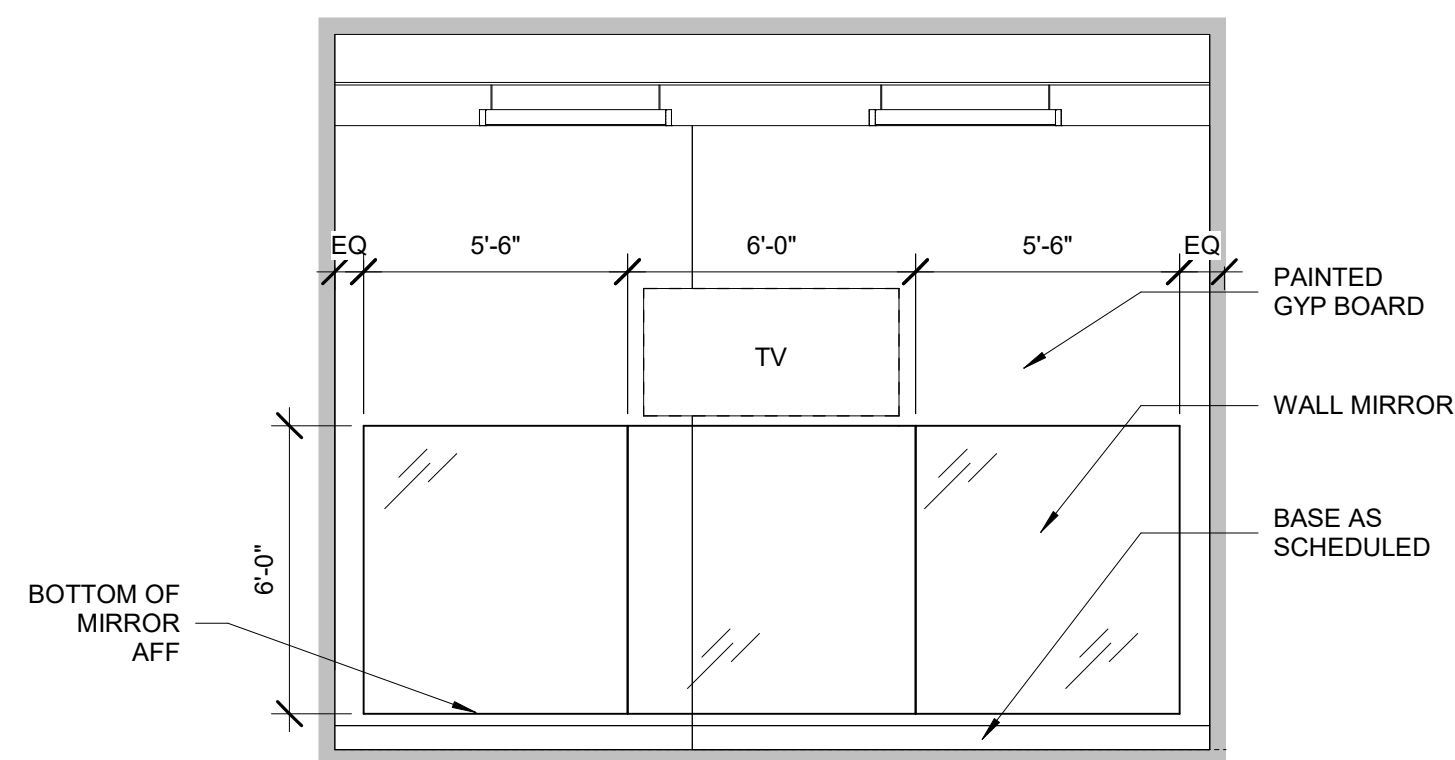


16 FITNESS
1/4" = 1'-0"

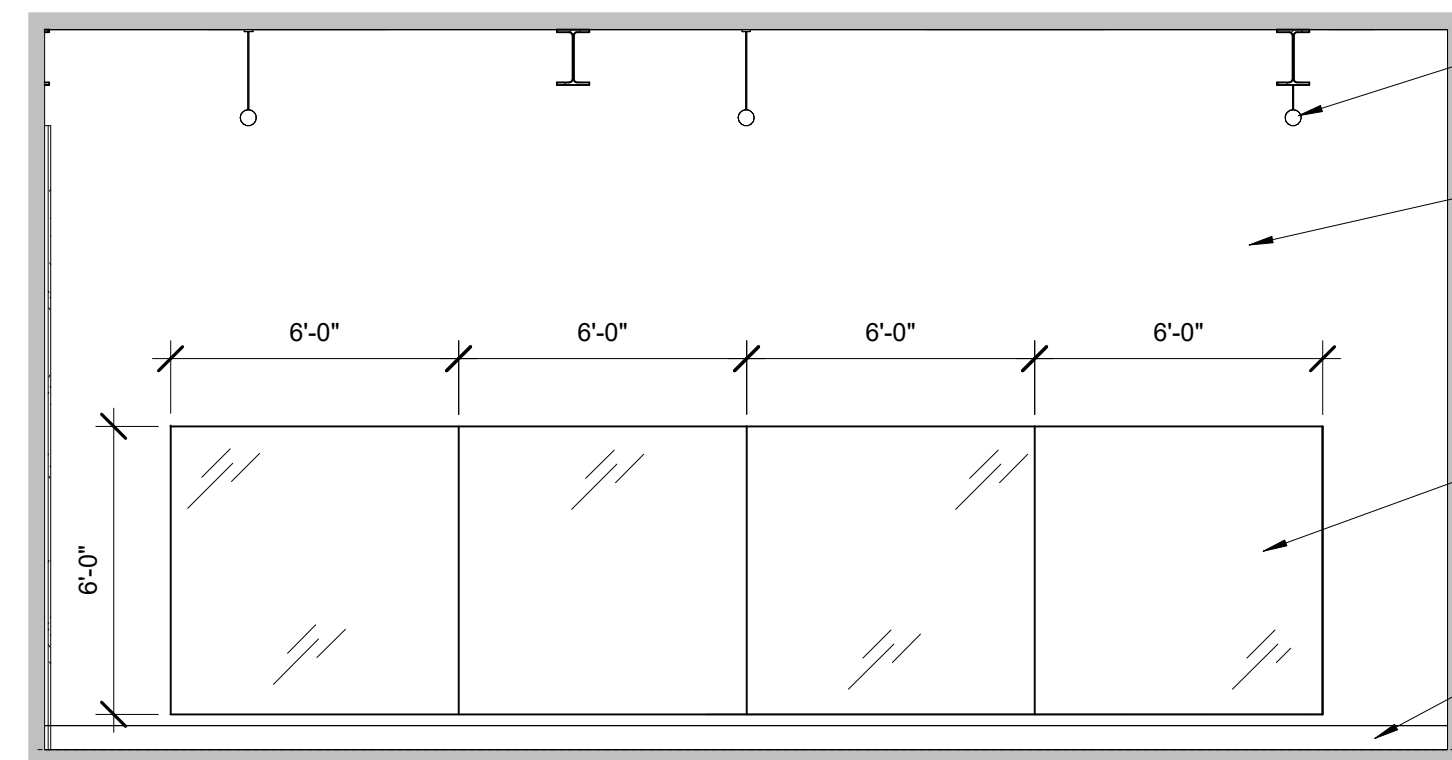


15 FITNESS
1/4" = 1'-0"

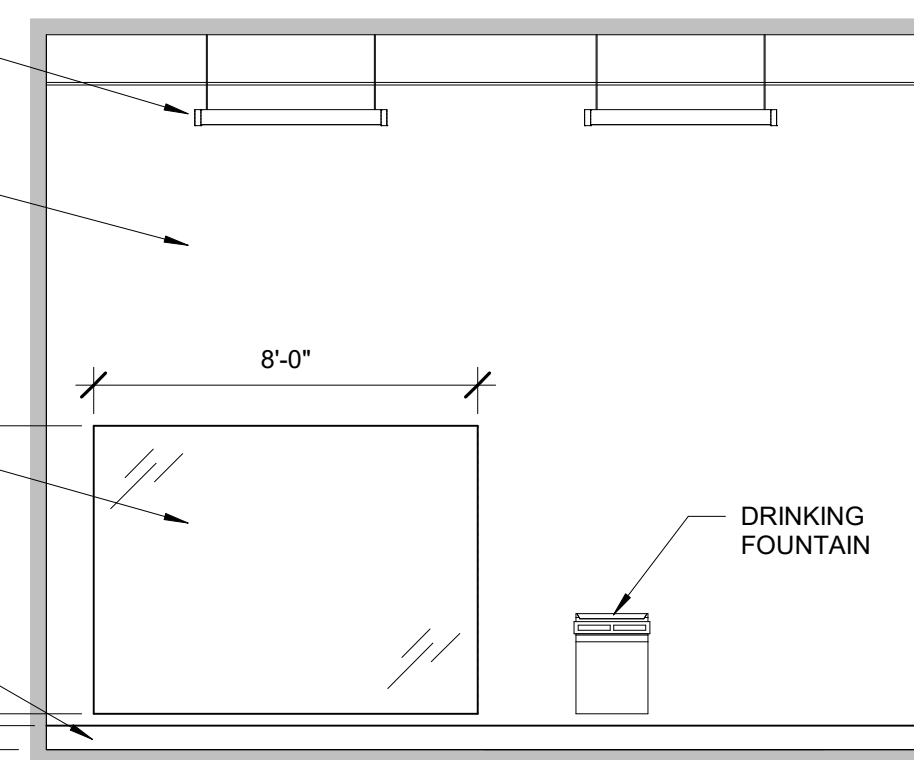


14 FITNESS
1/4" = 1'-0"

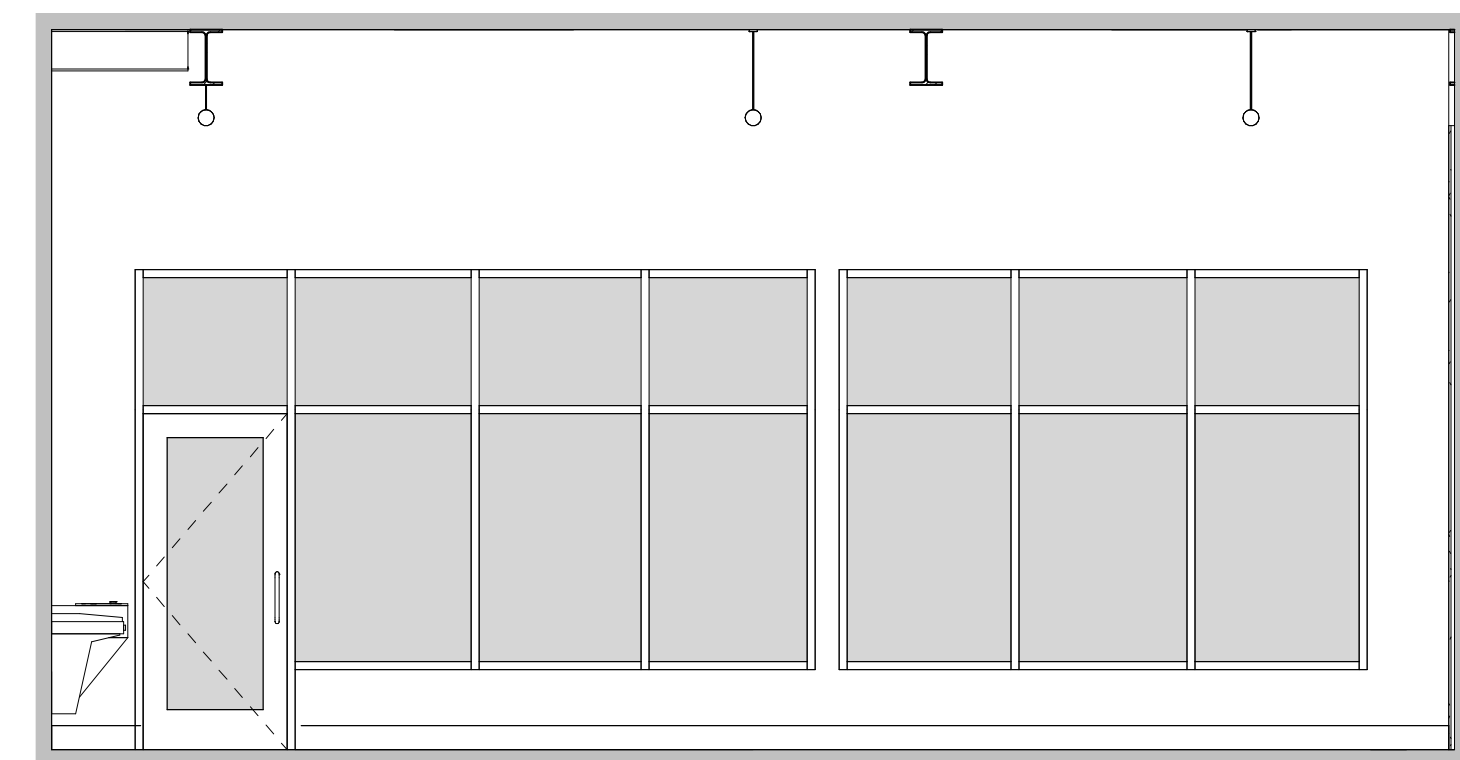


13 FITNESS
1/4" = 1'-0"

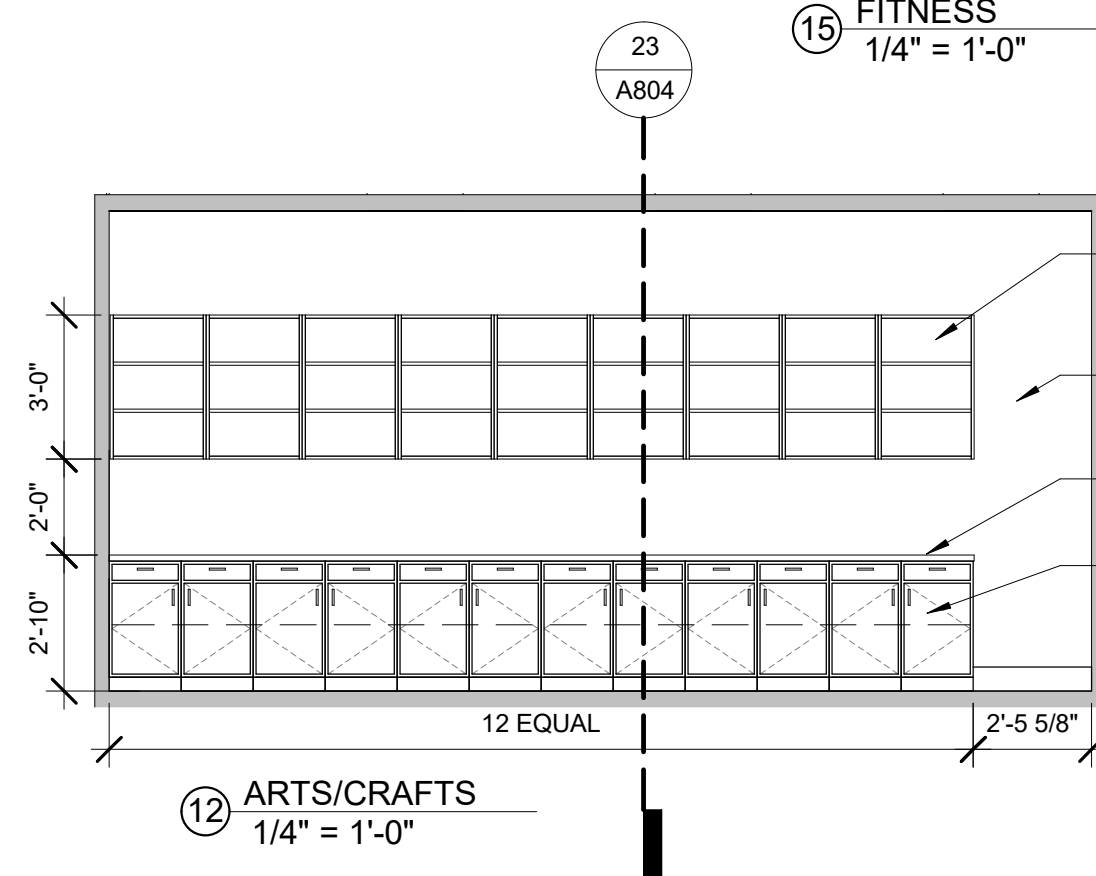


12 ARTS/CRAFTS
1/4" = 1'-0"

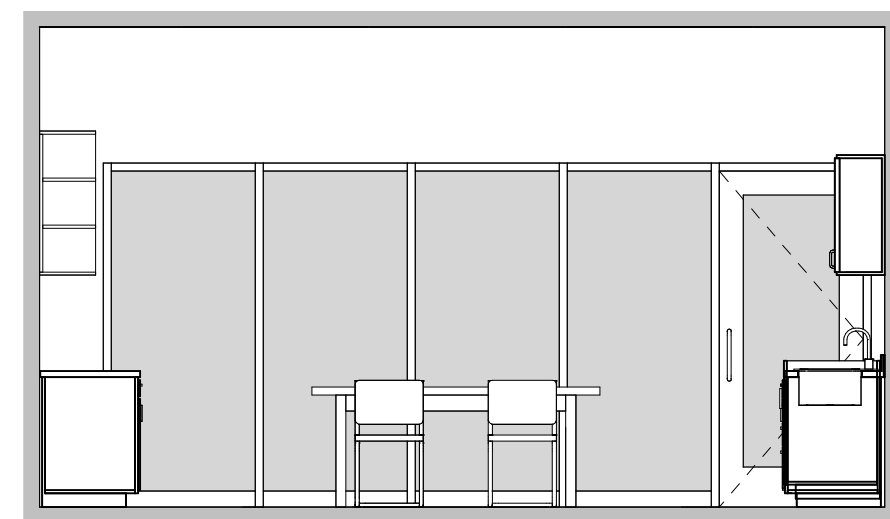


11 ARTS/CRAFTS
1/4" = 1'-0"

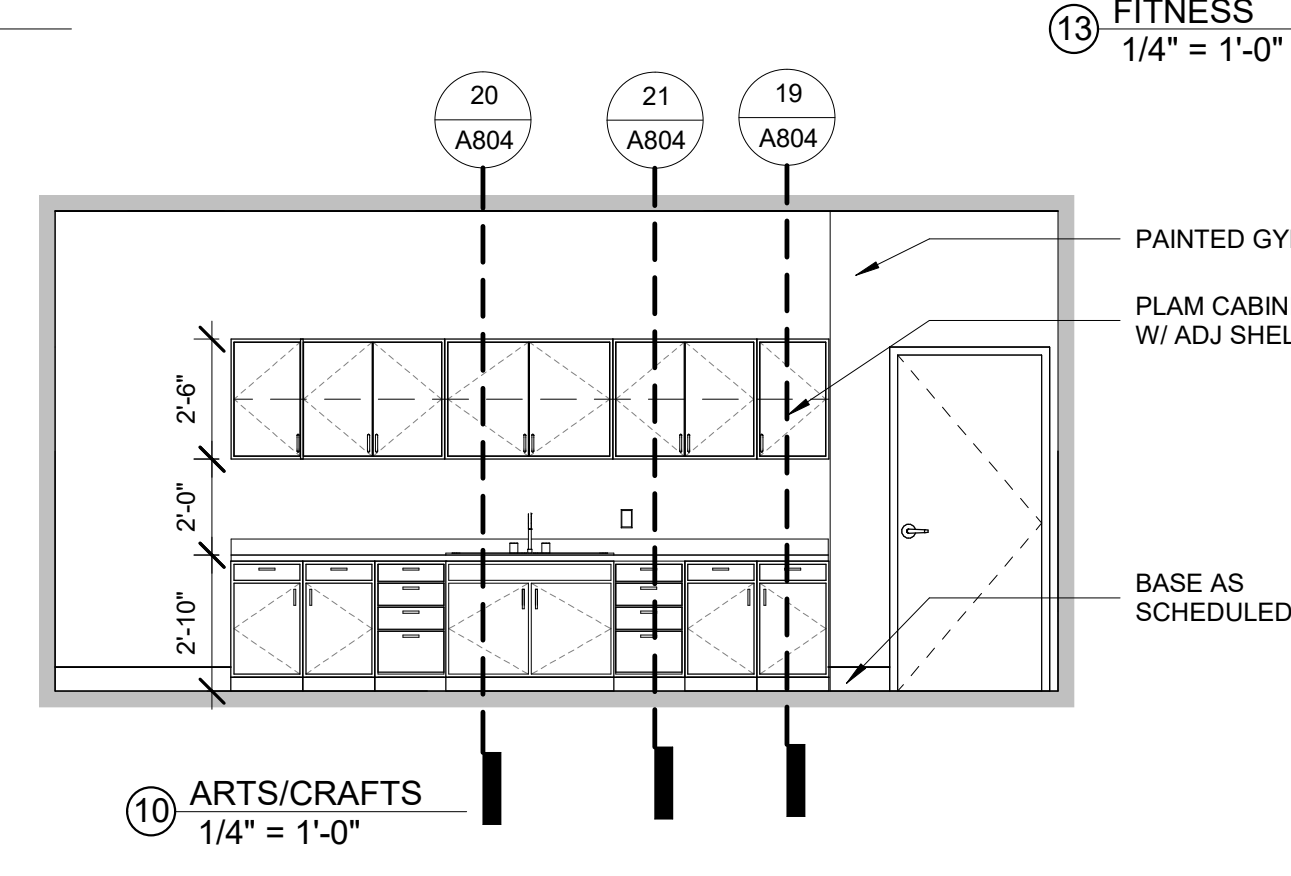


10 ARTS/CRAFTS
1/4" = 1'-0"

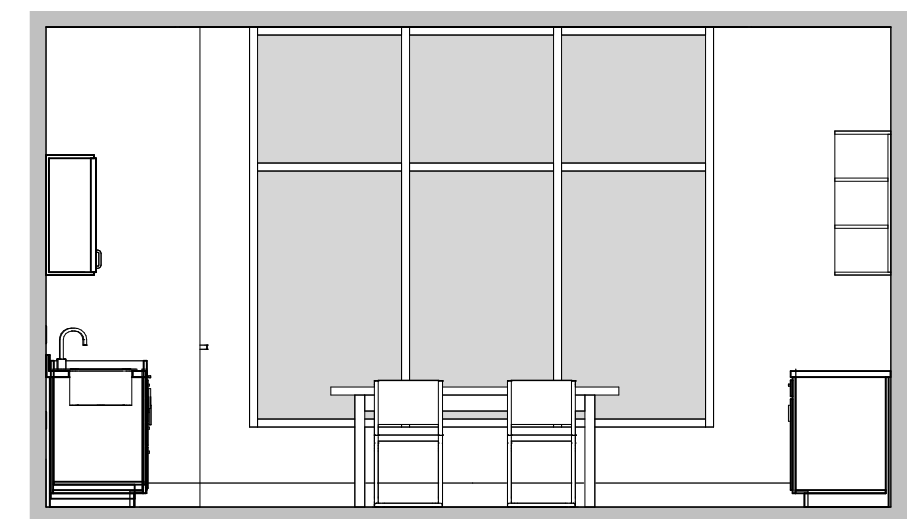


9 ARTS/CRAFTS
1/4" = 1'-0"

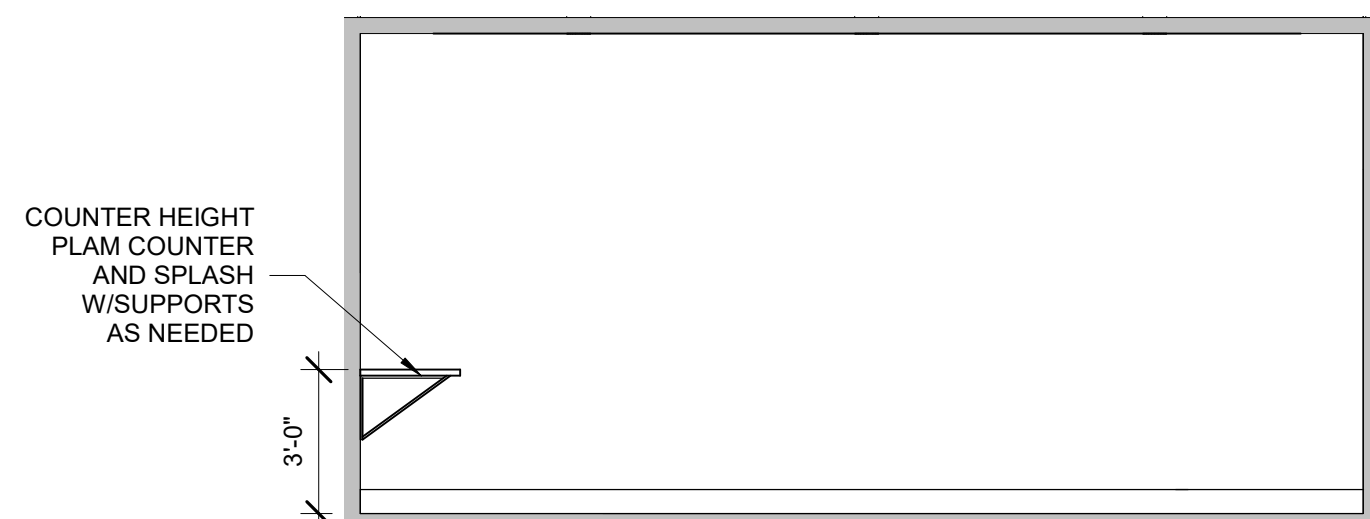


8 STUDY READING ROOM
1/4" = 1'-0"

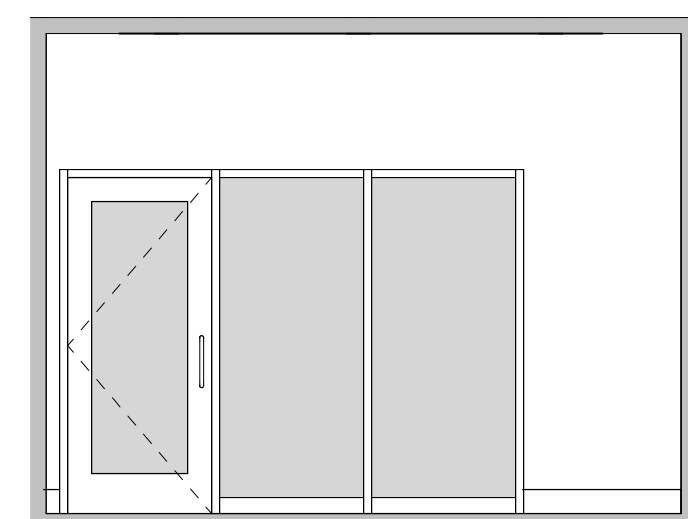


7 STUDY READING ROOM
1/4" = 1'-0"

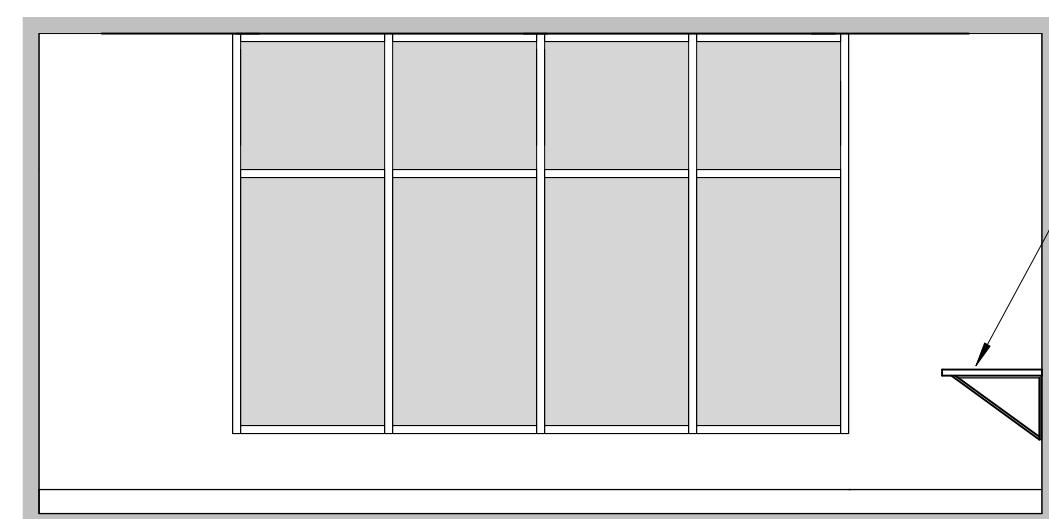


6 STUDY READING ROOM
1/4" = 1'-0"

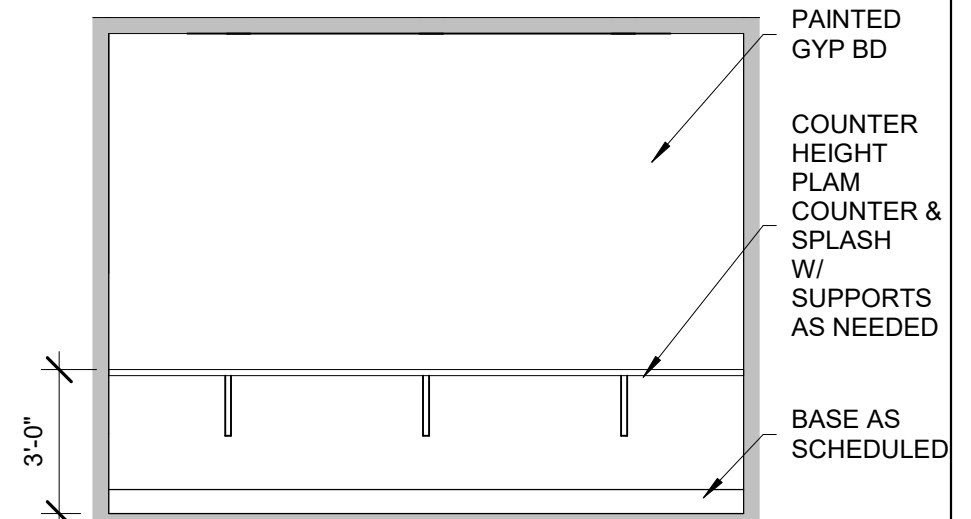


5 STUDY READING ROOM
1/4" = 1'-0"

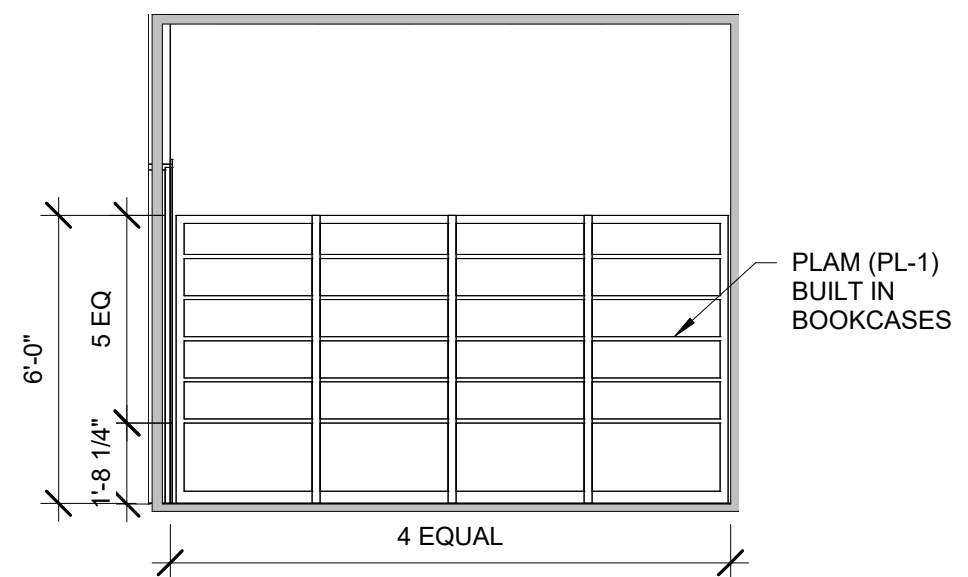


4 ADULT READING
1/4" = 1'-0"

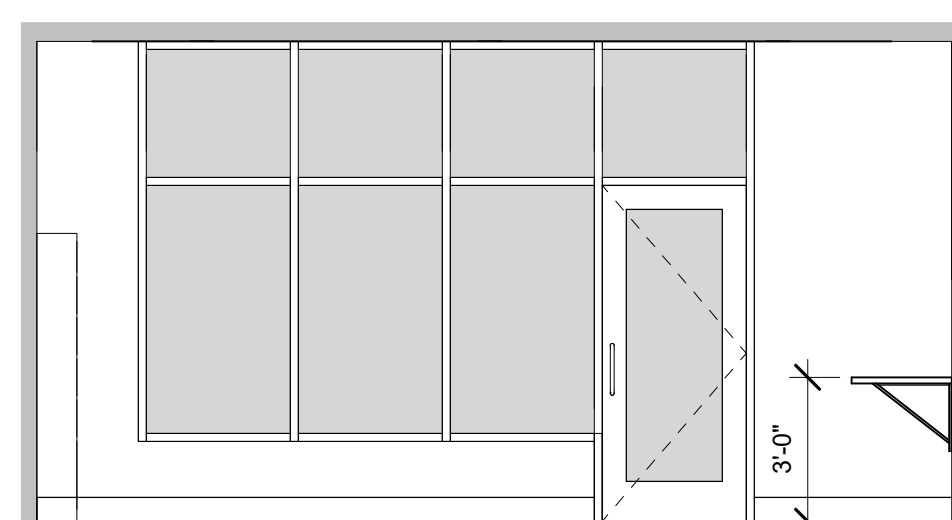


3 ADULT READING
1/4" = 1'-0"

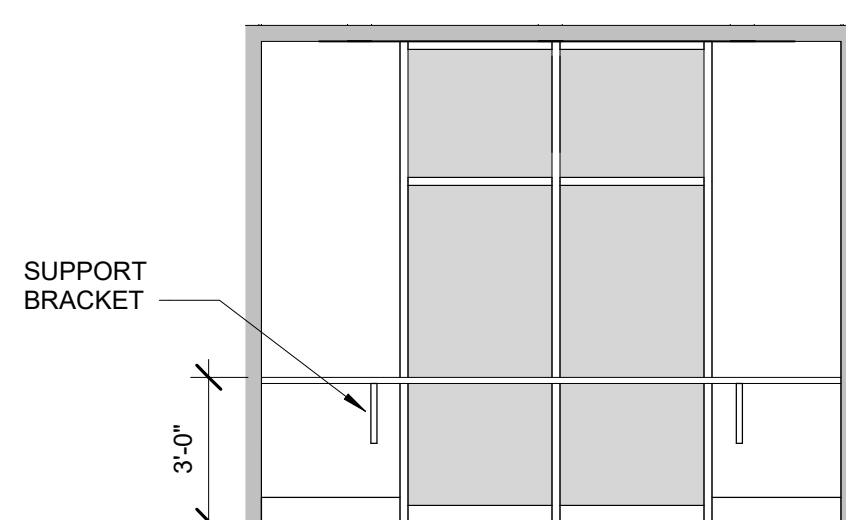

2 ADULT READING
1/4" = 1'-0"

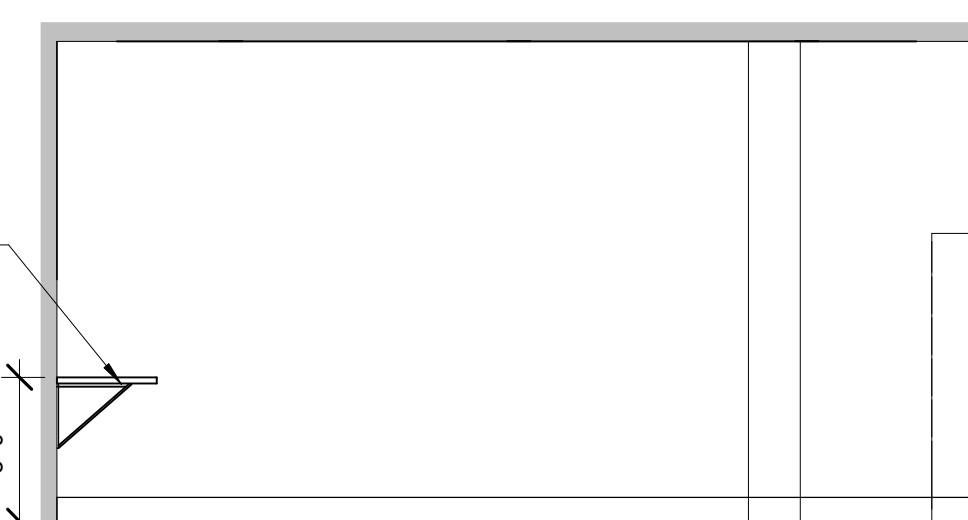

1 ADULT READING
1/4" = 1'-0"

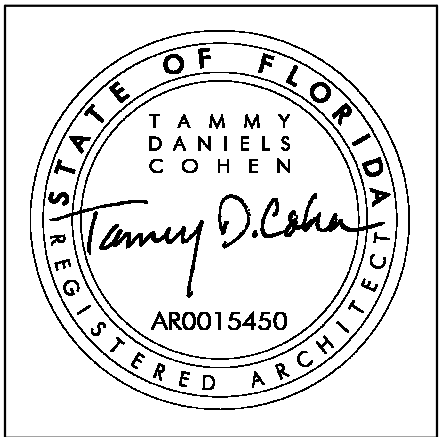

CCR ARCHITECTURE & INTERIORS

MARTIN LUTHER KING JR. RECREATION CENTER
705 14TH COURT EAST
PANAMA CITY, FL 32401

JOB NUMBER:
21109


DATE:
05/18/2023

PRINTED / REVISIONS
DESCRIPTION DATE


SHEET TITLE:
INTERIOR ELEVATIONS

SHEET NUMBER:
A803


05/18/2023 10:28 PM
THIS DRAWING IS THE PROPERTY OF CCR ARCHITECTURE & INTERIORS AND IS NOT TO BE REPRODUCED, COPIED OR ALTERED IN WHOLE OR IN PART OR USED FOR ANY PURPOSE WITHOUT THE APPROVAL OF CCR ARCHITECTURE & INTERIORS AND IS TO BE RETURNED UPON REQUEST.
705 14TH COURT EAST
PANAMA CITY, FL 32401
205-324-8864
CCR ARCHITECTURE & INTERIORS

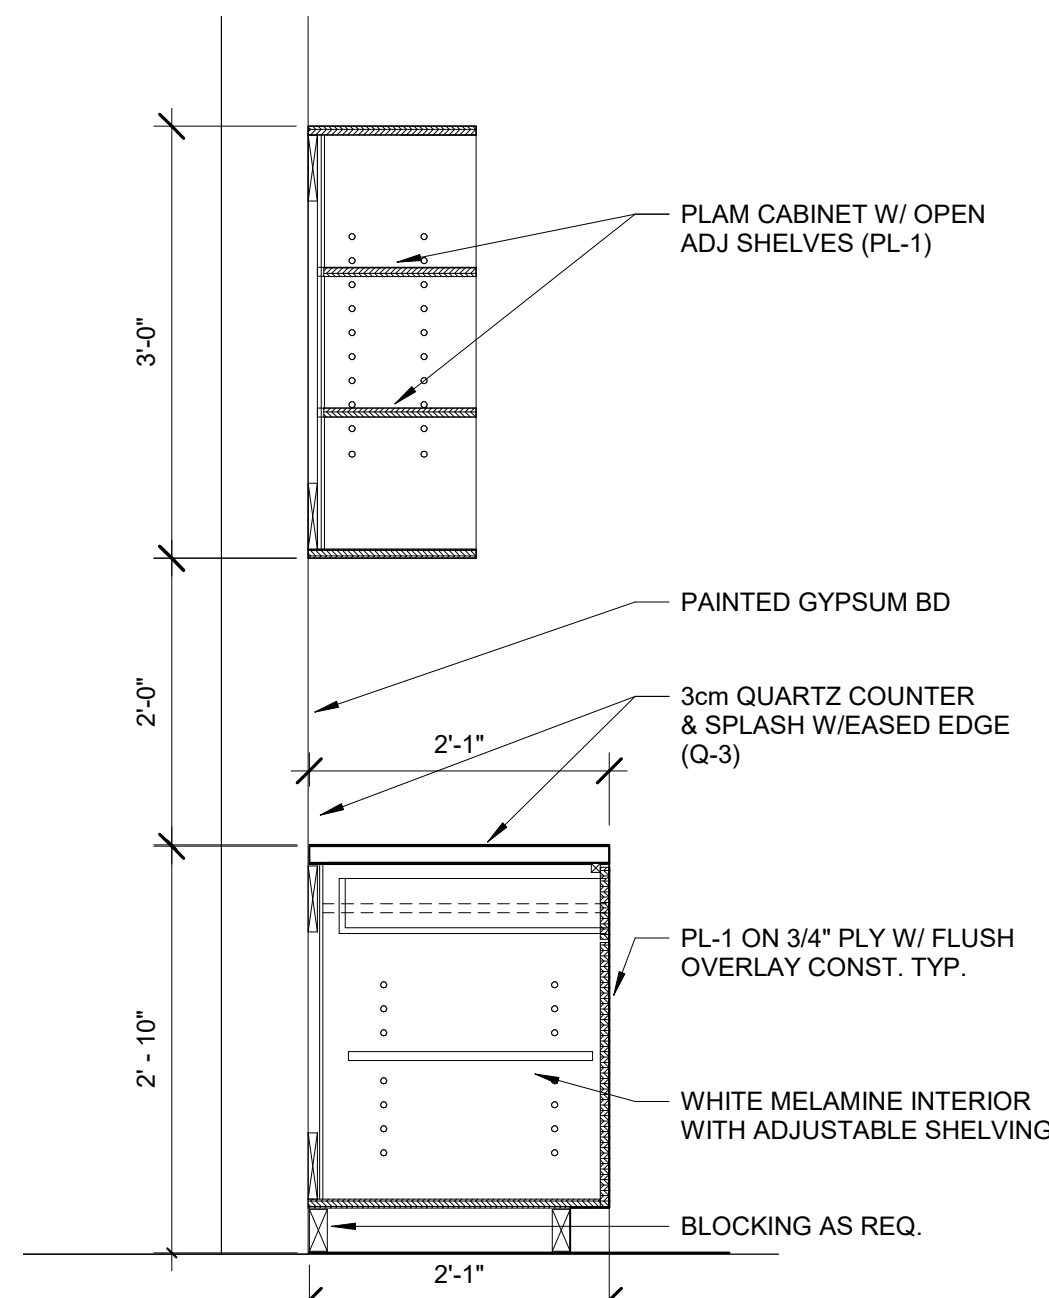


23 MILLWORK SECTION OPEN SHELVES ABOVE
3/4" = 1'-0"

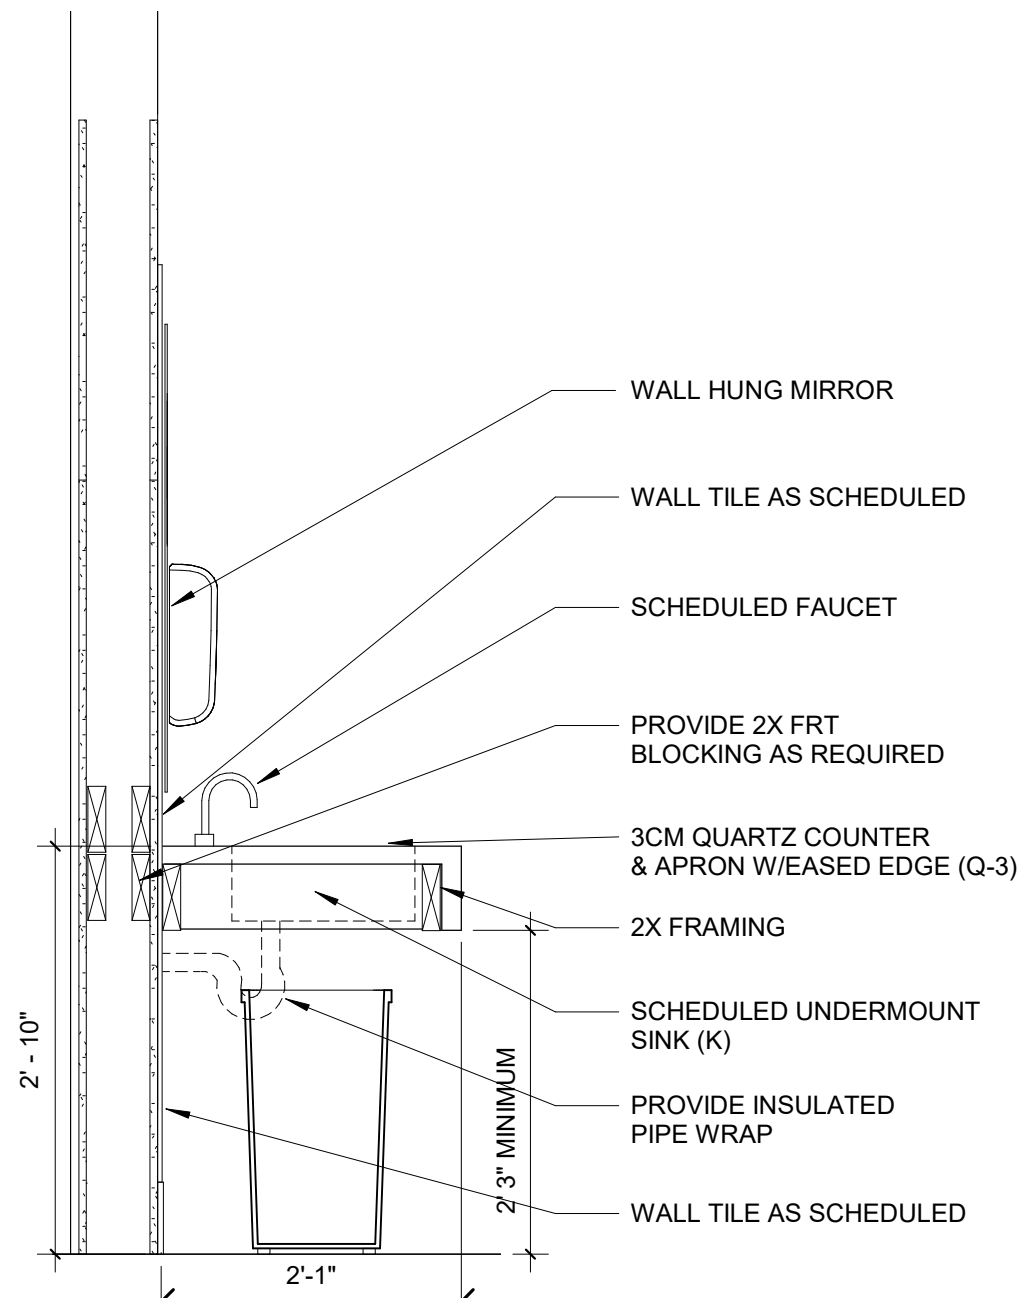


22 LAVATORY SECTION
3/4" = 1'-0"

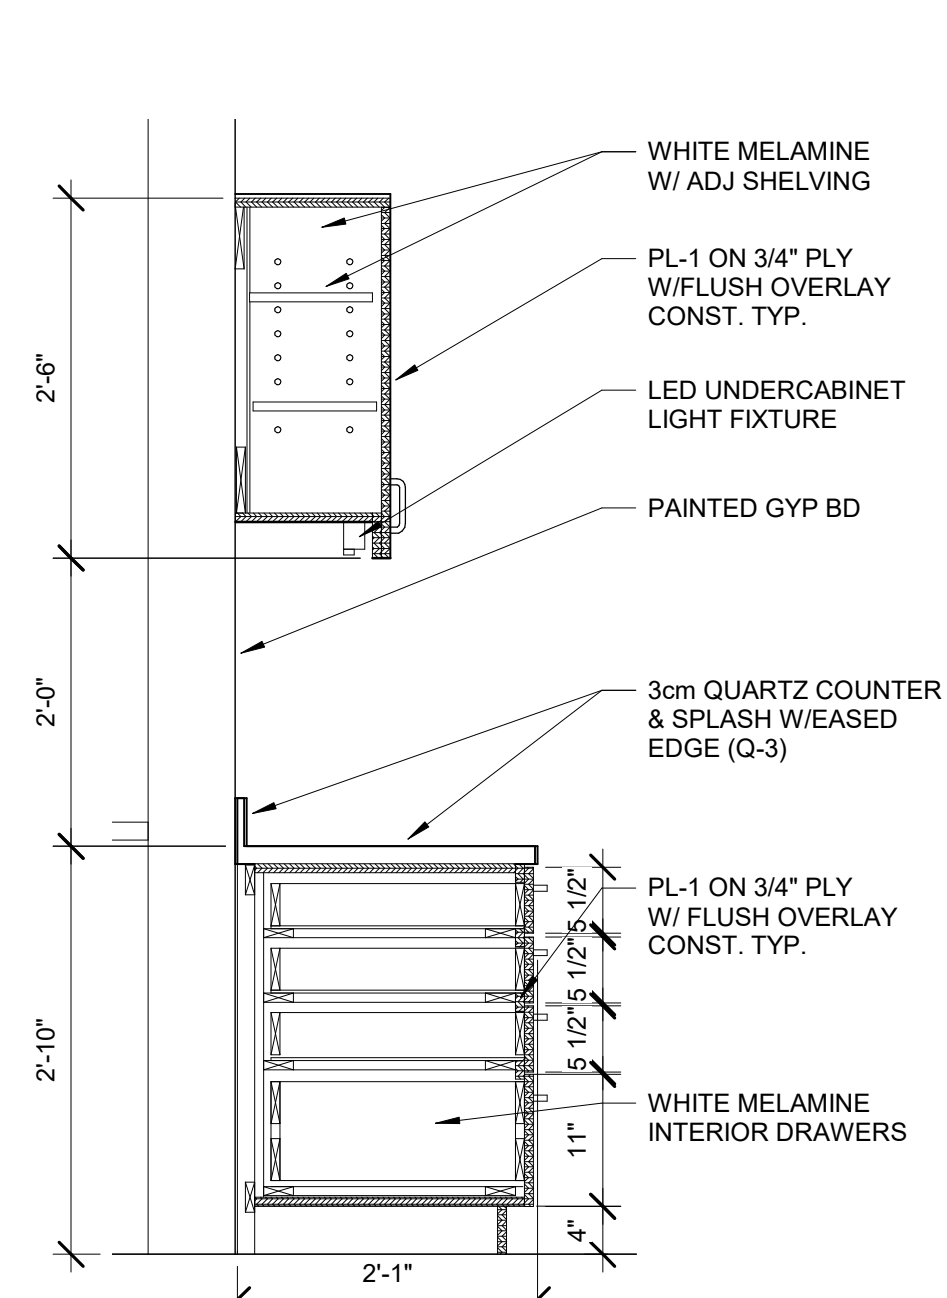


21 FOUR DRAWER MILLWORK SECTION
3/4" = 1'-0"

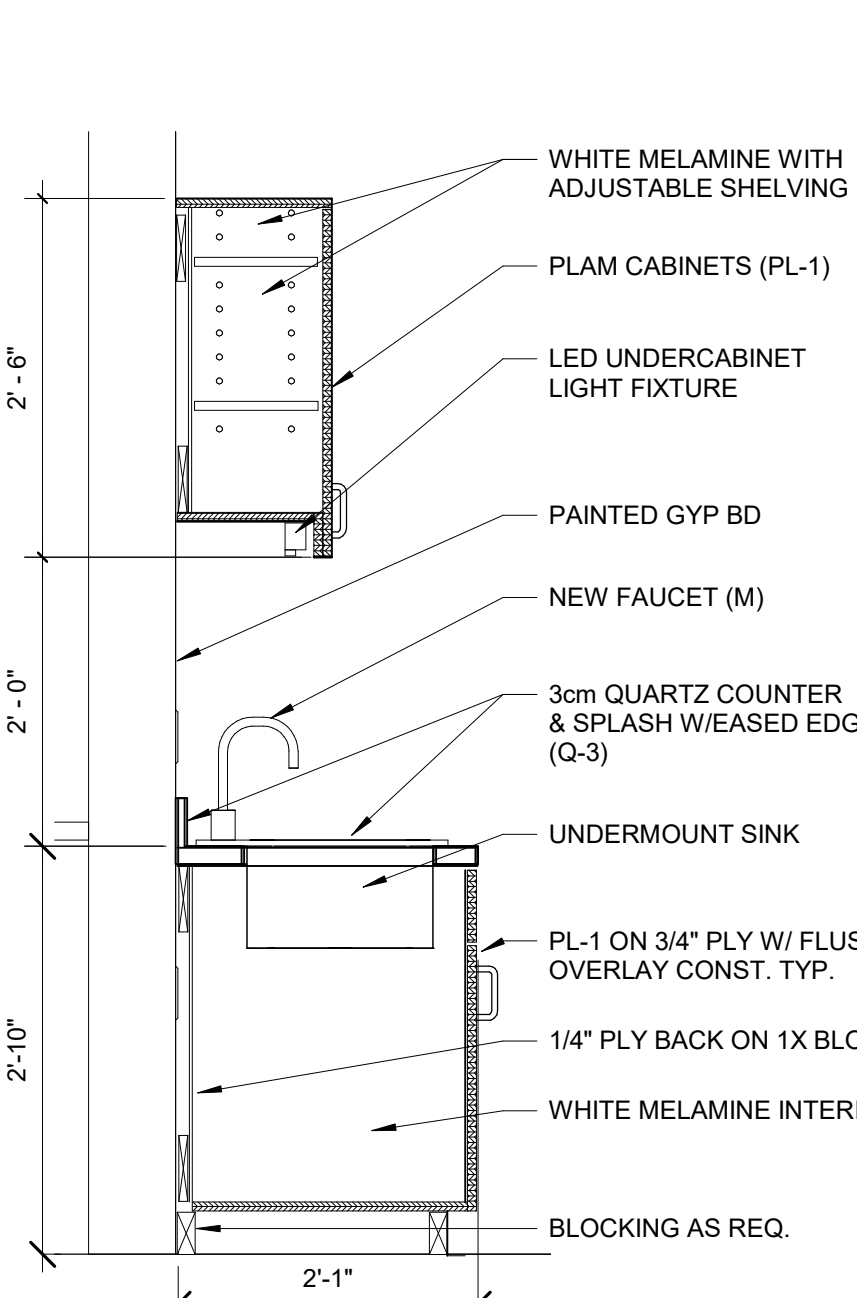


20 MILLWORK SECTION AT SINK
3/4" = 1'-0"

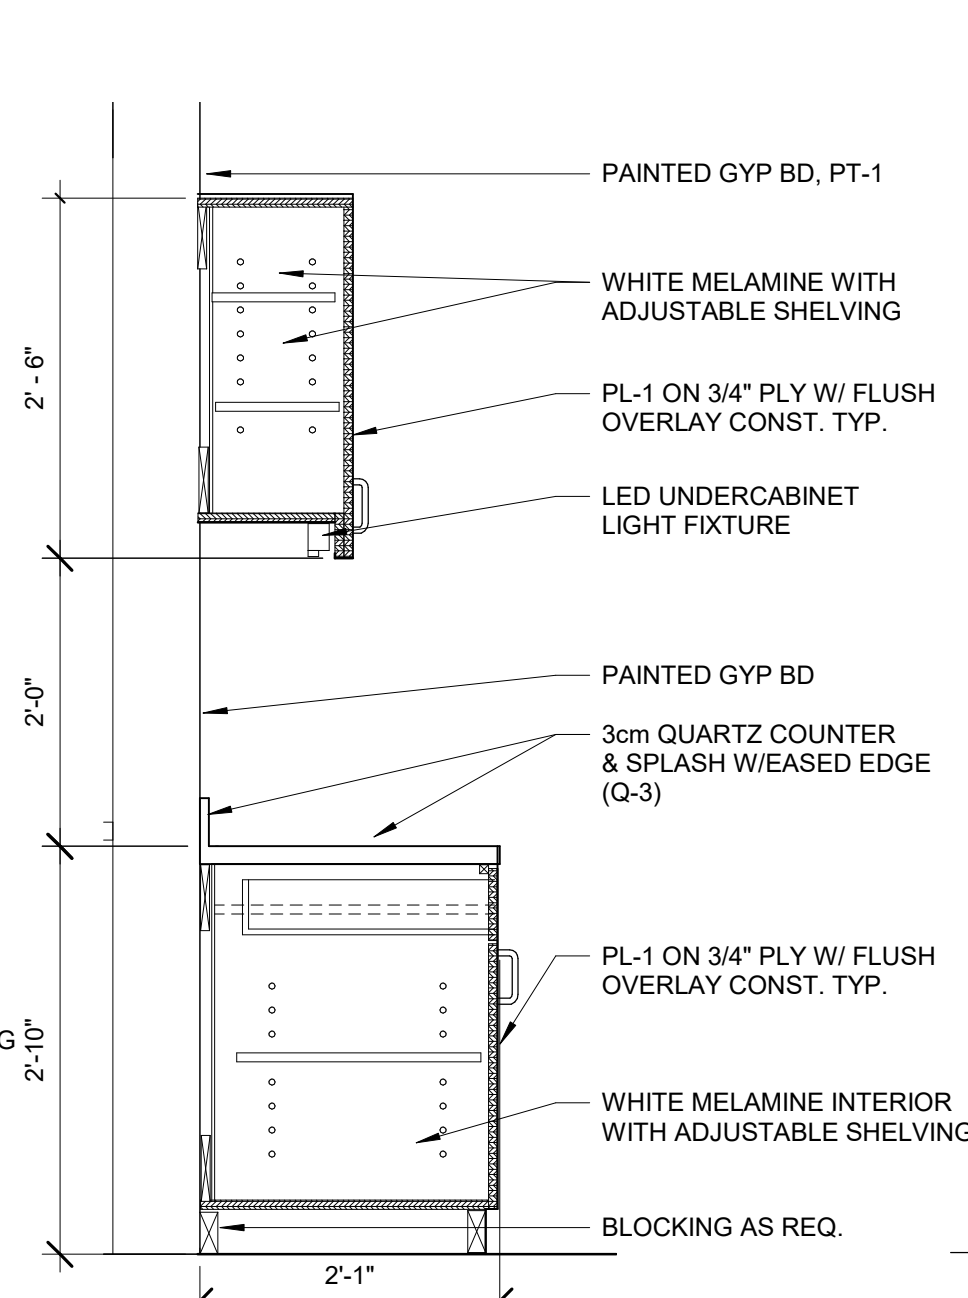


19 MILLWORK SECTION
3/4" = 1'-0"

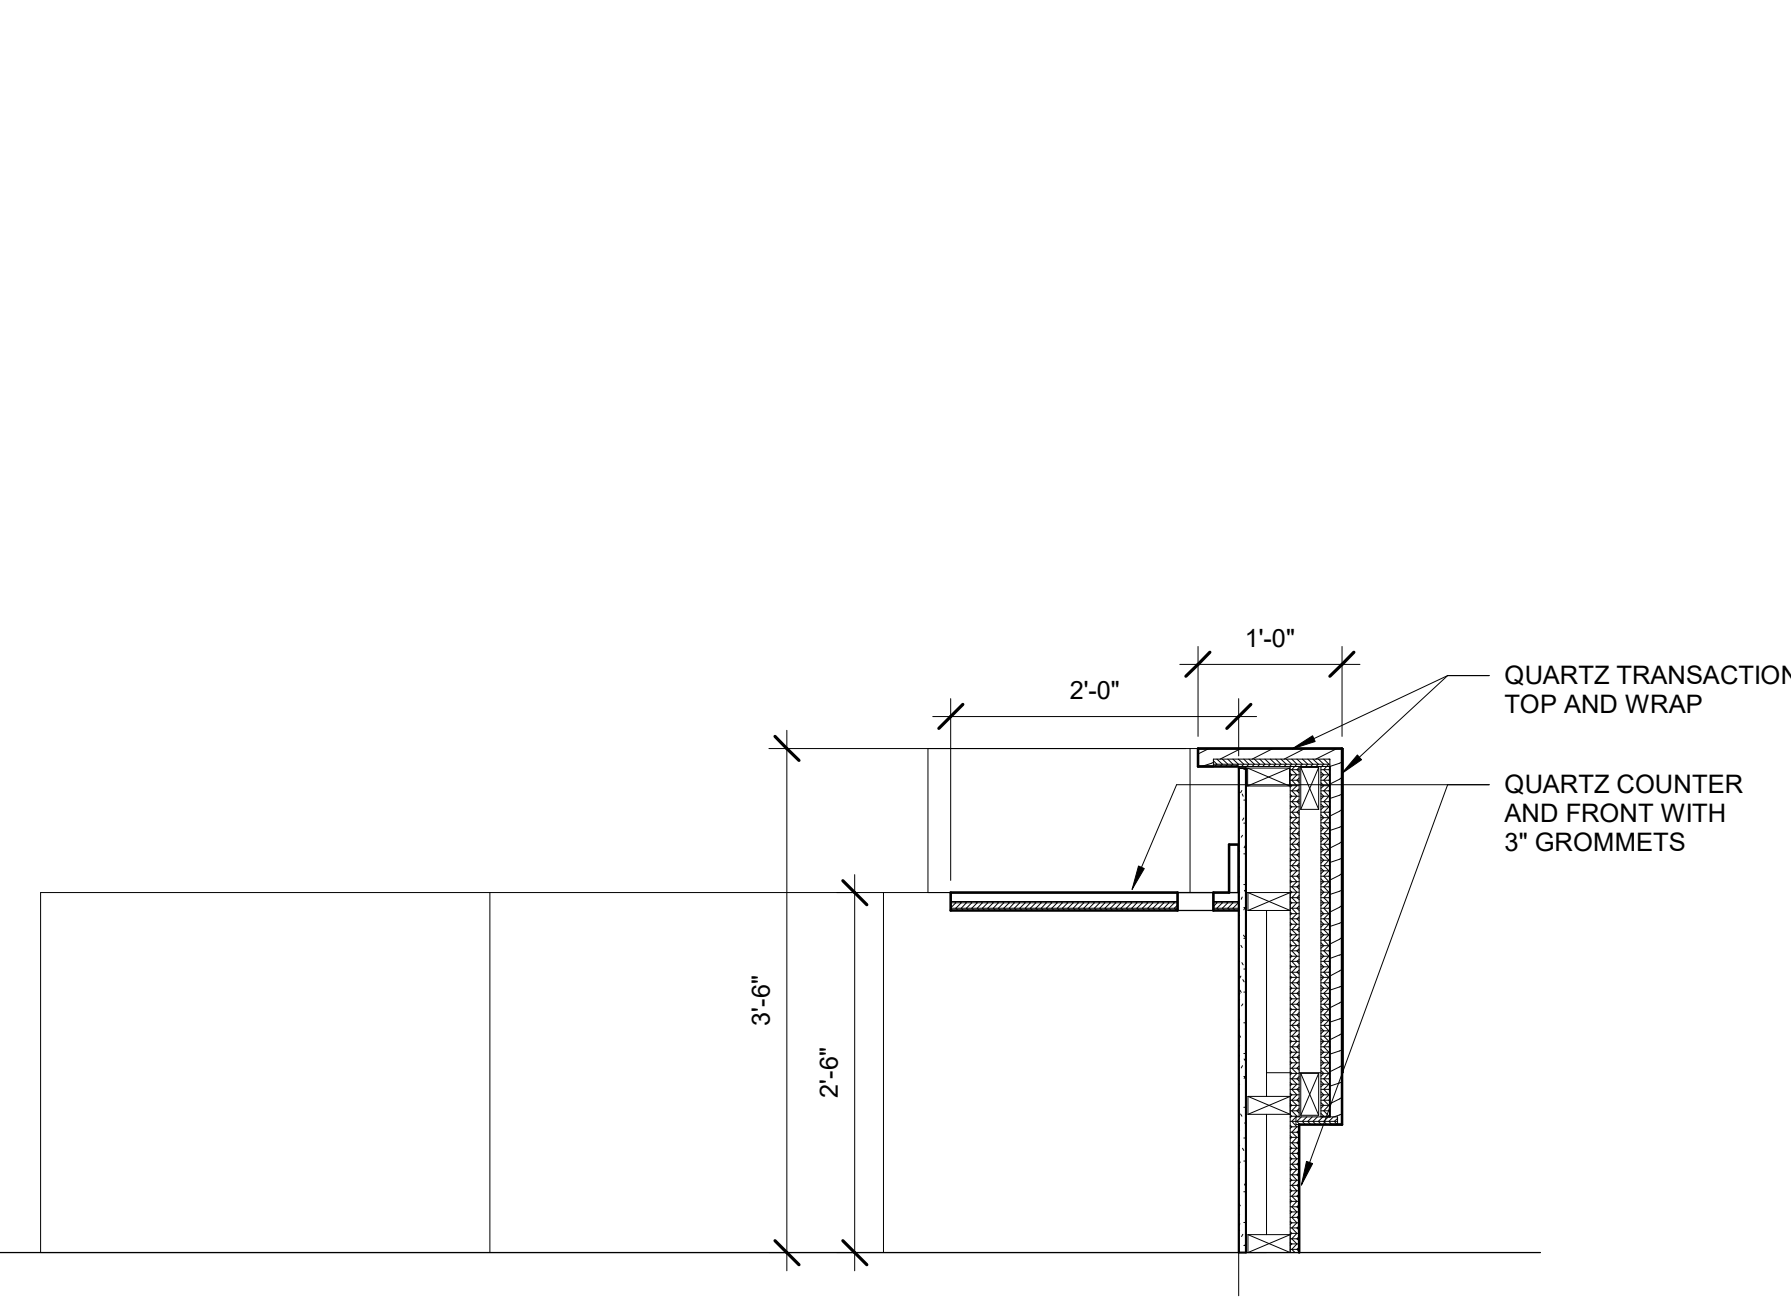


18 RECEPTION DESK
3/4" = 1'-0"

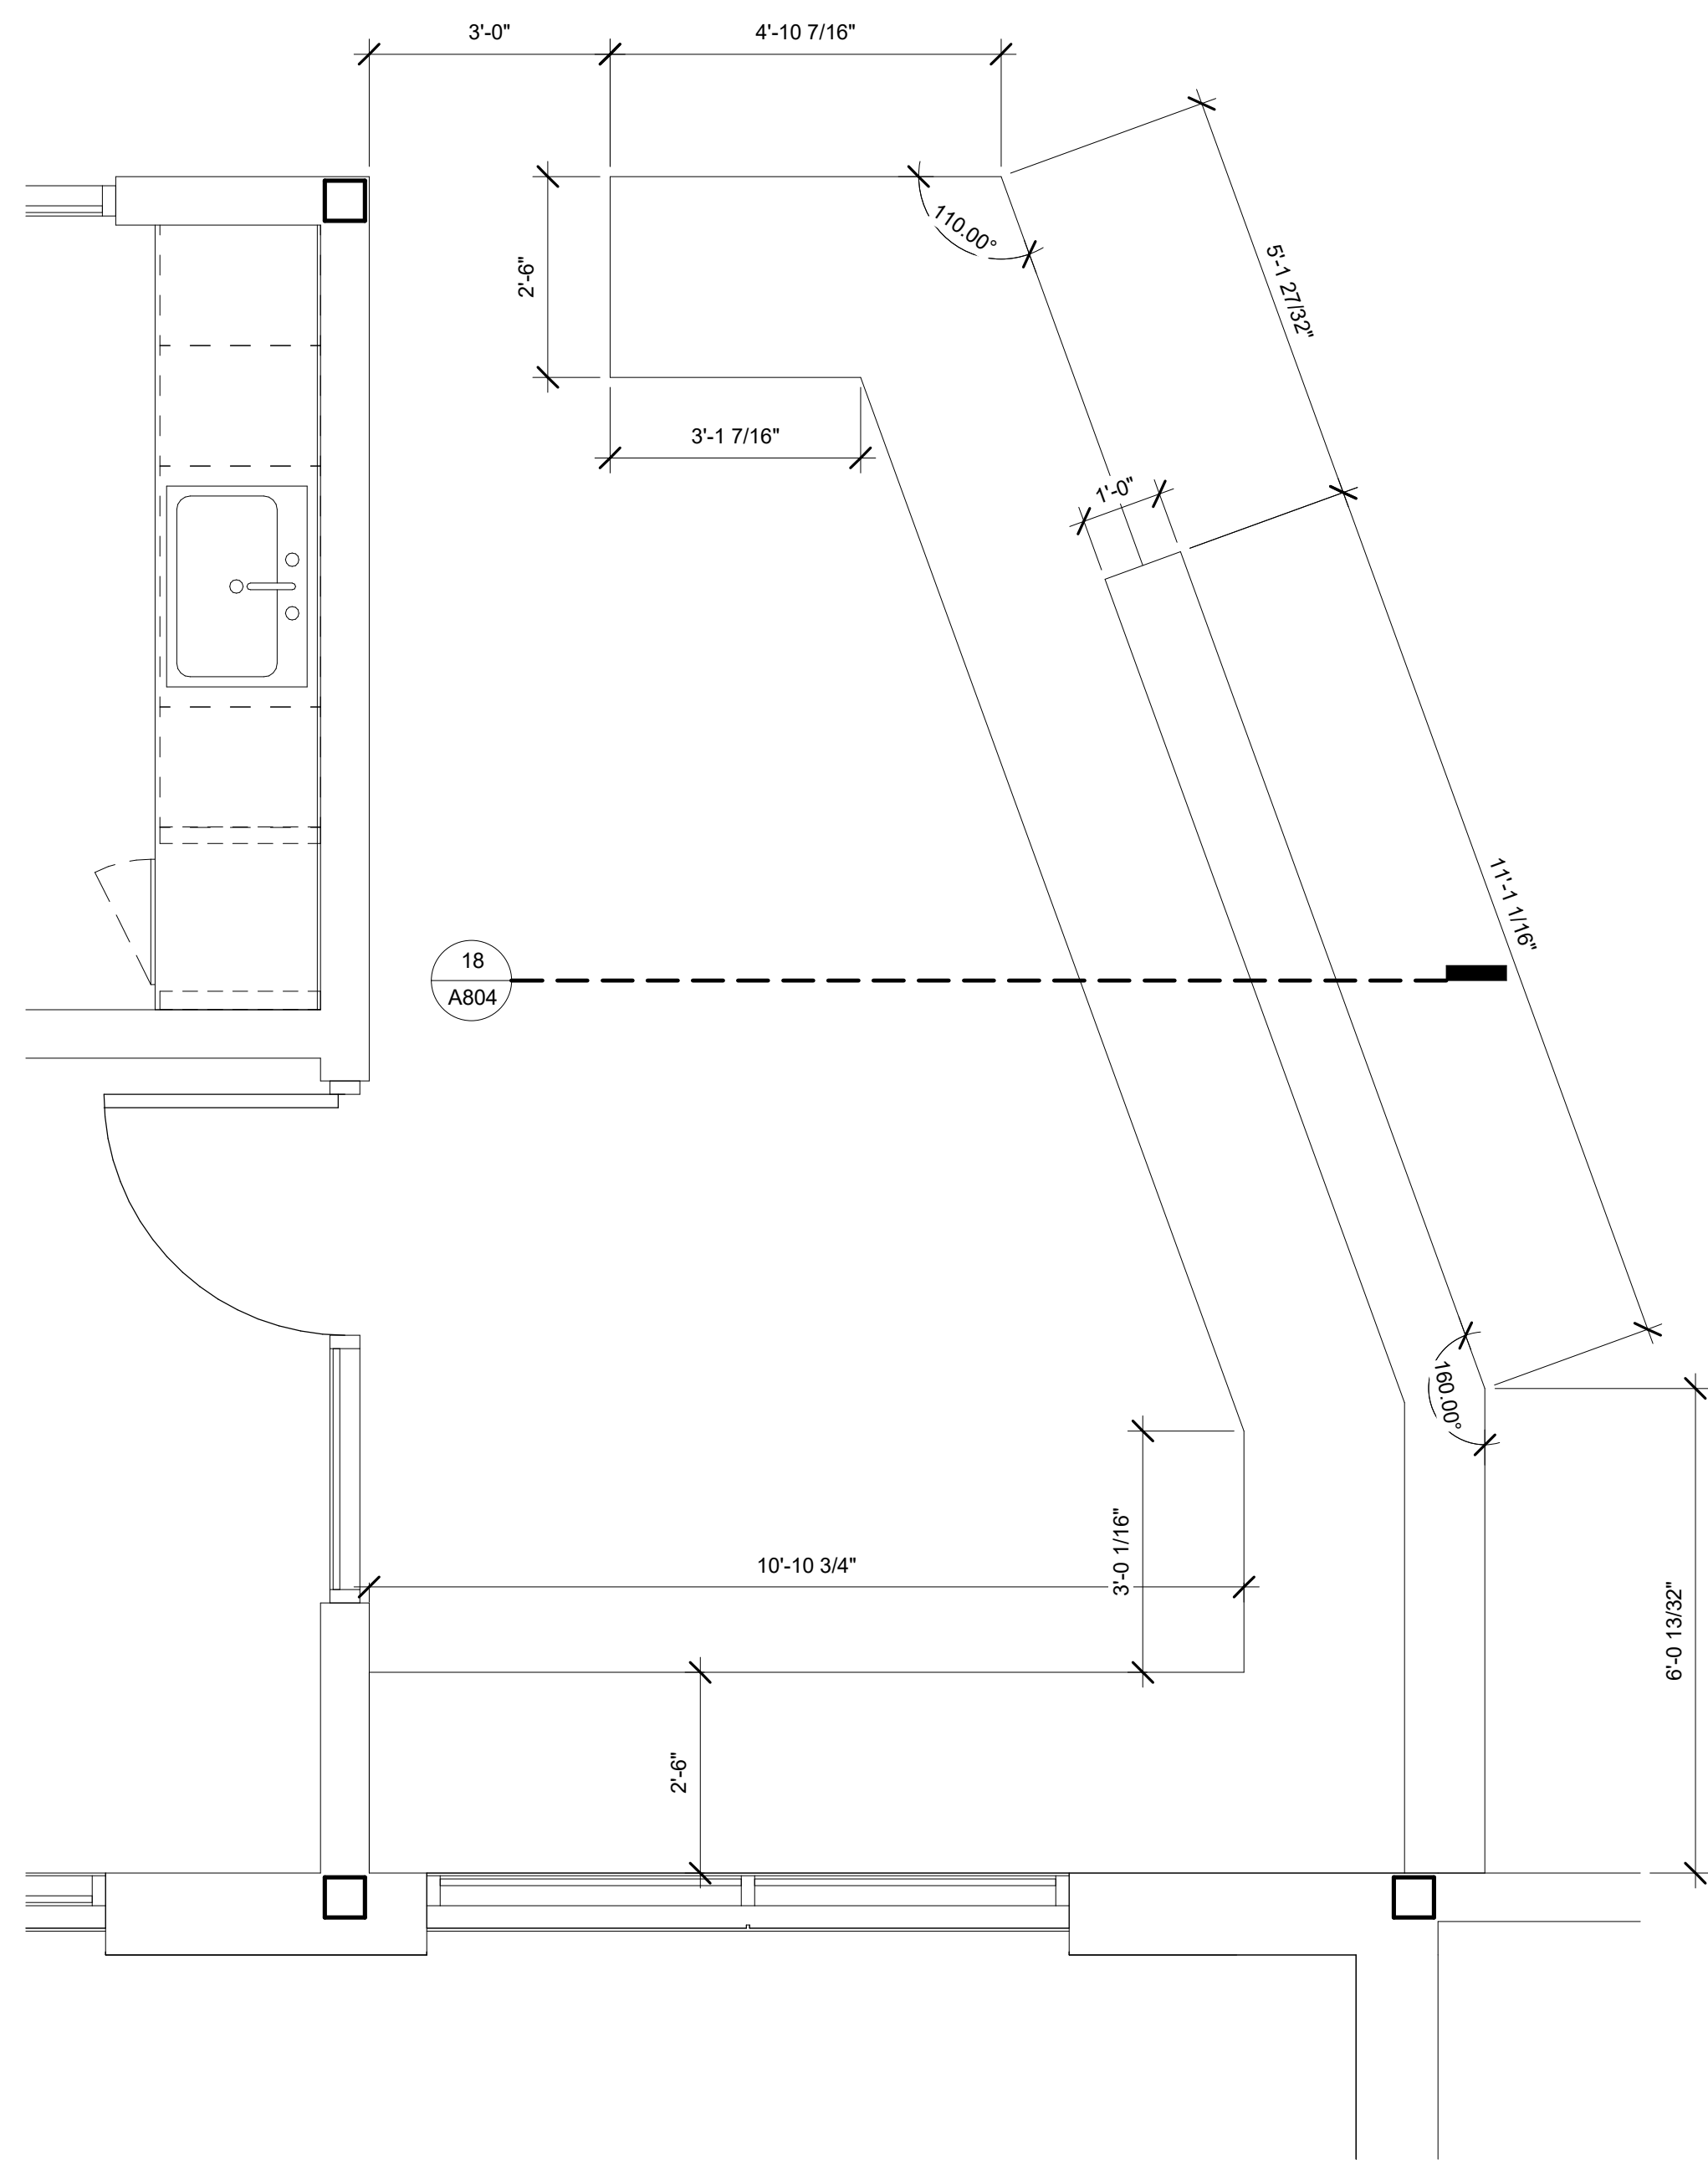


5 RECEPTION DESK ENLARGED PLAN
1/2" = 1'-0"

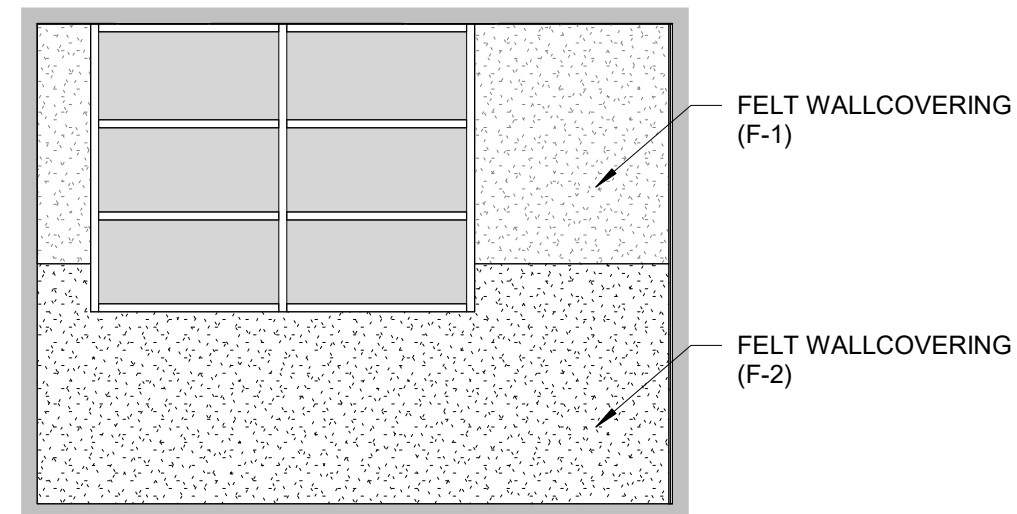


4 RECORDING STUDIO
1/4" = 1'-0"

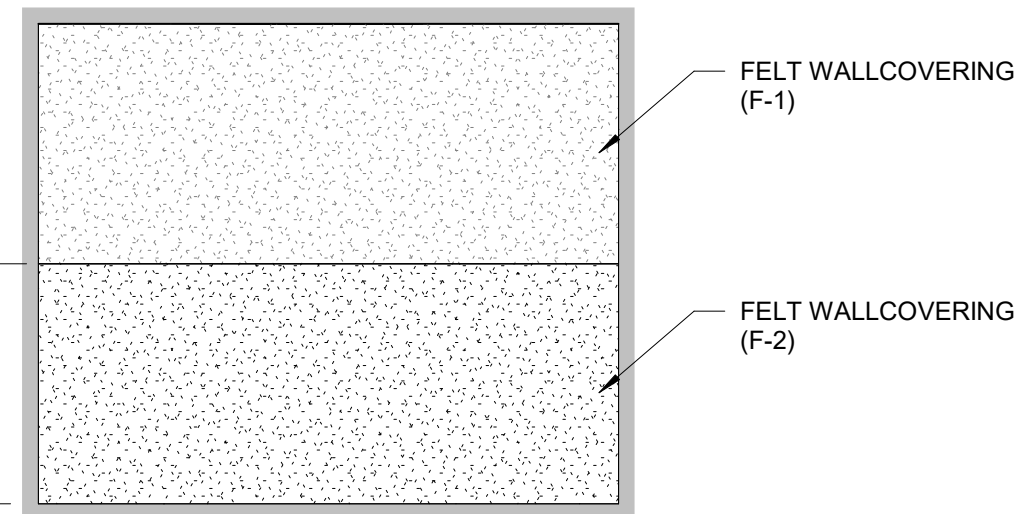


3 RECORDING STUDIO
1/4" = 1'-0"

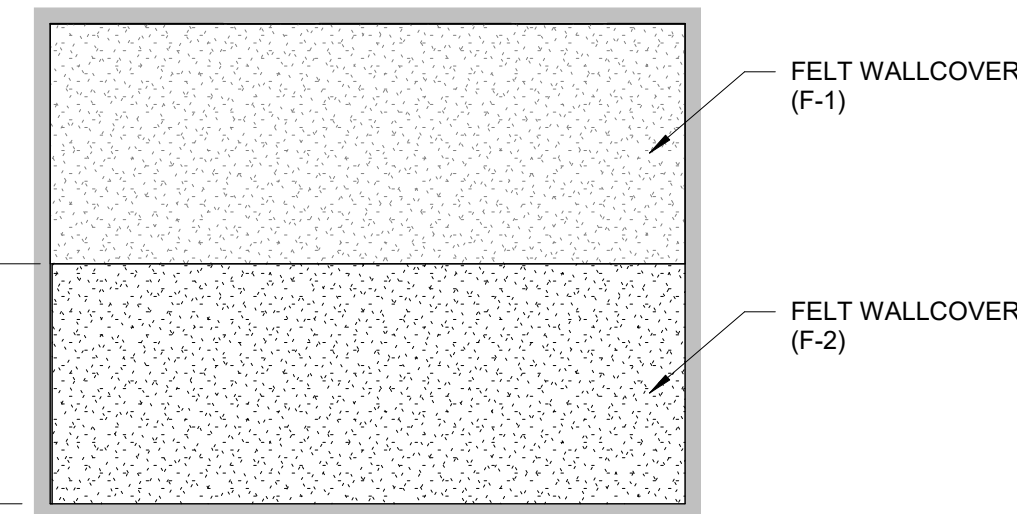


2 RECORDING STUDIO
1/4" = 1'-0"

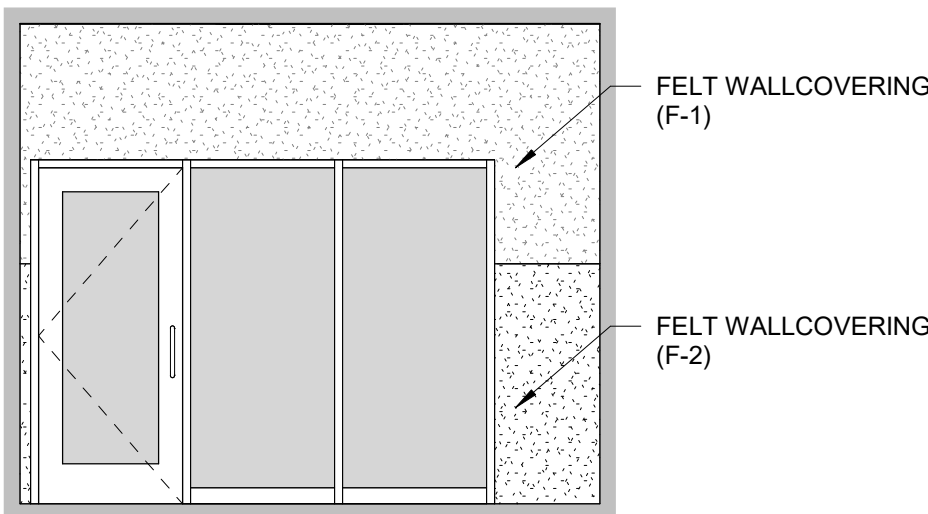


1 RECORDING STUDIO
1/4" = 1'-0"

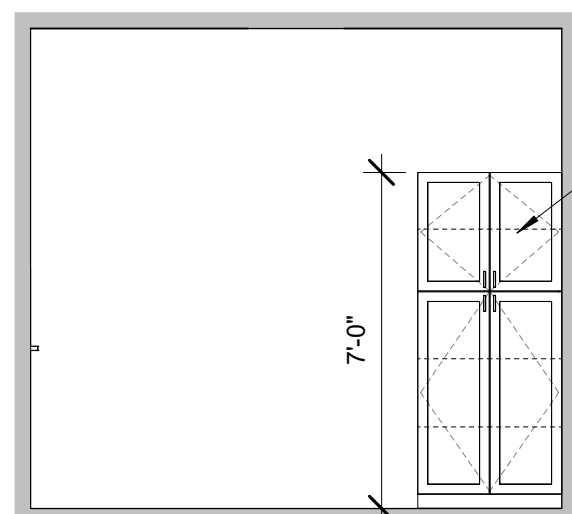


13 LAUNDRY
1/4" = 1'-0"

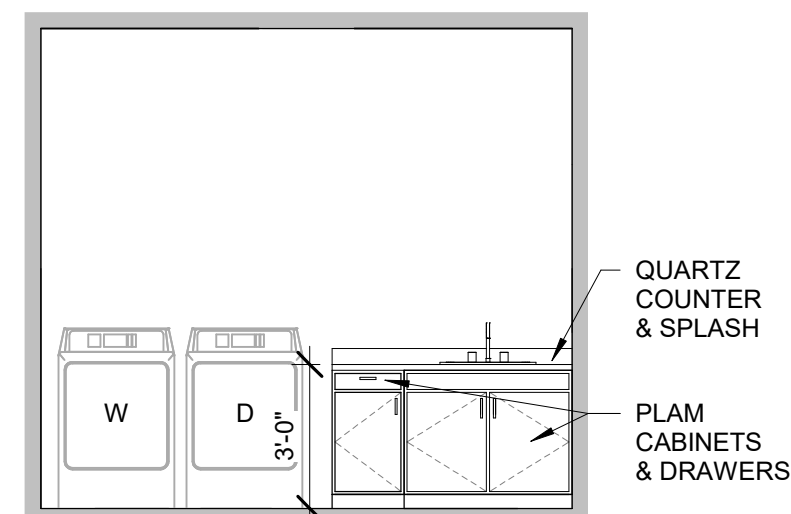


12 LAUNDRY
1/4" = 1'-0"

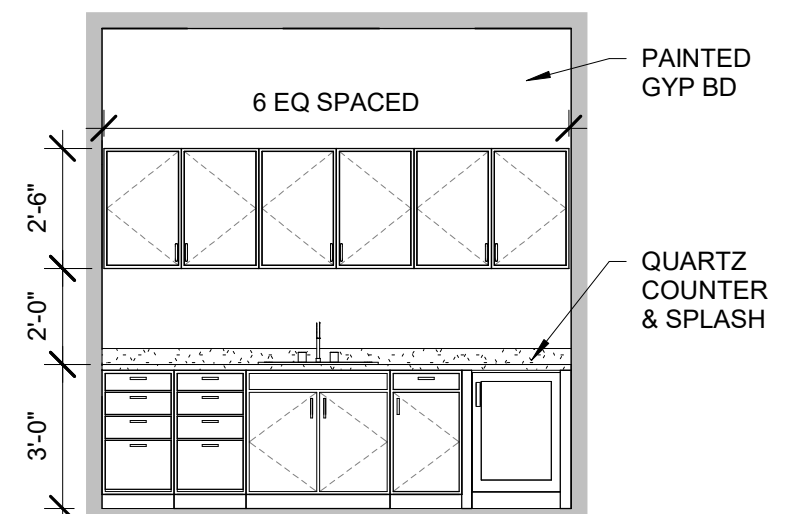


11 FIRST AID
1/4" = 1'-0"

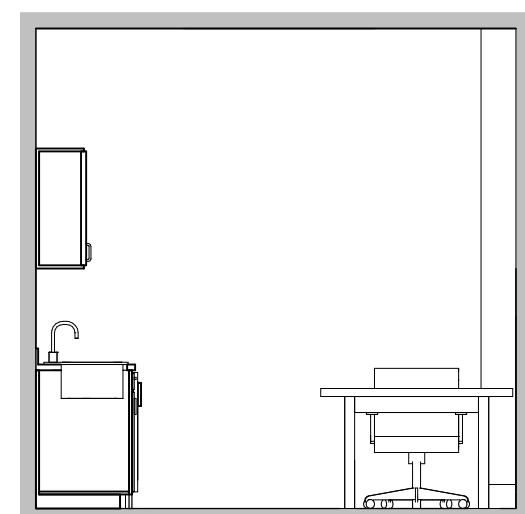


10 FIRST AID
1/4" = 1'-0"

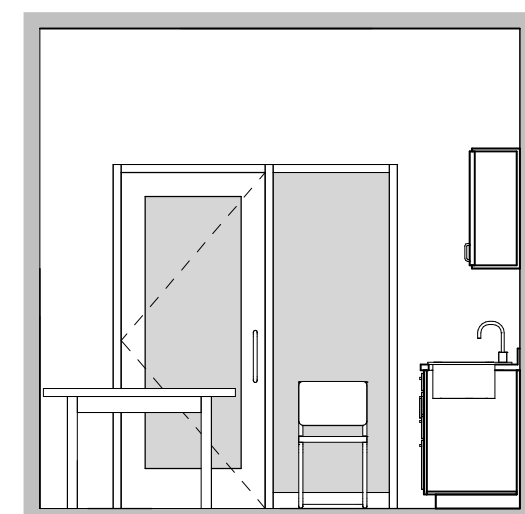


09 FIRST AID
1/4" = 1'-0"

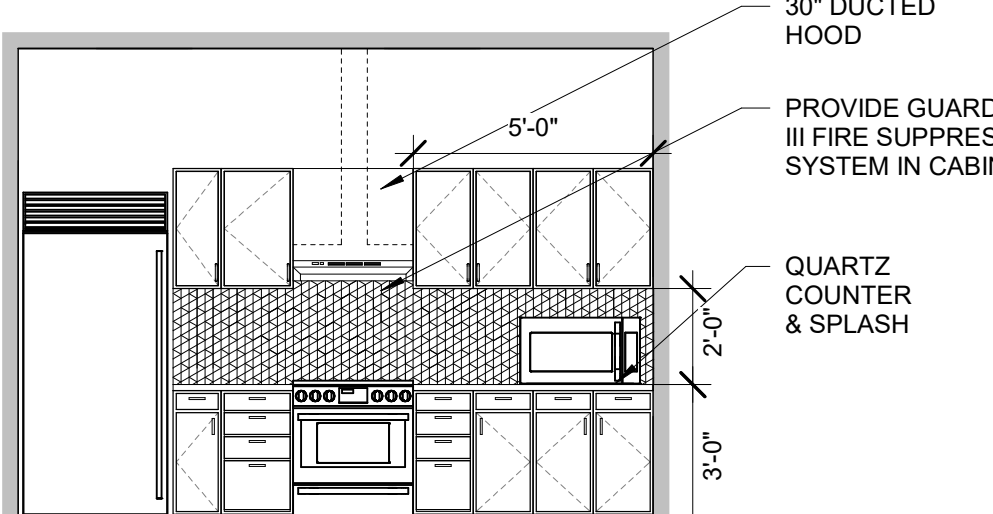

8 TEACHING KITCHEN
1/4" = 1'-0"

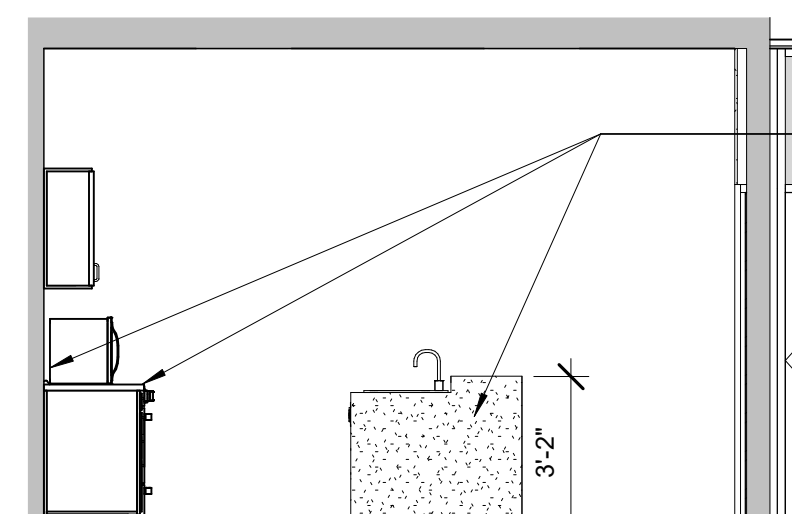

7 TEACHING KITCHEN
1/4" = 1'-0"

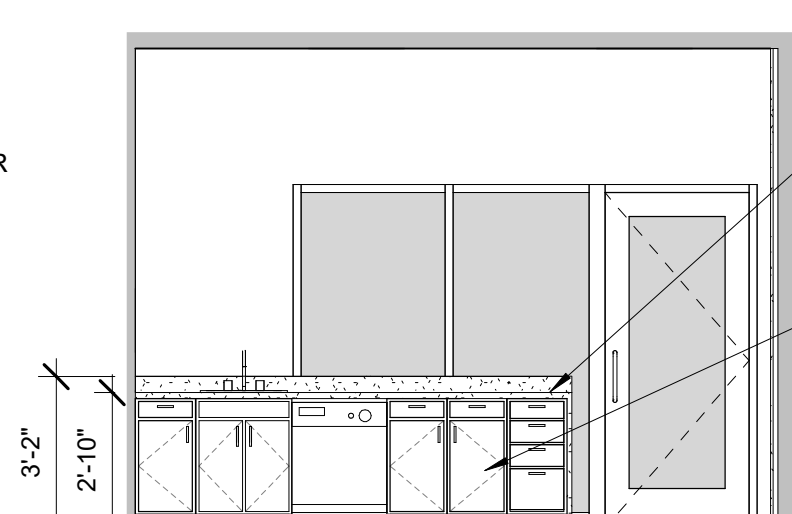

6 TEACHING KITCHEN
1/4" = 1'-0"

TAMMY DANIELS COHEN
ARCHITECT
A00015450

CCR ARCHITECTURE & INTERIORS

MARTIN LUTHER KING JR. RECREATION CENTER
705 14TH COURT EAST
PANAMA CITY, FL 32401

JOB NUMBER:
21109


DATE:
05/18/2023

PRINTED / REVISIONS
DESCRIPTION DATE


SHEET TITLE:
INTERIOR ELEVATIONS

SHEET NUMBER:
A804

DOOR LEGEND

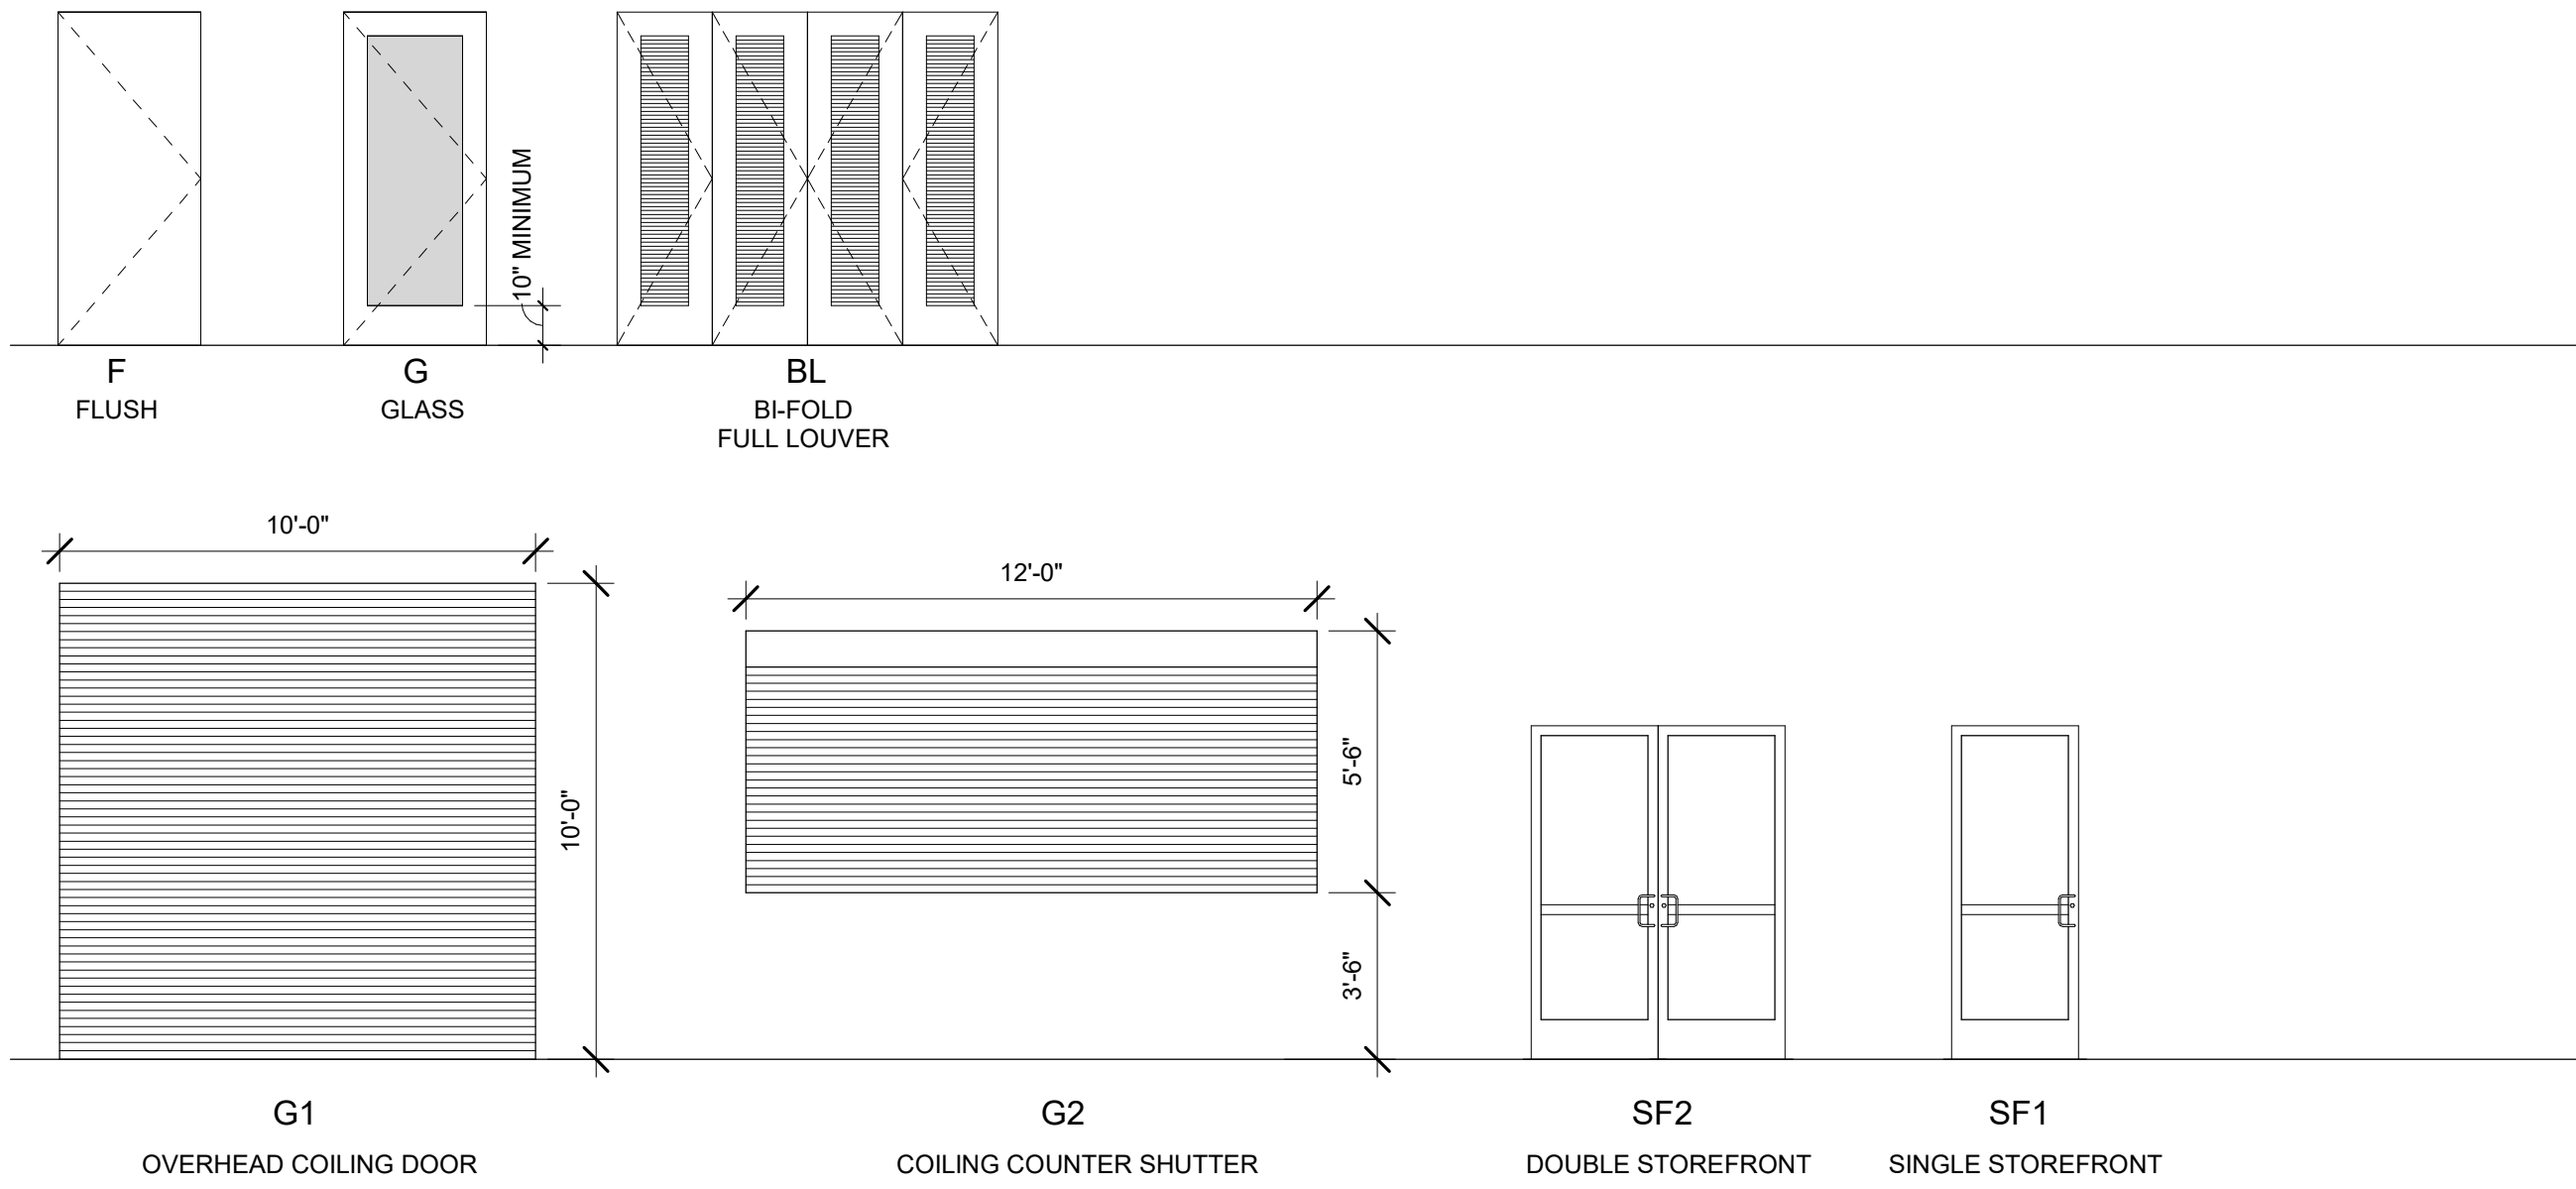

FRAME LEGEND

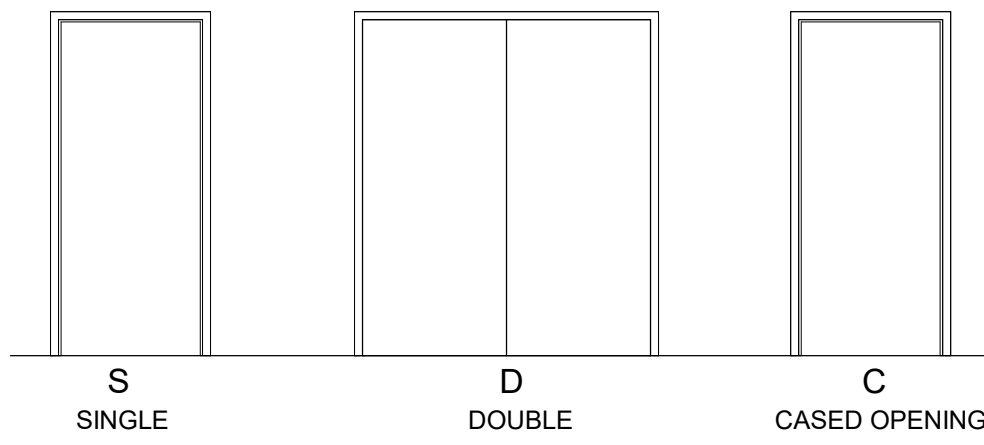


DOOR, FRAME AND HARDWARE SCHEDULE

SPACE NO. / DOOR DESIGNATION	FROM ROOM	TO ROOM	DOOR			DESCRIPTION		FRAME		DETAILS	FIRE RATING	Hardware Sets	REMARKS
			WIDTH	HEIGHT	THICK	MATL	TYPE	GLASS	MATL	TYPE			
100a	EXTERIOR	VESTIBULE	6'-0"	7'-0"	1 3/4"	ALUM.	SF2		ALUM.	D		01	CARD READER
100b	VESTIBULE	EXTERIOR	6'-0"	7'-0"	1 3/4"	ALUM.	SF2		ALUM.	D		01	CARD READER
101	VESTIBULE	RECEPTION	6'-0"	7'-0"	1 3/4"	ALUM.	SF2		ALUM.	D		06	CARD READER
102	RECEPTION	OFFICE	3'-0"	7'-0"	1 3/4"	PT	F		ALUM.	S		15	CARD READER
103	LOUNGE	EXTERIOR	6'-0"	7'-10"	1 3/4"	ALUM.	SF2		ALUM.	D		01	CARD READER
104	LOUNGE	FIRST AID	6'-0"	7'-0"	1 3/4"	PT	F		ALUM.	S		24	
105a	MULTI-PURPOSE ROOM	RECEPTION	6'-0"	7'-0"	1 3/4"	WD	F		ALUM.	D		07	
105b	MULTI-PURPOSE ROOM	CORR	3'-0"	7'-0"	1 3/4"	WD	F		ALUM.	S		18	CARD READER
105c	MULTI-PURPOSE ROOM	CORR	3'-0"	7'-0"	1 3/4"	WD	F		ALUM.	S		11	CARD READER
106	MECH.	MULTI-PURPOSE ROOM	3'-0"	7'-0"	1 3/4"	PT	F		HM	S		12	
107a	VEST.	MULTI-PURPOSE ROOM	3'-0"	7'-0"	1 3/4"	PT	F		HM	C			CASED OPENING, 4-0 x 7-0
107b	EXTERIOR	VEST.	3'-0"	7'-0"	1 3/4"	ALUM.	SF1		ALUM.	S		03	CARD READER
108	STORAGE	MULTI-PURPOSE ROOM	6'-0"	7'-0"	1 3/4"	PT	F		HM	D		09	
109a	CORR	LOUNGE	3'-0"	7'-0"	1 3/4"	WD	F		ALUM.	S		18	
109b	CORR	LOUNGE	3'-0"	7'-0"	1 3/4"	WD	F		ALUM.	S		18	CARD READER
110	CORR	MEN	3'-0"	7'-0"	1 3/4"	WD	F		HM	S		23	
111	CORR	WOMEN	3'-0"	7'-0"	1 3/4"	WD	F		HM	S		23	
112	CORR	JAN.	3'-0"	7'-0"	1 3/4"	PT	F		HM	S		14	
113	CORR	MECH.	6'-0"	7'-0"	1 3/4"	PT	F		HM	D		09	
114	CORR	STOR.	6'-0"	7'-0"	1 3/4"	PT	F		HM	D		10	
115	CORR	TEACHING KITCHEN	3'-0"	7'-0"	1 3/4"	WD	F		ALUM.	S		20	
116a	STEM LAB TECHIE-SPORTS	CORR	3'-0"	7'-0"	1 3/4"	WD	F		ALUM.	S		18	CARD READER
116b	STEM LAB TECHIE-SPORTS	CORR	3'-0"	7'-0"	1 3/4"	WD	F		ALUM.	S		18	CARD READER
117	STEM LAB TECHIE-SPORTS	LAB STOR	6'-0"	7'-0"	1 3/8"	PT	BL		HM	D		25	
118	COORD OFFICE	STEM LAB TECHIE-SPORTS	3'-0"	7'-0"	1 3/4"	WD	F		ALUM.	S		15	
119	STEM LAB TECHIE-SPORTS	ENGINEERING BOOTH	3'-0"	7'-0"	1 3/4"	WD	F		ALUM.	S		15	
120	ENGINEERING BOOTH	SOUND BOOTH	3'-0"	7'-0"	2 1/2"	HM	F		HM	S		15	BASIS OF DESIGN: IAC NOISE LOCK STC 53 - FINISH: WOOD VENEER
121a	CORR	ARTS & CRAFTS	3'-0"	7'-0"	1 3/4"	WD	F		ALUM.	S		20	
121b	ARTS & CRAFTS	ARTS & CRAFTS	3'-0"	7'-0"	1 3/4"	PT	F		HM	S		12	
122	STUDY ROOM	CORR	3'-0"	7'-0"	1 3/4"	WD	F		ALUM.	S		20	
123	CORRIDOR	GYMNASIUM	6'-0"	7'-0"	1 3/4"	ALUM.	SF2		ALUM.	D		08	CARD READER
124	LOUNGE	CONCESSION	3'-0"	7'-0"	1 3/4"	PT	F		HM	S		17	CARD READER
125	STORAGE	CONCESSION	3'-0"	7'-0"	1 3/4"	PT	F		HM	S		14	
126	CORRIDOR	LAUNDRY	3'-6"	7'-0"	1 3/4"	PT	F		HM	S		19	
127	CORRIDOR	LT	3'-6"	7'-0"	1 3/4"	PT	F		HM	S		17	CARD READER
128	ELEC.	CORRIDOR	3'-6"	7'-0"	1 3/4"	PT	F		HM	S		13	
129a	CORRIDOR	CORRIDOR	3'-0"	7'-0"	1 3/4"	WD	F		ALUM.	S		22	
129b	EXTERIOR	CORRIDOR	3'-0"	7'-0"	1 3/4"	ALUM.	SF1		ALUM.	S		03	CARD READER
130	ADULT READING	CORRIDOR	3'-0"	7'-0"	1 3/4"	WD	F		ALUM.	S		20	
131	STORAGE	GYMNASIUM	6'-0"	7'-0"	1 3/4"	WD	F		HM	D		09	
132	FITNESS	CORRIDOR	3'-0"	7'-0"	1 3/4"	WD	F		ALUM.	S		16	
133a	CORRIDOR	WOMEN	3'-0"	7'-0"	1 3/4"	WD	F		HM	S		23	
133b	GYMNASIUM	WOMEN	3'-0"	7'-0"	1 3/4"	WD	F		HM	S		21	
134a	CORRIDOR	MEN	3'-0"	7'-0"	1 3/4"	WD	F		HM	S		23	
134b	GYMNASIUM	MEN	3'-0"	7'-0"	1 3/4"	WD	F		HM	S		21	
135a	EXTERIOR	GYMNASIUM	6'-0"	7'-0"	1 3/4"	HM	F		HM	D		04	CARD READER
135b	GYMNASIUM	EXTERIOR	6'-0"	7'-0"	1 3/4"	HM	F		HM	D		04	CARD READER
135c	EXTERIOR	GYMNASIUM	6'-0"	7'-0"	1 3/4"	ALUM.	SF2		ALUM.	D		02	CARD READER
136a	GYMNASIUM	GARAGE	6'-0"	7'-0"	1 3/4"	HM	F		HM	D		05	
150	GARAGE	EXTERIOR	10'-0"	10'-0"		ALUM.	G1		STEEL			26	OVERHEAD COILING DOOR, MOUNTED INTERIOR FACE OF WALL
151	GYMNASIUM	EXTERIOR	10'-0"	10'-0"		ALUM.	G1		STEEL			26	OVERHEAD COILING DOOR, MOUNTED INTERIOR FACE OF WALL
152	CONCESSION	CORRIDOR	12'-0"	5'-6"	3"	ALUM.	G2		STEEL			26	COILING COUNTER SHUTTER, MOUNTED INSIDE JAMB




CORRIDOR

CONCESSION

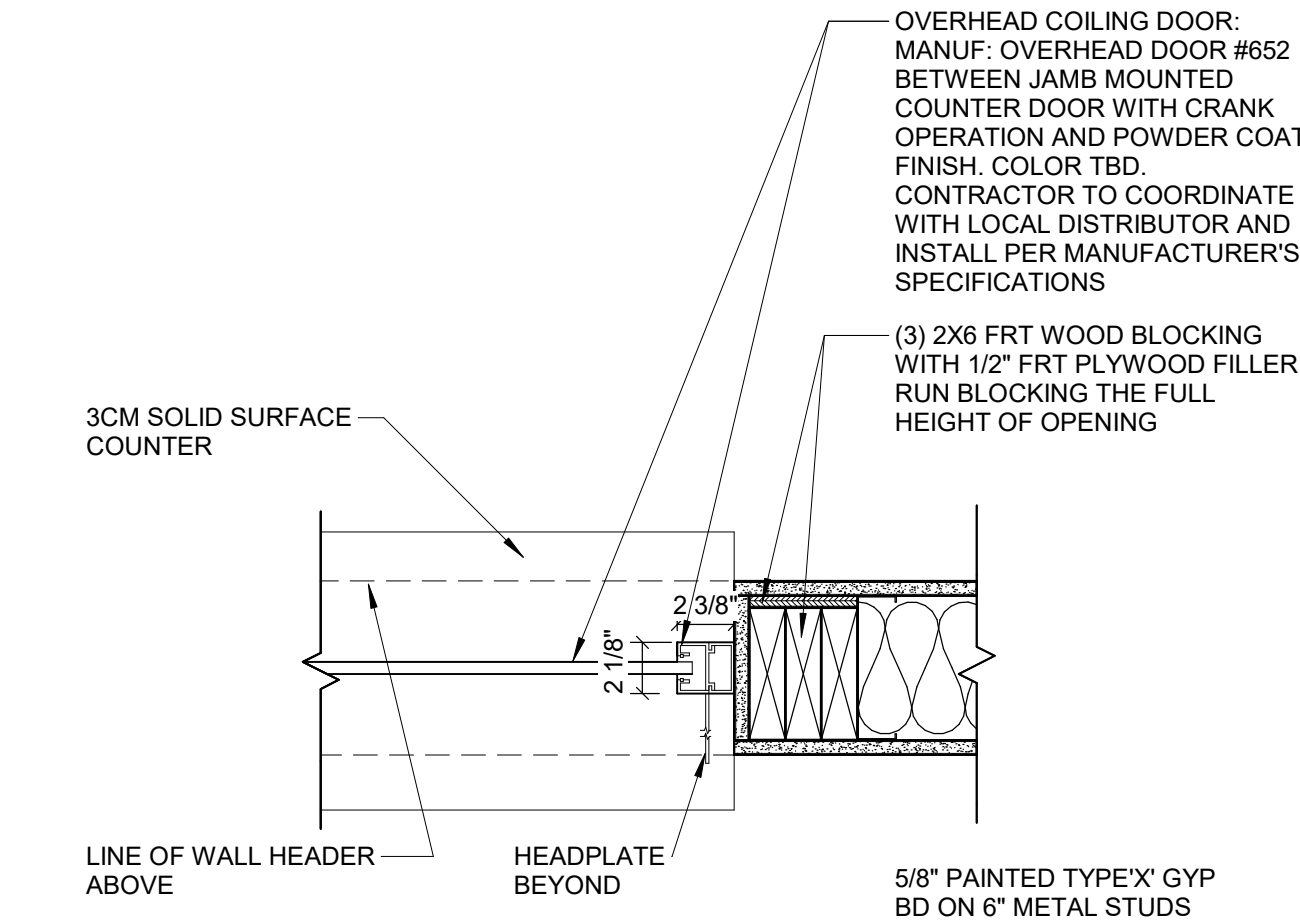

DETAIL JAMB - INTERIOR COILING DOOR AT CONCESSION
② 1 1/2" = 1'-0"

DETAIL SECTION - INTERIOR COILING DOOR AT CONCESSION
① 1 1/2" = 1'-0"

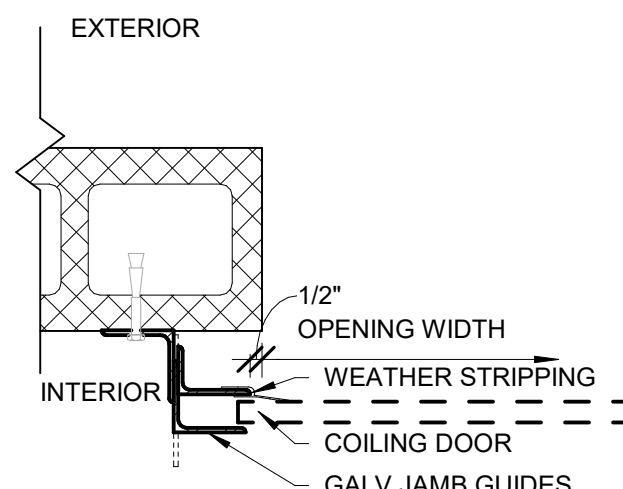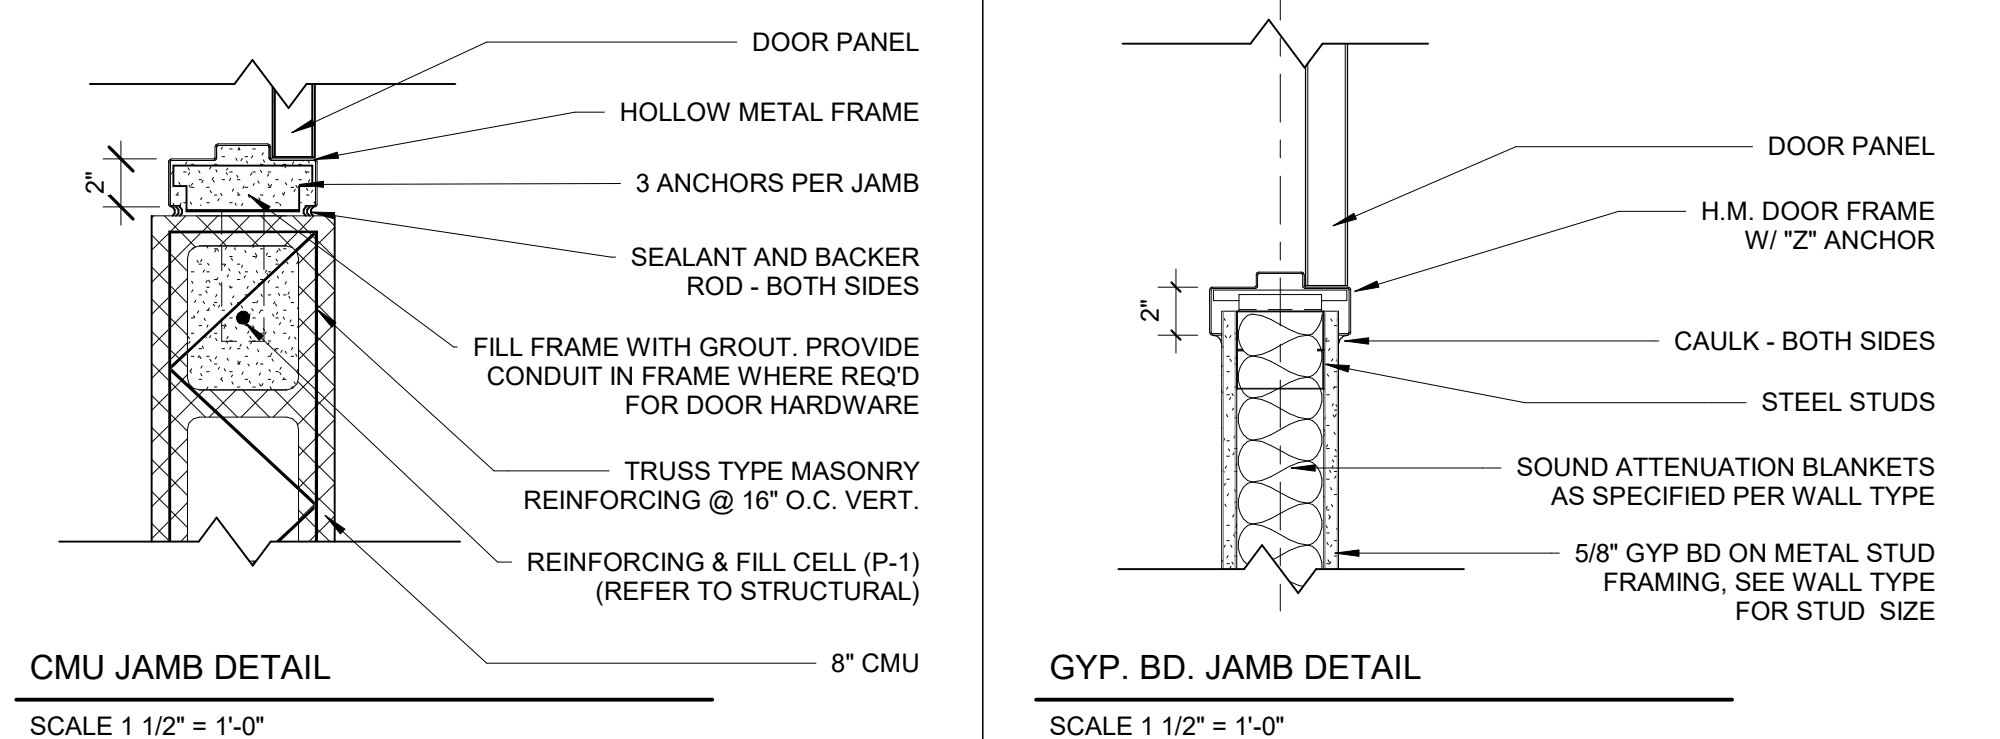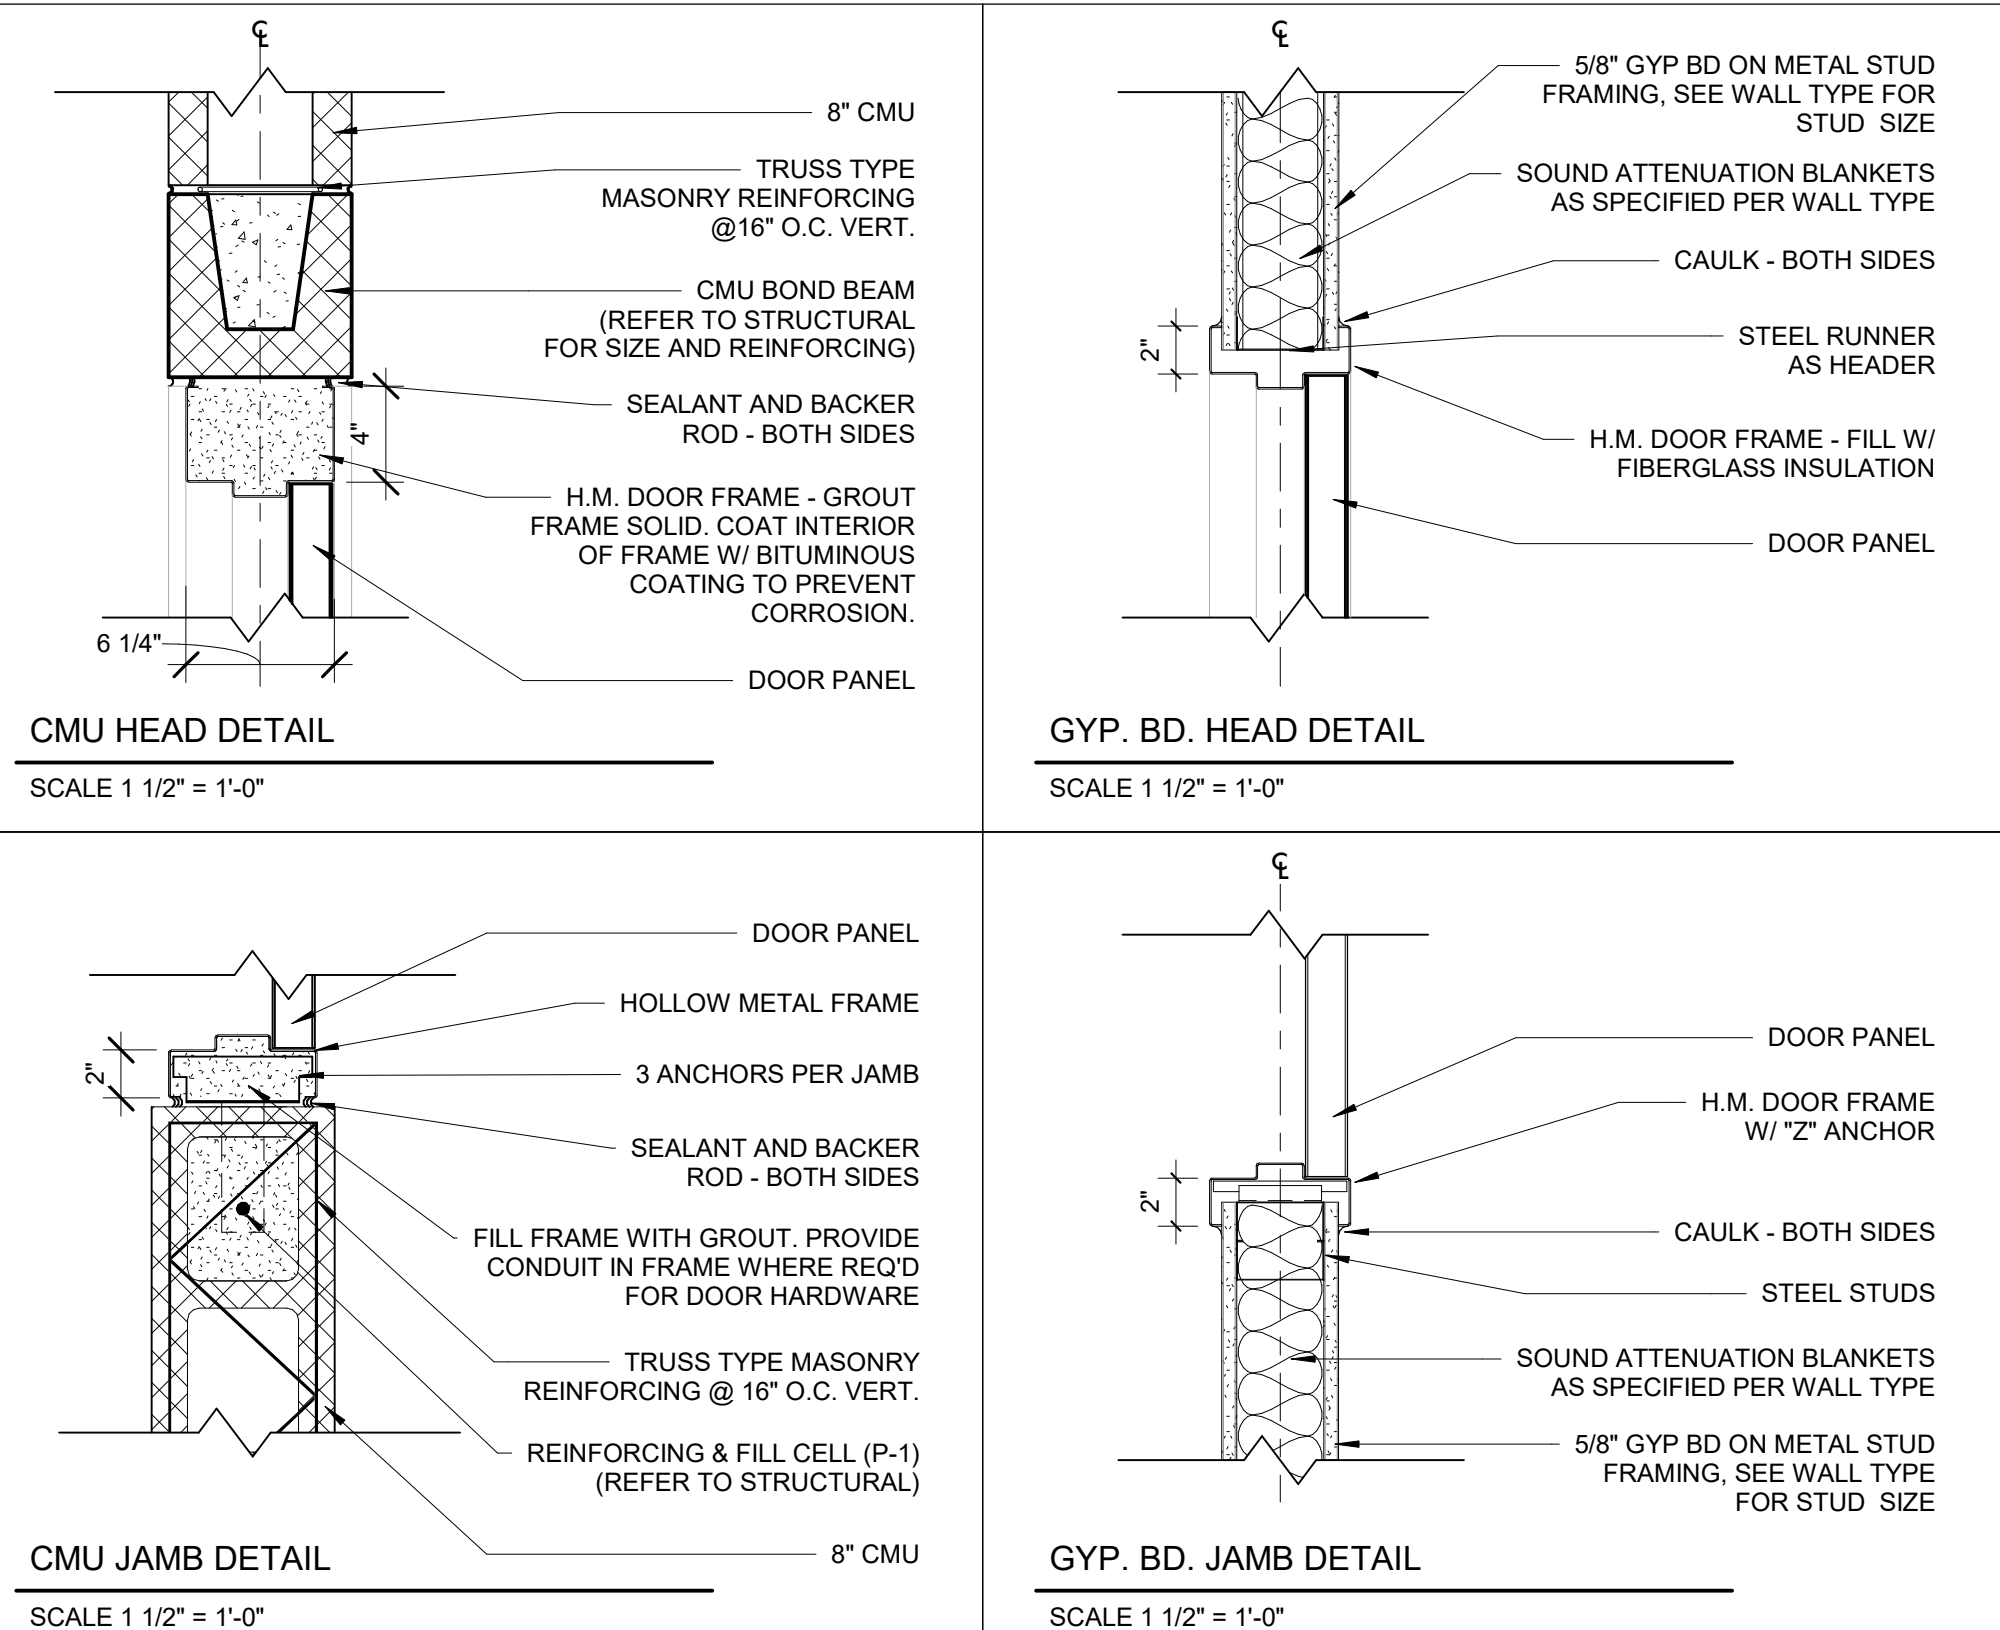

OH COILING DOOR JAMB DETAIL
SCALE 1 1/2" = 1'-0"

STATE OF FLORIDA
TAMMY
DANIELS
COHEN
ARD015450
REGISTERED ARCHITECT

CCR ARCHITECTURE & INTERIORS

MARTIN LUTHER KING JR. RECREATION CENTER
705 14TH COURT EAST
PANAMA CITY, FL 32401

JOB NUMBER:
21109

DATE:
05/18/2023

PRINTED / REVISIONS
DESCRIPTION DATE


SHEET TITLE:
DOOR SCHEDULE

SHEET NUMBER:
A901

05/18/2023 10:58 AM C:\Users\chad\OneDrive\Documents\Projects\A901\A901.dwg - New Building - Scheme 2 of 4
THIS DRAWING IS THE PROPERTY OF CCR ARCHITECTURE & INTERIORS AND IS NOT TO BE REPRODUCED, COPIED OR ALTERED IN WHOLE OR IN PART OR USED FOR ANY PURPOSE WITHOUT THE APPROVAL OF CCR ARCHITECTURE & INTERIORS AND IS TO BE RETURNED UPON REQUEST.

2920 FIRST AVENUE SOUTH BIRMINGHAM, ALABAMA 35233 CCRARCHITECTURE.COM 205-324-8864

05/2023 16101230 PANAMA CITY 161012300 Panama City, FL 32401 - New Building - Scheme 2 of 4
THIS DRAWING IS THE PROPERTY OF CCR ARCHITECTURE & INTERIORS AND IS NOT TO BE REPRODUCED, COPIED OR ALTERED IN WHOLE OR IN PART OR USED FOR ANY PURPOSE WITHOUT THE APPROVAL OF CCR ARCHITECTURE & INTERIORS AND IS TO BE RETURNED UPON REQUEST.

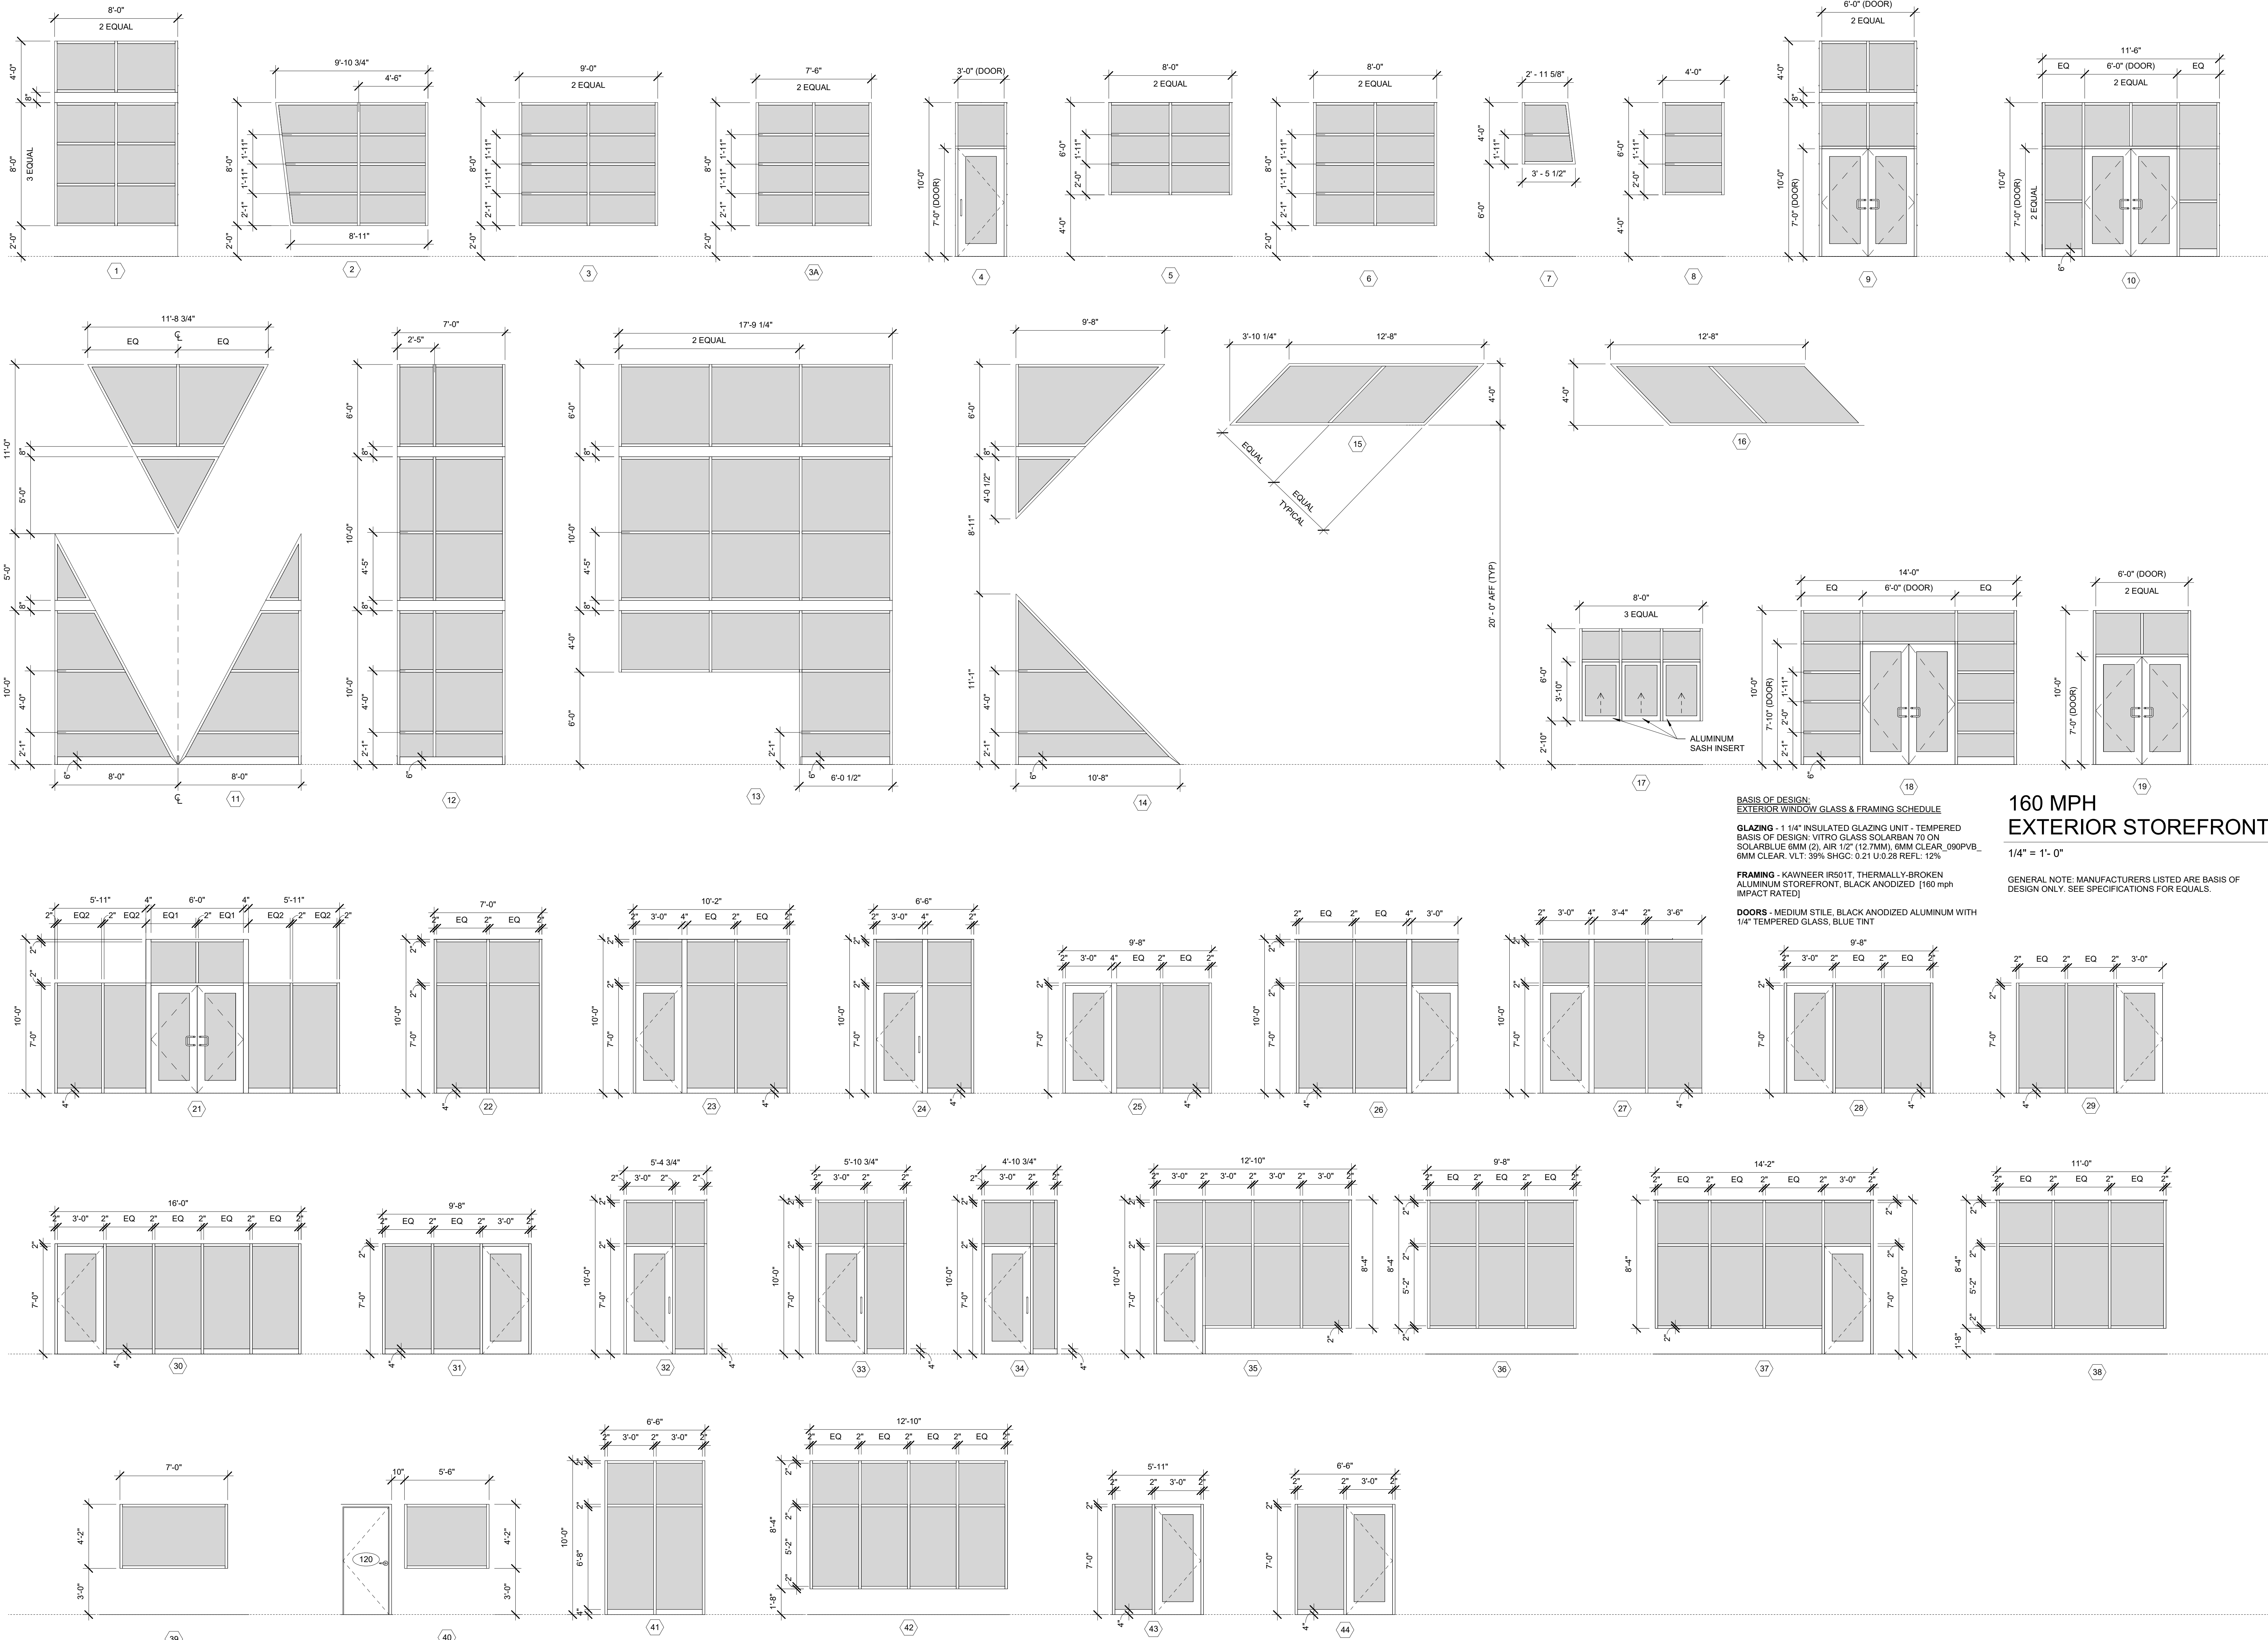

SOUND BOOTH GLAZING
BASIS OF DESIGN: IAC NOISE-LOCK "C" CLASS
ACOUSTIC WINDOWS OR EQUAL, DOUBLE
GLAZED WITH 1/4" LAMINATED SAFETY GLASS,
STC 53

SOUND BOOTH GLAZING
BASIS OF DESIGN: IAC NOISE-LOCK "C" CLASS
ACOUSTIC WINDOWS OR EQUAL, DOUBLE
GLAZED WITH 1/4" LAMINATED SAFETY GLASS,
STC 53

TYPICAL INTERIOR WINDOW GLASS & FRAMING SCHEDULE:
GLAZING - 1/4" CLEAR TEMPERED GLAZING UNIT
FRAMING - ALUMINUM STOREFRONT, BLACK ANODIZED

INTERIOR STOREFRONT
1/4" = 1'-0"

BASIS OF DESIGN:
EXTERIOR WINDOW GLASS & FRAMING SCHEDULE

GLAZING - 1 1/4" INSULATED GLAZING UNIT - TEMPERED
BASIS OF DESIGN: VITRO GLASS SOLARBAN 70 ON
SOLARBLUE 6MM (2) AIR 1/2" (12.7MM), 6MM CLEAR, 090PVB,
6MM CLEAR, VLT: 39% SHGC: 0.21 U-0.28 REFL: 12%


FRAMING - KAWNEER IR501T, THERMALLY-BROKEN
ALUMINUM STOREFRONT, BLACK ANODIZED (160 mph
IMPACT RATED)

DOORS - MEDIUM STILE, BLACK ANODIZED ALUMINUM WITH
1/4" TEMPERED GLASS, BLUE TINT

**160 MPH
EXTERIOR STOREFRONT**

1/4" = 1'-0"

GENERAL NOTE: MANUFACTURERS LISTED ARE BASIS OF
DESIGN ONLY. SEE SPECIFICATIONS FOR EQUALS.

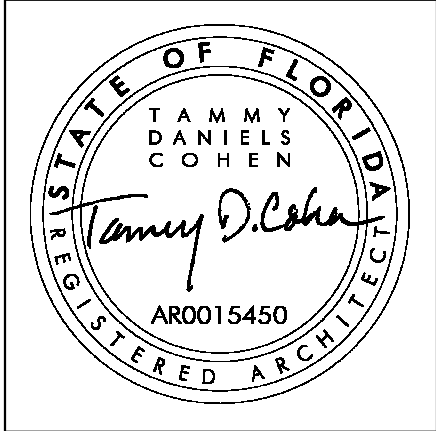

CCR ARCHITECTURE & INTERIORS

MARTIN LUTHER KING JR. RECREATION CENTER
705 14TH COURT EAST
PANAMA CITY, FL 32401

JOB NUMBER:
21109

DATE:
05/18/2023


PRINTED / REVISIONS
DESCRIPTION DATE

SHEET TITLE:
STOREFRONT
SCHEDULE

SHEET NUMBER:

A902

05/2023, 40128 Bldg, PANAMA CITY 36613100 Panama City, AL - New Building - Scheme 2 of 4
THIS DRAWING IS THE PROPERTY OF CCR ARCHITECTURE & INTERIORS AND IS NOT TO BE REPRODUCED, COPIED OR ALTERED IN WHOLE OR IN PART OR USED FOR ANY PURPOSE WITHOUT THE APPROVAL OF CCR ARCHITECTURE & INTERIORS AND IS TO BE RETURNED UPON REQUEST.





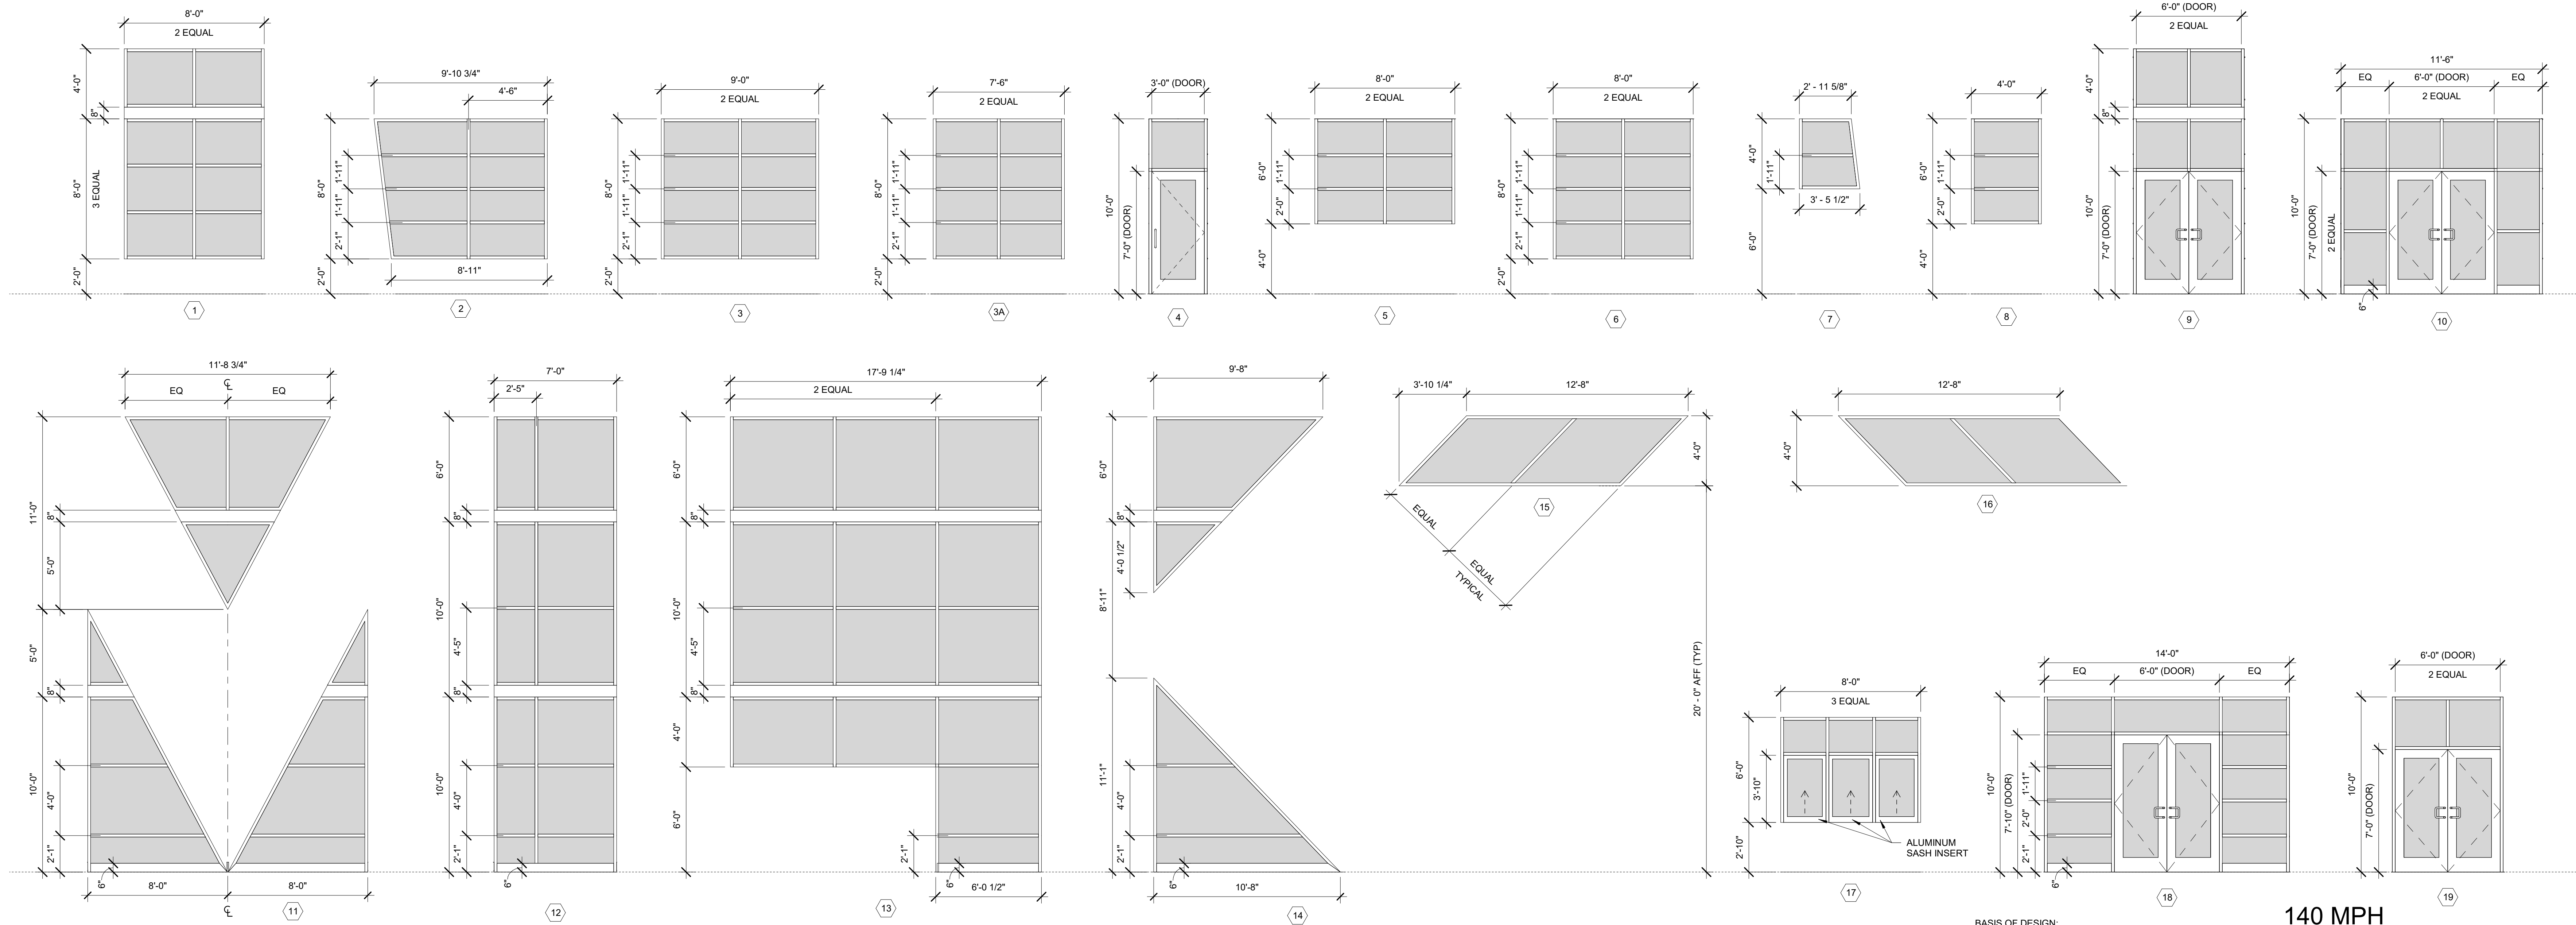


140 MPH EXTERIOR STOREFRONT

1/4" = 1'-0"

GENERAL NOTE: MANUFACTURERS LISTED ARE BASIS OF DESIGN ONLY. SEE SPECIFICATIONS FOR EQUALS.

BASIS OF DESIGN:
EXTERIOR WINDOW GLASS & FRAMING SCHEDULE:
GLAZING - 1" INSULATED GLAZING UNIT - TEMPERED
BASIS OF DESIGN: VITRO GLASS SOLARBAN 70 ON SOLARBLUE 6MM (2), AIR 1/2" (12.7MM), 6MM CLEAR.
VLT: 41% SHGC: 0.22 U: 0.28 REFL: 13%
FRAMING - CORAL ARCHITECTURAL PRODUCTS FL300T, THERMALLY-BROKEN ALUMINUM STOREFRONT, BLACK ANODIZED (140 mph NON-IMPACT RATED)
DOORS - MEDIUM STYLE, BLACK ANODIZED ALUMINUM WITH 1/4" TEMPERED GLASS, BLUE TINT

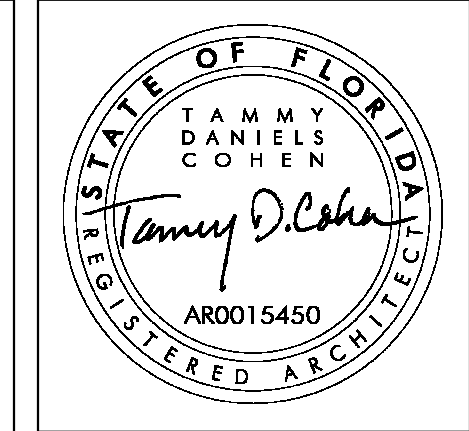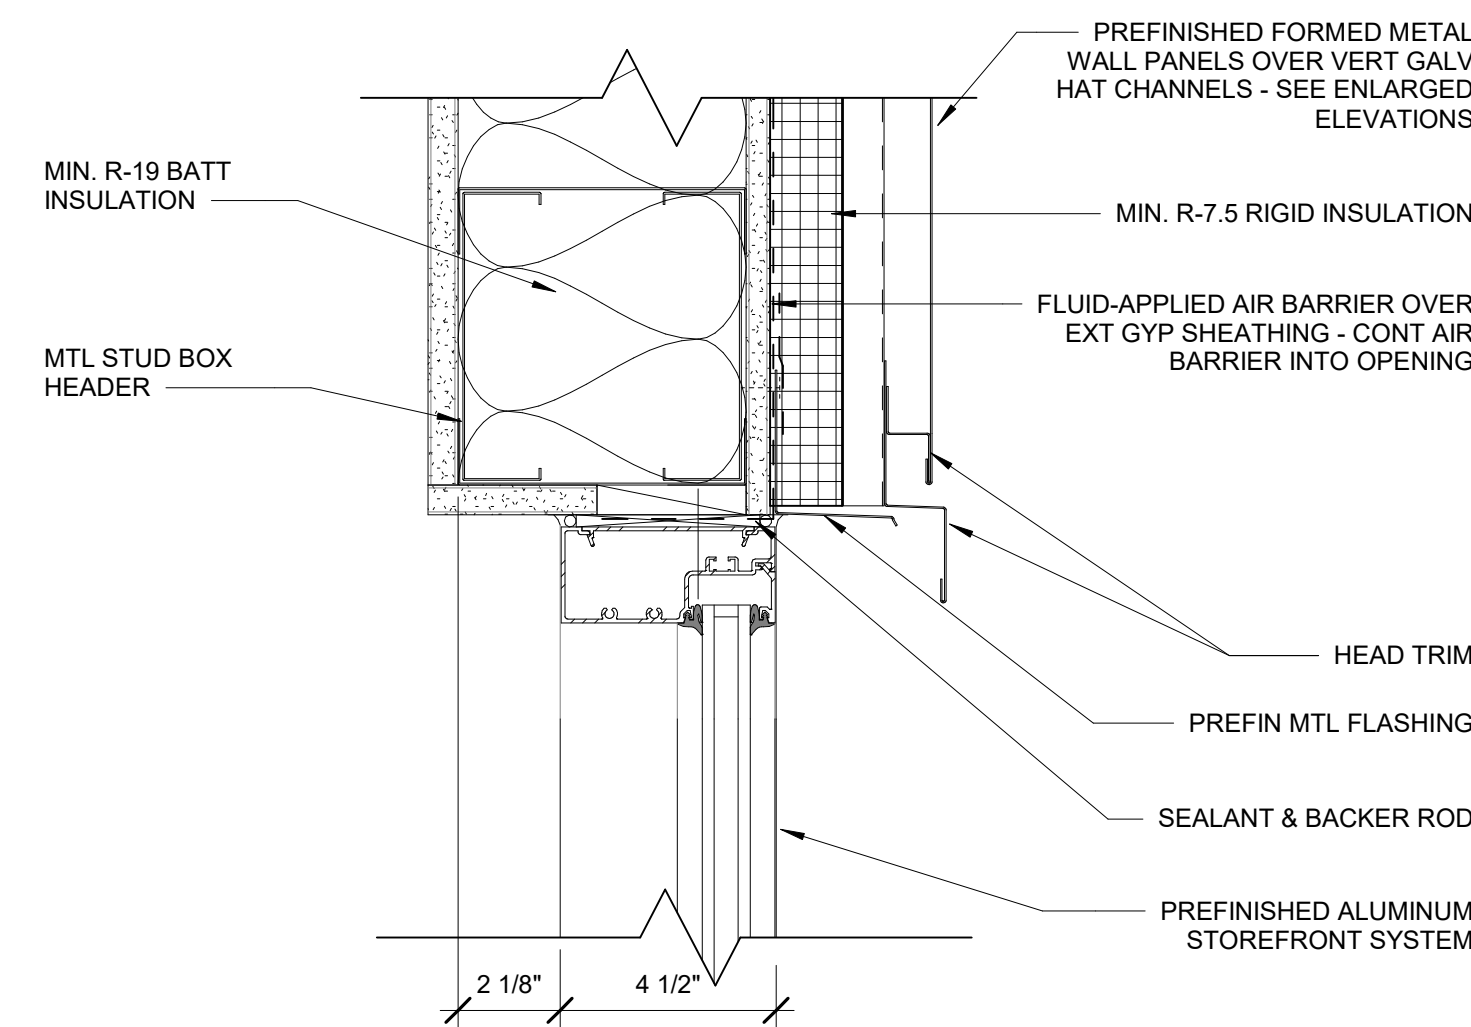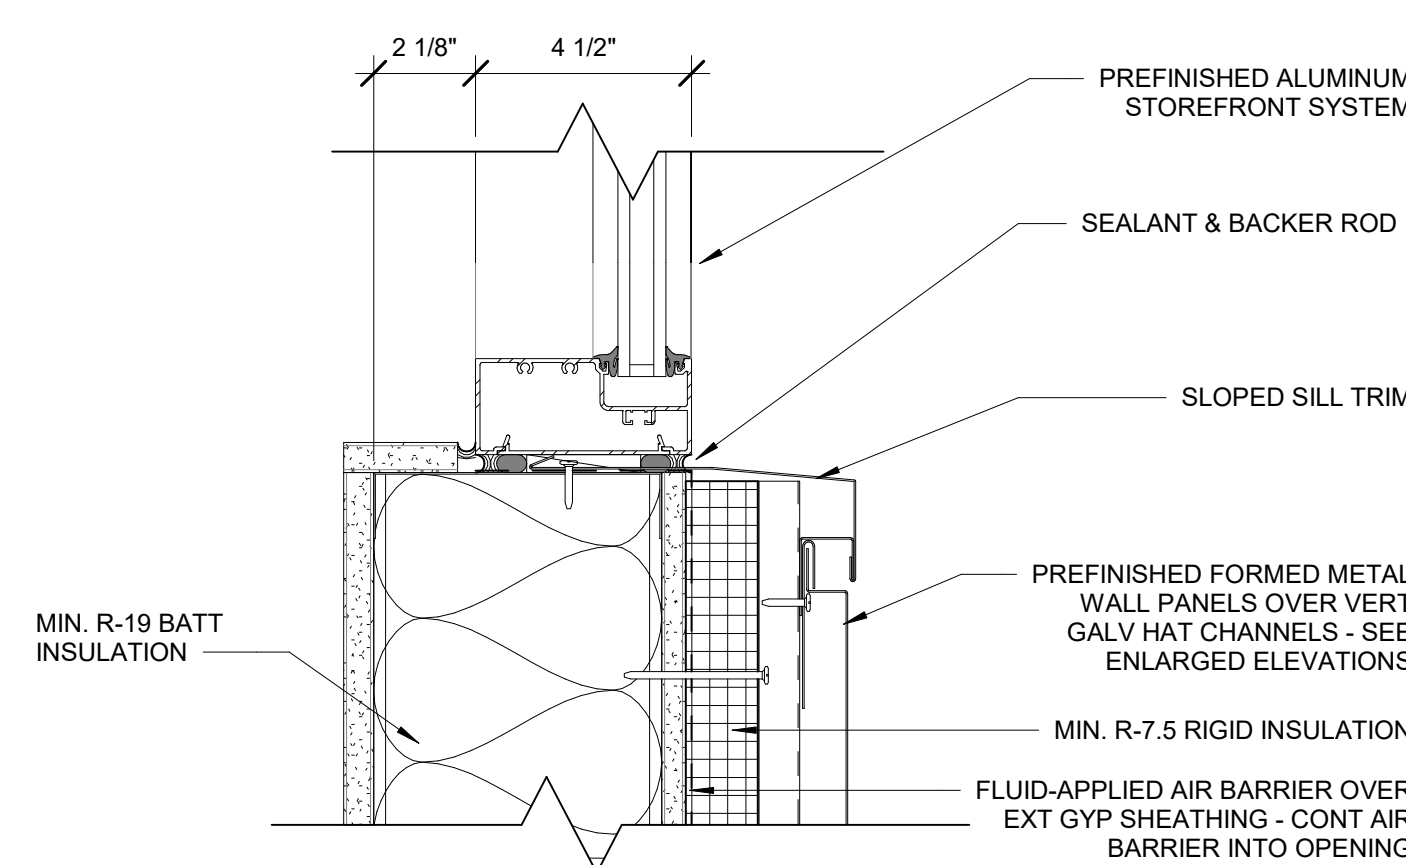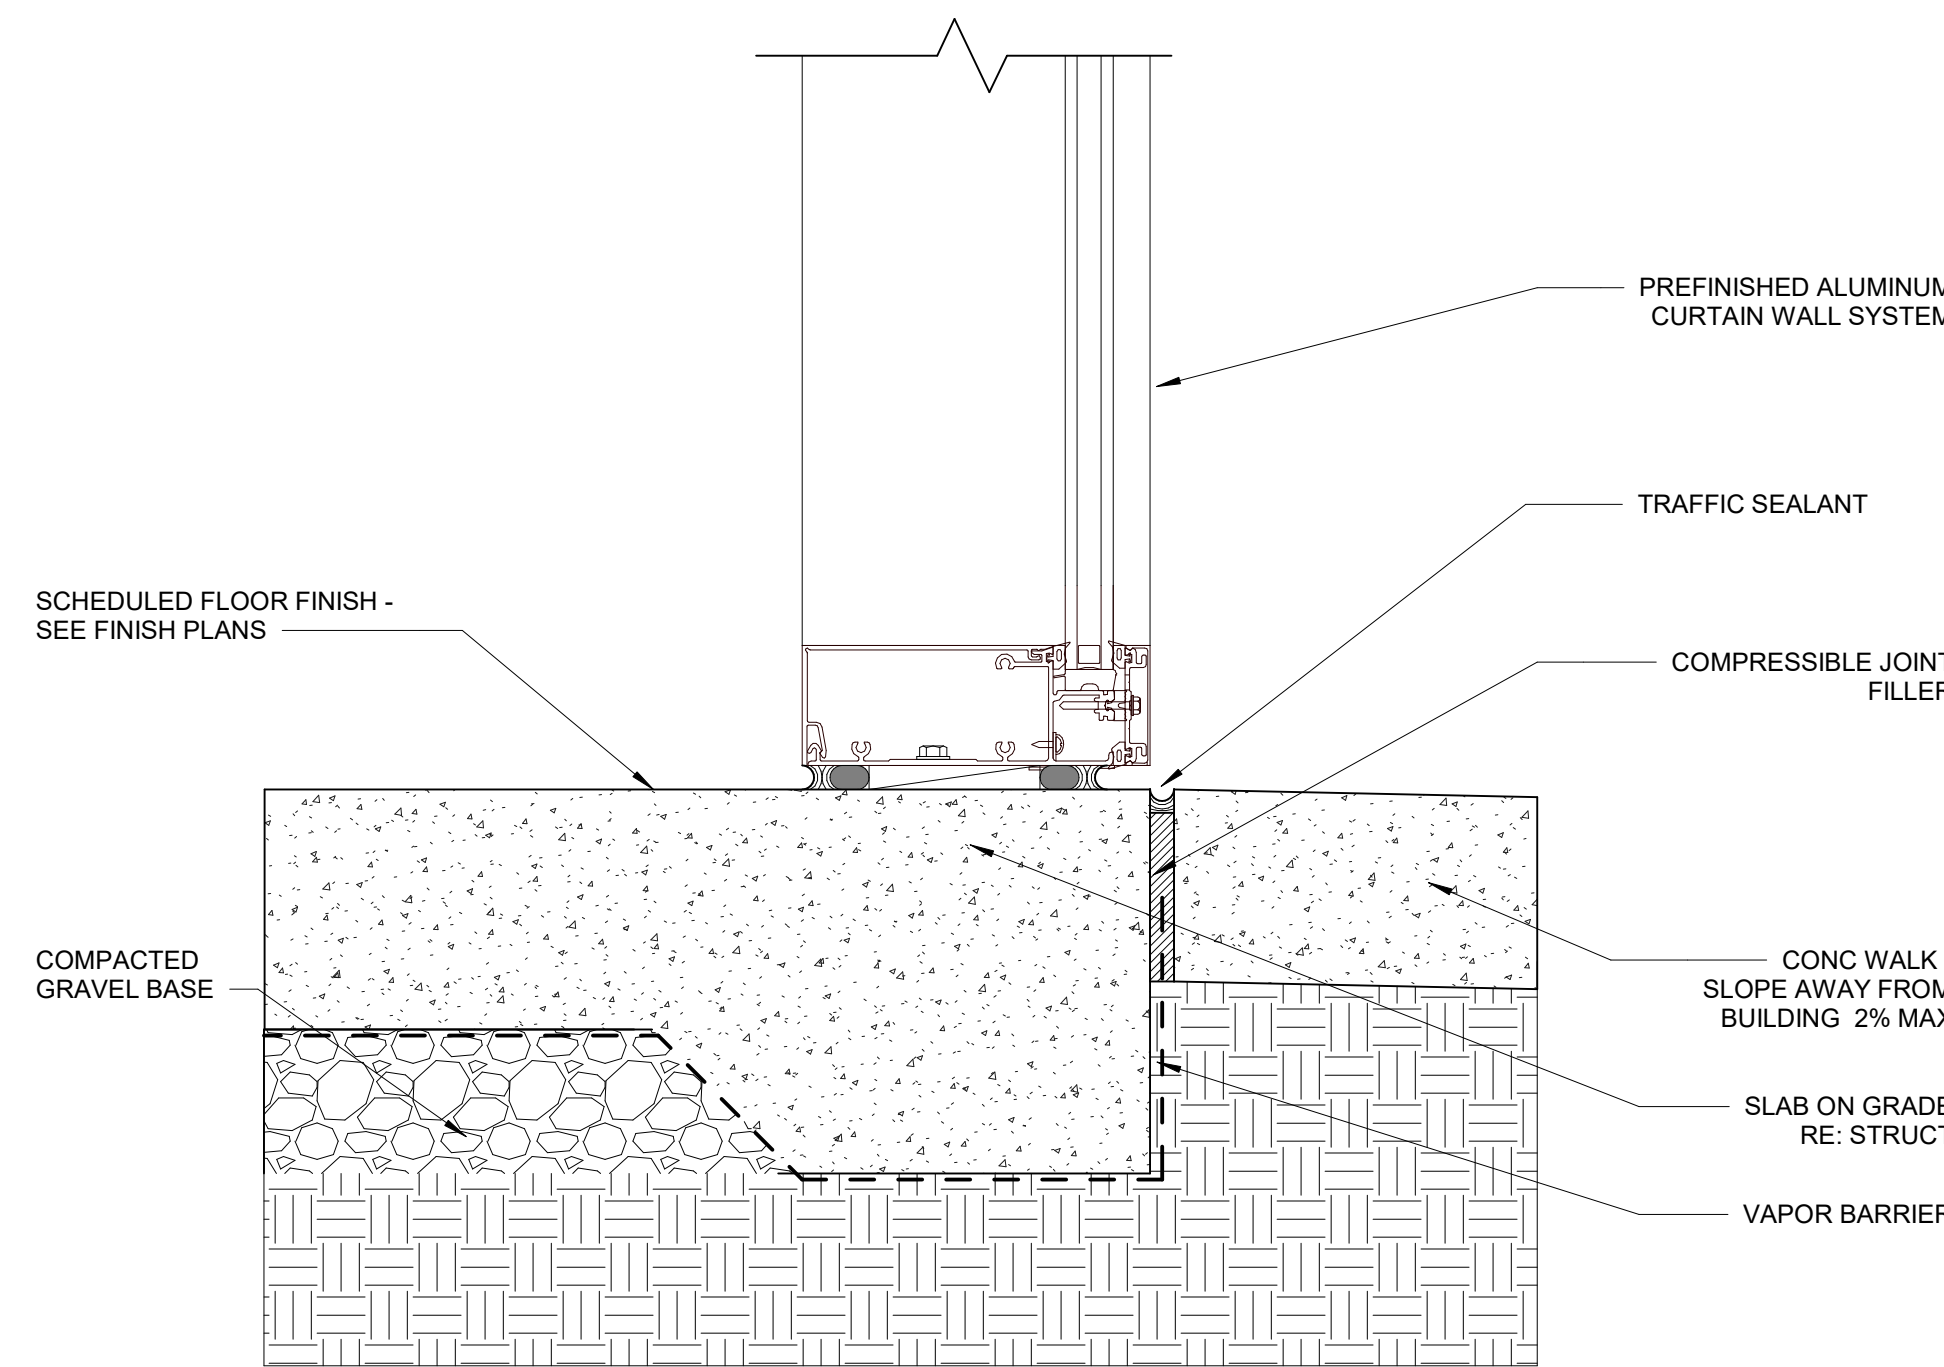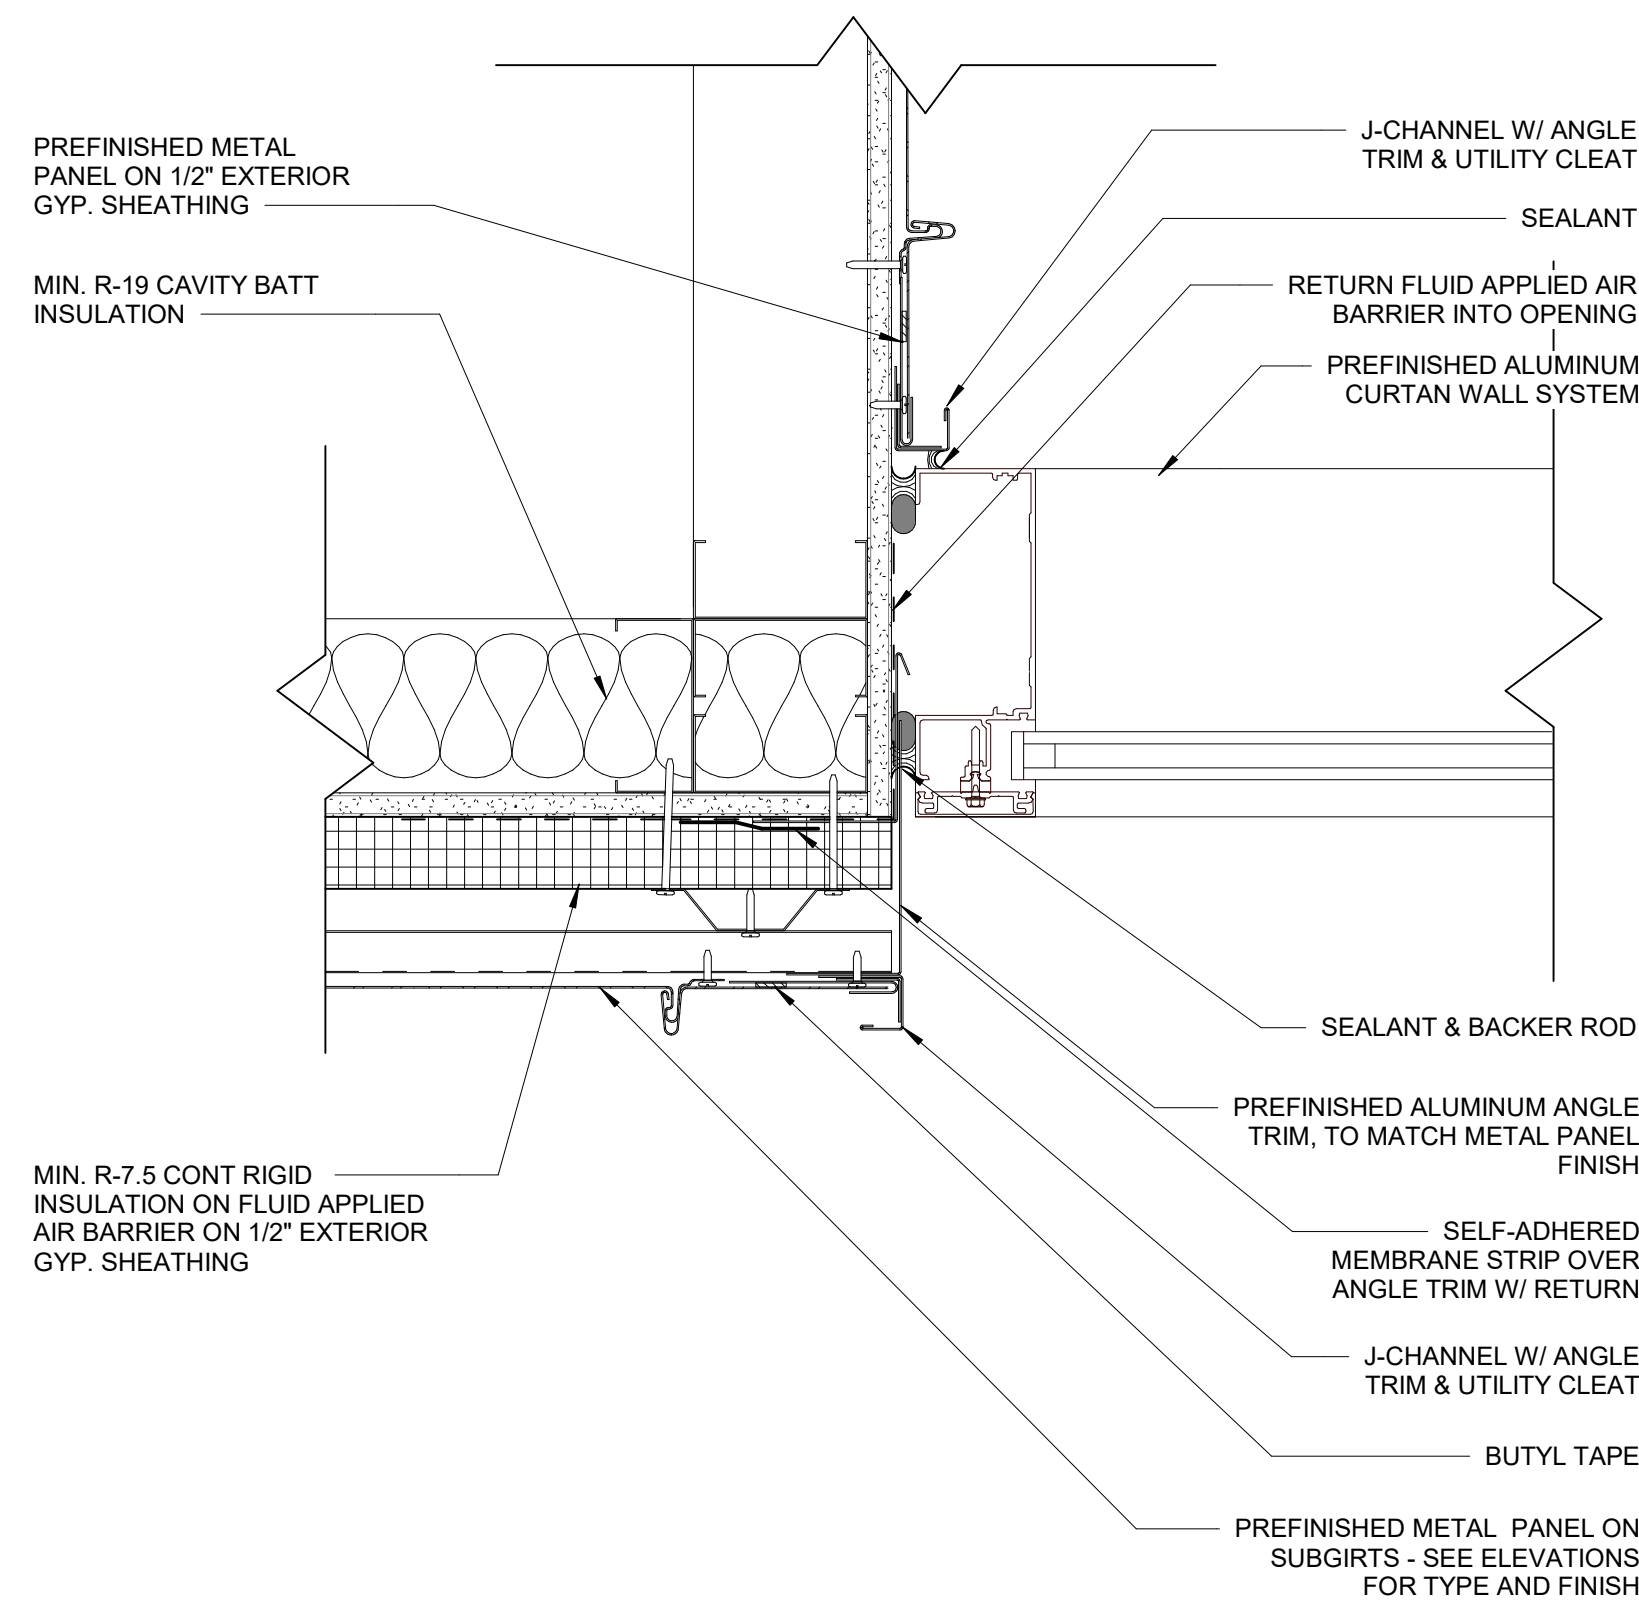

CCR ARCHITECTURE & INTERIORS

MARTIN LUTHER KING JR. RECREATION CENTER

705 14TH COURT EAST
PANAMA CITY, FL 32401

JOB NUMBER:
21109

DATE:
05/18/2023

PRINTED / REVISIONS
DESCRIPTION DATE

SHEET TITLE:
STOREFRONT
SCHEDULE Alternate

SHEET NUMBER:

A902-ALT