

Kitchen Equipment & Supply Co.

Mobile, AL
816 Anniston Ave. S.W., 13
Birmingham, AL 35208
205-417-4200

Panama City, FL
2718 Government Blvd.,
Panama City, FL 32407
904-939-1522

Pensacola, FL
1000 W. Main Street,
Pensacola, FL 32507
904-459-1505

Meridianville, GA
95 Main Street, E., 22509
Meridianville, GA 30138
770-427-7424

OWNER: _____

SEAL: _____

MLK
CONCESSION

PANAMA CITY, FL.

REVISIONS:

ISSUED FOR: _____
ISSUED_FOR: _____
DATE: 06.23.22

SHEET TITLE: _____
SHEET_TITLE: _____

© 2022
THESE DOCUMENTS ARE THE PROPERTY
OF KITCHEN EQUIPMENT & SUPPLY CO., INC.
THEY MAY NOT BE ALTERED OR REPRODUCED
WITHOUT WRITTEN CONSENT.


DATE: 06.23.22
SCALE: 1/4"=1'-0"
DRAWN BY: WHO
CHECKED BY: _____
JOB NO.: _____





 
 

SHEET NO.:
FS1



EQUIPMENT SCHEDULE

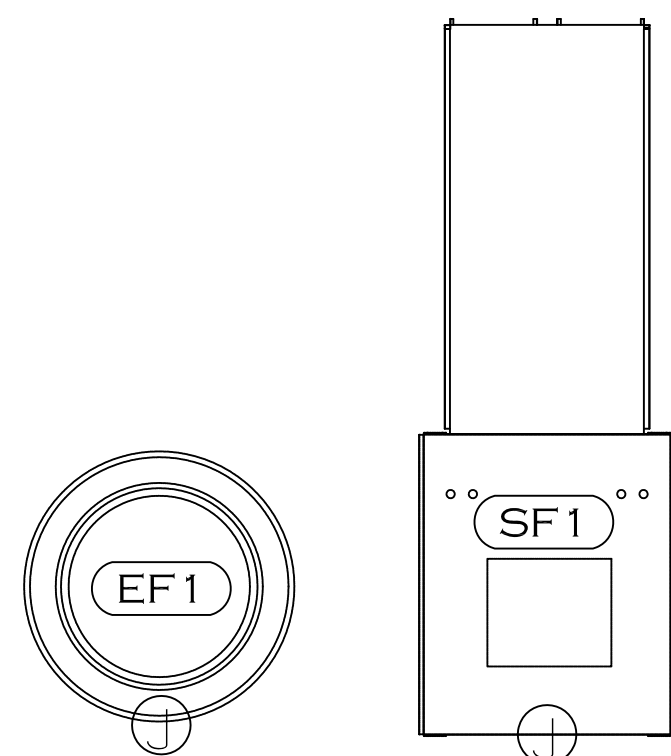ITEM NO	QTY	EQUIPMENT CATEGORY
1	1	RANGE, RESTAURANT, GAS
2	2	FRYER, GAS
3	1	GRIDDLE, GAS
5	1	STAND, EQUIPMENT
6	1	FREEZER, REACH-IN
7	2	REFRIGERATOR, REACH-IN
8	1	REFRIGERATOR, SANDWICH UNIT
9	1	FREEZER, UNDERCOUNTER
10	1	SINK, 3 COMP. W/ DBOARD
11	1	PRE-RINSE FAUCET, WALL MOUNT
13	4	TABLE, WORK S/S
14	1	TABLE, WORK S/S
16	1	DISPLAY CASE, HEATED
17	2	WARMER, FOOD, ELECTRIC
18	2	OVERSHELF, TABLE MOUNT
22	1	HAND SINK, WALL MOUNT
22.1	1	HAND SINK, WALL MOUNT
23	2	CABINET, WARMING & HOLDING
24	1	WARMER, BUN
25	1	HOT DOG GRILL
26	1	NACHO CHIP WARMER
28	1	POPCORN MACHINE
29	1	SODA DISPENSER (BY OTHERS)
30	1	BAG IN BOX RACK (FOR ITEM #29)
POS	2	POINT OF SALE (BY OTHERS)
HS	1	HOOD SYSTEM PACKAGE
EF 1	1	EXHAUST FAN (HOOD SYSTEM)
SF 1	1	SUPPLY AIR FAN (HOOD SYSTEM)

HOOD FANS SHOWN ARE
FOR REFERENCE ONLY.
LOCATION TBD BY
ARCHITECT/ENGINEER.



ELECTRICAL LEGEND			
SYMBOLS		ABBREVIATIONS	
	JUNCTION BOX (J-BOX)	A	AMPERES
	DATA LINE CONNECTION	V	VOLTS
	DUPLEX ELECTRICAL OUTLET (DCO)	W	WATTS
	SINGLE ELECTRICAL OUTLET (SCO)	PH	PHASE
	EQUIPMENT INTERCONNECTION BY E.C.	AF	ABOVE FINISHED FLOOR
	FLUORESCENT LIGHT FIXTURE	DN	DOWN FROM ABOVE
	SWITCH AS NOTED	BTC BRANCH TO CONNECTION POINT AND CONNECT EQUIP.	
		HP	HORSE POWER
		KW	KILOWATTS
		DC	DIRECT CONNECTION
		K.E.C	KITCHEN EQUIPMENT CONTRACTOR
		E.C.	ELECTRICAL CONTRACTOR
		C.O.	CONVENIENCE OUTLET 120 VOLT 1 PH 20.0A

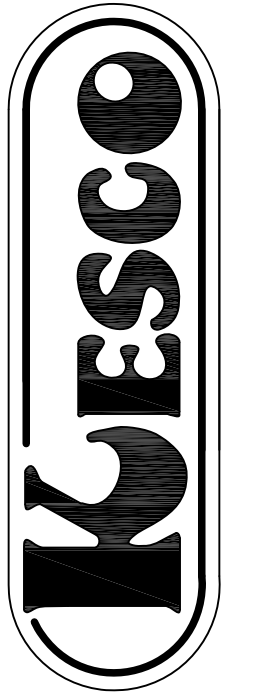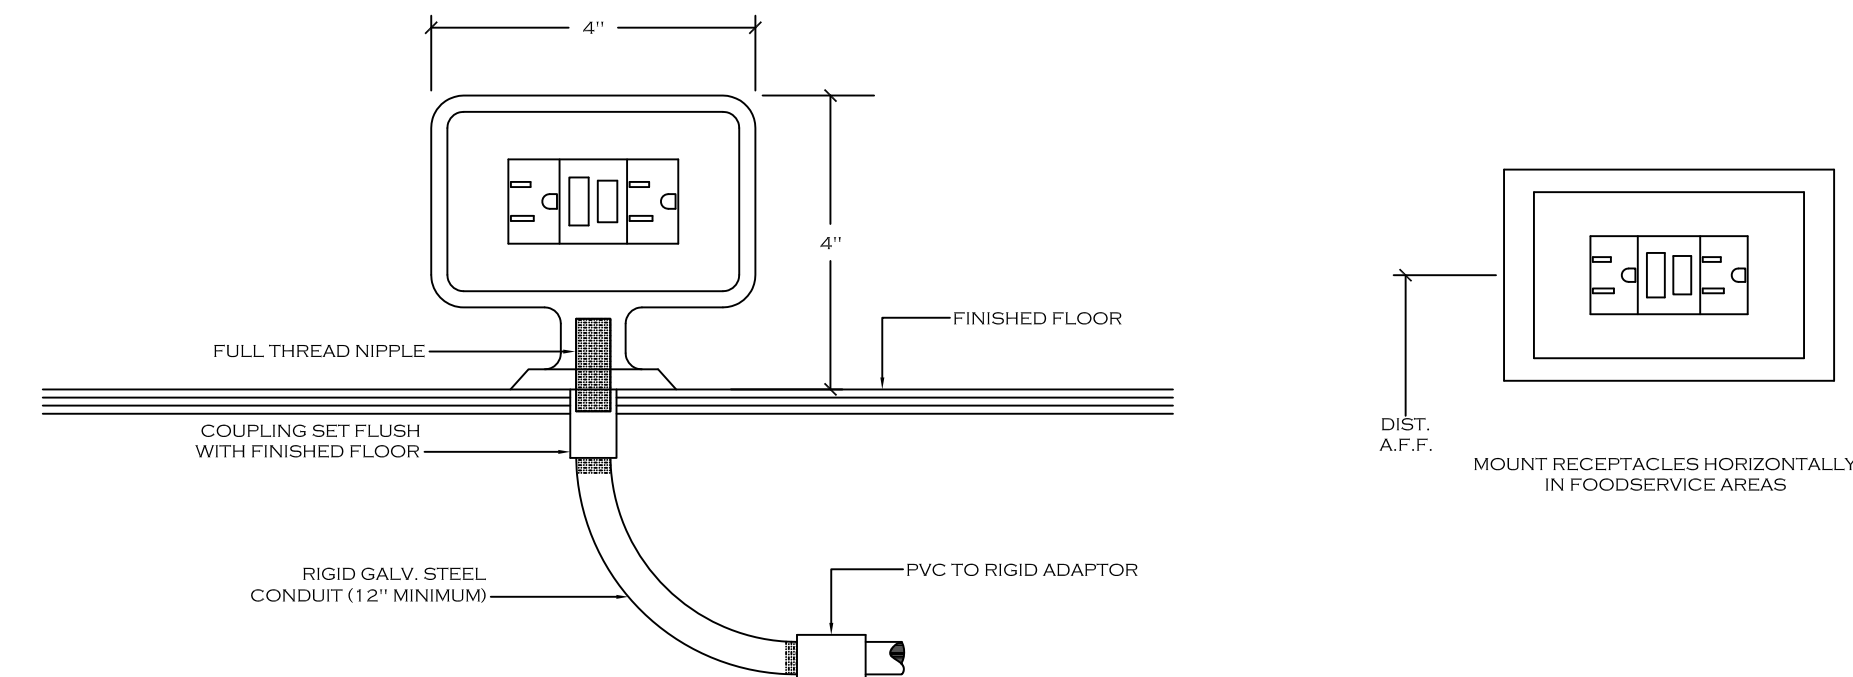

Kitchen Equipment & Supply Co.

Mary Esther Mary Esther Blvd. Esther, FL 32569 850-243-7900	Pensacola 1600 W Main Street Pensacola, FL 32507 850-396-1633	Panama City Beach 7930 Front Beach Rd Panama City Beach, FL 32407 850-234-1922	Mobile, Ala. 2718 Government Blvd. Mobile, Alabama 36606 251-430-2221	Bradenton 816 Manatee Ave. S Bradenton, FL 34206 941-417-0200
---	---	--	---	---

[illegible]

4' VERIFY
3'-4"

17 26 13 25 13 14
24 17

FS4

1

-ELEVATION @ CONCESSION SIDE EXPO-

SCALE: NTS

FS4

