

AUDITORIUM RENOVATION FOR

SPRINGVILLE MIDDLE SCHOOL

6601 US-11 SPRINGVILLE, ALABAMA 35146

ST. CLAIR COUNTY BOARD OF EDUCATION



ST. CLAIR COUNTY BOARD OF EDUCATION

MR. SCOTT SUTTLE	BOARD PRESIDENT
MS. ALLISON GRAY	BOARD VICE PRESIDENT
MRS. NICKIE STEVENS VAN PELT	BOARD MEMBER
MRS. CATHY FINE	BOARD MEMBER
MR. BOGIE LOVELL	BOARD MEMBER
MR. BILL MORRIS	BOARD MEMBER
MR. RANDY THOMPSON	BOARD MEMBER
MR. RUSTY ST. JOHN	INTERIM SUPERINTENDENT

OWNER

ST. CLAIR COUNTY BOARD OF EDUCATION
410 ROY DRIVE
ASHVILLE, ALABAMA 35953

ARCHITECT

LATHAN ASSOCIATES ARCHITECTS, P.C.
dba LATHAN McKEE ARCHITECTS
300 CHASE PARK SOUTH
SUITE 200
HOOVER, ALABAMA 35244
EMAIL: LATHANRFI@LATHANMCKEE.COM

ELECTRICAL
ENGINEER

STEWART ENGINEERING, INC.
P.O. BOX 2233
ANNISTON, ALABAMA 36202

DRAWING INDEX (SET - 6 TOTAL SHEETS)

(1 SHEETS)

T1 - TITLE AND INDEX

ARCHITECTURAL DRAWINGS


(2 SHEETS)

- A1 - AUDITORIUM DEMOLITION PLAN & PARTIAL FLOOR PLAN
- A2 - REFLECTED CEILING AND FLOOR FINISH PLAN AND LEGENDS

ELECTRICAL DRAWINGS


(3 SHEETS)

- E1.1 - SCHEDULES, SYMBOLS AND NOTES
- E2.1 - FLOOR PLAN - LIGHTING AND POWER
- E3.1 - FLOOR PLAN - AUXILIARIES

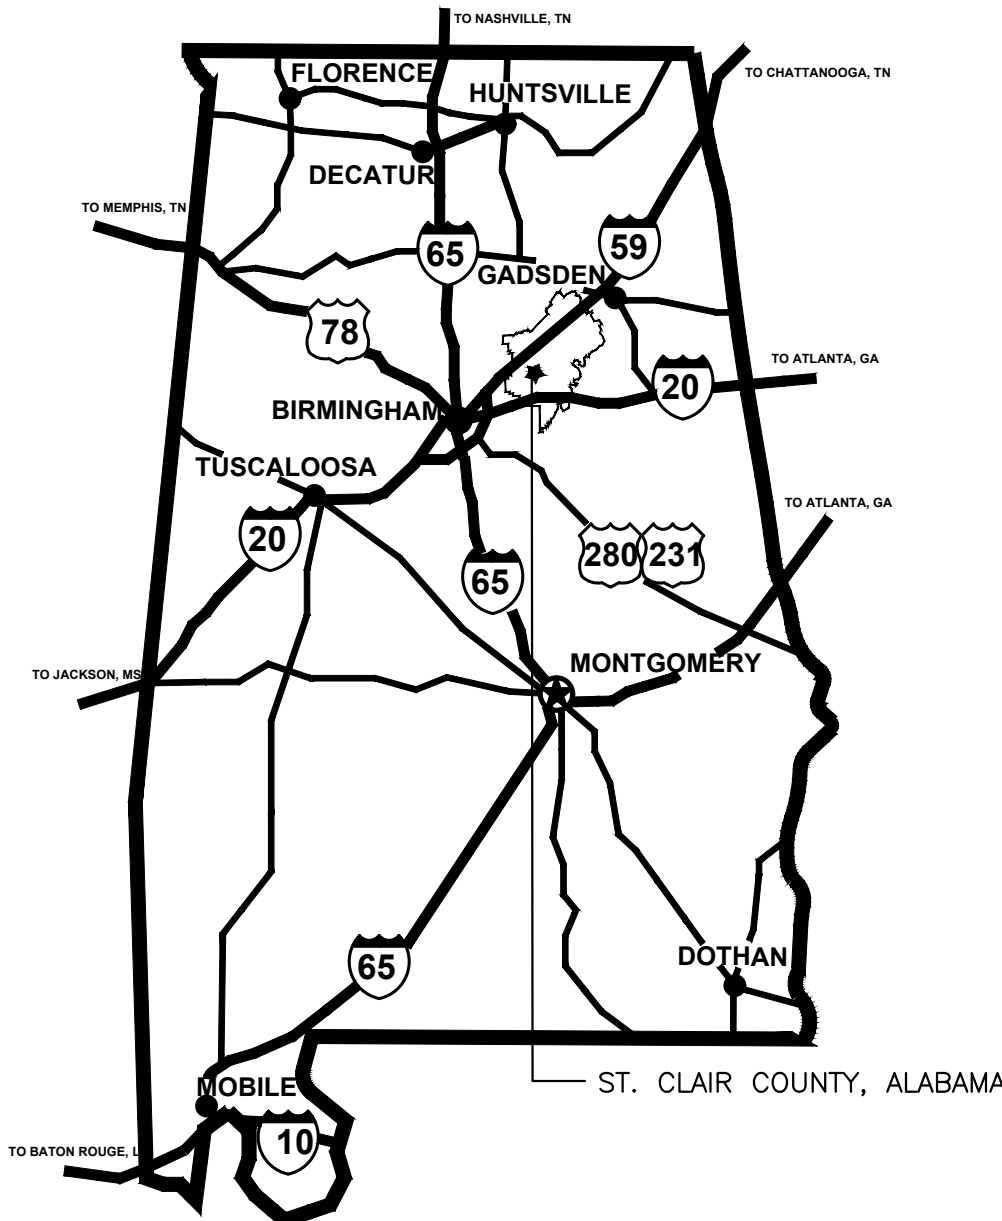

AREA MAP

STATE OF ALABAMA

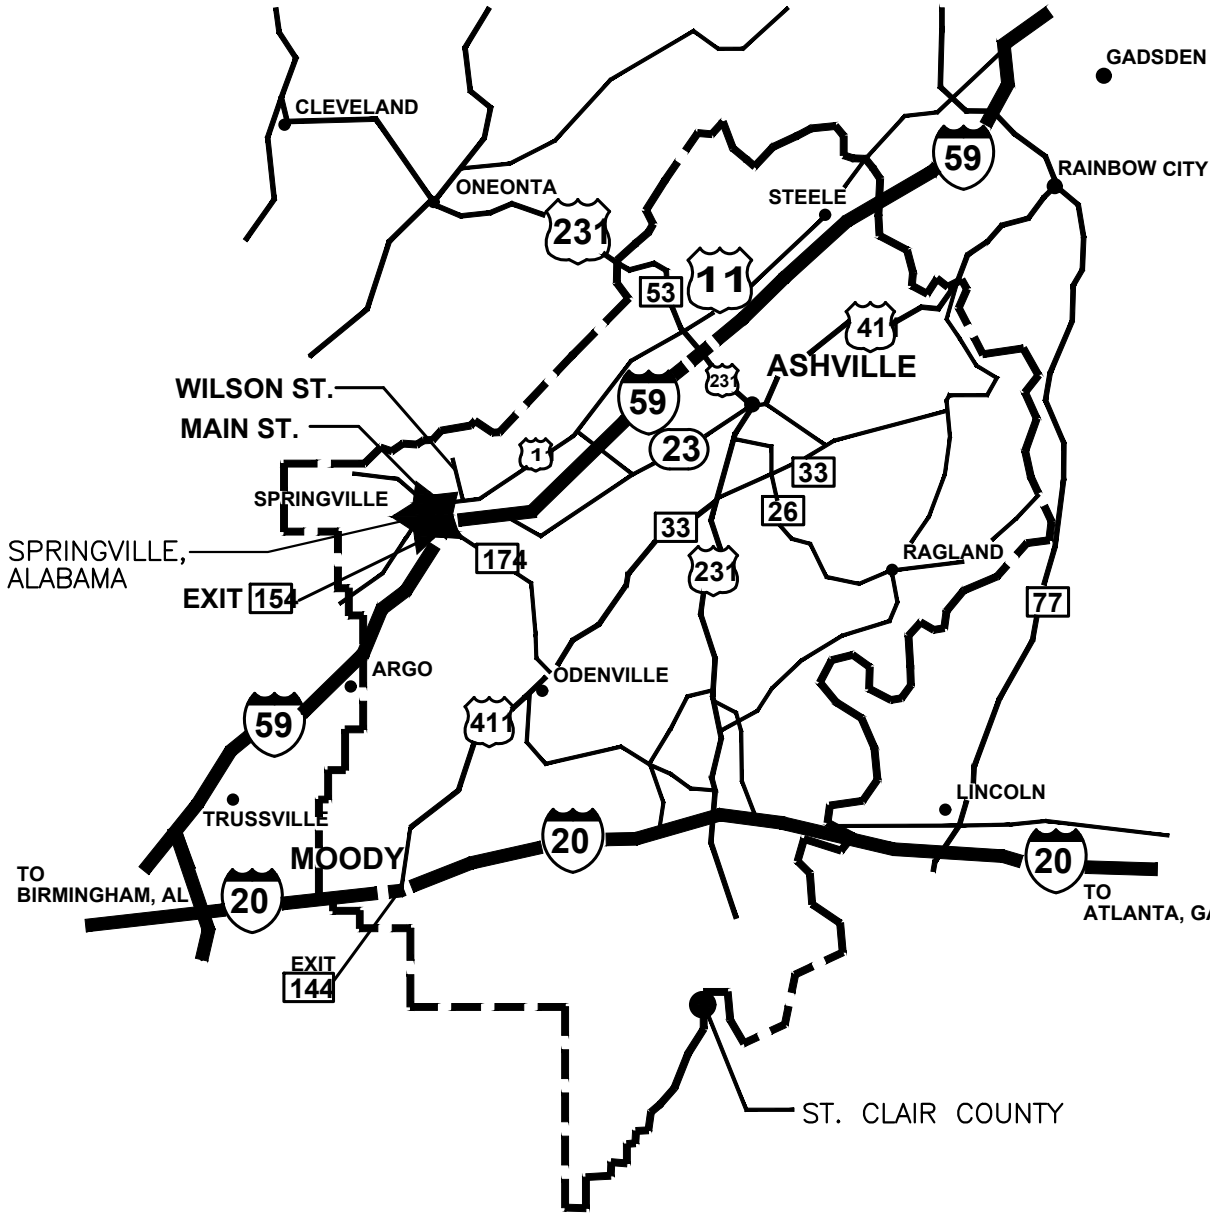

VICINITY MAP

ST. CLAIR COUNTY, ALABAMA

AUDITORIUM RENOVATION FOR


SPRINGVILLE MIDDLE SCHOOL

6601 US-11 SPRINGVILLE, ALABAMA 35146

ST. CLAIR COUNTY BOARD OF EDUCATION

SHEET TITLE:

TITLE AND INDEX

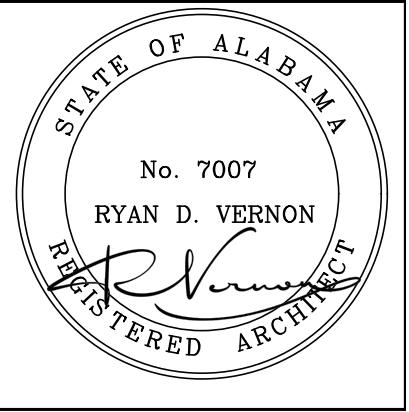

PROJ. MGR.: R.VERNON

DRAWN:B.LOGAN

DATE: JULY 28, 2026

REVISIONS

 
JOB NO.

LAA-26-019-00

SHEET NO:

T1

1 OF 1




TYPICAL SYMBOLS LEGEND	
NEW DOOR AND SWING	DOOR TYPE DOOR RATING HARDWARE SYMBOL
ROOM NUMBER	INTERIOR ELEVATION

GENERAL NOTES	
ALL PLAN DIMENSIONS ARE TO FACE OF CMU WALL OR FACE OF STUD WALL UNLESS NOTED OTHERWISE	

DEMOLITION KEY NOTES	
	REMOVE ALL EXISTING AUDITORIUM SEATING, INCLUDING BUT NOT LIMITED TO SEATS, SEAT SUPPORTS, ANCHORS, FASTENERS, ASLE END PANELS, ARMRESTS, AND ANY ASSOCIATED MOUNTING HARDWARE. REMOVE ALL ASSOCIATED CONSTRUCTION RELATED TO THE SEATING SYSTEM, INCLUDING PLATFORM MOUNTING BRACKETS, RAILINGS, AND TRIM AS REQUIRED.
	REMOVE EXISTING WOOD ACCORDION FOLDING PARTITION, INCLUDING ALL PANELS, TRACKS, HANGERS, GUIDES, HEADERS, FRAMES, TRIM, AND ASSOCIATED HARDWARE. REMOVE ANY ASSOCIATED CONSTRUCTION REQUIRED FOR THE PARTITION SYSTEM.
	REMOVE ALL EXISTING VCT FLOORING, WALL BASE, AND AREA RUGS, INCLUDING ADHESIVES, TRANSITION STRIPS, AND ASSOCIATED ACCESSORIES. REMOVE FLOORING MATERIALS AND GRIND, SCRAPE, OR OTHERWISE REMOVE EXISTING ADHESIVES TO PROVIDE A CLEAN, SMOOTH SUBSTRATE.
	REMOVE EXISTING SUSPENDED A/V BOOTH, INCLUDING PLATFORM, EQUIPMENT, FRAMING, GUARDRAILS, AND ALL ASSOCIATED ELECTRICAL/LOW-VOLTAGE COMPONENTS AND MOUNTING HARDWARE. BOOTH IS SUSPENDED FROM ROOF STRUCTURE ABOVE. PERFORM DEMOLITION IN A CONTROLLED AND SELECTIVE MANNER. EXISTING ROOF STRUCTURE SHALL REMAIN. DO NOT CUT, MODIFY, OR REMOVE STRUCTURAL MEMBERS WITHOUT REVIEW AND APPROVAL BY THE STRUCTURAL ENGINEER. COORDINATE WITH ELECTRICAL AND A/V SYSTEMS.
	REMOVE EXISTING CHALKBOARD TACKBOARDS, INCLUDING TRIM, ACCESSORIES, AND ALL MOUNTING HARDWARE. PATCH AND REPAIR WALL SURFACE AS REQUIRED TO RECEIVE NEW FINISHES.
	REMOVE ALL EXISTING STAGE LIGHTING AND ASSOCIATED CONSTRUCTION, INCLUDING LIGHTING FIXTURES, TRACKS, HOUSINGS, RIGGING, SUPPORTS, MOUNTING HARDWARE, CONDUITS, AND CONTROL COMPONENTS. COORDINATE REMOVAL WITH ELECTRICAL AND STRUCTURAL SYSTEMS. PROTECT ANY ADJACENT CONSTRUCTION OR EQUIPMENT TO REMAIN.
	REMOVE EXISTING CEILING GRID SYSTEM AND ASSOCIATED CONSTRUCTION. PROVIDE NEW CEILING SYSTEM AS REQUIRED IN THE AREA SHOWN.

GENERAL DEMOLITION NOTES	
1. SCOPE OF WORK: DEMOLISH AND REMOVE EXISTING CONSTRUCTION AND MATERIALS AS INDICATED ON THE DRAWINGS, IN SPECIFICATIONS, AND AS REQUIRED TO ACCOMMODATE NEW WORK. THIS INCLUDES AUDITORIUM SEATING, WOOD ACCORDION FOLDING PARTITIONS, LAY-IN ACOUSTICAL CEILINGS, VCT FLOORING AND WALL BASE, AREA RUGS, A/V BOOTH, CHALKBOARDS, AND ASSOCIATED HARDWARE AND CONSTRUCTION.	
2. SELECTIVE DEMOLITION: PERFORM SELECTIVE DEMOLITION. REMOVE ONLY THE CONSTRUCTION NECESSARY FOR NEW WORK OR AS OTHERWISE INDICATED. PROTECT ADJACENT CONSTRUCTION AND FINISHES TO REMAIN FROM DAMAGE.	
3. OWNER COORDINATION & SALVAGE: VERIFY ITEMS DESIGNATED TO REMAIN, TO BE RELOCATED, OR TO BE SALVAGED. COORDINATE WITH THE OWNER FOR ITEMS TO BE SALVAGED, INCLUDING EQUIPMENT, FURNITURE, AND SPECIALTY MATERIALS. DELIVER SALVAGED ITEMS IN A SAFE AND PROTECTED CONDITION.	
4. FIELD VERIFICATION: VERIFY EXISTING CONDITIONS IN THE FIELD BEFORE STARTING DEMOLITION. REPORT DISCREPANCIES OR CONFLICTS BETWEEN DRAWINGS AND FIELD CONDITIONS TO THE ARCHITECT/ENGINEER PRIOR TO PROCEEDING.	
5. PROTECTION OF EXISTING CONSTRUCTION: PROTECT ALL BUILDING ELEMENTS NOT SCHEDULED FOR DEMOLITION, INCLUDING FLOORS, WALLS, CEILING, FINISHES, AND FIXED EQUIPMENT. REPAIR DAMAGE TO REMAINING CONSTRUCTION TO MATCH ADJACENT MATERIALS.	
6. UTILITIES AND SYSTEMS: IDENTIFY, LOCATE, AND PROTECT ALL ACTIVE UTILITIES, ELECTRICAL, MECHANICAL, FIRE PROTECTION, AND LIFE SAFETY SYSTEMS THAT REMAIN. CAP, REROUTE, OR TERMINATE UTILITIES SERVING DEMOLISHED ELEMENTS IN ACCORDANCE WITH CODE. COORDINATE WITH ELECTRICAL, LOW-VOLTAGE, AND A/V SYSTEMS FOR SUSPENDED BOOTHS OR CEILING-MOUNTED DEVICES TO REMAIN OR BE RELOCATED.	
7. STRUCTURAL INTEGRITY: DO NOT CUT, REMOVE, OR ALTER STRUCTURAL MEMBERS WITHOUT PRIOR WRITTEN APPROVAL FROM THE ARCHITECT AND STRUCTURAL ENGINEER. PROVIDE TEMPORARY SHORING, BRACING, OR SUPPORT AS REQUIRED, PARTICULARLY WHEN REMOVING SUSPENDED PLATFORMS OR BOOTHS.	
8. REMOVAL AND DISPOSAL: REMOVE AND LEGALLY DISPOSE OF DEMOLISHED MATERIALS NOT DESIGNATED FOR SALVAGE. REMOVE ADHESIVES, TRANSITION STRIPS, AND OTHER RESIDUAL MATERIALS TO PROVIDE A CLEAN, SMOOTH SUBSTRATE FOR NEW FINISHES. HANDLE HAZARDOUS MATERIALS ACCORDING TO FEDERAL, STATE, AND LOCAL REGULATIONS.	
9. PATCH AND REPAIR: PATCH, REPAIR, OR FINISH SURFACES DISTURBED BY DEMOLITION TO MATCH EXISTING ADJACENT SURFACES OR AS REQUIRED TO RECEIVE NEW CONSTRUCTION AND FINISHES, INCLUDING WALLS BEHIND REMOVED CHALKBOARDS, PARTITIONS, AND TRIM.	
10. SITE MAINTENANCE AND CLEAN-UP: MAINTAIN CLEAN AND SAFE CONDITIONS DURING DEMOLITION. CONTROL DUST, DEBRIS, AND NOISE. PROVIDE DUST BARRIERS, FLOOR PROTECTION, AND OTHER TEMPORARY MEASURES AS REQUIRED.	
11. SAFETY AND CODES: PERFORM DEMOLITION WORK IN COMPLIANCE WITH OSHA, NFPA, AND ALL APPLICABLE CODES, REGULATIONS, AND LOCAL ORDINANCES. MAINTAIN SAFE ACCESS AND EGRESS FOR BUILDING OCCUPANTS THROUGHOUT DEMOLITION OPERATIONS.	
12. COORDINATION: COORDINATE WITH ALL TRADES, SUBCONTRACTORS, AND THE OWNER TO MINIMIZE CONFLICTS AND DISRUPTIONS DURING DEMOLITION OPERATIONS.	

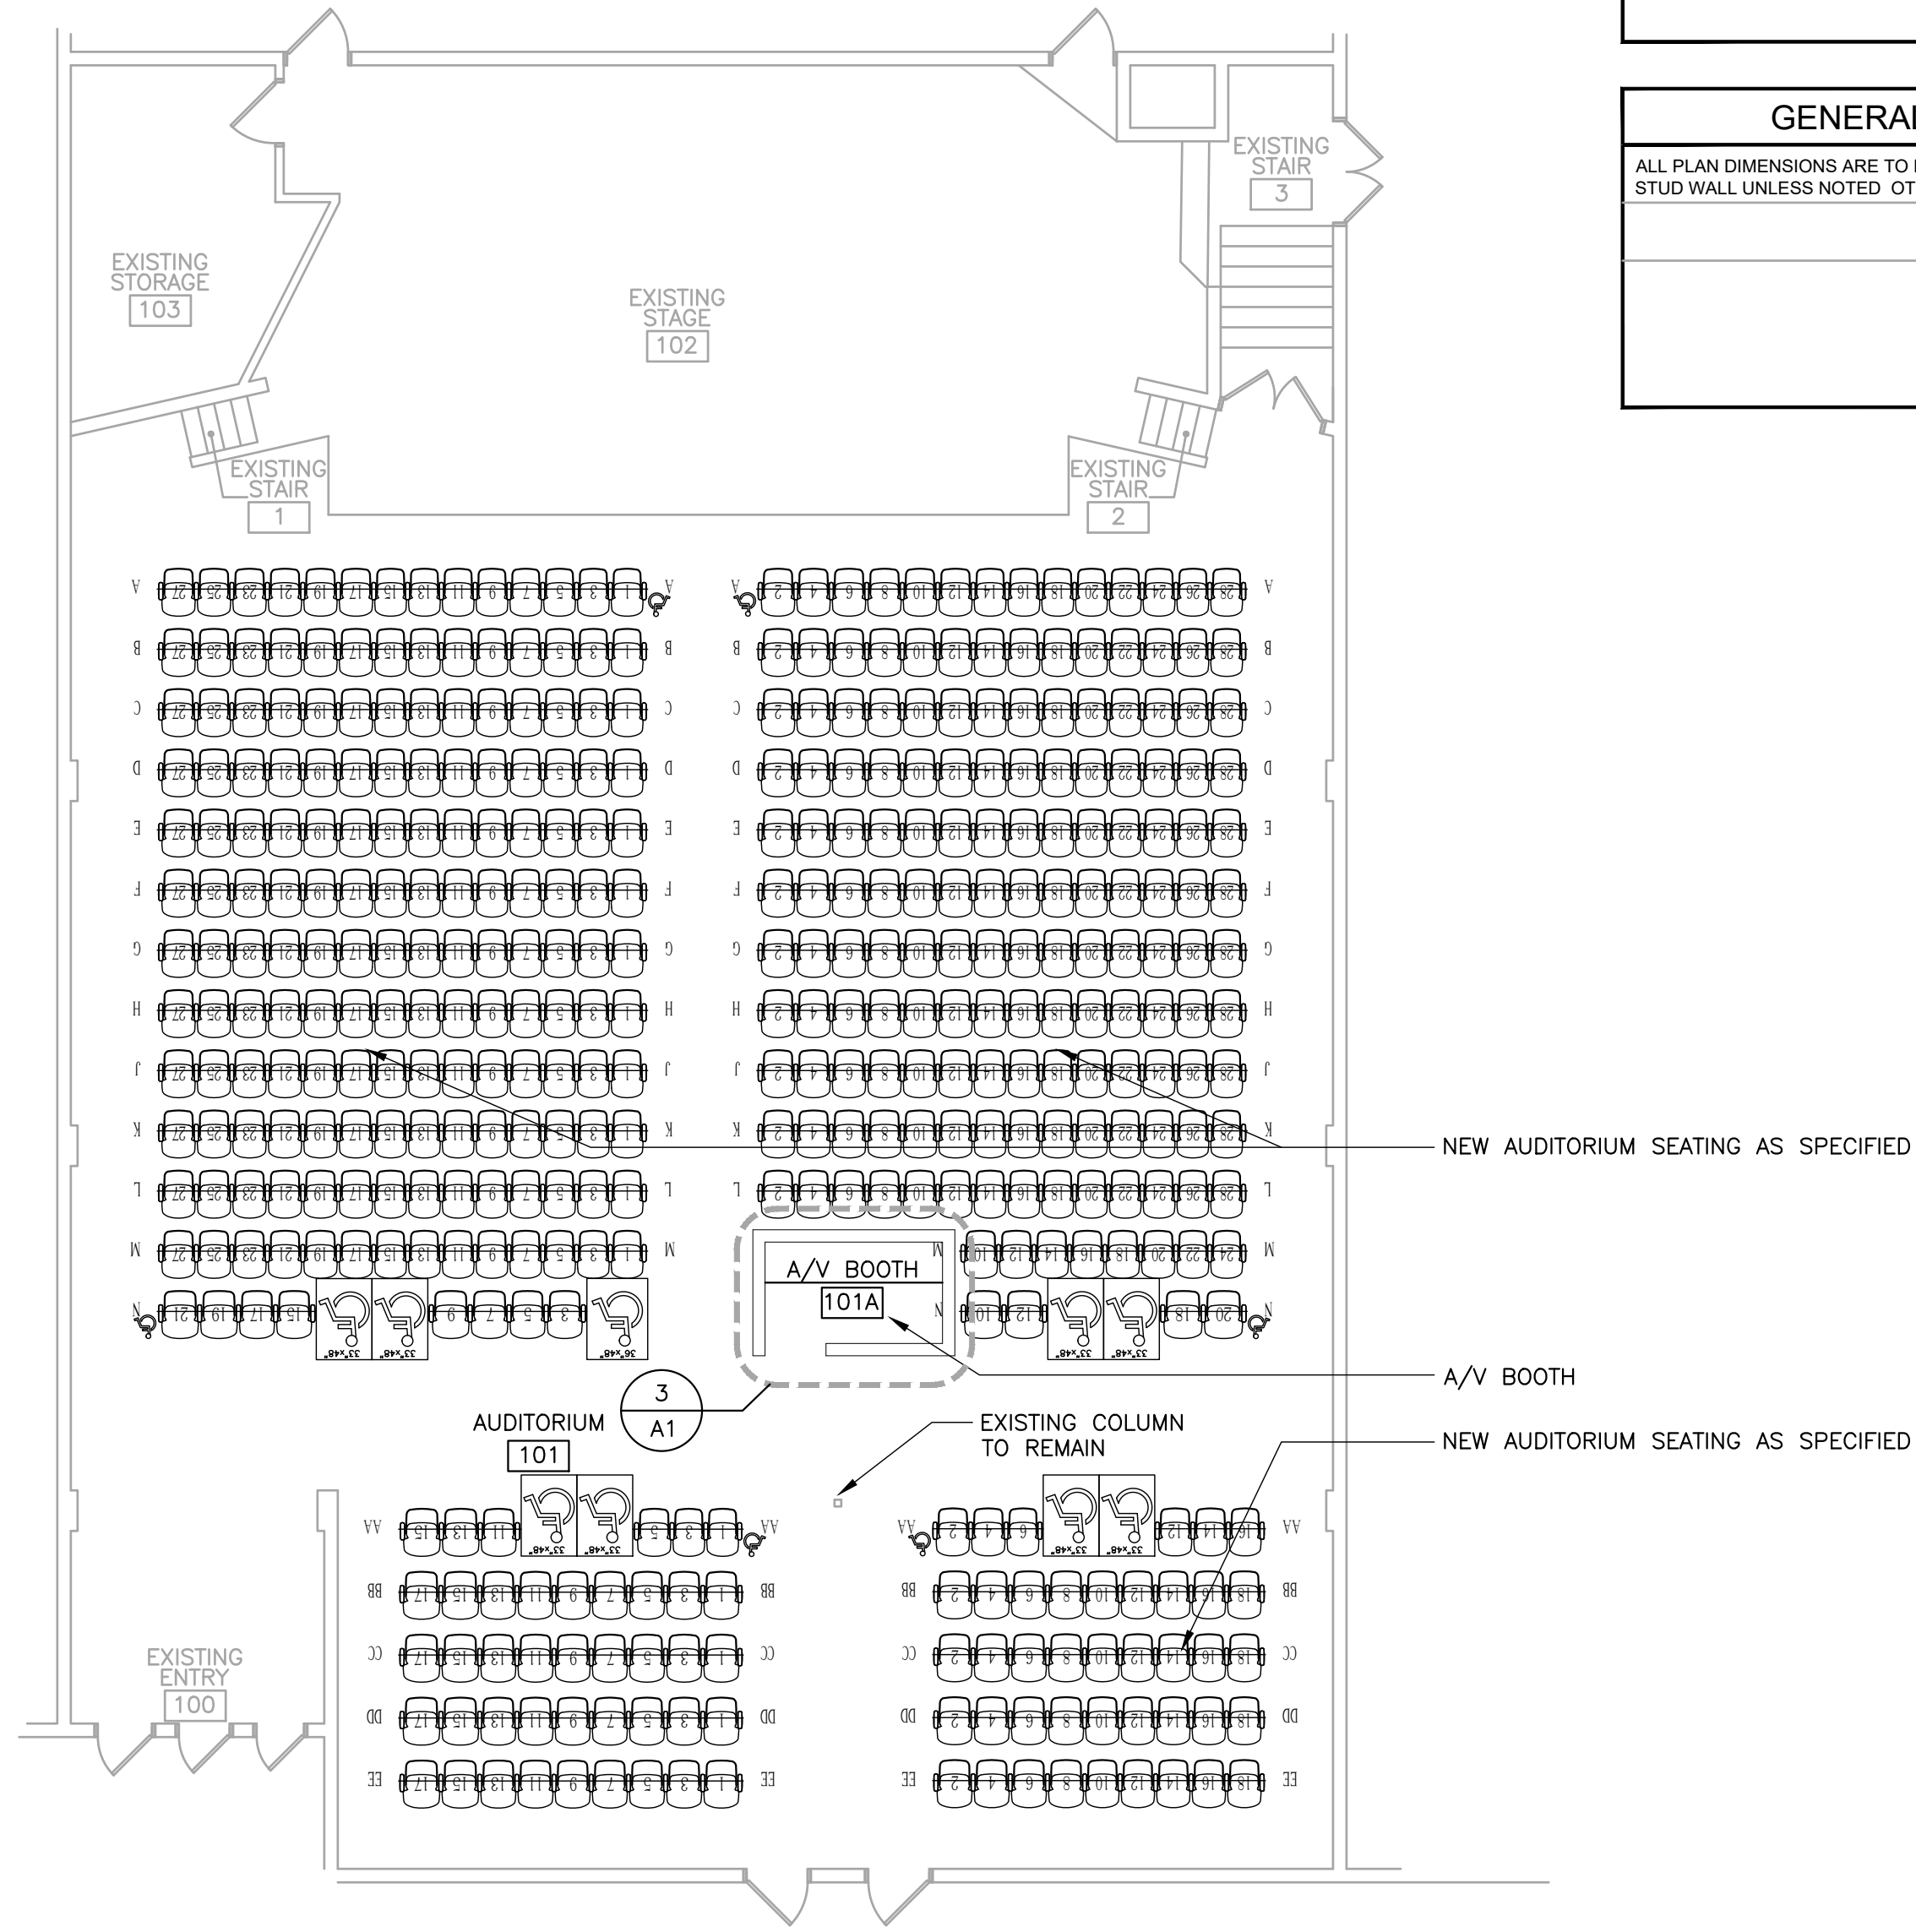

2 PARTIAL FLOOR PLAN

1/8" = 1'-0"


1 AUDITORIUM - DEMOLITION PLAN

1/8" = 1'-0"

3 ENLARGED PLAN

1/4" = 1'-0"

AV BOOTH 101A

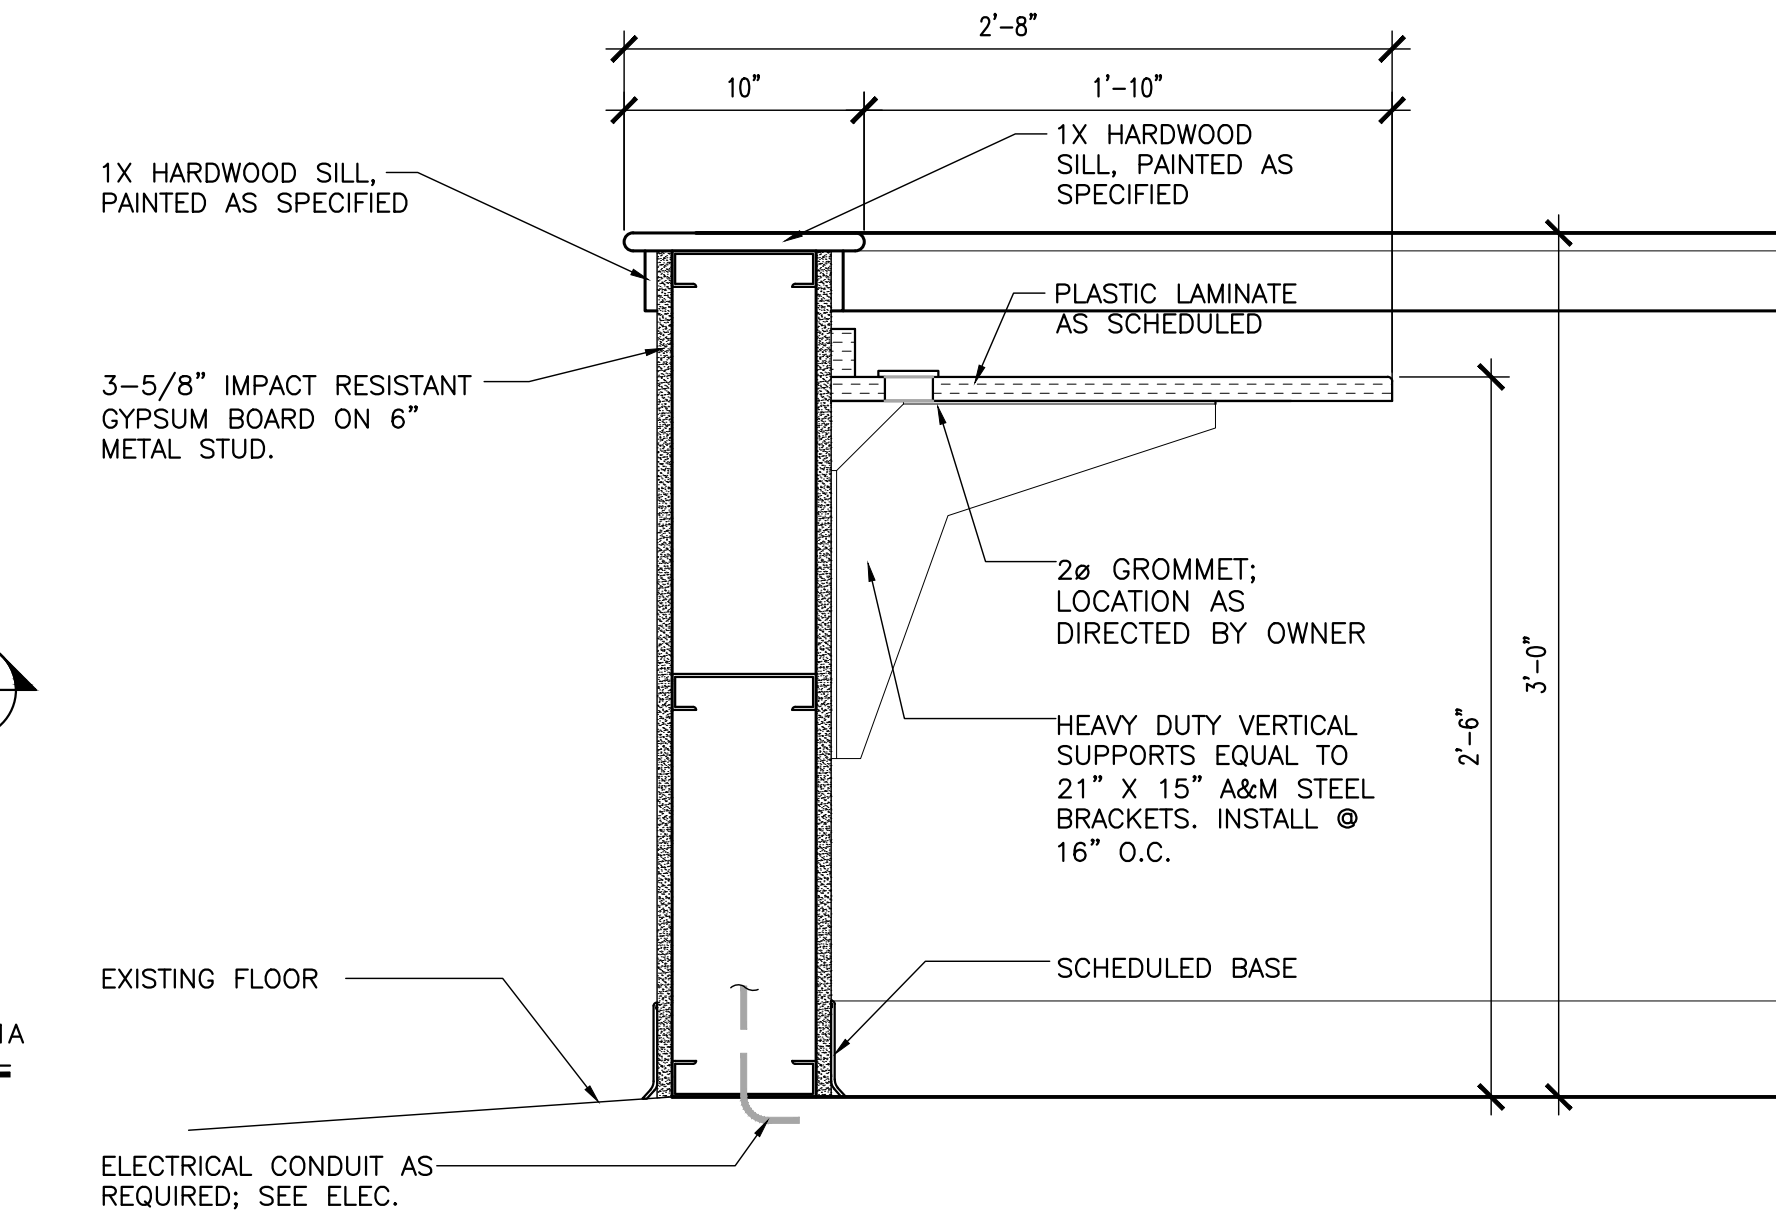


4 SECTION DETAIL

1-1/2" = 1'-0"


FINISH SCHEDULE									
ROOM NO.	ROOM NAME	FLOOR	BASE	MILLWORK	WALLS			DOOR FRAME	NOTES
				FACE TOP	NORTH	SOUTH	EAST	WEST	
1	STAIR	ETR-REFINISH	ETR						
2	STAIR	ETR-REFINISH	ETR						
3	STAIR	ETR-REFINISH	ETR						
100	ENTRY	CPT-1	RB-1	-	-	PNT-4	PNT-4	PNT-4	
101	AUDITORIUM	CPT-1/LVT-1	RB-1	-	-	PNT-1	PNT-1	PNT-1	
101A	AV BOOTH	LVT-1	RB-1	PL-1	PL-1	PNT-1	PNT-1	PNT-1	
102	CLASSROOM	CPT-1/LVT-1	RB-1	-	-	PNT-1	PNT-1	PNT-1	
103	CLASSROOM	CPT-1/LVT-1	RB-1	-	-	PNT-1	PNT-1	PNT-1	
104	STAGE	ETR	RB-1	-	-	PNT-4	PNT-4	PNT-4	
105	STORAGE	ETR	ETR						

BASE(RUBBER/CERAMIC/PORCELAIN/WOOD)				PLASTIC LAMINATE			
ITEM	MANUFACTURER	ITEM NUMBER/NAME	LOCATION	ITEM	MANUFACTURER	ITEM NUMBER/NAME	LOCATION
RB-1	JOHNSONITE	COLOR: BLACK 40, 4" HIGH	SEE FINISH SCHEDULE	PL-1	WILSONART	COLOR: 7891K NEO WALNUT (MATT FINISH ON ALL SURFACES, EDGE-BAND: SURTECO 8849E5	COUNTERTOPS, CABINETS AND SHELVING
LUXURY VINYL TILE				PAINT/STAIN			
ITEM	MANUFACTURER	ITEM NUMBER/NAME	LOCATION	ITEM	MANUFACTURER	ITEM NUMBER/NAME	TYPE/LOCATION
LVT-1	INTERFACE	COLOR: A00702 PEWTER COLLECTION: STUDIO SET LVT, INSTALL DIRECTION: SHOWN ON PLAN	FIELD COLOR	PNT-1	SHERWIN WILLIAMS	COLOR: SW 6280 UNIQUE GRAY	GENERAL WALLS EPOXY AT WET AREAS
WOOD				PNT-2	SHERWIN WILLIAMS	COLOR: SW 7067 CITYSCAPE	GENERAL TRIM
ITEM	MANUFACTURER	ITEM NUMBER/NAME	LOCATION	PNT-3	SHERWIN WILLIAMS	COLOR: SW 7007 CEILING BRIGHT WHITE	SOFFIT
WD-1	SEE SPECS	COLOR: CLEAR	EXISTING WOOD FLOORING TO BE REMAIN, REFINISH AS SPECIFIED	PNT-4	SHERWIN WILLIAMS	COLOR: FLAT BLACK	PROSCENIUM WALL/STAGE WALLS (DASHED LINES ON PLAN)
CARPET				FINISH NOTES			
ITEM	MANUFACTURER	ITEM NUMBER/NAME	LOCATION	ALL WALLS TO BE PAINTED PNT-1 UNLESS NOTED OTHERWISE.			
CPT-1	INTERFACE	COLOR: TITANIUM IRS 107245 NIGHT LIGHTS COLLECTION SIZE: 250M X 1M DIRECTION: ASHLAR	SEE FINISH PLAN	ALL WALLS LOCATED IN WET AREAS SHALL HAVE EPOXY BASED PAINT			
FINISH ABBREVIATION LEGEND				ALL ROOM NUMBERS SHOULD BE USED FOR CONSTRUCTION PURPOSES ONLY.			
APF	ACOUSTIC PANEL	PL	PLASTIC LAMINATE	TP	TACKABLE	ACOUSTIC PANEL	
FABRIC		PM	PANEL MOULDING	TS	TACKABLE SURFACE		
CC	COATED CONCRETE	PNT	PAINT	LVT	VINYL COMP. TILE		
CM	CROWN MOLDING	PT	PORCELAIN TILE	WB	WOOD BASE		
CPT	CARPET	PTB	PORCELAIN TILE BASE	WC	WALLCOVERING		
CR	CHAIR RAIL	QT	QUARRY TILE	WF	WOOD FLOORING		
CWT	CERAMIC WALL TILE	QTB	QUARRY TILE BASE	WP	WOOD PANELING		
ERB	EPOXY RESIN BASE	RB	RUBBER BASE	WV	WOOD VENEER		
ERF	EPOXY RESIN FLOOR	RF	RUBBER FLOOR				
ESD	STATIC CONTROL TILE	SC	SEALED CONCRETE				
GYP	GYPSON BOARD	STC	STAINED CONCRETE				
IC	IMPRINTED CONCRETE	SS	SOLID SURFACE				
LVT	LUXURY VINYL TILE	ST	STAIN				

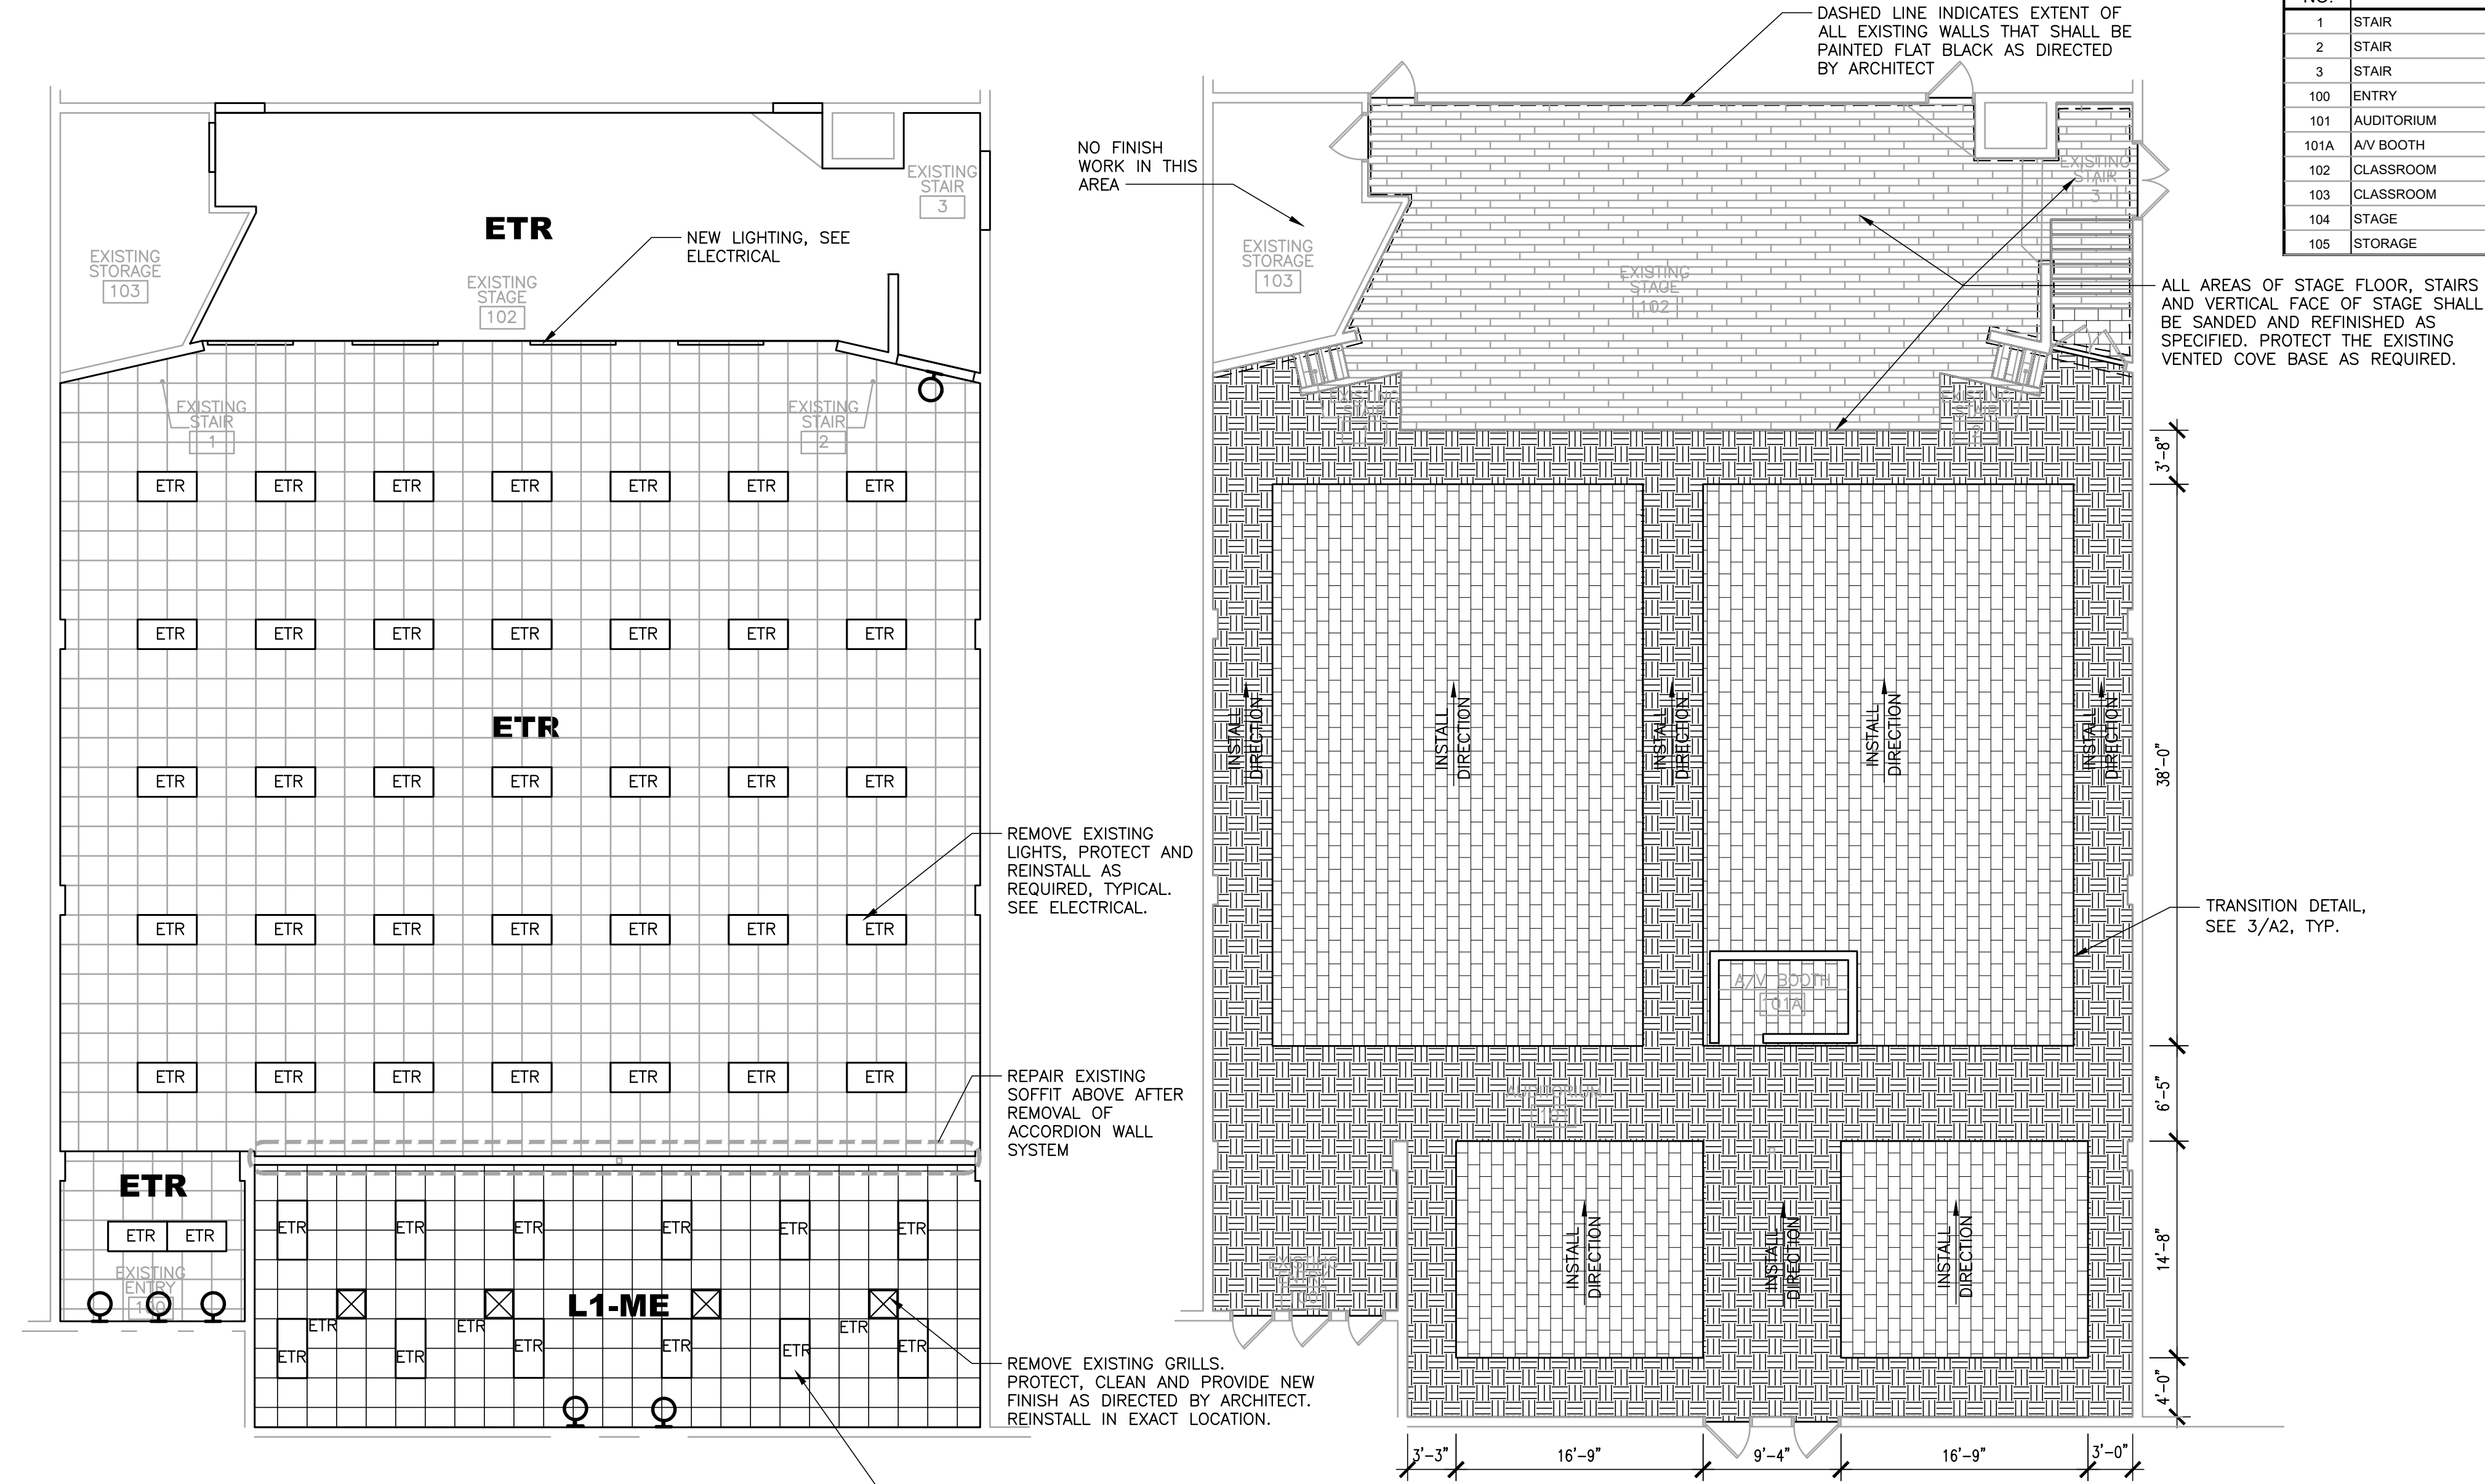

1 PARTIAL REFLECTED CEILING PLAN
1/8" = 1'-0"

2 PARTIAL FINISH FLOOR PLAN
1/8" = 1'-0"

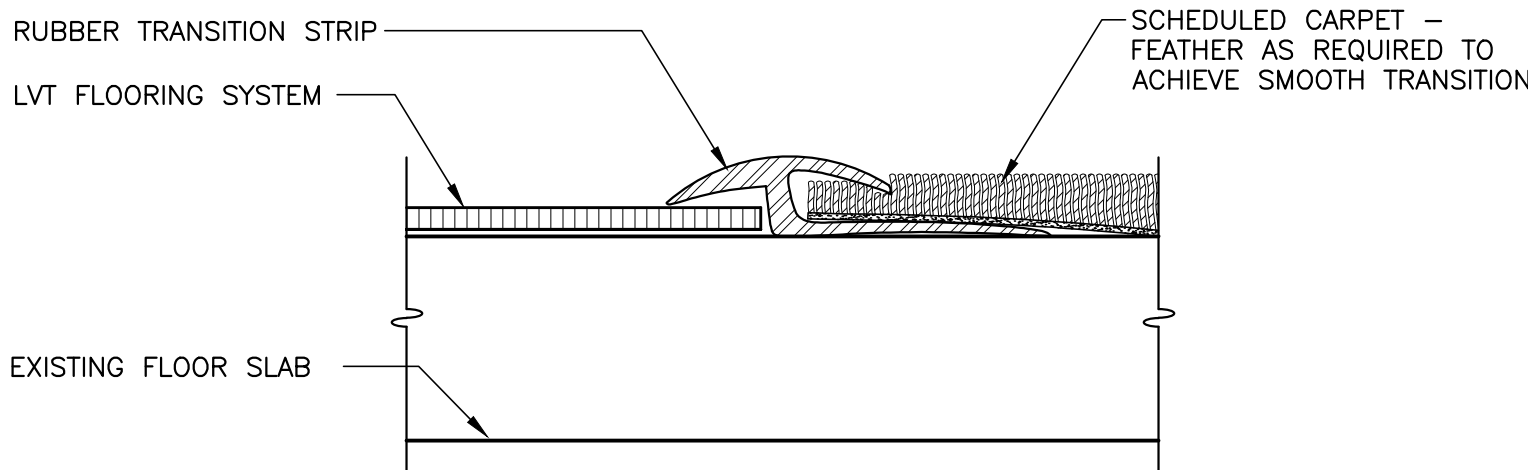


3 DETAIL LVT TO CARPET
1/8" = 1'-0"

LIGHTING/ELECTRICAL NOTES	
COORDINATE LIGHTING LAYOUTS WITH ELECTRICAL DRAWINGS. CONTACT ARCHITECT WITH ANY DISCREPANCIES	
REPLACE ANY DAMAGED, MISSING OR DISCOLORED CEILING TILES WITH ATTIC STOCK PROVIDED BY OWNER.	

CEILING LEGEND	
FIXTURE TYPES - SEE ELECTRICAL	
CEILING TYPE	CEILING HEIGHTS
ETR - EXISTING TO REMAIN (PNT-4)	ETR = EXISTING TO REMAIN
GB - GYP BOARD (PAINT AS SCHEDULED)	
REFER TO FINISH SYMBOLS ON PLAN FOR MATERIALS AND CEILING HEIGHTS	
CEILING TYPE	CEILING HEIGHT
L1-ME	98 = 9'-8" AFF

SHEET TITLE:

SCHEDULES, SYMBOLS,
AND NOTES

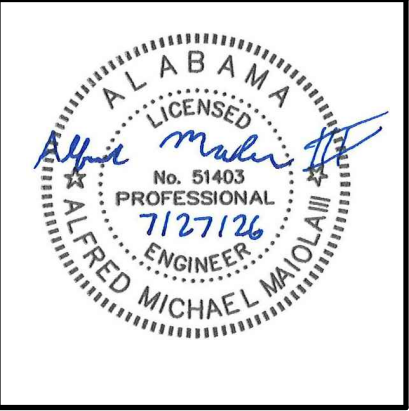

PROJ. MGR.: S. CRAWFORD
DRAWN: SEC

 
DATE: JULY 27, 2026
REVISIONS

JOB NO.
LAA-26-019

SHEET NO:

E1.1

1 OF 3



GENERAL NOTES

- SERVICE TO PROJECT IS 120/208 VOLTS, 3 PHASE, 4 WIRE.
- VERIFY ALL DOOR SWINGS WITH ARCHITECTURAL DRAWINGS BEFORE ROUGHING IN SWITCHES.
- VERIFY EXACT LOCATION OF ALL MOTORS AND EQUIPMENT BEFORE ROUGHING IN.
- CONTRACTOR TO VERIFY LOCATION OF ALL OUTLETS PRIOR TO INSTALLATION.
- THE ELECTRICAL CONTRACTOR SHALL VERIFY THE EXACT LOCATION OF COUNTERTOPS AND BACKSPLASHES ON ARCHITECTURAL DETAILS AND/OR CASEWORK SHOP DRAWINGS AND ADJUST SPECIFIED MOUNTING HEIGHT OF WALL OUTLETS AS REQUIRED TO AVOID CONFLICTS.
- ELECTRICAL CONTRACTOR MUST CHECK THE CORRESPONDING MECHANICAL SHEETS AND BE RESPONSIBLE FOR INCLUDING PROPER SERVICE AND CONNECTIONS TO ALL MECHANICAL ITEMS SHOWN THEREON REGARDLESS OF ITS BEING OR NOT BEING SHOWN ON ELECTRICAL SHEETS.
- ALL CONDUIT CONCEALED UNLESS SPECIFICALLY SHOWN EXPOSED. METAL WIRE MOLD IS PERMITTED WHERE SURFACE MOUNT CONDUIT IS REQUIRED.
- COORDINATE SERVICES WITH POWER AND COMMUNICATIONS COMPANIES. REMOVE OR RELOCATE ALL POWER AND COMMUNICATIONS CIRCUITS ABOVE OR BELOW GRADE THAT WOULD OBSTRUCT THE CONSTRUCTION OF THE PROJECT OR CONFLICT IN ANY MANNER WITH COMPLETION OF THE PROJECT OR ANY CODE PERTAINING THERETO. IF UTILITY COMPANY REQUIREMENTS ARE AT VARIANCE WITH THESE DRAWINGS AND SPECIFICATIONS, THE CONTRACT PRICE SHALL INCLUDE THE ADDITIONAL COST.
- IT IS INTENDED THAT SPECIFICATIONS AND PLANS SHALL INCLUDE EVERYTHING REQUIRED AND NECESSARY FOR PROPER AND COMPLETE INSTALLATION OF THE COMPLETE SYSTEMS SHOWN EVEN THOUGH EVERY ITEM MAY NOT BE PARTICULARLY MENTIONED IN DETAIL. THE CONTRACTOR SHALL DELIVER TO OTHER TRADES ANY EQUIPMENT THAT MUST BE INSTALLED DURING CONSTRUCTION. CONTRACTOR SHALL BE RESPONSIBLE FOR FIELD MEASUREMENTS AND COORDINATION OF THE PHYSICAL SIZE OF ALL EQUIPMENT WITH THE ARCHITECTURAL REQUIREMENTS OF THE SPACES INTO WHICH THE EQUIPMENT WILL BE INSTALLED.
- THIS CONTRACTOR SHALL INSTALL EQUIPMENT GROUNDS THROUGHOUT THIS PROJECT, USING GREEN INSULATED GROUND WIRE. USE OF CONDUIT AS THE ONLY GROUND CONDUCTOR WILL NOT BE ALLOWED. (SIZE GROUND WIRES PER N.E.C.)
- REMOVE ALL EXISTING PANELBOARDS, DISCONNECTS, FIXTURES, RECEPTACLES, AUXILIARY SYSTEM DEVICES, CONDUIT, CONDUCTORS, ETC. BEING RENDERED OBSOLETE BY THIS PROJECT.
- WHERE EXISTING REMAINING CIRCUITS ARE BEING INTERRUPTED DUE TO STRUCTURAL AND/OR DESIGN CHANGES, THIS CONTRACTOR WILL EXTEND EXISTING CIRCUITS AS REQUIRED TO MAINTAIN CIRCUIT CONTINUITY TO REMAINING ACTIVE DEVICES.


FIRE ALARM SYSTEM NOTES

- PROVIDE FIRE ALARM COMPLETION DOCUMENTS AT THE STATE FINAL INSPECTION. THIS ITEM WILL BE REQUIRED BY STATE BUILDING INSPECTOR AT THE TIME OF FINAL INSPECTION (OLD CERTIFICATION FORM).
- ADDITIONS AND ALTERATIONS TO THE FIRE ALARM SYSTEM REQUIRE TESTING, A RECORD OF COMPLETION, AND RECERTIFICATION. ALL FIRE ALARM WORK SHALL BE PERFORMED BY QUALIFIED PERSONNEL AS DEFINED IN NFPA-72 (2019) 10.4, 10.5, AND 10.18.
- ALL WORK SHALL BE PERFORMED BY A CERTIFIED FIRE ALARM CONTRACTOR.
- ALL FIRE ALARM WIRING SHALL BE IN CONDUIT. MATCH EXISTING MANUFACTURER FOR ALL RELAYS. ALL DEVICES SHALL BE UL LISTED.

COLOR CODE FOR ELECTRICAL WIRING

- 120/208 V, 60Hz, 3 PHASE, 4 WIRE SYSTEM
PHASE: A-BLACK
B-RED
C-BLUE
N-WHITE
- GROUND-GREEN

ELECTRICAL SYMBOLS

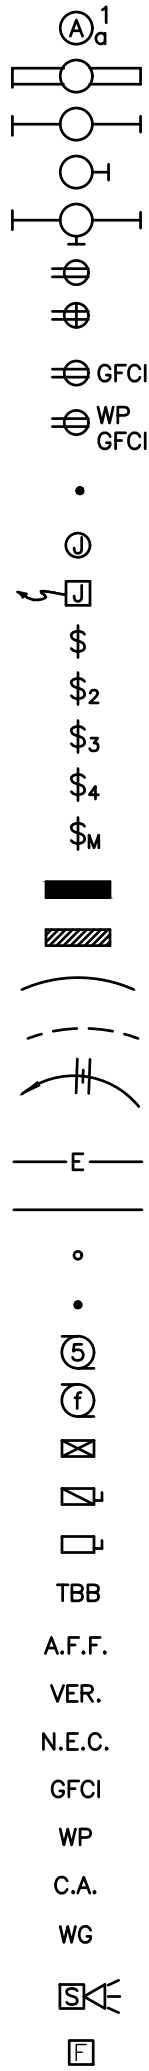

CEILING OUTLET - FIXTURE "A", CIRCUIT 1, SWITCH a.

CEILING OUTLET - LED FIXTURE.

CEILING OUTLET - LED INDUSTRIAL OR STRIP TYPE.

WALL OUTLET - LED BRACKET TYPE.

WALL OUTLET - LED BRACKET TYPE.

WALL OUTLET - DUPLEX OUTLET, 20A, 125V, GROUNDED, PASS & SEYMOUR PT5362A-GRY WITH PT6STR PLUG TAIL CONNECTOR - TAMPER RESISTANT.

WALL OUTLET - DUPLEX OUTLET, 20A, 125V, GROUNDED, PASS & SEYMOUR PT5362A-GRY WITH PT6STR PLUG TAIL CONNECTOR - TAMPER RESISTANT - MOUNT AT 6" ABOVE COUNTER.

WALL OUTLET - DUPLEX OUTLET, 20A, 125V, GROUNDED, PASS & SEYMOUR PT2095-GRY WITH PT6STR PLUG TAIL CONNECTOR - TAMPER RESISTANT.

WALL OUTLET - DUPLEX OUTLET, 20A, 125V, GROUNDED, WEATHERPROOF, PASS & SEYMOUR PT2095-GRY WITH PT6STR PLUG TAIL CONNECTOR - TAMPER RESISTANT. INSTALL #WUIC10-CAGV WEATHERPROOF COVER. DEVICE SHALL BE LABELED AS "EXTRA DUTY".

FLOOR OUTLET - CONDUIT STUB UP.

CEILING OUTLET - JUNCTION BOX.

WALL OUTLET - JUNCTION BOX WITH FLEXIBLE CONNECTION TO EQUIPMENT.

SWITCH OUTLET - AC TYPE, SINGLE POLE, 20A, 120/277V, HUBBELL #1221 - GREY.("N" DENOTES NARROW)

SWITCH OUTLET - AC TYPE, TWO POLE, 20A, 120/277V, HUBBELL #1222 - GREY.

SWITCH OUTLET - AC TYPE, THREE WAY, 20A, 120/277V, HUBBELL #1223 - GREY.

SWITCH OUTLET - AC TYPE, FOUR WAY, 20A, 120/277V, HUBBELL #1224 - GREY.

SWITCH MANUAL MOTOR STARTER, SINGLE POLE WITH OVERLOAD PROTECTION.

LIGHTING PANEL - SEE SPECIFICATIONS AND SCHEDULE.

POWER PANELS - SEE SPECIFICATIONS AND SCHEDULE.

BRANCH CIRCUIT CONCEALED IN WALL OR CEILING.

BRANCH CIRCUIT CONCEALED IN FLOOR OR GROUND.

HOMERUN TO PANELBOARD - ANY CIRCUIT WITHOUT FURTHER DESIGNATION 2 # 12 & 1 # 12(G) - 1/2" CONDUIT.

3 # 12 & 1 # 12(G) - 3/4" CONDUIT. 4 # 12 & 1 # 12(G) - 3/4" CONDUIT.

EMPTY CONDUIT - 3/4".

BRANCH CIRCUIT EXPOSED.

CONDUIT RUN DOWN WALLS, CONCEALED

CONDUIT RUN UP WALLS, CONCEALED

MOTOR SHOWN 5hp (TYPICAL) OR 40 AMPS (TYPICAL).

EXHAUST FAN MOTOR - FRACTIONAL HORSEPOWER.

MAGNETIC MOTOR STARTER.

NON-FUSED DISCONNECT SWITCH. (RT - RAINIGHT).

FUSED DISCONNECT SWITCH.

TELEPHONE BACKBOARD - 4' X 4' X 3/4" - 2 COATS OF GREY ENAMEL BOTH SIDES. (OR AS NOTED).

ABOVE FINISHED FLOOR.

VERIFY LOCATION.

NATIONAL ELECTRICAL CODE.

GROUND FAULT CIRCUIT INTERRUPTER


WEATHER PROOF

CARD ACCESS SYSTEM

WIRE GUARD COVER

FIRE ALARM - SPEAKER STROBE - EXISTING TO REMAIN


FIRE ALARM - PULL STATION - EXISTING TO REMAIN

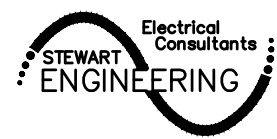STEWART ENGINEERING ELECTRICAL CONSULTANTS	
P.O. Box 2233 (36202) 300 East 7th Street (36207) Anniston, Alabama Phone: 256/237-0891 Fax No.: 256/237-1077 Email: services@stewartengineering.org	
Engineer: Alfred Maiola, P.E. Alabama Reg. 51403	Project Number: 2657

AUDITORIUM RENOVATION FOR
SPRINGVILLE MIDDLE SCHOOL
6891 US-11 SPRINGVILLE, ALABAMA 35946
ST. CLAIR COUNTY BOARD OF EDUCATION

SHEET TITLE:

FLOOR PLAN –
LIGHTING AND POWER

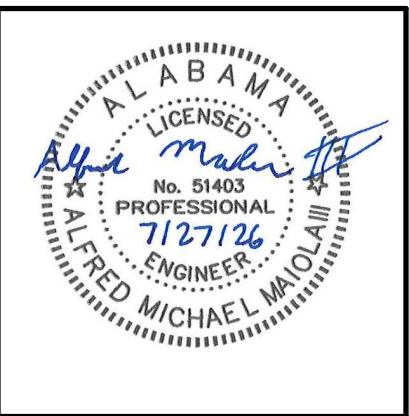


PROJ. MGR.: S. CRAWFORD
DRAWN: SEC

DATE: JULY 27, 2026
REVISIONS


JOB NO.
LAA-26-019

SHEET NO:
E2.1
2 OF 3
0 1" 2'

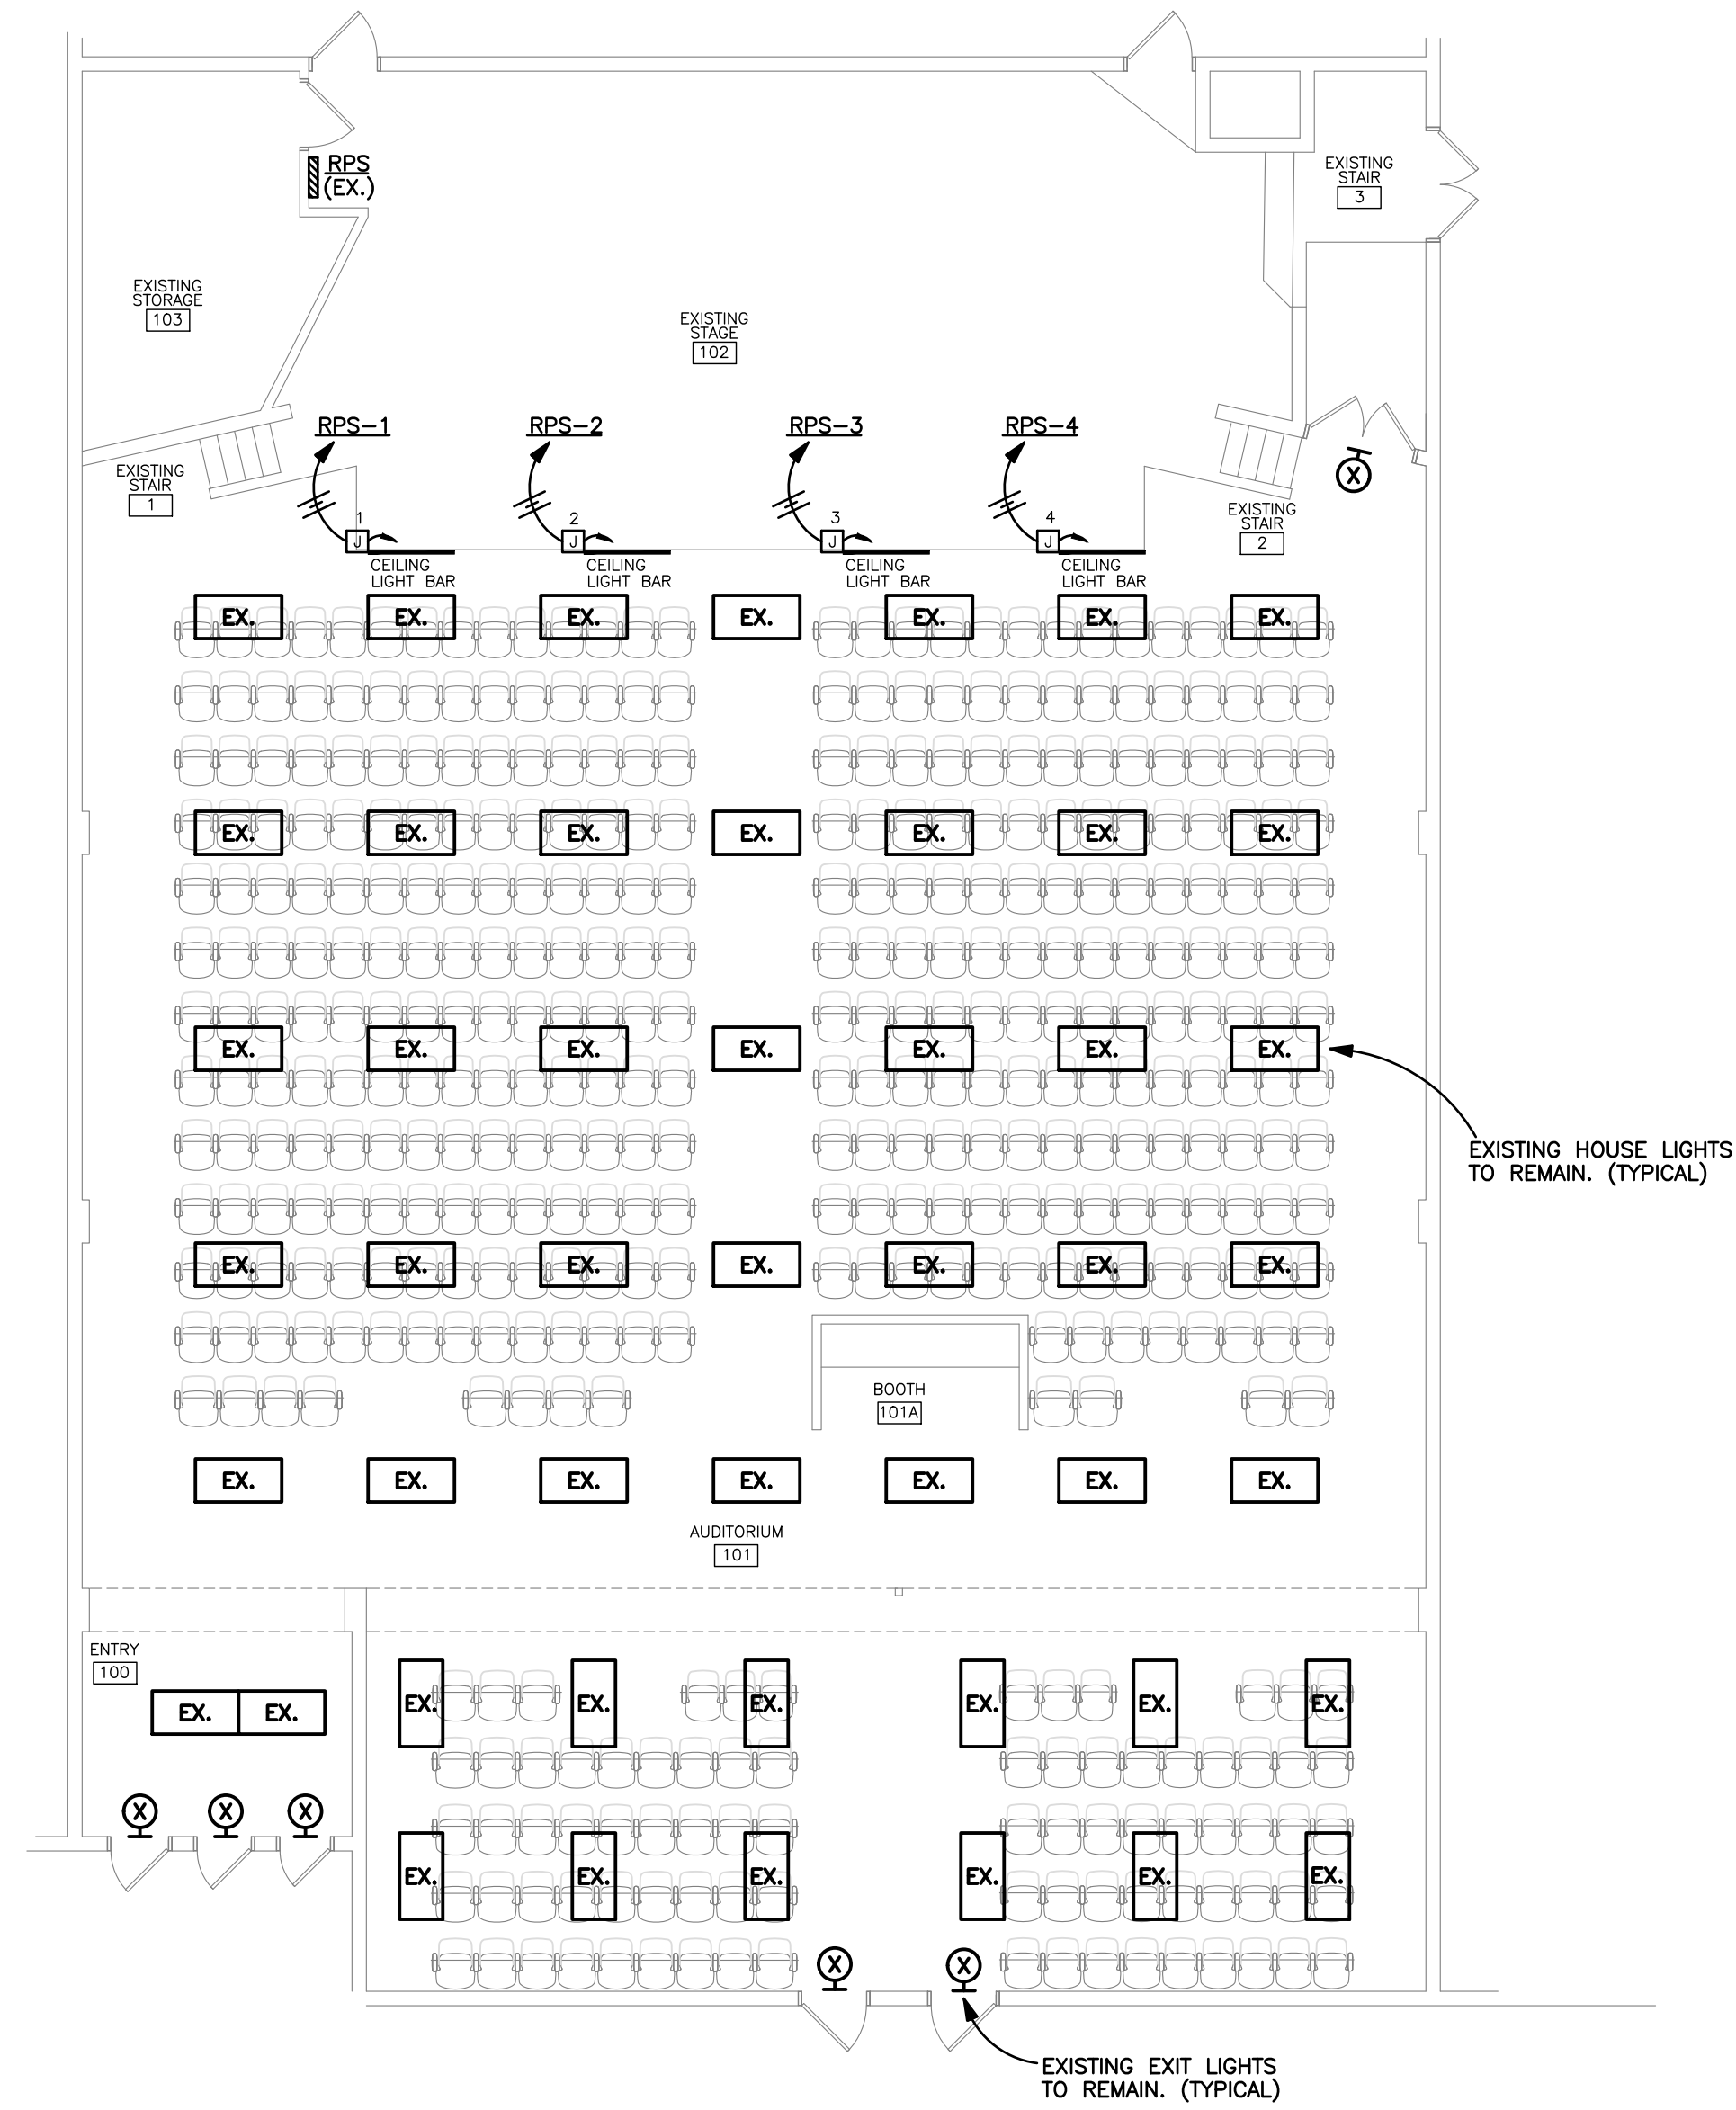

FLOOR PLAN - LIGHTING
SCALE: 1/8" = 1'-0"


- NOTES:
- EXISTING EMERGENCY LIGHTING IS INSTALLED AND WILL REMAIN.
 - EXISTING EMERGENCY LIGHTING IN AREAS THAT ARE IMMEDIATELY ADJACENT TO EXIT DISCHARGE ARE EXISTING AND WILL REMAIN.

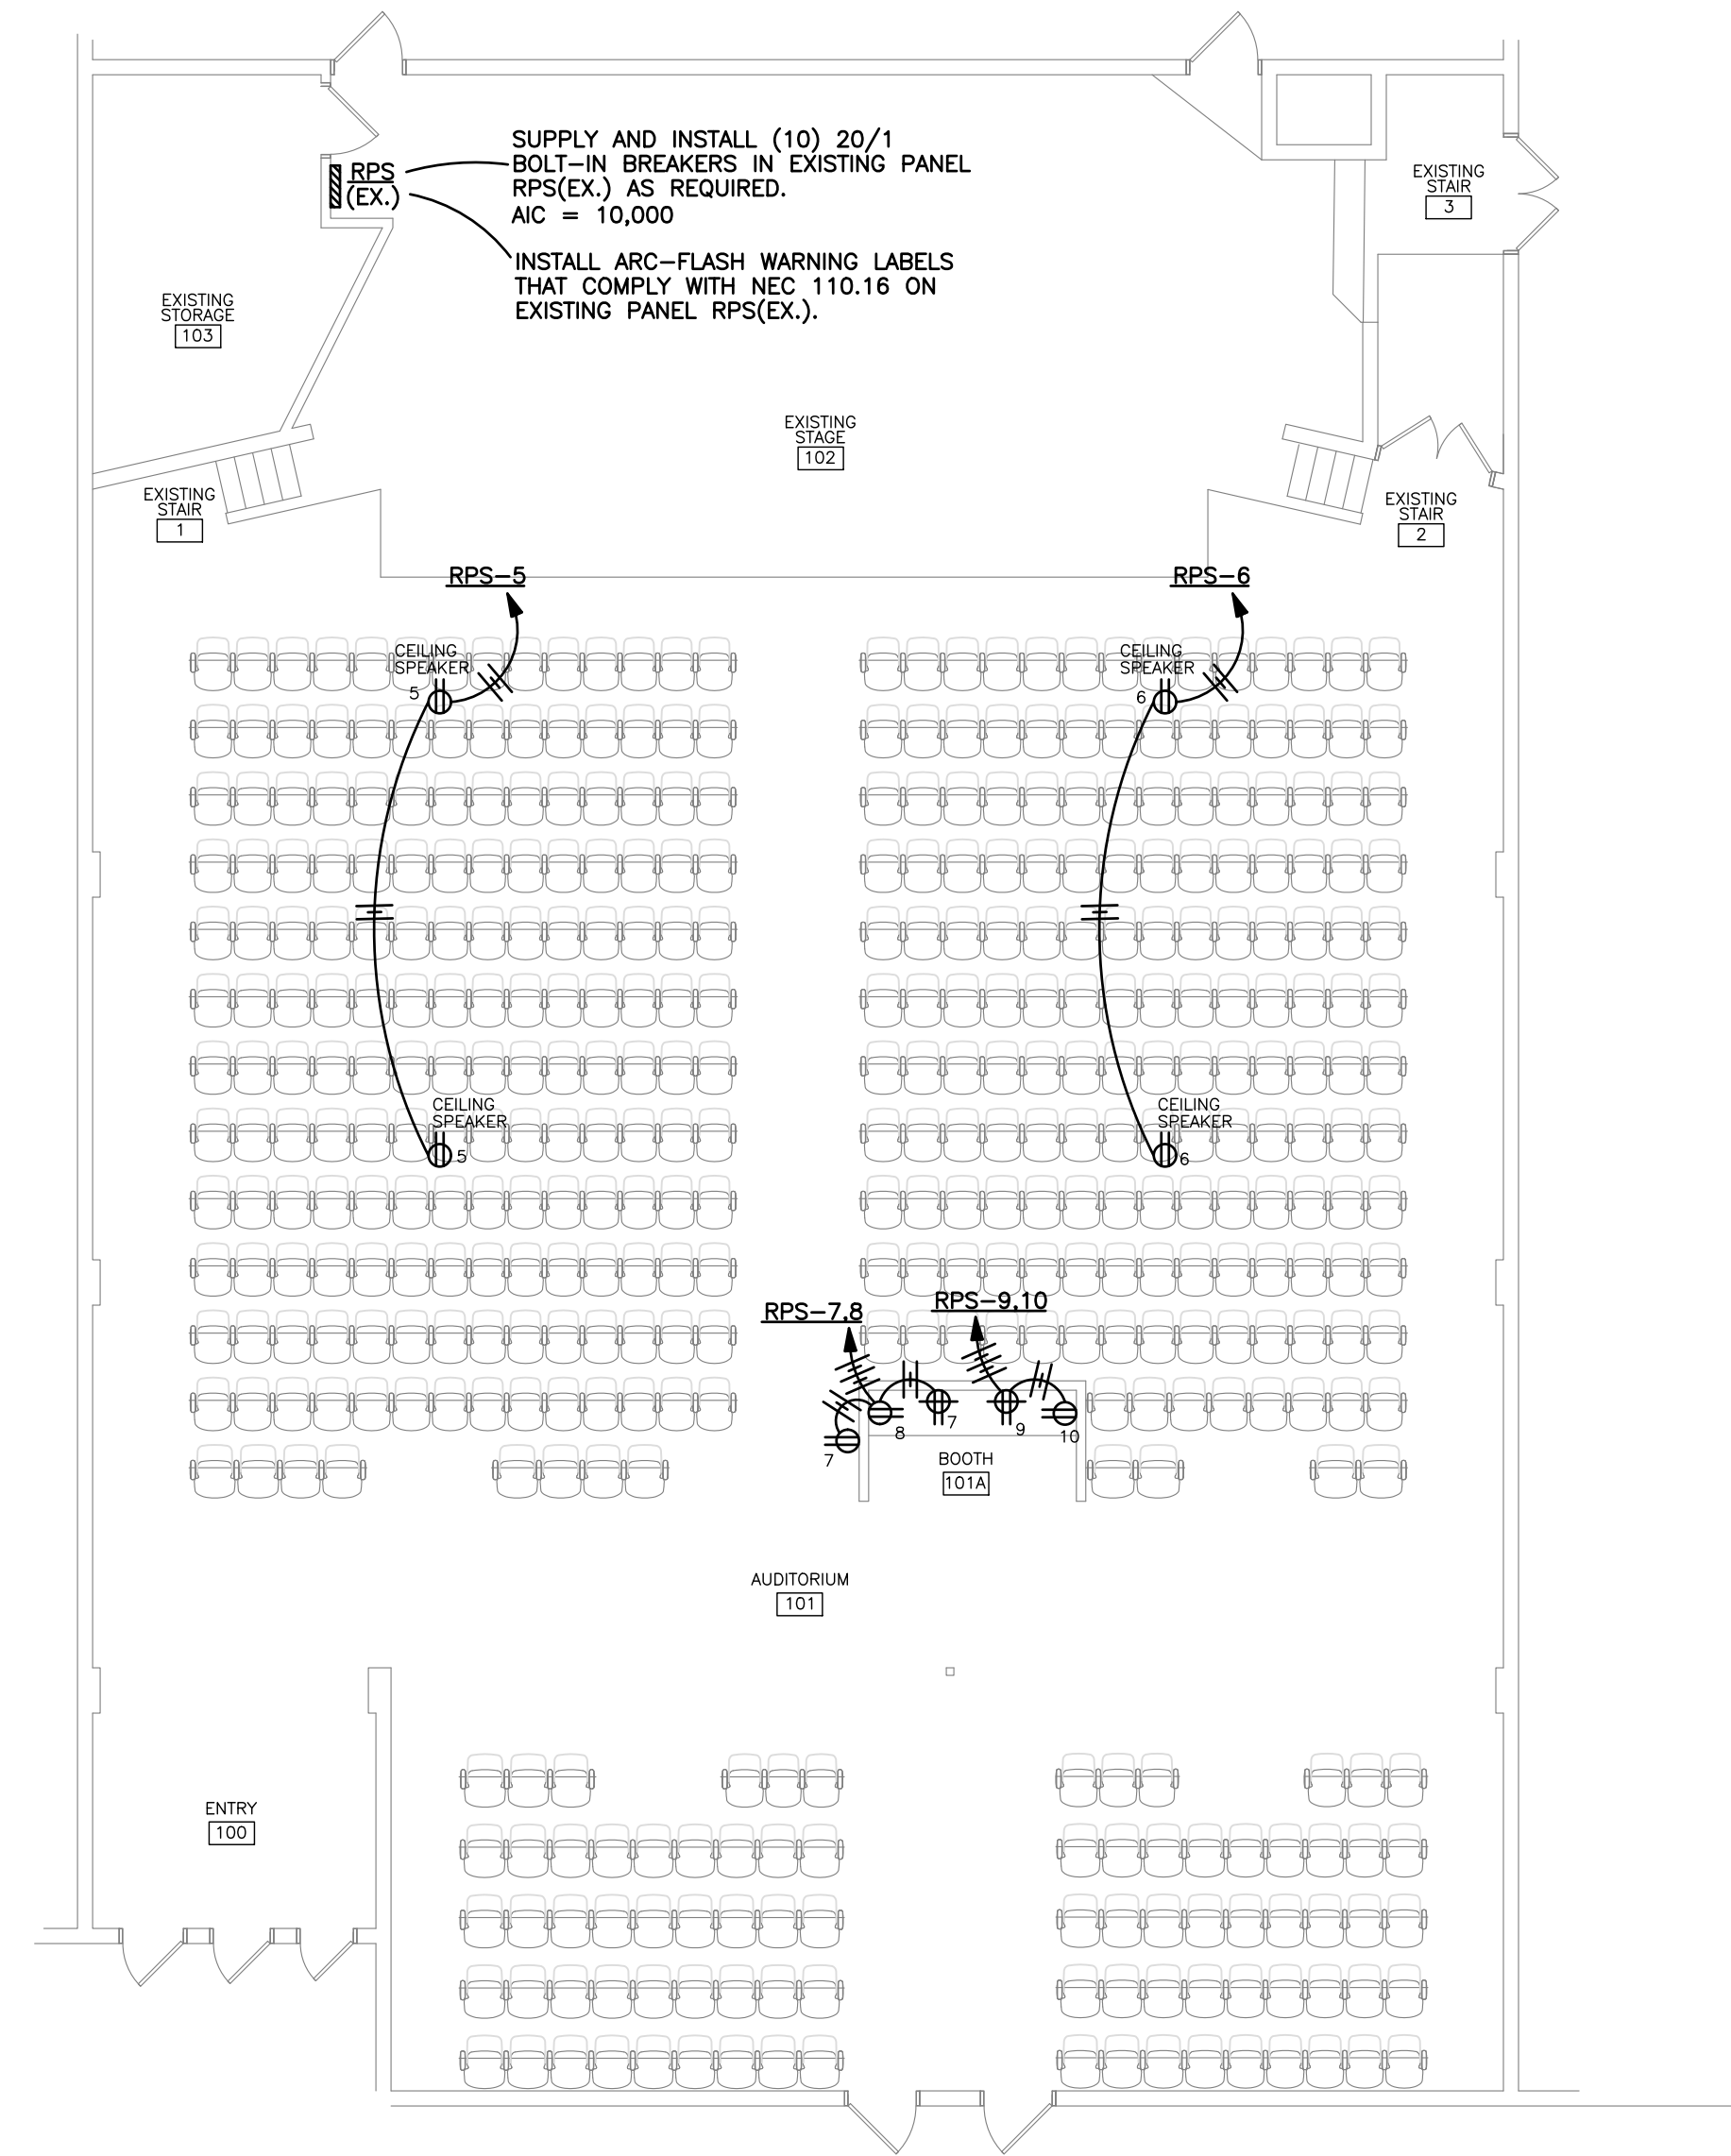

FLOOR PLAN - POWER
SCALE: 1/8" = 1'-0"

STEWART ENGINEERING
ELECTRICAL CONSULTANTS

P.O. Box 2233 (36202)
300 East 7th Street (36207)
Anniston, Alabama
Phone: 256/237-0891
Fax No.: 256/237-1077
Email: services@stewartengineering.org

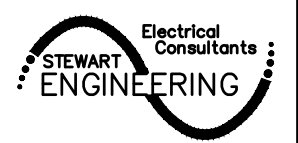


Engineer:
Alfred Maiola, P.E.
Alabama Reg. 51403

Project Number:
2657

AUDITORIUM RENOVATION FOR
SPRINGVILLE MIDDLE SCHOOL
6691 US-11 SPRINGVILLE, ALABAMA 35946
ST. CLAIR COUNTY BOARD OF EDUCATION

SHEET TITLE:

FLOOR PLAN –
AUXILIARIES

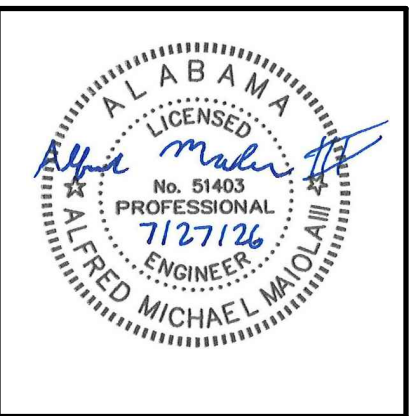

PROJ. MGR.: S. CRAWFORD
DRAWN: SEC


DATE: JULY 27, 2026

REVISIONS

JOB NO.
LAA-26-019

SHEET NO:
E3.1

3 OF 3
0 1" 2"

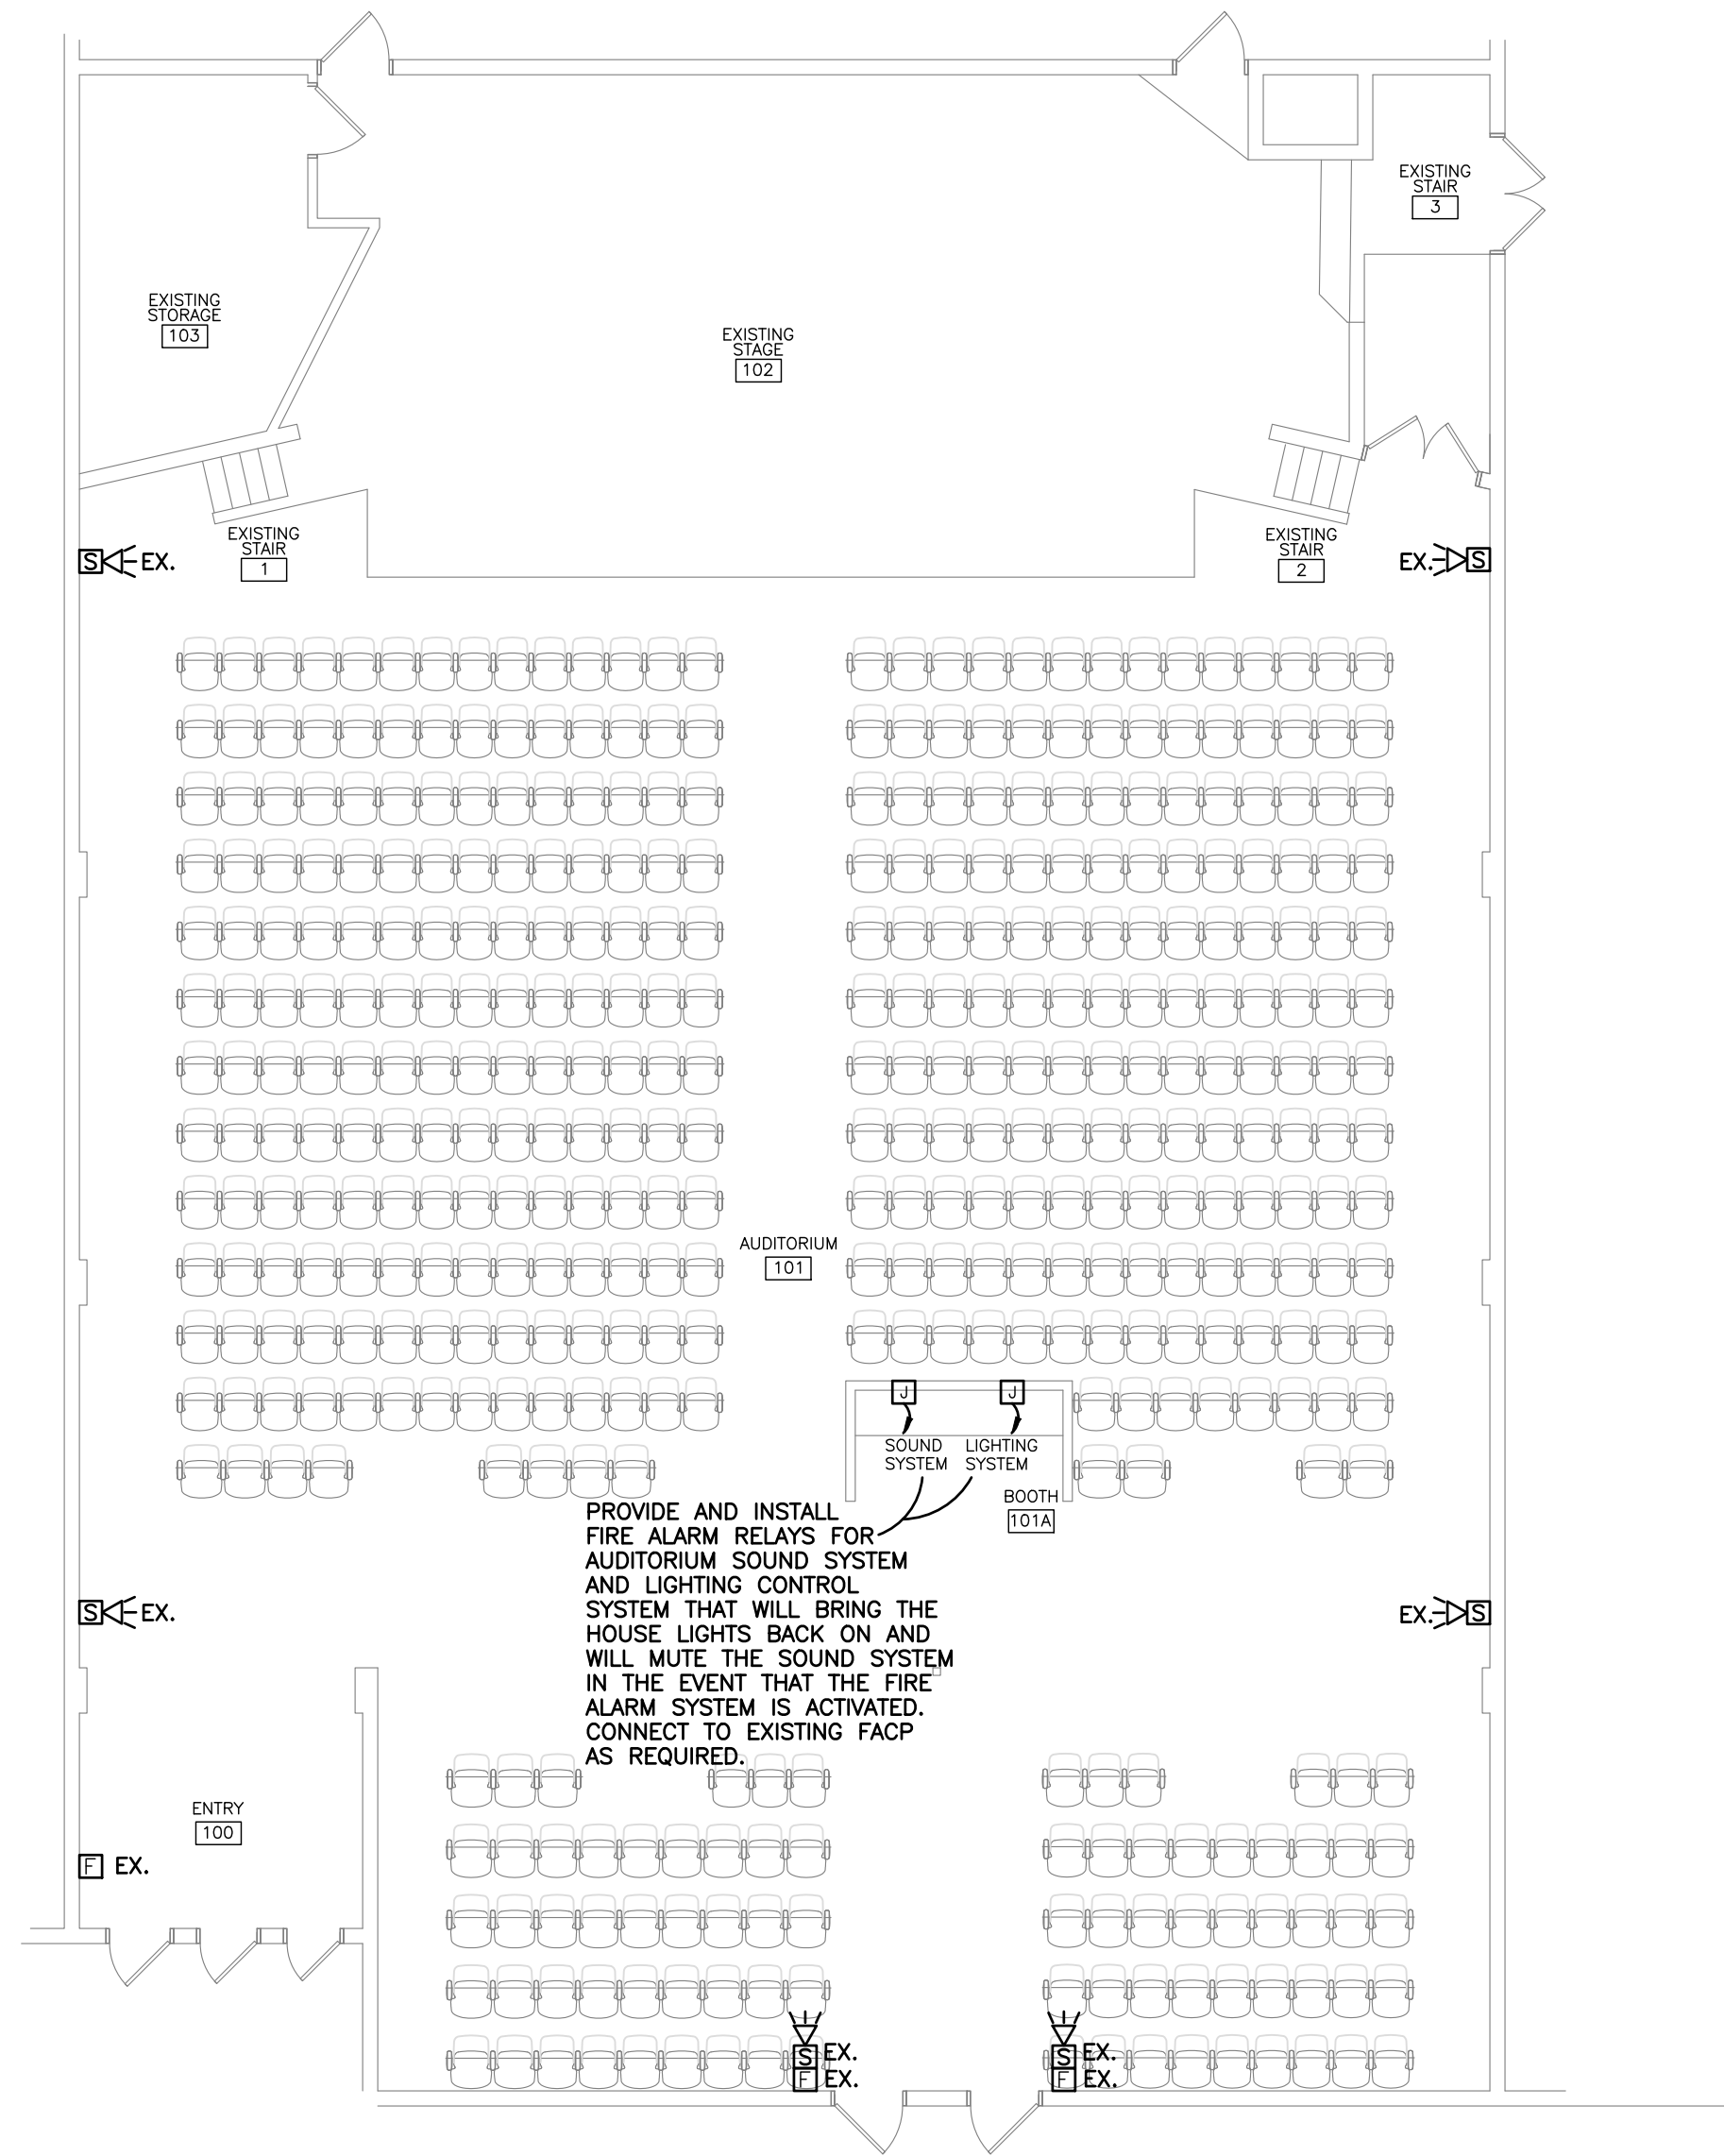

FLOOR PLAN - AUXILIARIES

SCALE: 1/8" = 1'-0"

NOTES:
1. FIRE ALARM DEVICES ARE INSTALLED AND WILL REMAIN.

STEWART ENGINEERING ELECTRICAL CONSULTANTS	
P.O. Box 2233 (36202) 300 East 7th Street (36207) Anniston, Alabama Phone: 256/237-0891 Fax No.: 256/237-1077 Email: services@stewartengineering.org	
Engineer: Alfred Maiola, P.E. Alabama Reg. 51403	Project Number: 2657